


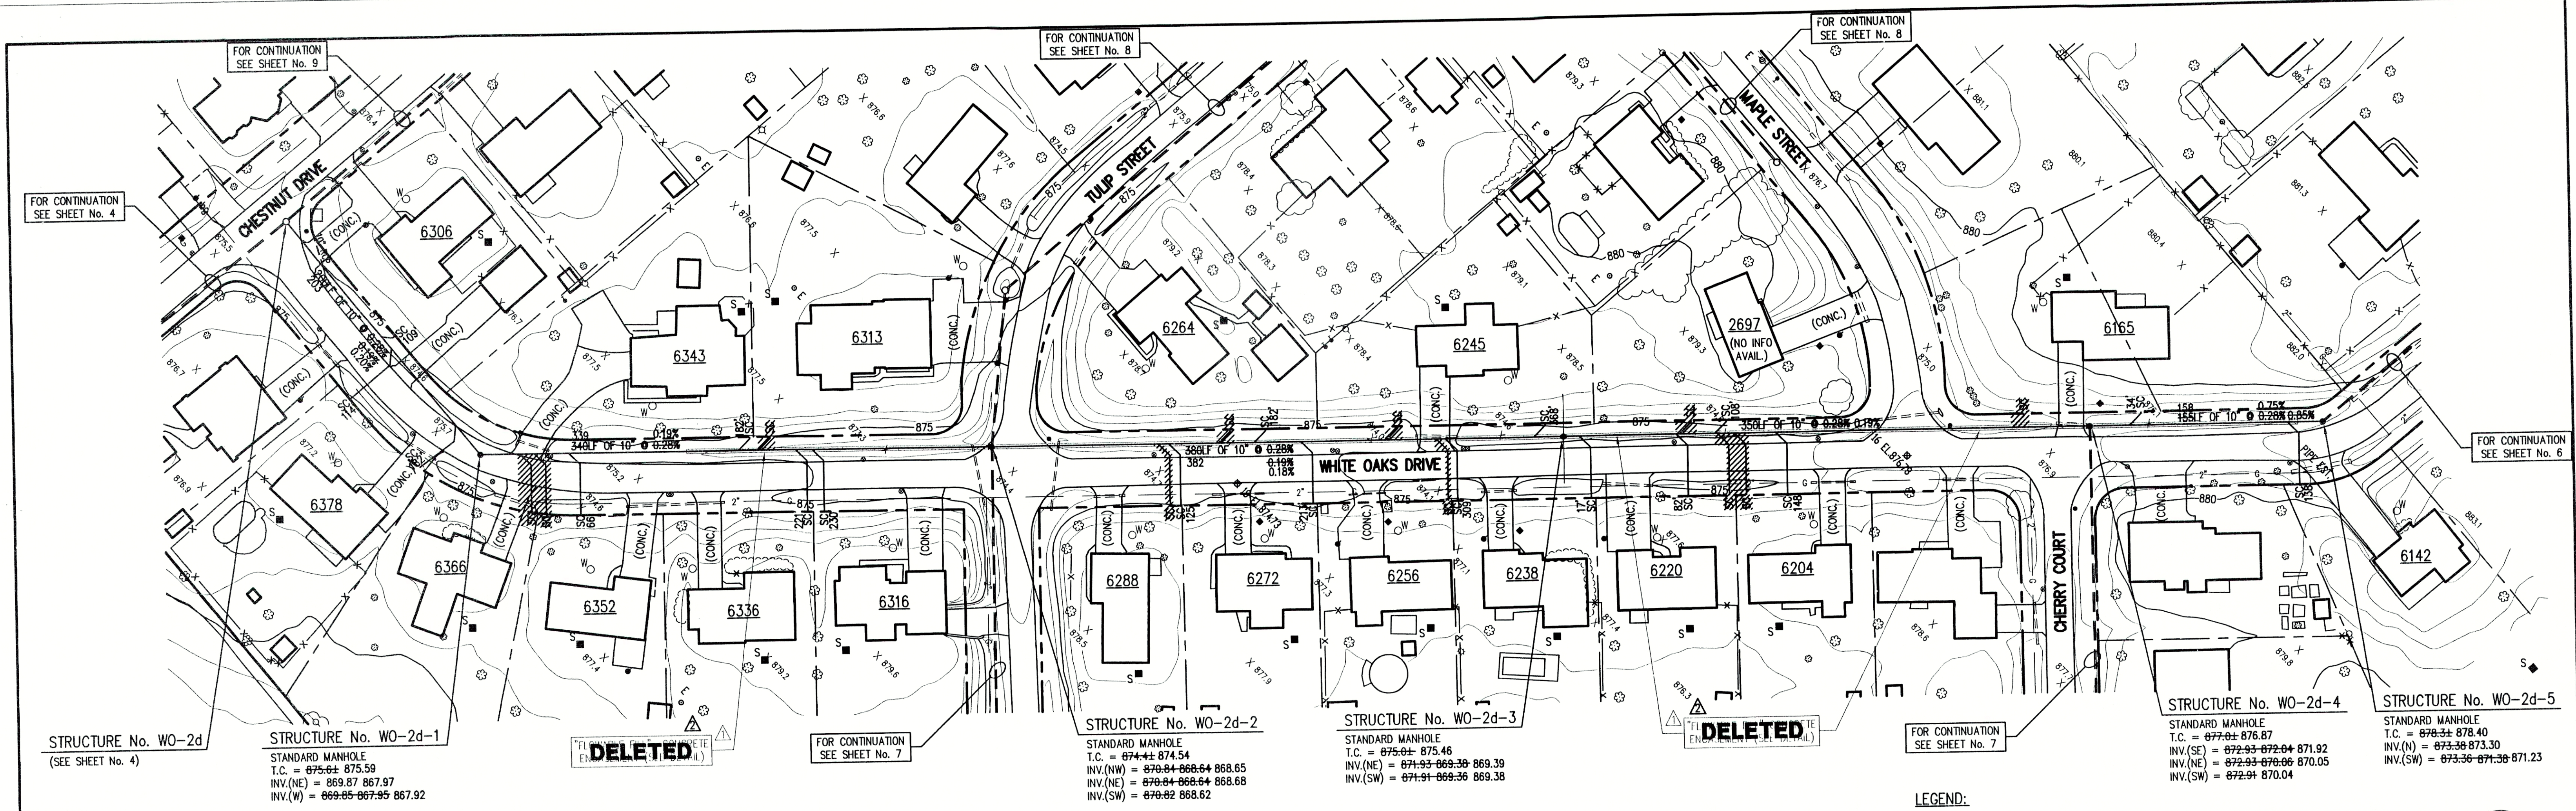

NOTE:
ADDITIONAL RIGHT-OF-WAY OR EASEMENTS MAY
NEED TO BE ACQUIRED FOR INSTALLATION OF SEWER.

DON'T DIG BILD
CALL BEFORE YOU DIG
TOLL FREE
1-800-382-5544
1-800-428-5200

PER INDIANA STATE LAW IS-69-1991, IT IS
AGAINST THE LAW TO EXCAVATE WITHOUT
NOTIFYING THE UNDERGROUND LOCATION SERVICE
TWO (2) WORKING DAYS BEFORE COMMENCING WORK.

NOTE: CONTRACTOR TO VERIFY ALL UTILITY LOCATIONS
PRIOR TO THE START OF CONSTRUCTION

- GENERAL NOTES:**
- ALL UTILITY LOCATIONS ARE APPROXIMATE. THE CONTRACTOR SHALL HAVE
ALL UTILITIES FIELD VERIFIED AND MARKED PRIOR TO CONSTRUCTION.
 - CONTRACTOR SHALL MAINTAIN A MINIMUM 10'-0" HORIZONTAL AND 18"
VERTICAL SEPARATION BETWEEN SEWER AND WATER MAINS.
 - ALL PROPOSED TOP OF CASTING ELEVATIONS ARE APPROXIMATE. THE CONTRACTOR
SHALL ADJUST FINAL ELEVATIONS AS REQUIRED TO BE FLUSH WITH PAVEMENT.
 - ALL SEWER TRENCHES SHALL BE BACKFILLED WITH FULL DEPTH COMPACTED
GRANULAR BACKFILL ("B" BORROW) UNDER OR WITHIN 5' OF EDGE OF PAVEMENT.
 - THE CONTRACTOR SHALL VISIT THE SITE PRIOR TO BID TO BECOME FAMILIAR
WITH ALL SITE CONDITIONS.
 - THE CONTRACTOR SHALL PROVIDE THE REQUIRED MEANS FOR MAINTAINING SAFE
TRAFFIC AT ALL TIMES.
 - CONTRACTOR SHALL RESTORE ALL DISTURBED LAWN AREAS, STREETS, WALKS,
DRIVES, ETC. AS SHOWN ON DRAWINGS, IN THE SPECIFICATIONS, OR TO AT
LEAST PRE-EXISTING CONDITIONS.
 - ALL UTILITY CROSSINGS SHALL BE PROTECTED AND SUPPORTED WITH GRANULAR
FILL OR CONCRETE AS REQUIRED PER THE DETAIL SHEET.


- LEGEND:**
- TREE
 - POWER POLE
 - GUY WIRE
 - FIRE HYDRANT
 - MAILBOX
 - FLAGPOLE
 - SPOT SHOT
 - CONTOUR
 - FENCE
 - EXIST. SANITARY
SEWER w/ MANHOLE
 - NEW SANITARY SEWER w/ MANHOLE
 - NEW SANITARY SERVICE CONNECTION
 - WATER LINE
 - GAS LINE
 - UNDERGROUND ELECTRIC LINE
 - UNDERGROUND TELEPHONE LINE
 - APPROX. RIGHT-OF-WAY
 - APPROX. CORPORATE LIMITS
 - APPROX. PROPERTY LINE
 - EXISTING WATER WELL
 - EXISTING SEPTIC TANK

SCALE:
HORIZONTAL 1" = 50'
VERTICAL 1" = 5'

NORTH

RECORD DRAWING

February 15, 2001

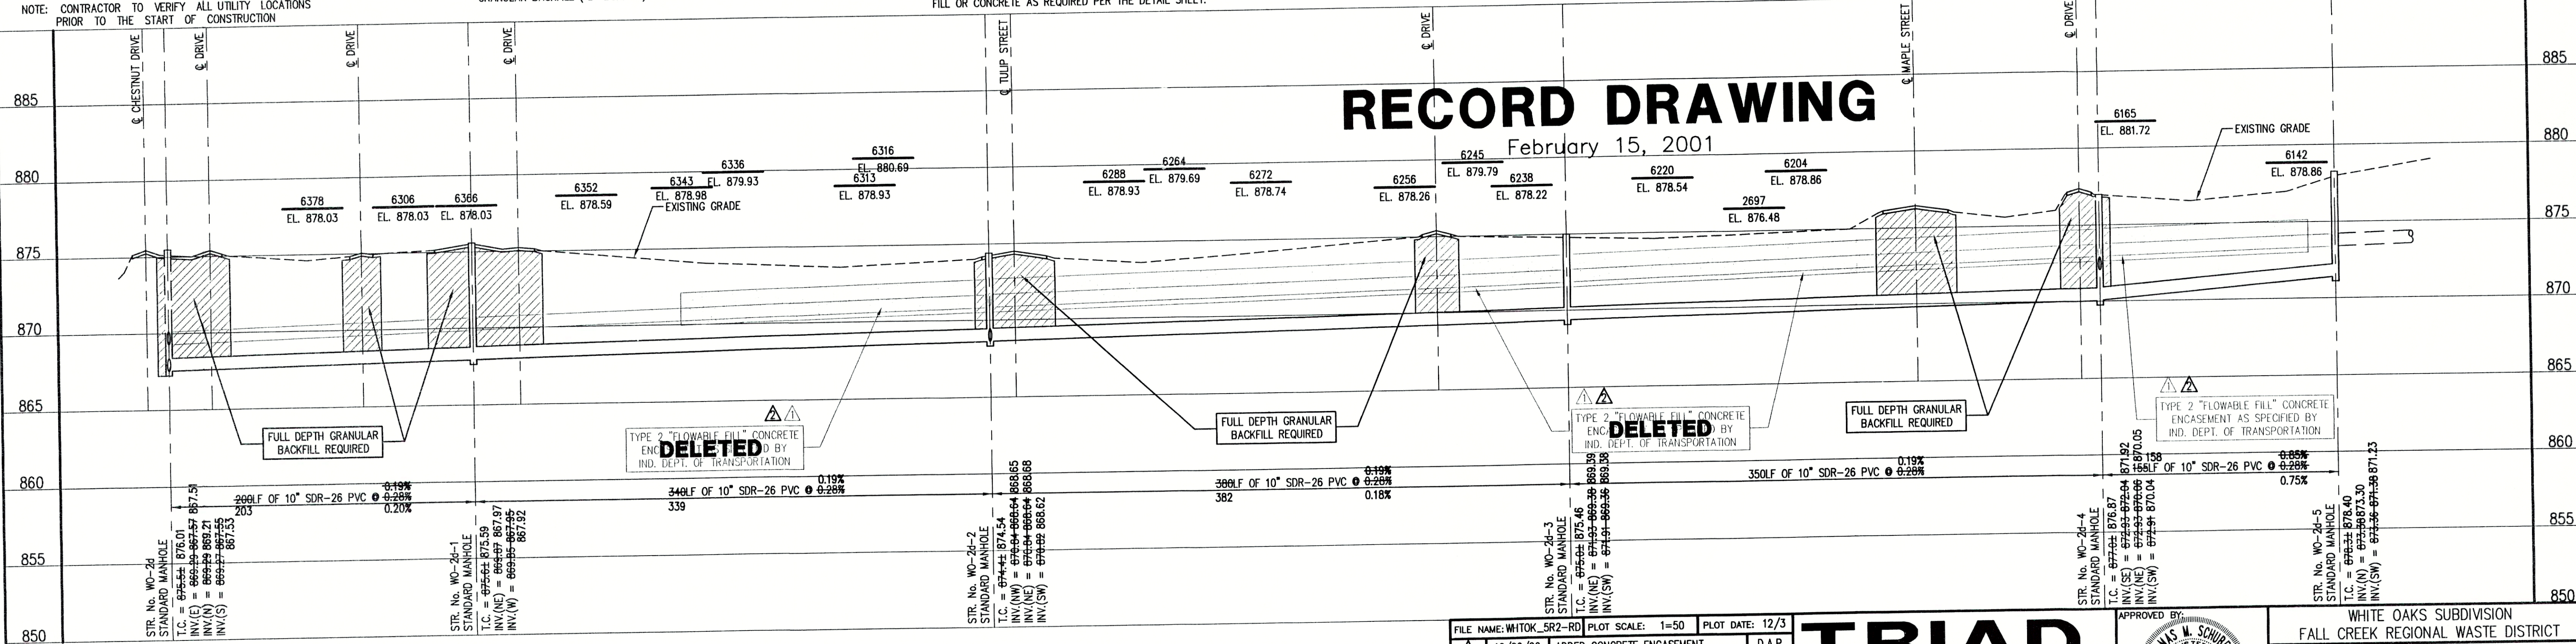

NOTE:
THE CONTRACTOR SHALL INCLUDE IN THE COSTS FOR SANITARY PIPE,
ALL WATER SERVICE RECONNECTIONS, STORM SEWER RECONNECTION,
WATER MAIN RELOCATIONS, CONCRETE RECONSTRUCTION, AND
SIDEWALK RECONSTRUCTION AS REQUIRED TO INSTALL NEW WORK
AS SHOWN ON THE DRAWINGS.

FILE NAME: WHITOK_5R2-RD PLOT SCALE: 1"=50' PLOT DATE: 12/3		TRIAD ASSOCIATES INC. INDIANAPOLIS, INDIANA		THOMAS W. SCHUBERT REGISTERED PROFESSIONAL ENGINEER No. 15614 STATE OF INDIANA	WHITE OAKS SUBDIVISION FALL CREEK REGIONAL WASTE DISTRICT	
PLAN AND PROFILE						
DRAWN BY: DAP	DATE: 04/12/98				PROJECT No. 98008A	SHEET No. 5
DESIGNED BY: D.A. Pauling		CHECKED BY: James W. Frazell, P.E.		of 11		