

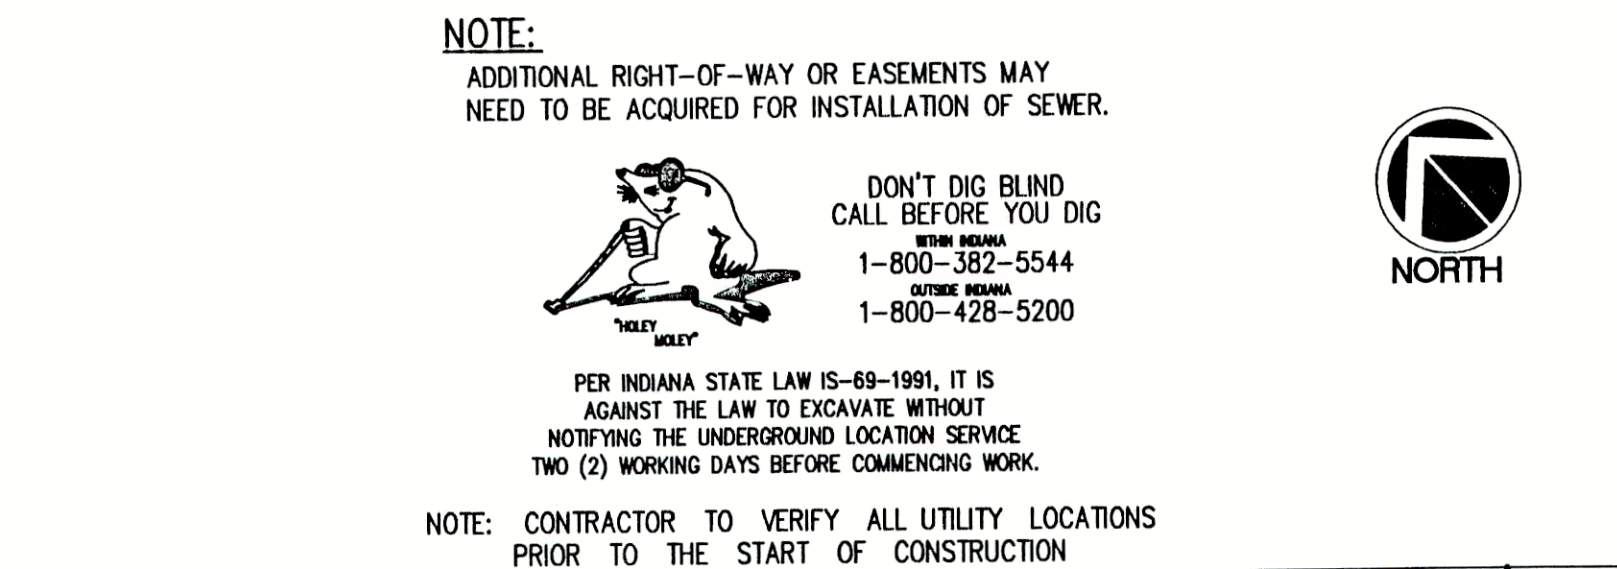


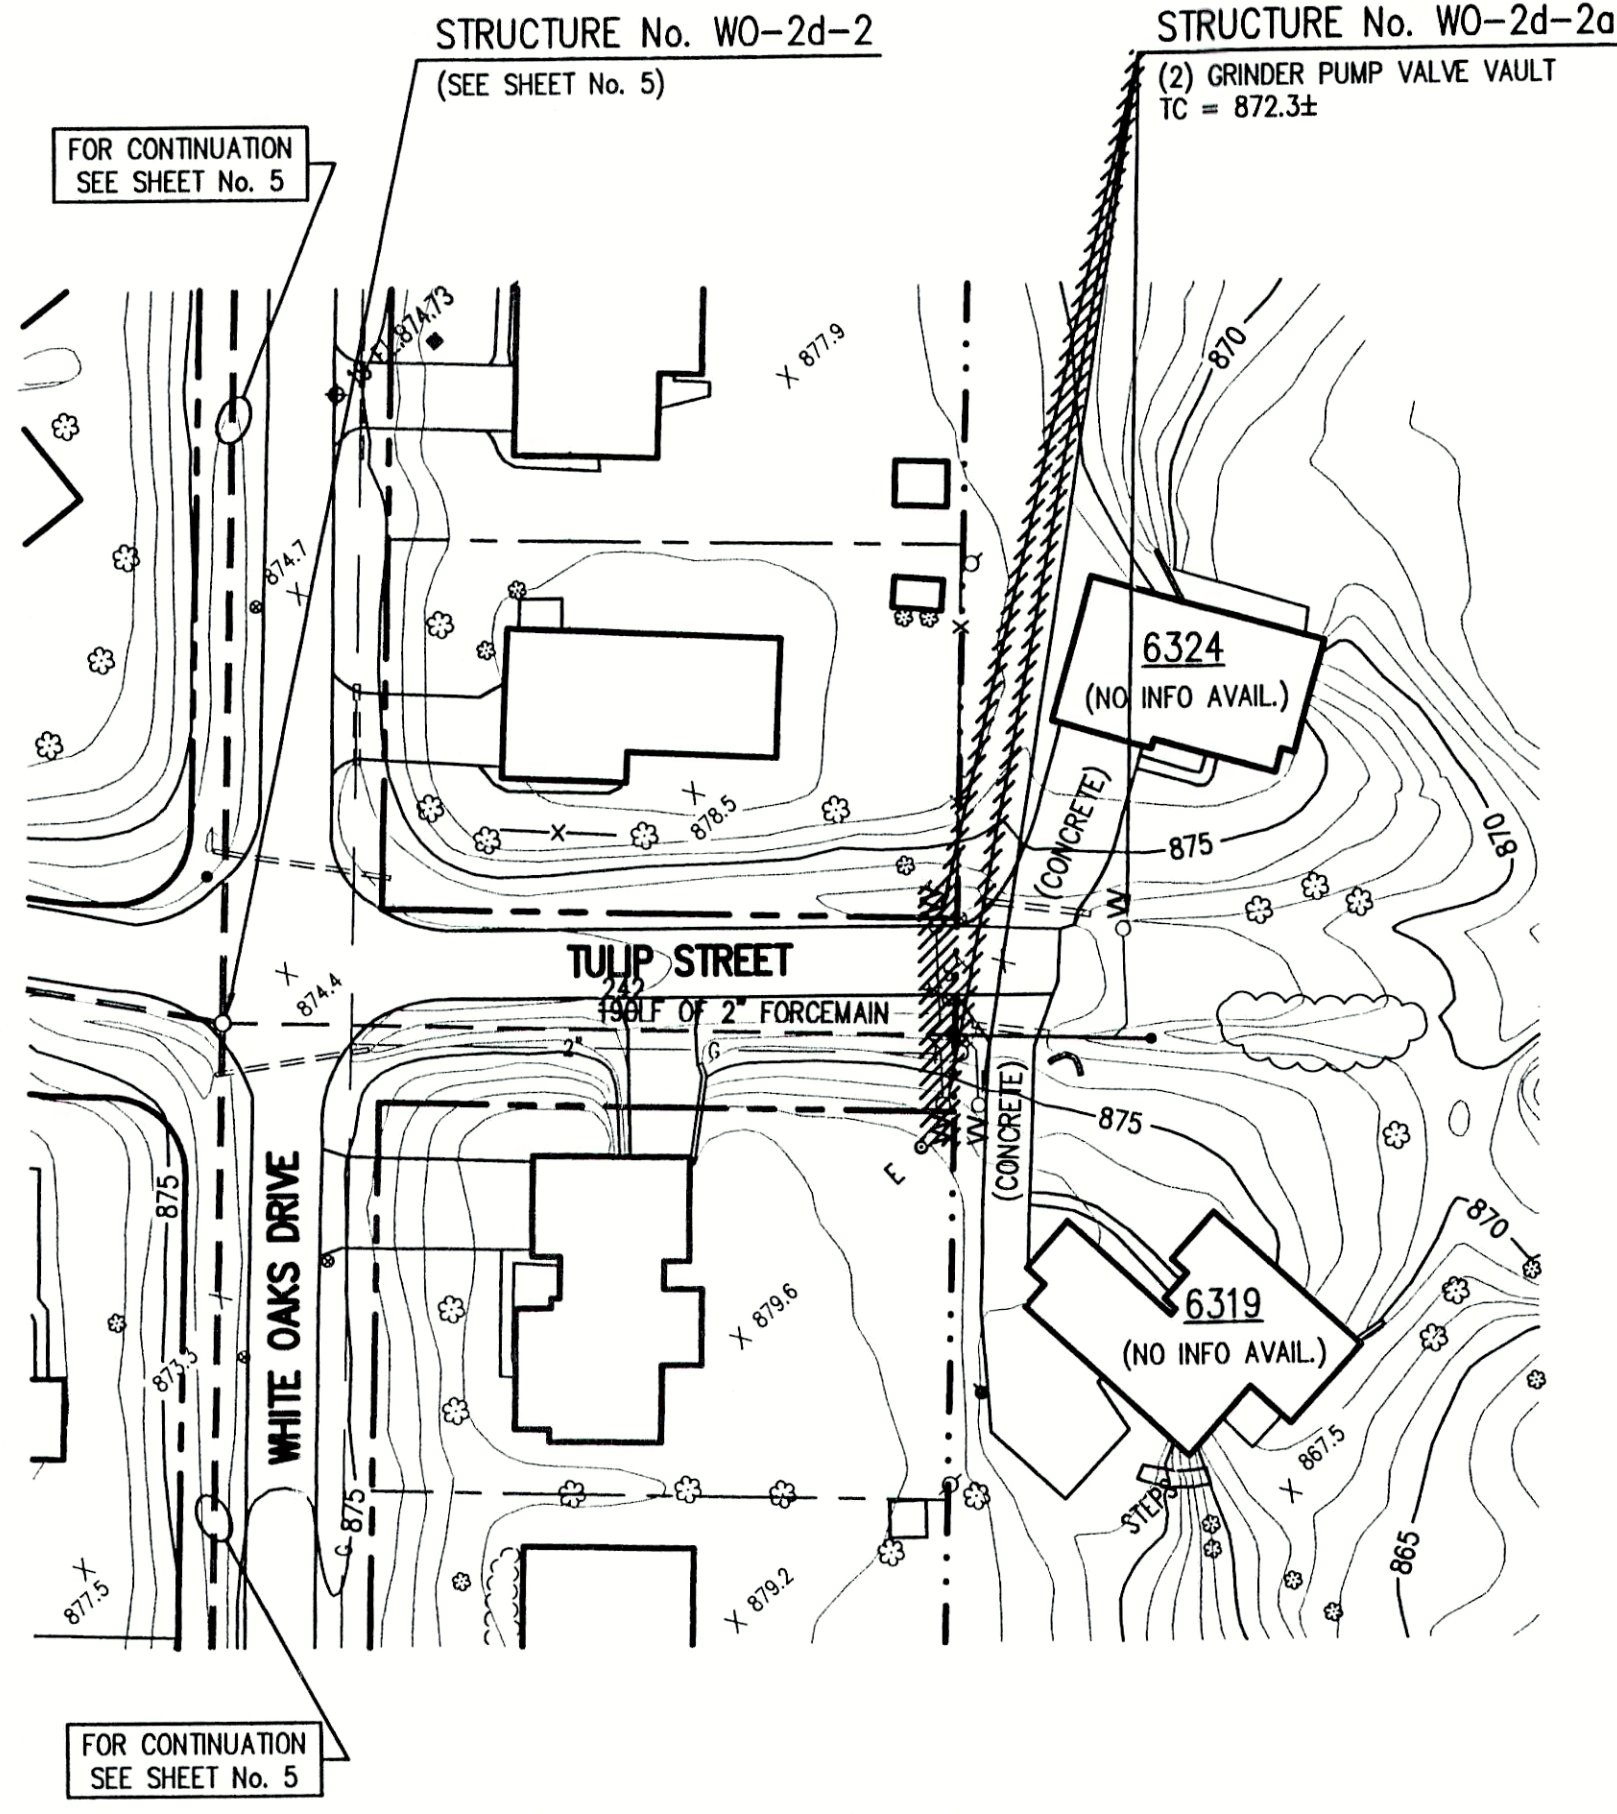

- NOTE:**
ADDITIONAL RIGHT-OF-WAY OR EASEMENTS MAY
NEED TO BE ACQUIRED FOR INSTALLATION OF SEWER.
- 
A cartoon illustration of a blind man wearing a hat and holding a cane, walking a dog. The dog is also wearing a hat and has the word "WILEY" written on its collar. The man is looking down at the cane.
- DON'T DIG BLIND
CALL BEFORE YOU DIG
800-382-5544
1-800-382-5544
OR
1-800-428-5200
- PER INDIANA STATE LAW IS-69-1991, IT IS
AGAINST THE LAW TO EXCAVATE WITHOUT
NOTIFYING THE UNDERGROUND LOCATION SERVICE
TWO (2) WORKING DAYS BEFORE COMMENCING WORK.
- NOTE: CONTRACTOR TO VERIFY ALL UTILITY LOCATIONS
PRIOR TO THE START OF CONSTRUCTION**

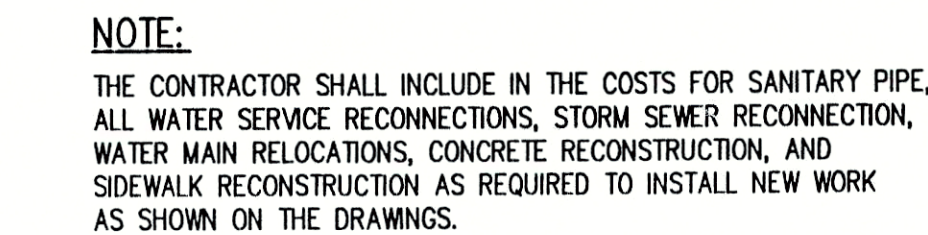

TRIAD
ASSOCIATES
INC.
INDIANAPOLIS, INDIANA

WHITE OAKS SUBDIVISION			
FALL CREEK REGIONAL WASTE DISTRICT			
PLAN AND PROFILE			
DRAWN BY: DAP	DATE 04/12/98	PROJECT No. 98008A	SHEET No. 7
SCALE AS NOTED			
DESIGNED BY: D.A. Pauling			
CHECKED BY: James W. Frazell, P.E.		OF 11	