


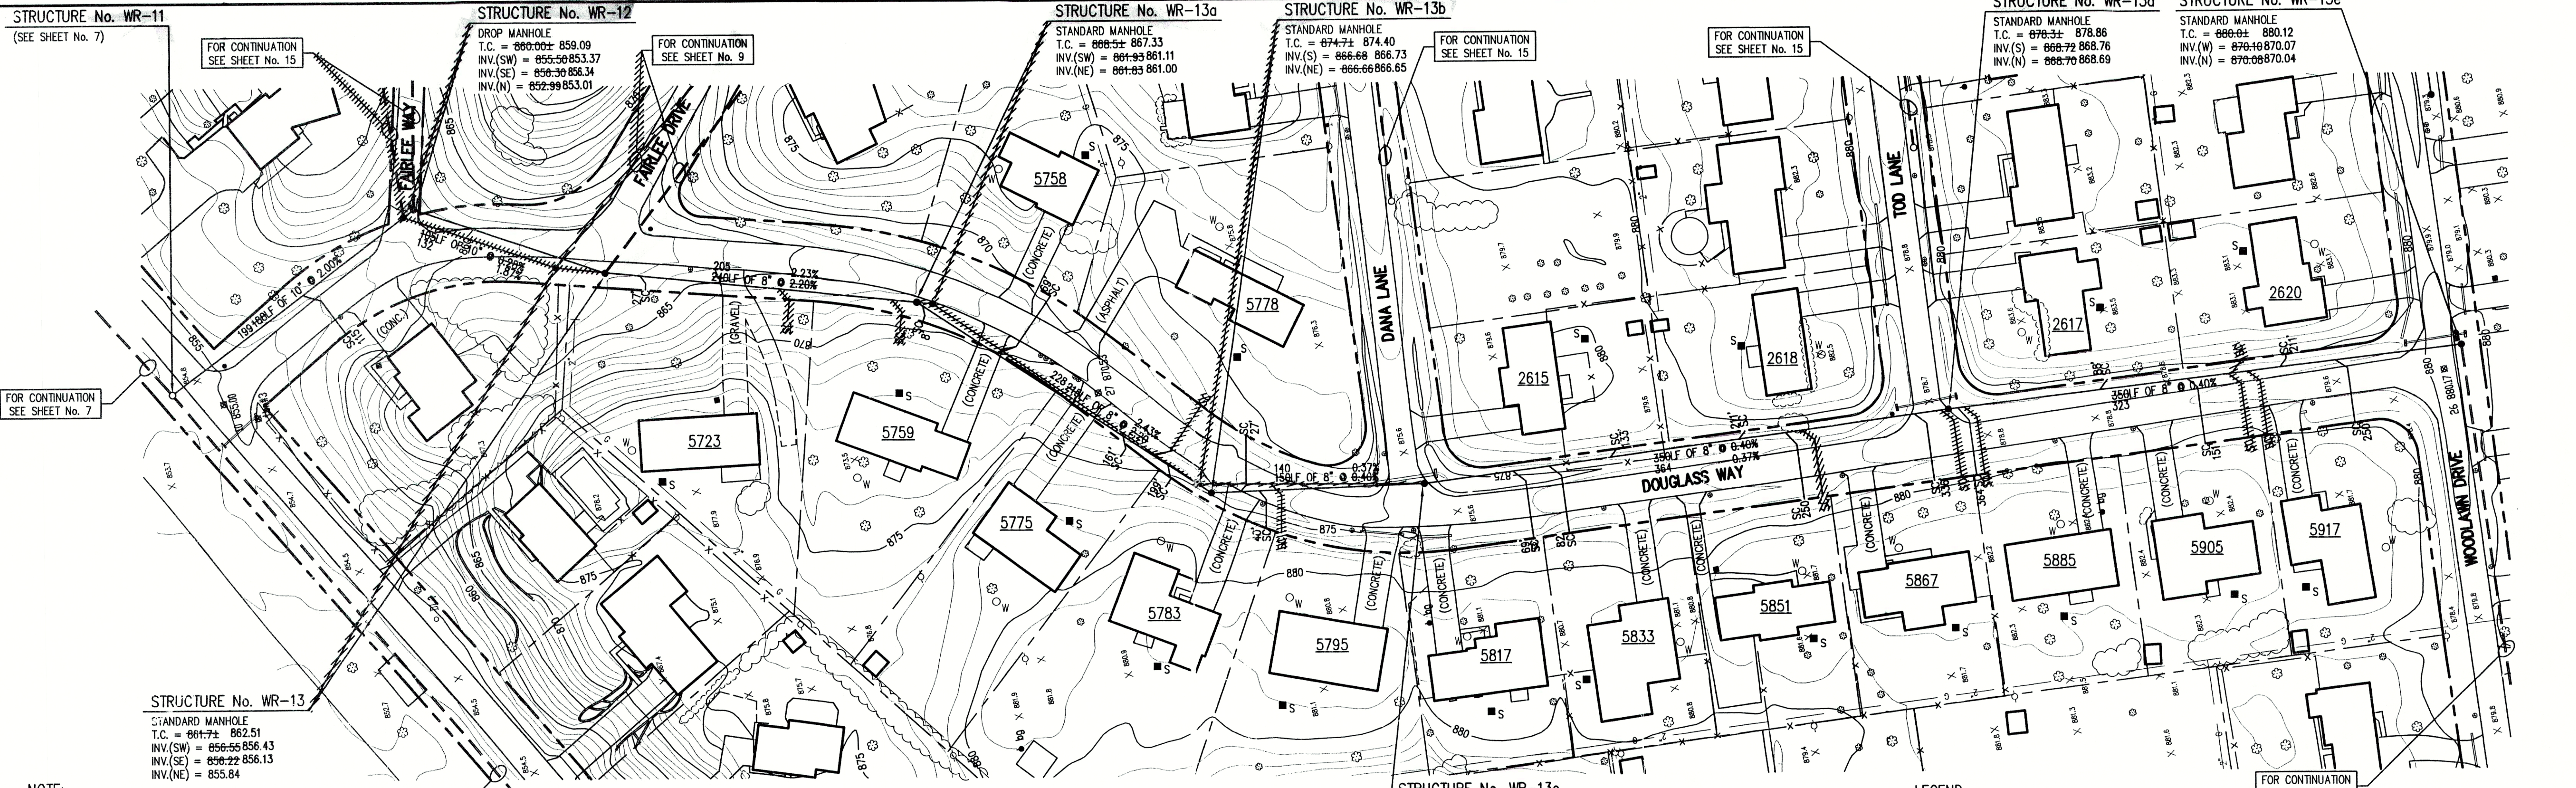

NOTE:
ADDITIONAL RIGHT-OF-WAY OR EASEMENTS MAY
NEED TO BE ACQUIRED FOR INSTALLATION OF SEWER.


NOTE: CONTRACTOR TO VERIFY ALL UTILITY LOCATIONS
PRIOR TO THE START OF CONSTRUCTION

GENERAL NOTES:

- ALL UTILITY LOCATIONS ARE APPROXIMATE. THE CONTRACTOR SHALL HAVE ALL UTILITIES FIELD VERIFIED AND MARKED PRIOR TO CONSTRUCTION.
- CONTRACTOR SHALL MAINTAIN A MINIMUM 10'-0" HORIZONTAL AND 18" VERTICAL SEPARATION BETWEEN SEWER AND WATER MAINS.
- ALL PROPOSED TOP OF CASTING ELEVATIONS ARE APPROXIMATE. THE CONTRACTOR SHALL ADJUST FINAL ELEVATIONS AS REQUIRED TO BE FLUSH WITH PAVEMENT.
- ALL SEWER TRENCHES SHALL BE BACKFILLED WITH FULL DEPTH COMPACTED GRANULAR BACKFILL ("B" BORROW) UNDER OR WITHIN 5' OF EDGE OF PAVEMENT.
- THE CONTRACTOR SHALL VISIT THE SITE PRIOR TO BID TO BECOME FAMILIAR WITH ALL SITE CONDITIONS.
- THE CONTRACTOR SHALL PROVIDE THE REQUIRED MEASURES FOR MAINTAINING SAFE TRAFFIC AT ALL TIMES.
- CONTRACTOR SHALL RESTORE ALL DISTURBED LAWN AREAS, STREETS, WALKS, DRIVES, ETC. AS SHOWN ON DRAWINGS, IN THE SPECIFICATIONS, OR TO AT LEAST PRE-EXISTING CONDITIONS.
- ALL UTILITY CROSSINGS SHALL BE PROTECTED AND SUPPORTED WITH GRANULAR FILL OR CONCRETE AS REQUIRED PER THE DETAIL SHEET.

LEGEND:

- 1085 ——— CONTOUR
- — — — — UNDERGROUND ELECTRIC LINE
- — — — — UNDERGROUND TELEPHONE LINE
- — — — — APPROX. RIGHT-OF-WAY
- — — — — APPROX. CORPORATE LIMITS
- — — — — APPROX. PROPERTY LINE
- W ——— EXISTING WATER WELL
- S ——— EXISTING SEPTIC TANK
- — — — — EXIST. SANITARY SEWER w/ MANHOLE
- — — — — NEW SANITARY SEWER w/ MANHOLE
- — — — — NEW SANITARY SERVICE CONNECTION
- — — — — WATER LINE
- — — — — GAS LINE
- — — — — FENCE
- — — — — GUY WIRE
- — — — — FIRE HYDRANT
- — — — — MAILBOX
- — — — — FLAGPOLE
- — — — — SPOT SHOT

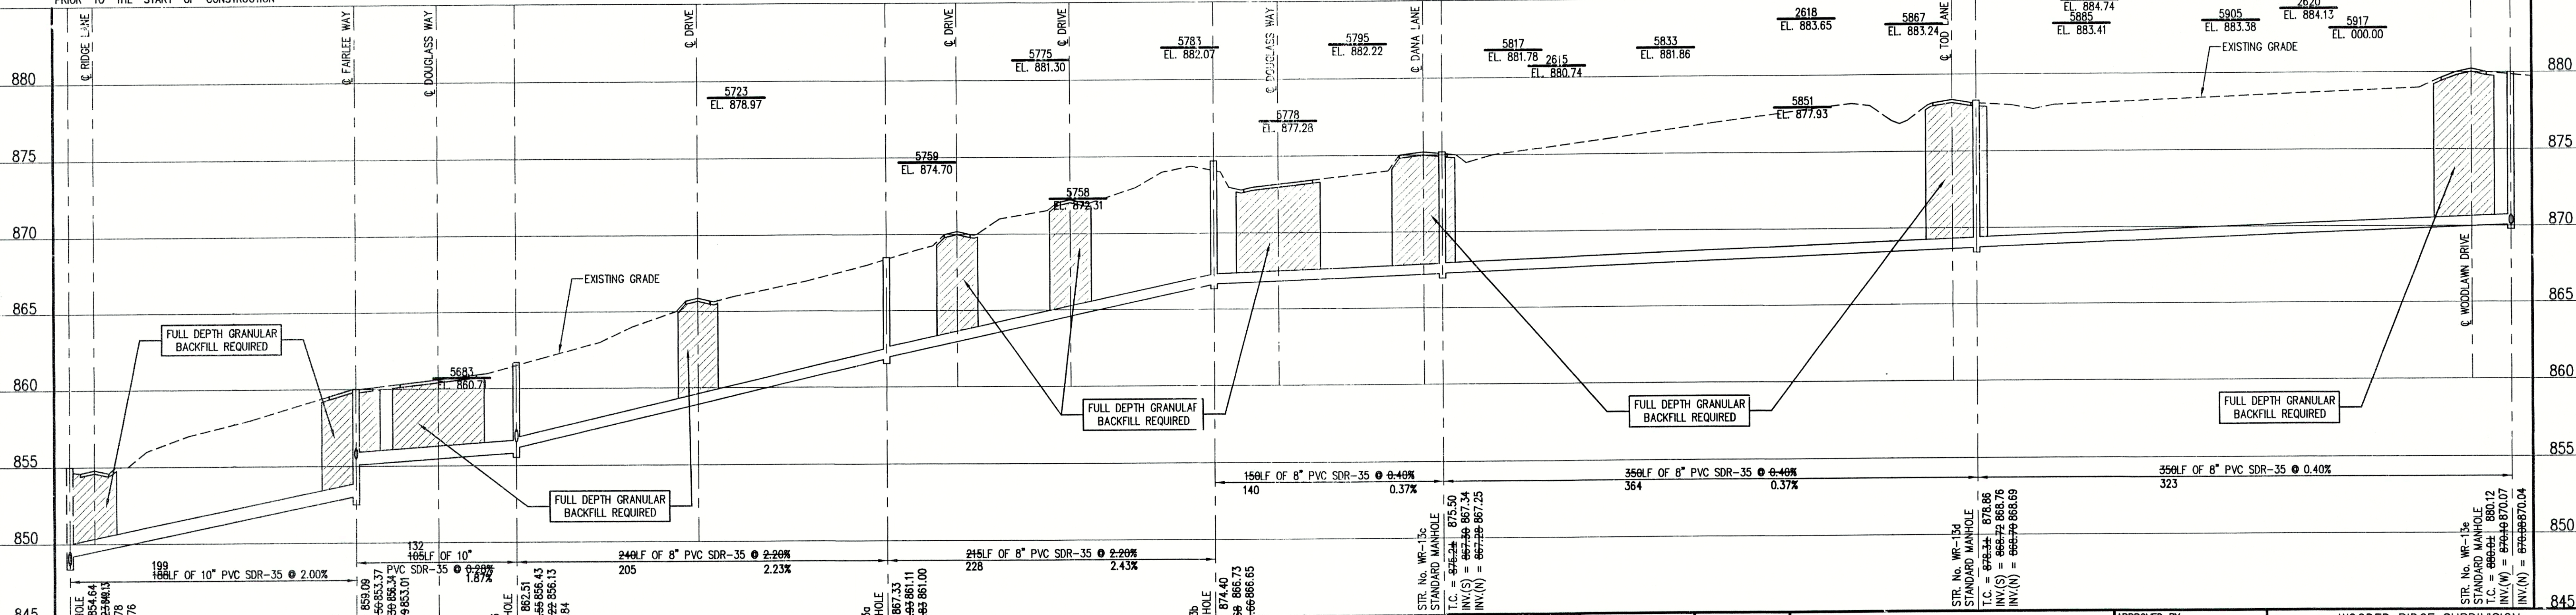

STRUCTURE No. WR-11
STANDARD MANHOLE
T.C. = 861.71 ± 862.51
INV.(SW) = 856.55 856.43
INV.(SE) = 856.22 856.13
INV.(NE) = 855.84

STRUCTURE No. WR-12
DROP MANHOLE
T.C. = 860.00 ± 859.09
INV.(SW) = 855.50 853.37
INV.(SE) = 856.30 856.34
INV.(N) = 852.99 853.01

STRUCTURE No. WR-13
STANDARD MANHOLE
T.C. = 861.71 ± 862.51
INV.(SW) = 856.55 856.43
INV.(SE) = 856.22 856.13
INV.(NE) = 855.84

STRUCTURE No. WR-13a
STANDARD MANHOLE
T.C. = 868.51 ± 867.33
INV.(SW) = 861.93 861.11
INV.(NE) = 861.83 861.00

STRUCTURE No. WR-13b
STANDARD MANHOLE
T.C. = 874.71 ± 874.40
INV.(S) = 866.66 866.73
INV.(NE) = 866.66 866.65

STRUCTURE No. WR-13c
STANDARD MANHOLE
T.C. = 875.21 ± 875.50
INV.(S) = 867.36 867.34
INV.(N) = 867.28 867.25

STRUCTURE No. WR-13d
STANDARD MANHOLE
T.C. = 878.31 ± 878.86
INV.(S) = 868.72 868.76
INV.(N) = 868.70 868.69

STRUCTURE No. WR-13e
STANDARD MANHOLE
T.C. = 880.01 ± 880.12
INV.(W) = 870.40 870.07
INV.(N) = 870.08 870.04

RECORD DRAWING

February 15, 2001

NOTE: THE CONTRACTOR SHALL INCLUDE IN THE COSTS FOR SANITARY PIPE, ALL WATER SERVICE RECONNECTIONS, STORM SEWER RECONNECTION, WATER MAIN RELOCATIONS, CONCRETE RECONSTRUCTION, AND SIDEWALK RECONSTRUCTION AS REQUIRED TO INSTALL NEW WORK AS SHOWN ON THE DRAWINGS.

TRIAD ASSOCIATES INC.

INDIANAPOLIS, INDIANA

FILE NAME: WDR06_4-RD PLOT SCALE: 1=50 PLOT DATE: 12/5

NO.	DATE	DESCRIPTION	BY

APPROVED BY:

THOMAS M. SCHUBERT

REGISTERED PROFESSIONAL ENGINEER

No. 15614

STATE OF INDIANA

Thomas M. Schubert, P.E.

WOODED RIDGE SUBDIVISION
FALL CREEK REGIONAL WASTE DISTRICT

PLAN AND PROFILE

DRAWN BY: DATE 04/12/98 PROJECT No. 98008A SHEET No. 8

DESIGNED BY: D.A. Pauling

CHECKED BY: James W. Frazell, P.E.