


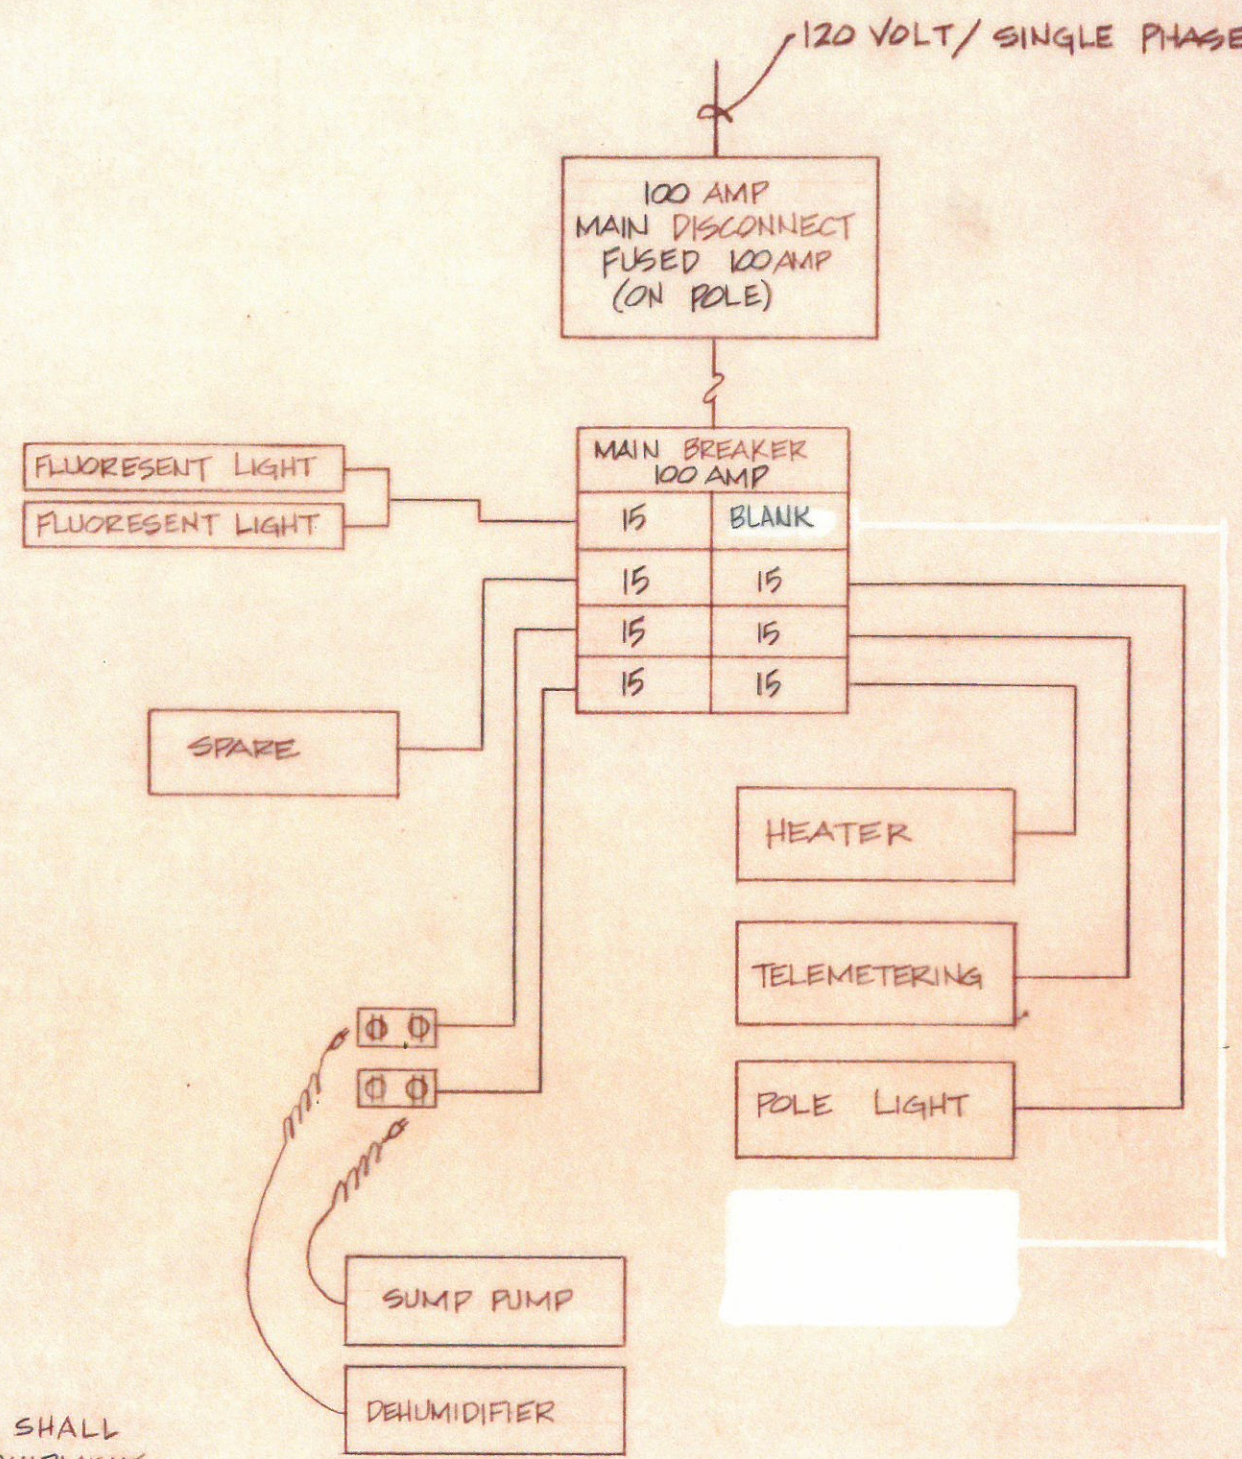


**NOTE:**

THE DIVISION "A" CONTRACTOR SHALL FURNISH & INSTALL ALL EQUIPMENT AS SHOWN ON THIS SHEET AS A PART OF THE LUMP SUM BID ITEM FOR THE SOLENOID VALVE VAULT AS PER THE SPECIFICATIONS & BID PROPOSALS.

ALL ELECTRICAL WORK SHALL BE IN ACCORDANCE WITH THE NATIONAL ELECTRICAL CODE REQUIREMENTS/LATEST EDITION.

**AS BUILT**  
 Date 6-16-83 By M. Seemur

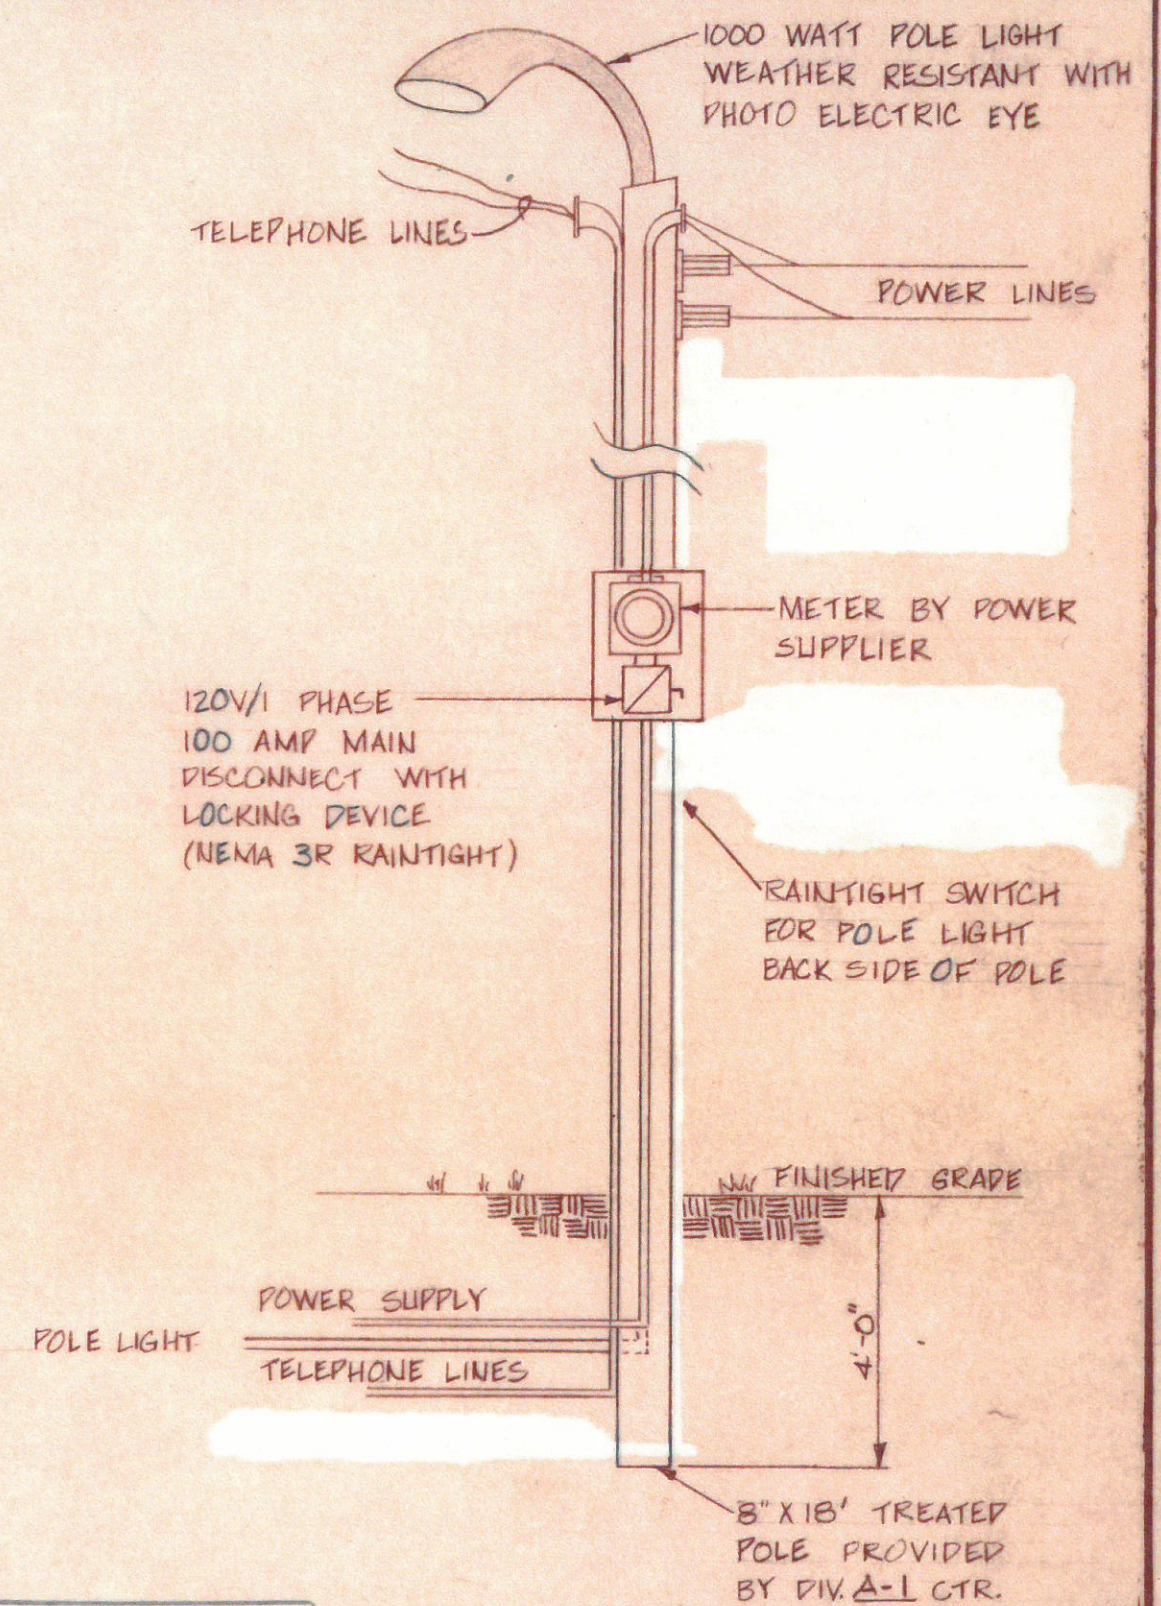

|                                                                                                              |           |            |
|--------------------------------------------------------------------------------------------------------------|-----------|------------|
| <br>CONSULTING ENGINEERS,<br>ARCHITECTS, PLANNERS<br>Columbus, Indiana<br>Madison, Indiana<br>Delaware, Ohio | JOB       | 61140      |
|                                                                                                              | SHEET NO. | 85 OF 89   |
|                                                                                                              | SCALE     | NONE       |
|                                                                                                              | DATE      | 1-29-80    |
|                                                                                                              | DRAWN     | NEW        |
|                                                                                                              | CHECKED   | David Jett |
| APPROVED                                                                                                     |           |            |
| CERTIFIED                                                                                                    |           |            |

ELROD WATER COMPANY, INC.  
 RIPLEY CO., IND.  
 SYSTEM IMPROV. - DIVISION "A"  
 SOLENOID ELECTRICAL DETAILS