


# MAIN CONTROL PANEL IN BOOSTER STATION

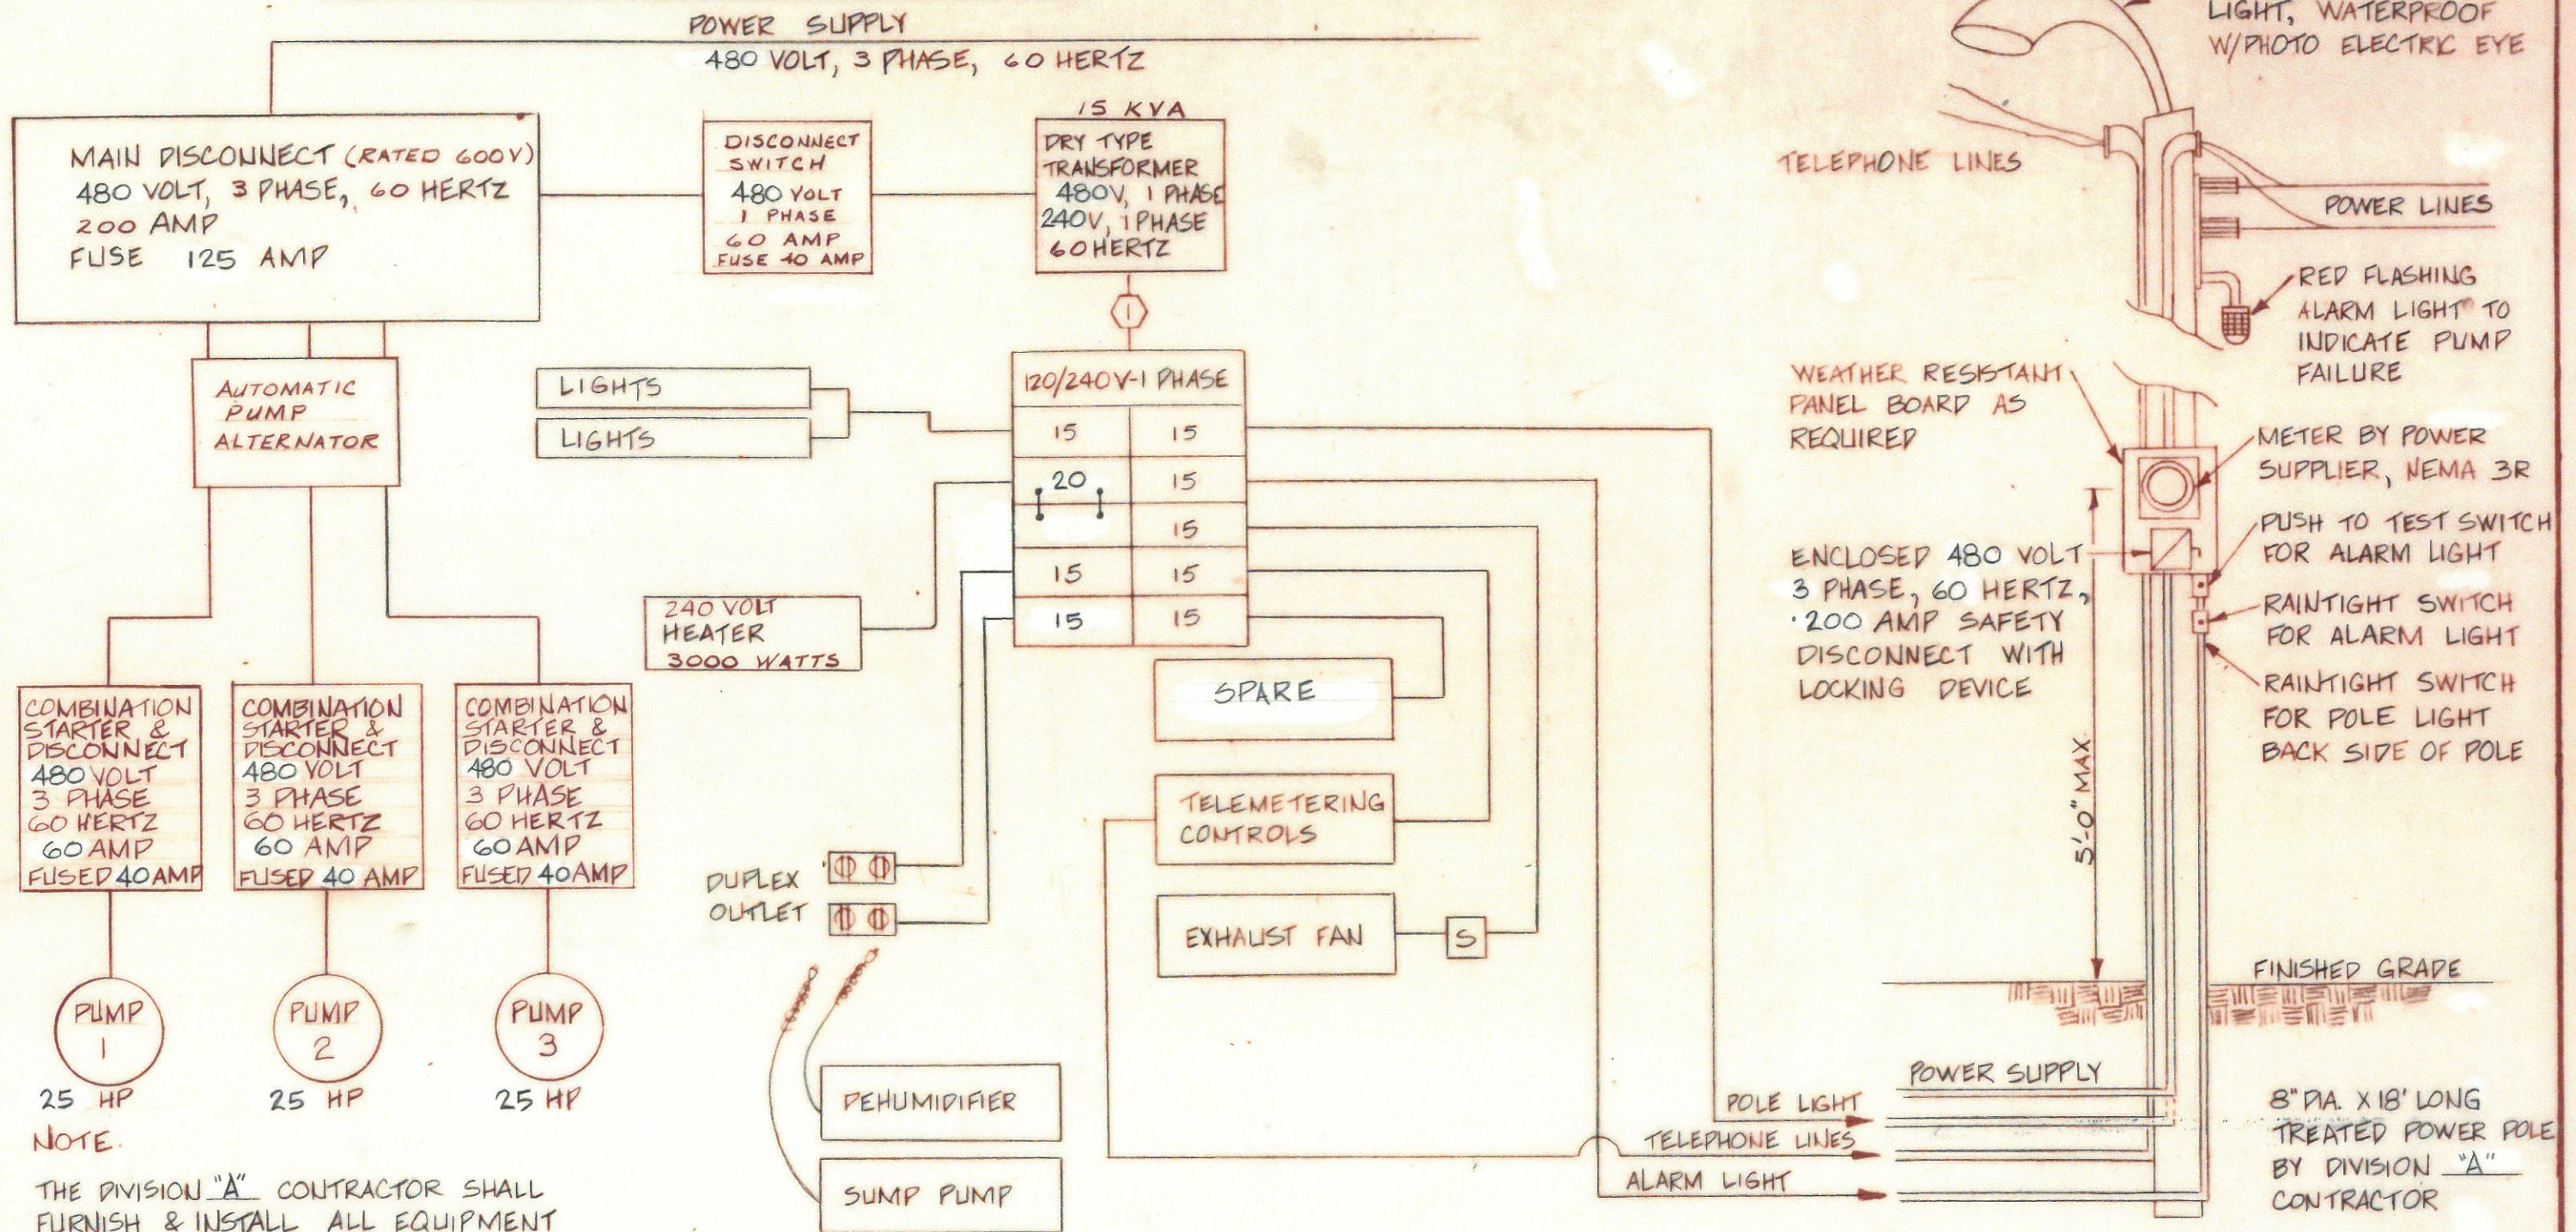

① 120/240V, SINGLE PHASE, 100 AMP PANEL BOARD - BREAKER TYPE - WITH MAIN BREAKER FUSED 60 AMP, 10 CIRCUITS WITH SOLID NEUTRAL.

AS BUILT

Date 6-16-83 By M. Sencus

|                                                                                                                      |           |            |
|----------------------------------------------------------------------------------------------------------------------|-----------|------------|
|                                                                                                                      | JOB       | 61140      |
|                                                                                                                      | SHEET NO. | 87 of 89   |
|                                                                                                                      | SCALE     | NONE       |
|                                                                                                                      | DATE      | 1-29-80    |
|                                                                                                                      | DRAWN     | W. D.J.    |
|                                                                                                                      | CHECKED   | David Jett |
|                                                                                                                      | APPROVED  |            |
|                                                                                                                      | CERTIFIED |            |
| ELROD WATER COMPANY, INC.<br>RIPLEY CO., INC.<br>SYSTEM IMPROV. - DIVISION "A"<br>BOOSTER STATION ELECTRICAL DETAILS |           |            |