




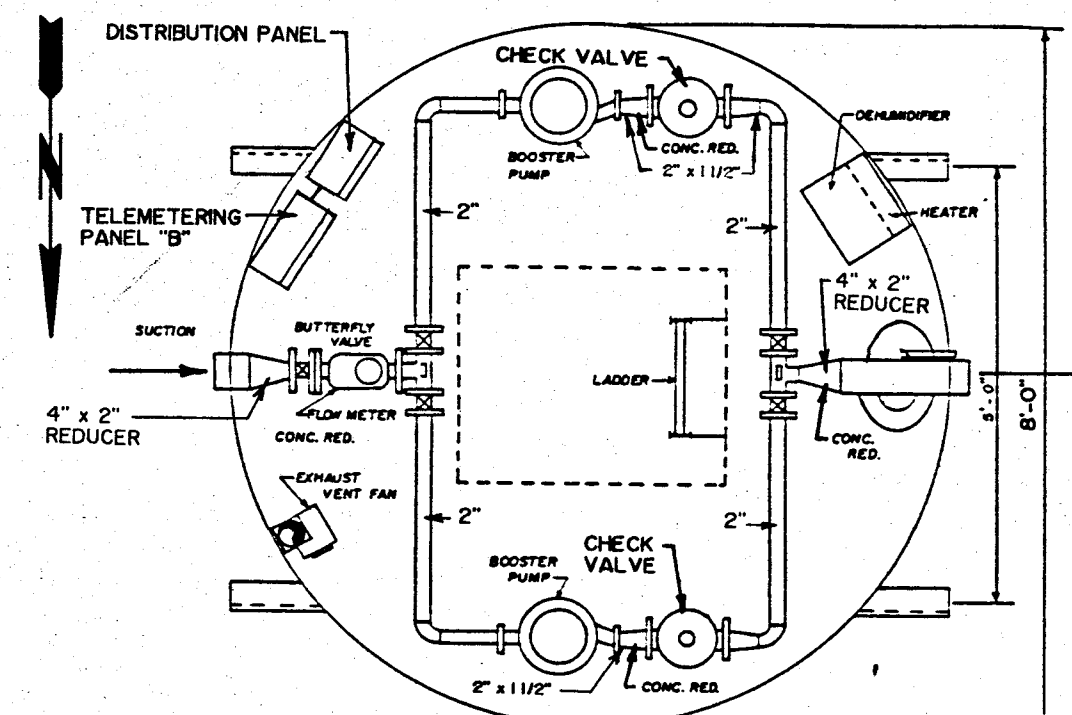

PLAN VIEW

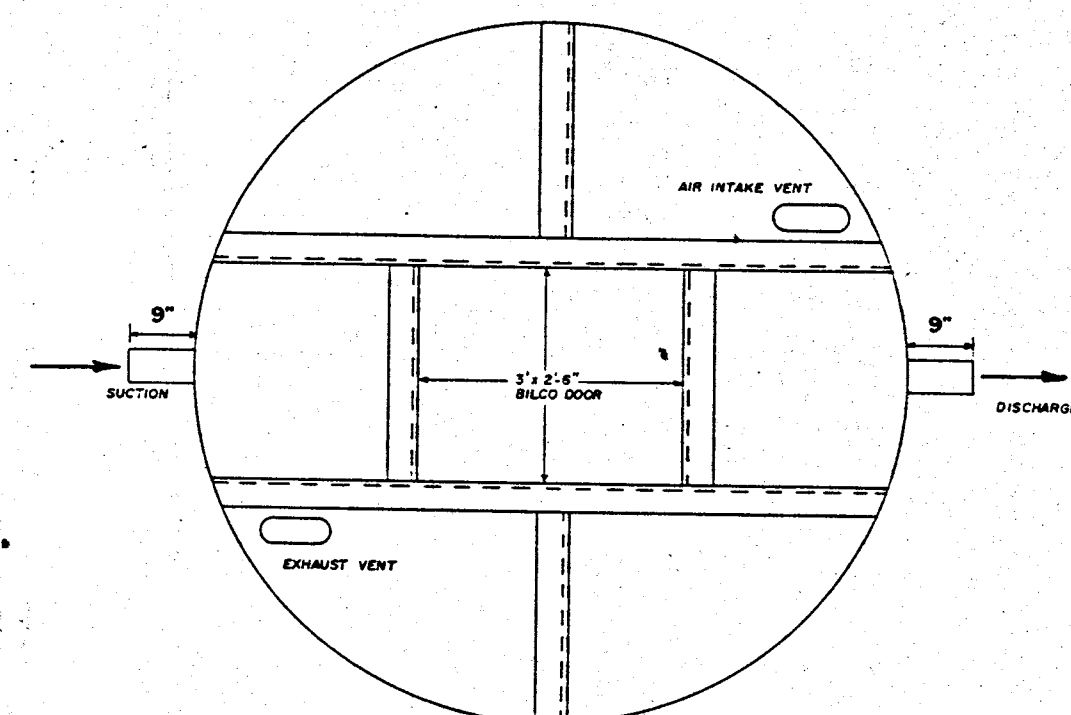


TOP VIEW

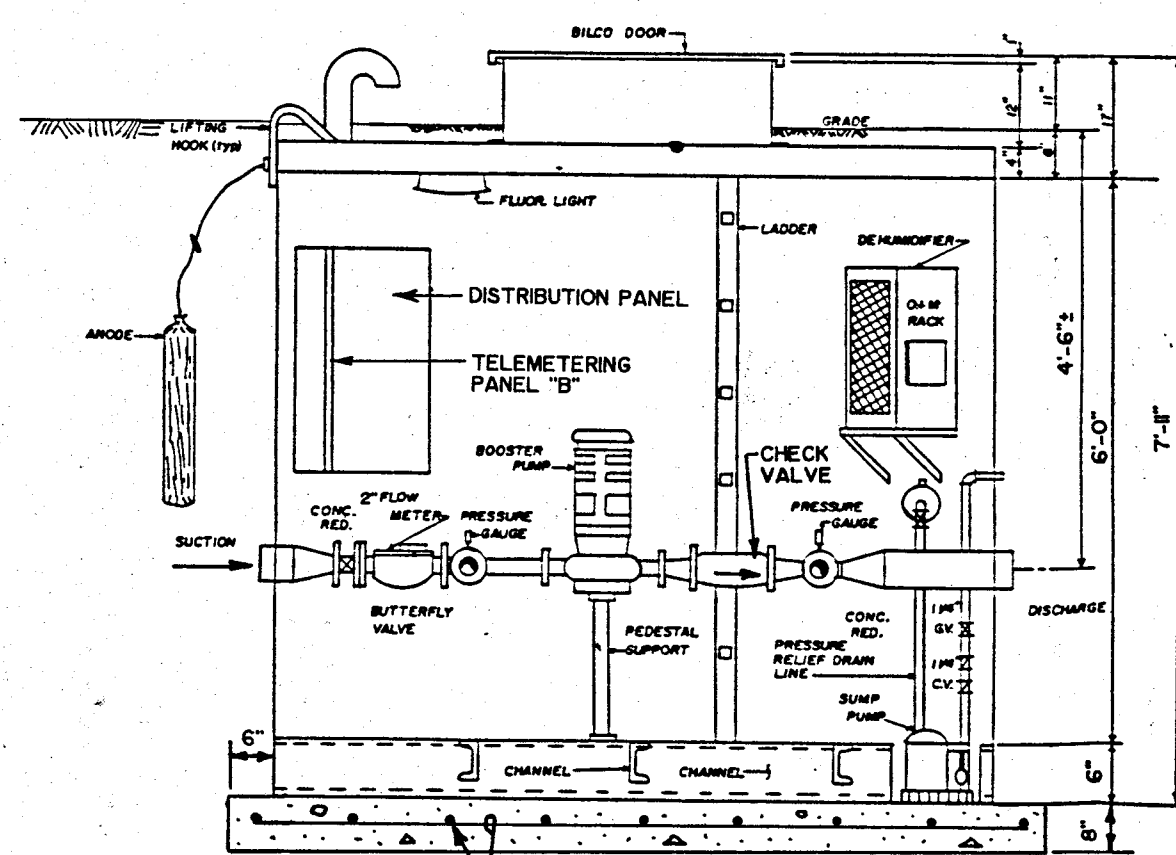


SECTION VIEW


4 BOOSTER STATION VAULT DETAILS
41 NO SCALE

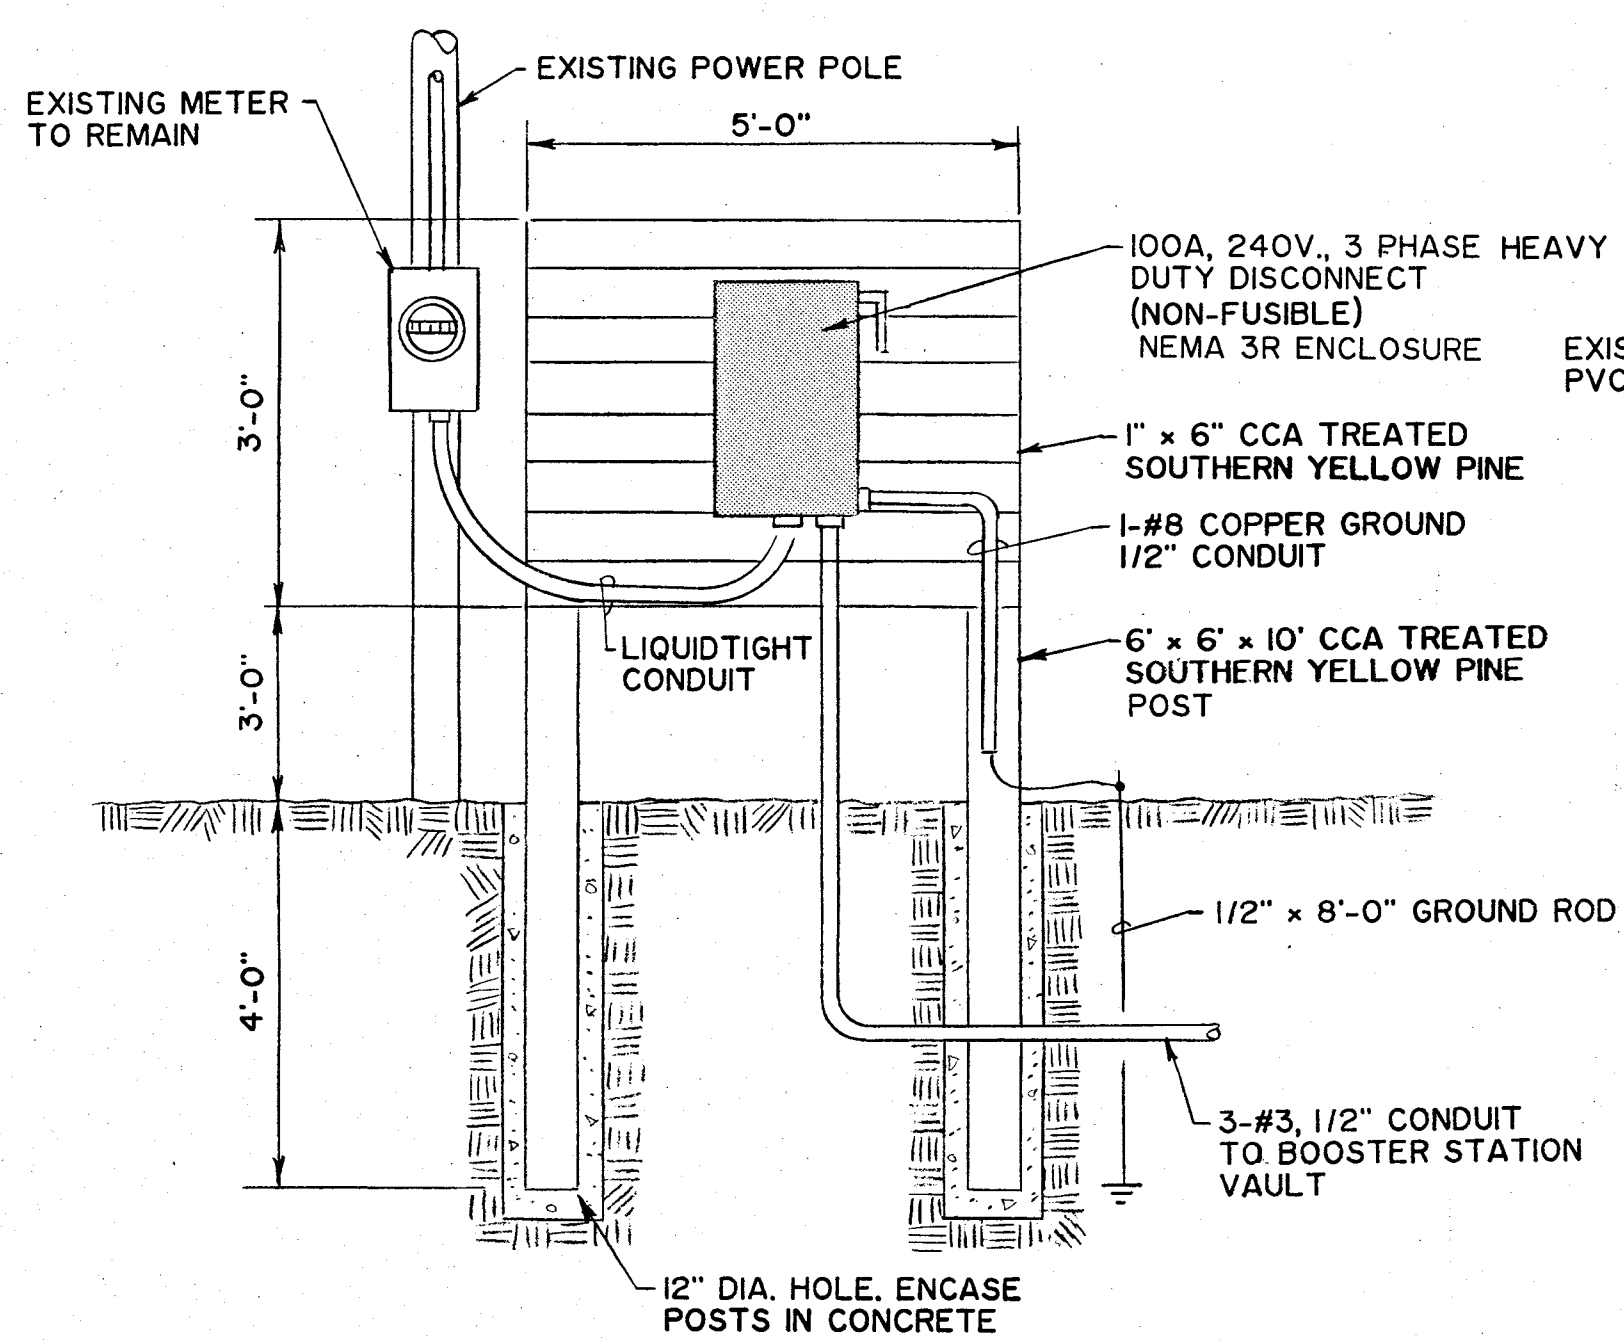

5 ELECTRICAL DISCONNECT DETAIL
41 NO SCALE

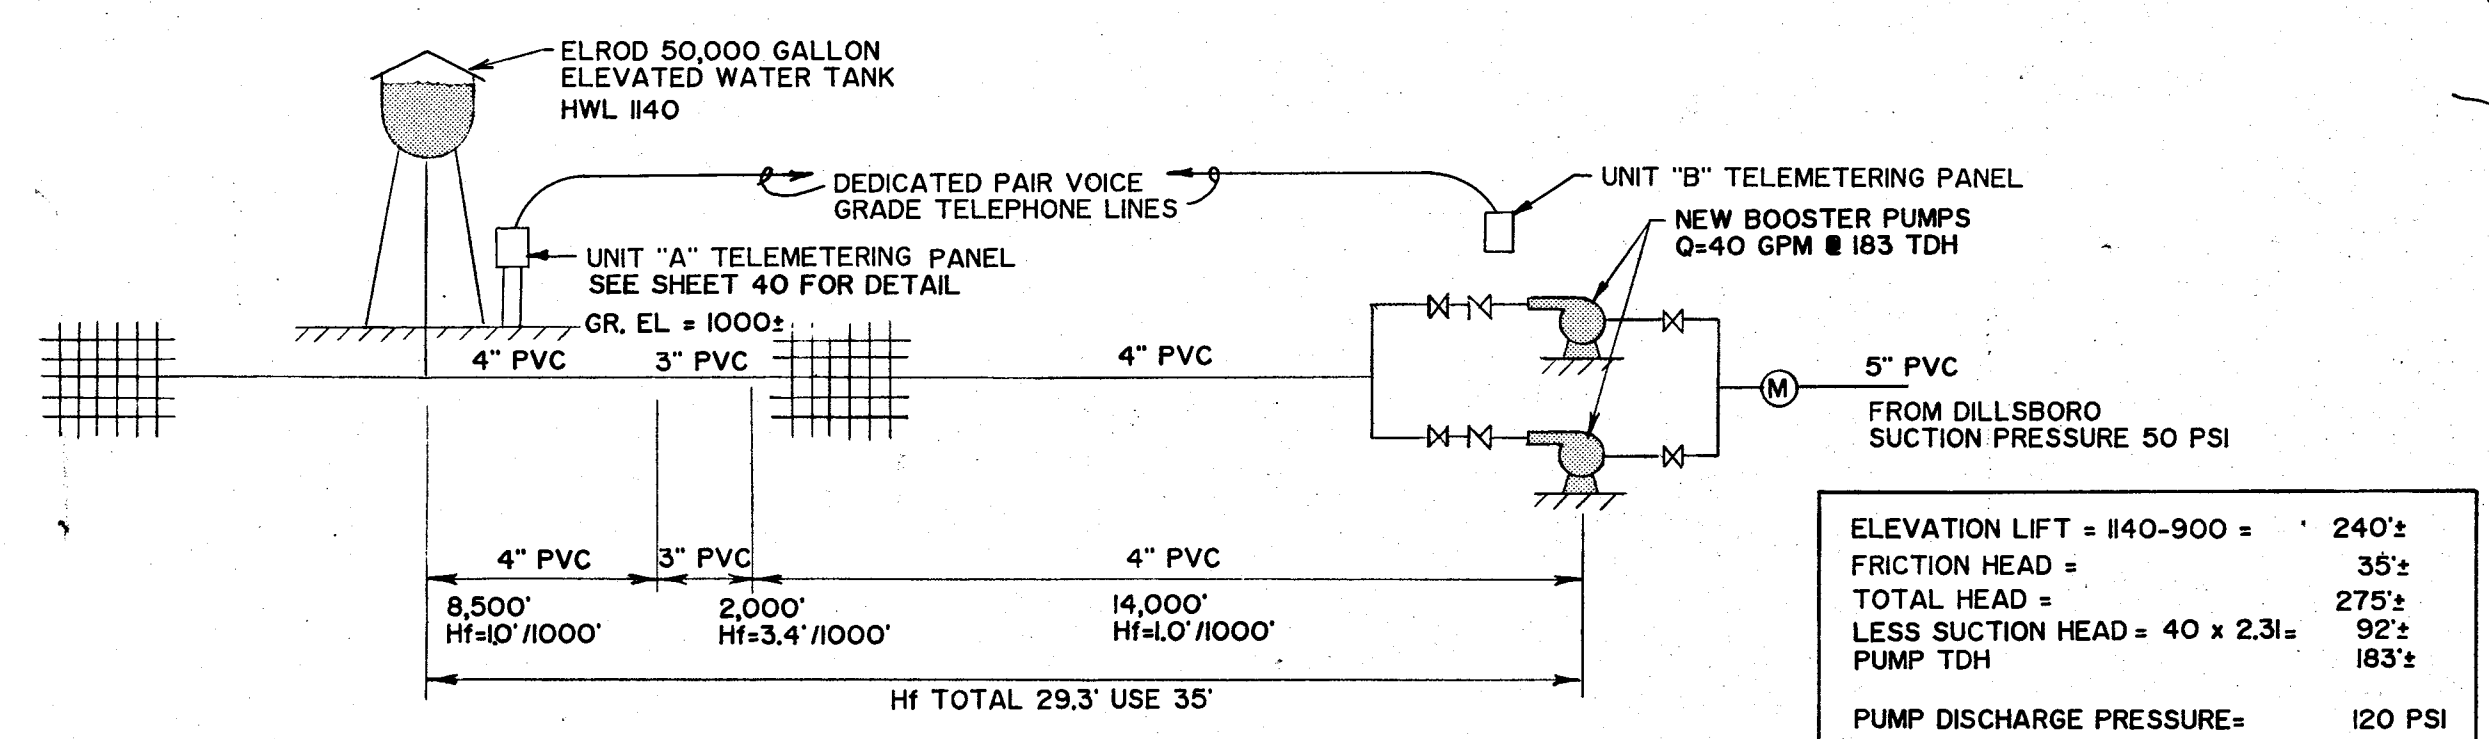


2 FLOW SCHEMATIC
41 NO SCALE

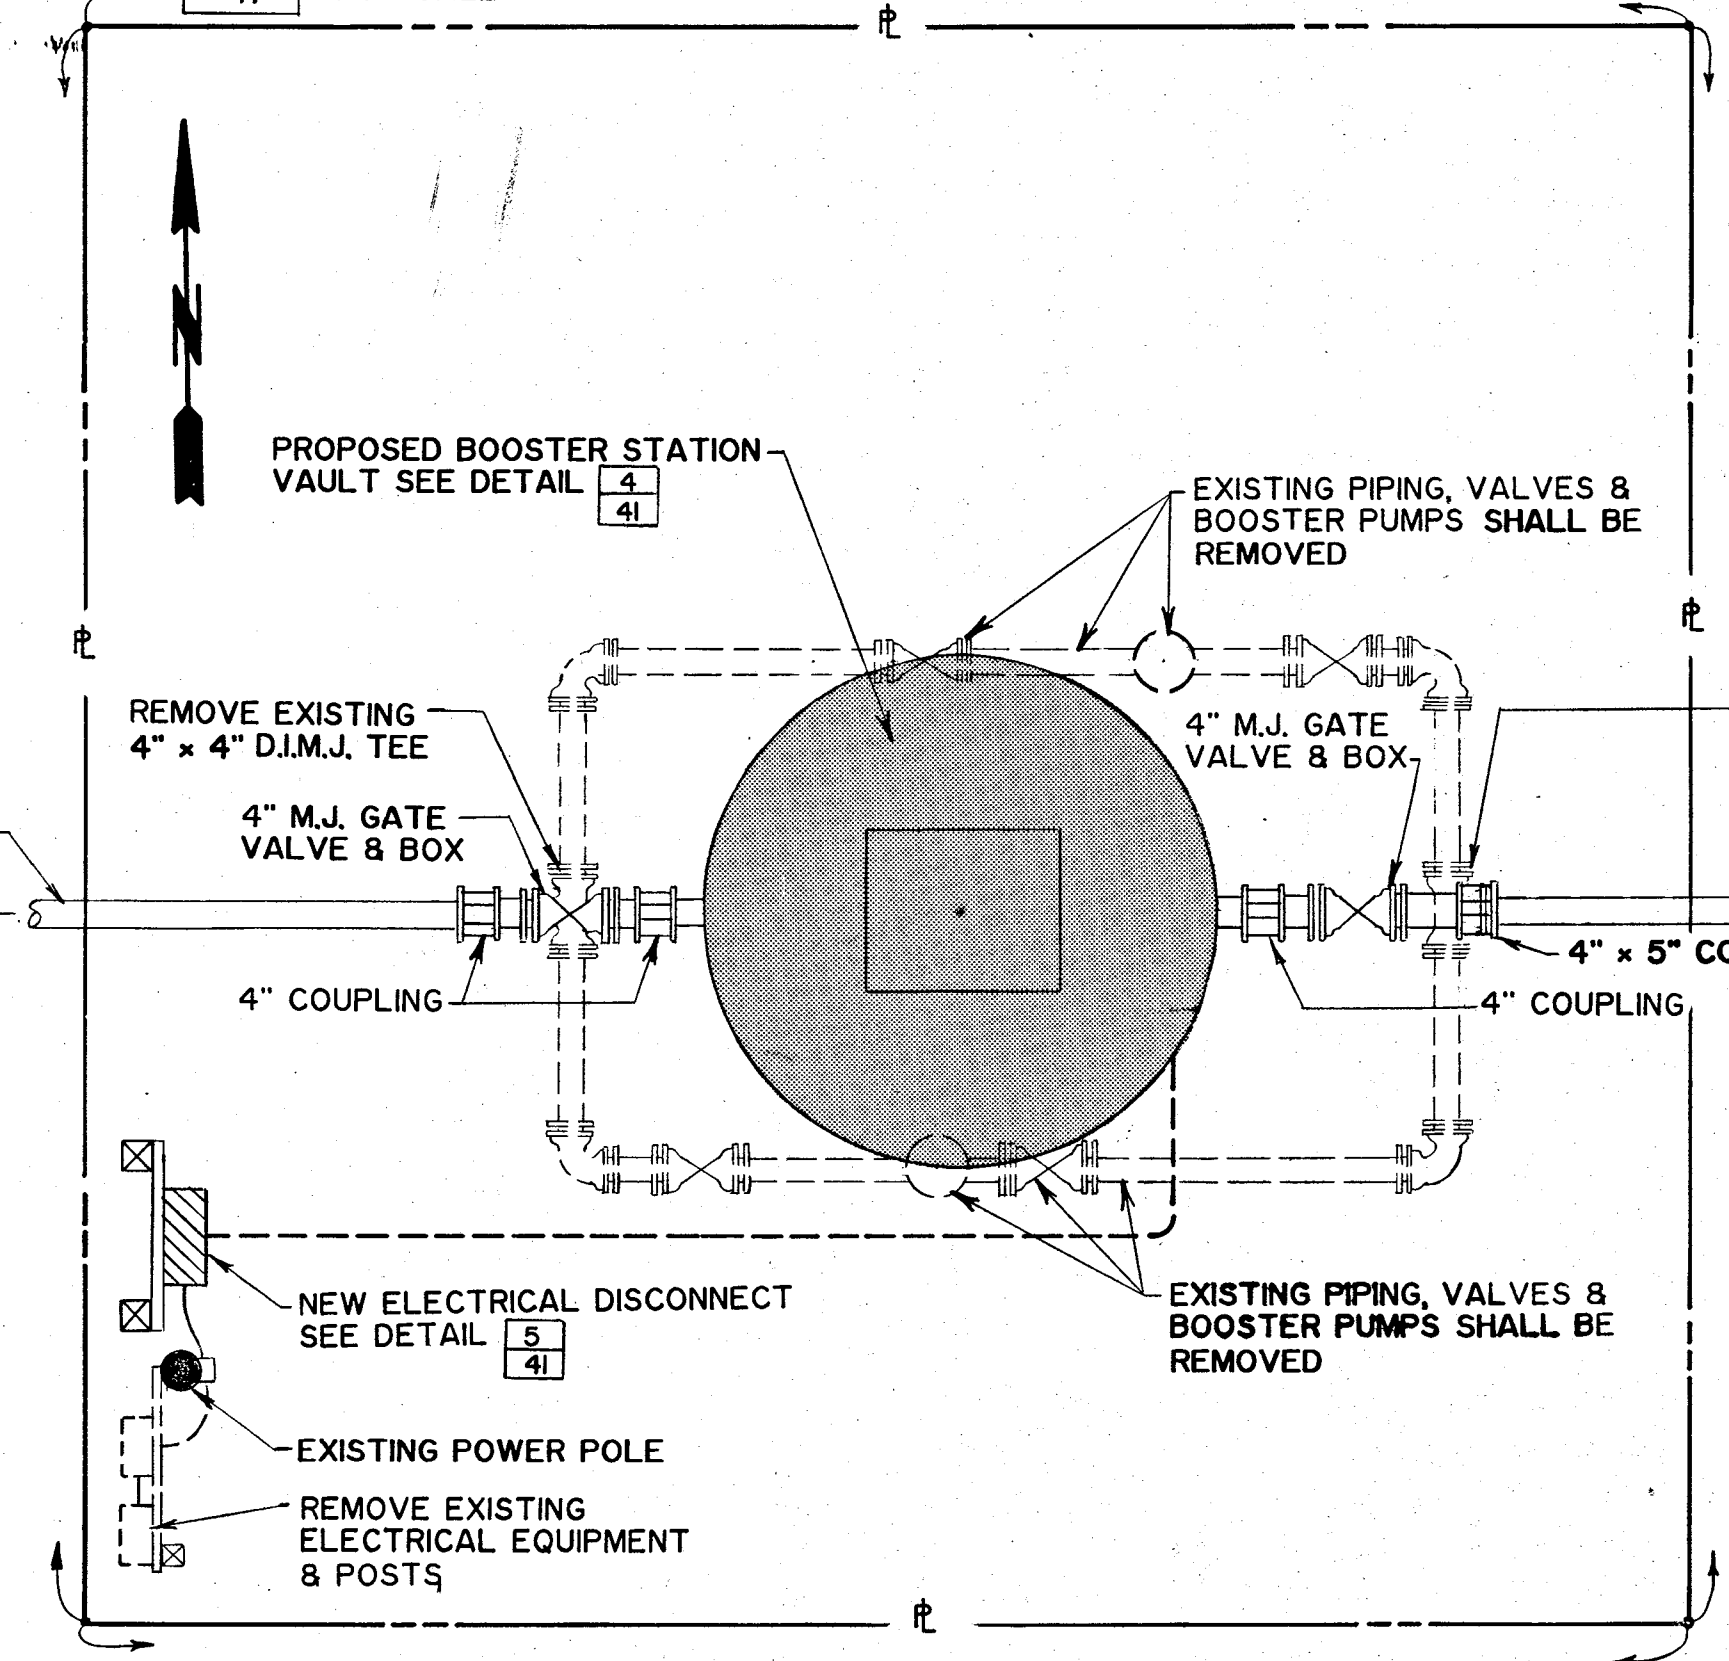


3 BOOSTER STATION SITE PLAN
41 SCALE 1" = 30'

(PROPOSAL ITEM No. 6)

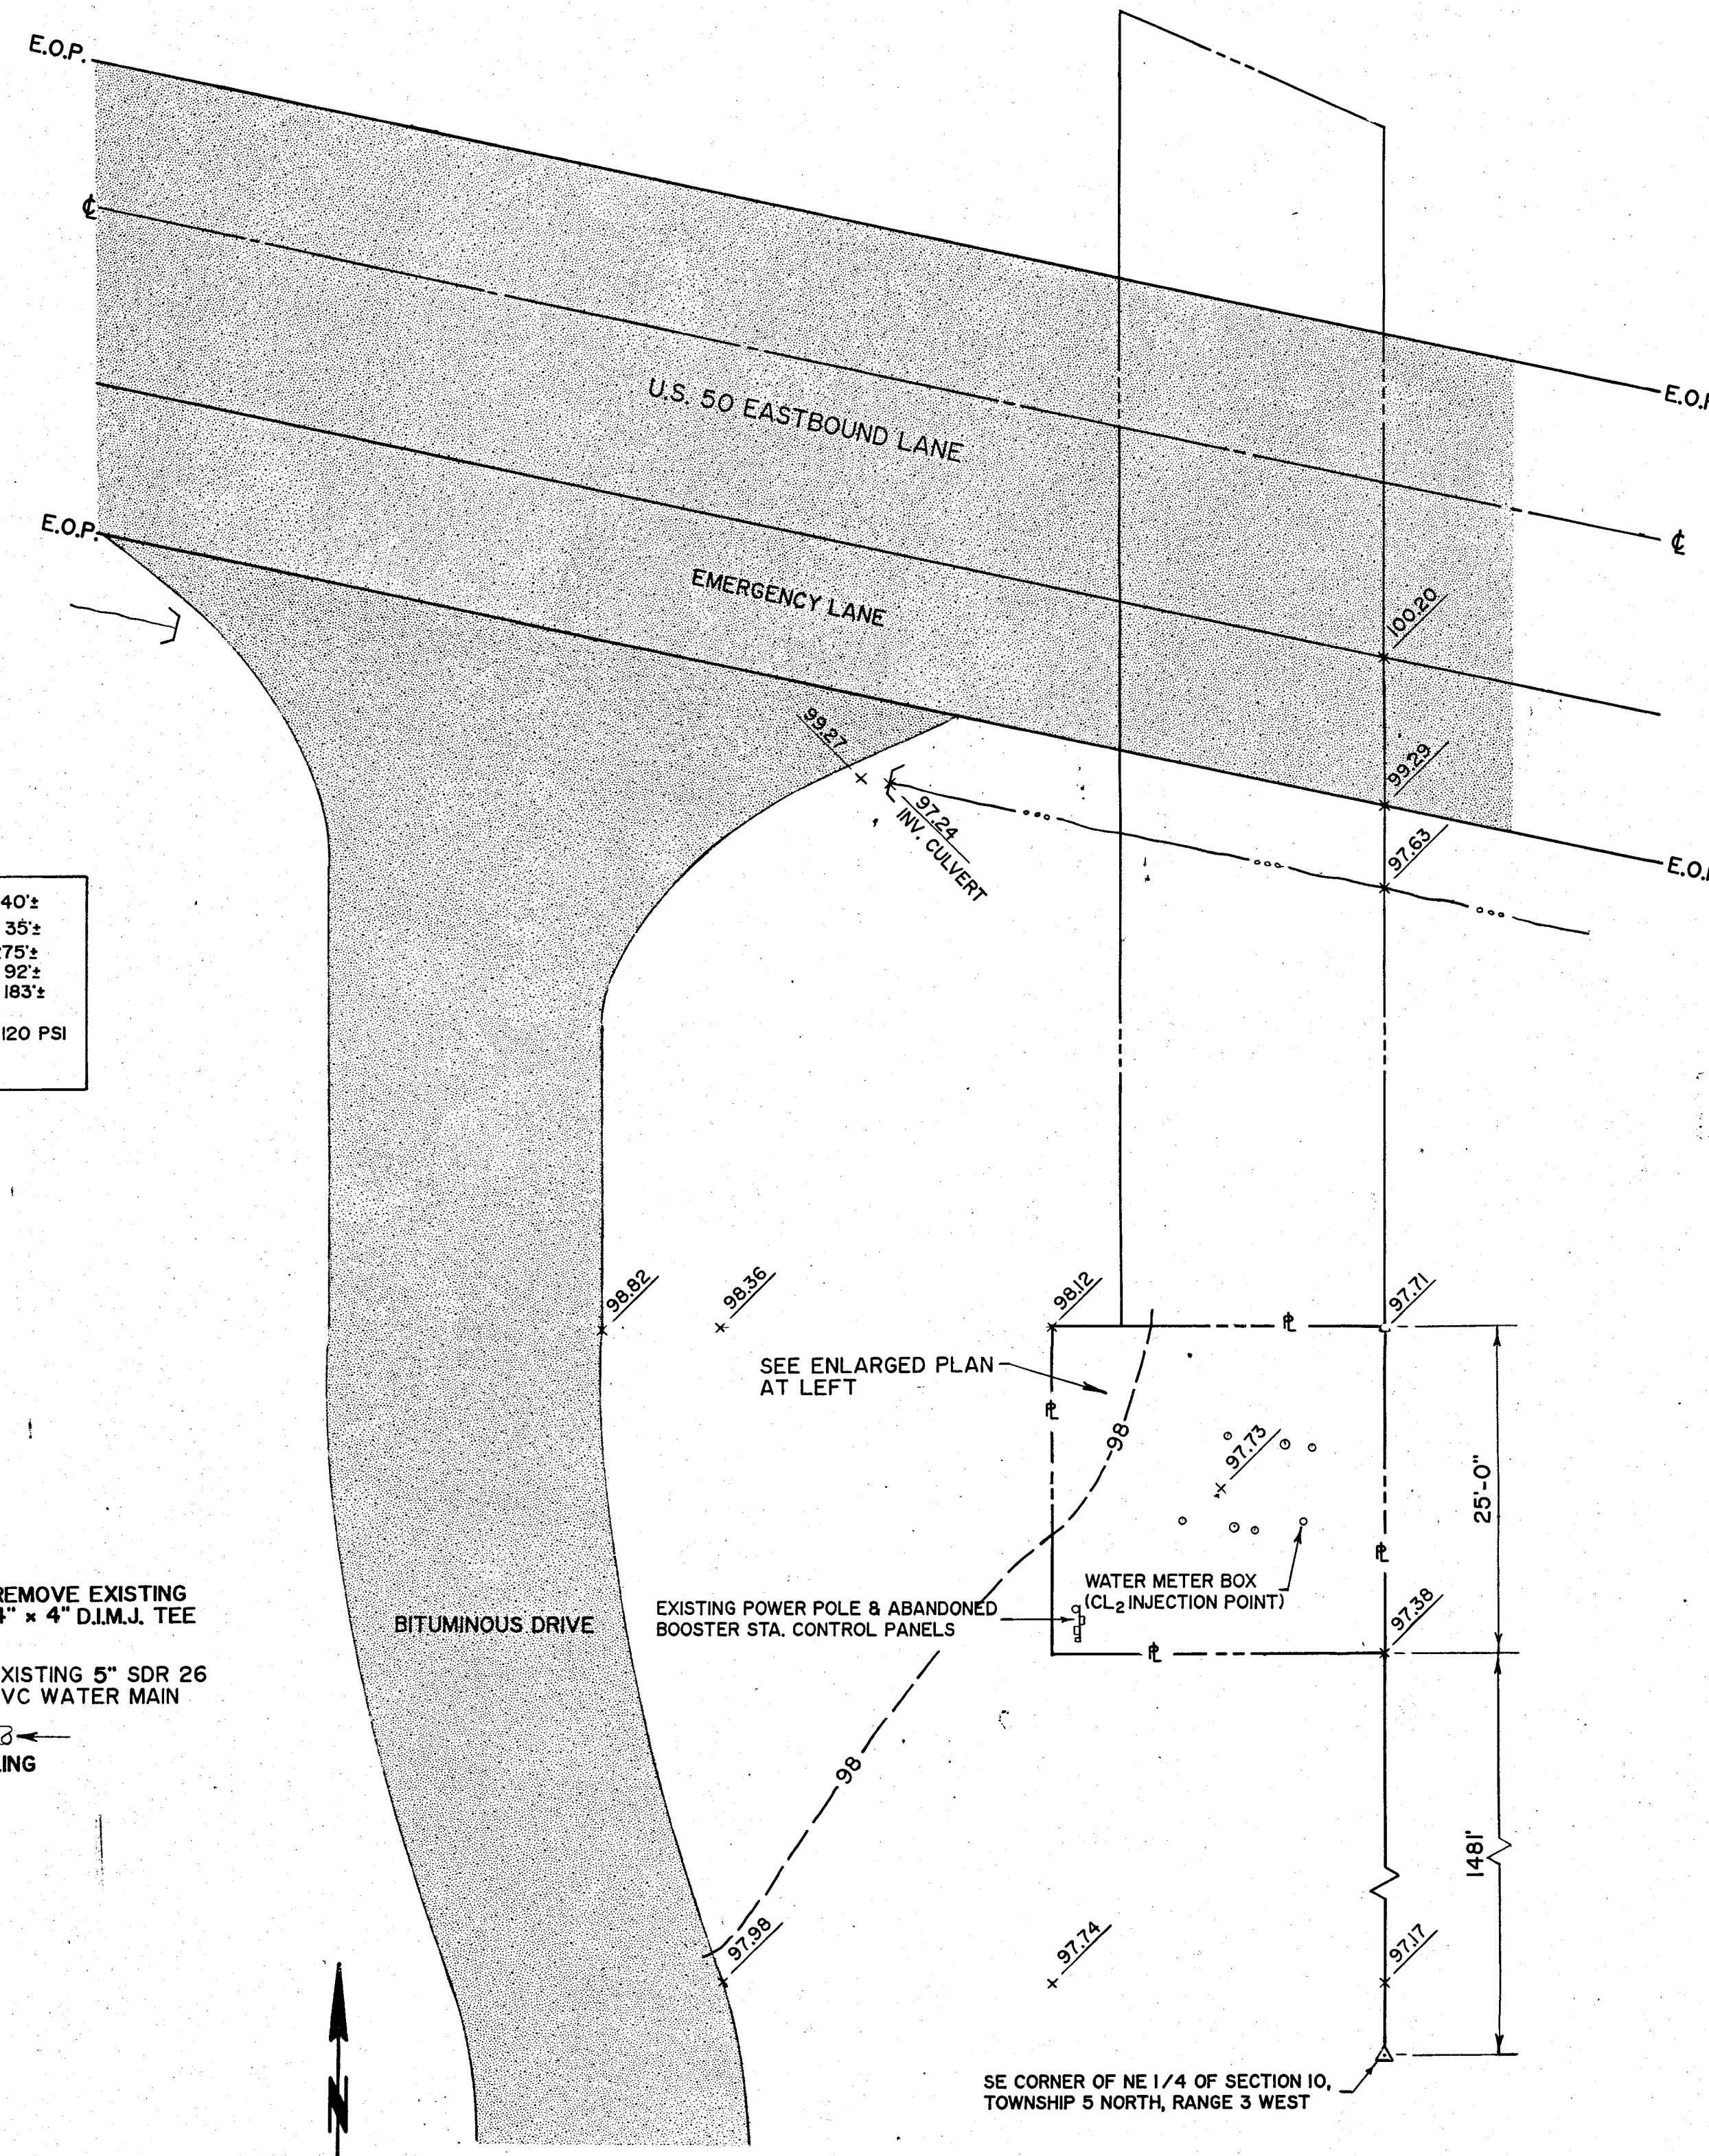

1 SITE PLAN
41 SCALE 1" = 10'

BOOSTER STATION PUMP SCHEDULE									
UNIT	MOTOR H.P.	STARTER TYPE	STARTER SIZE	VOLTAGE & PHASE	CIRCUIT BREAKER TRIP RATING	AUXILIARY CONTACTS	PUMP GPM	PUMP TDH	SIMILAR TO MODEL NO.
BOOSTER PUMP PUMP NO. 1	5	MAGNETIC NON-REVERSING ACROSS THE LINE	1	240V, 3 PH.	40 AMPS	1-N.C.	40	183'	PACO NO. 1270-S
BOOSTER PUMP PUMP NO. 2	5	MAGNETIC NON-REVERSING ACROSS THE LINE	1	240V, 3 PH.	40 AMPS	1-N.C.	40	183'	PACO NO. 1270-S

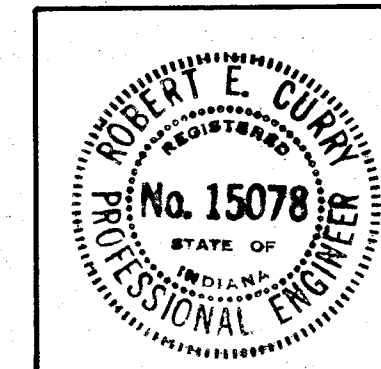

Robert E. Curry & Associates, Inc.
Engineers and Architects
3346 Avon Road, Plainfield, IN 46168
(317)-272-3050

ELROD WATER COMPANY, INC.
DIV. "D" DISTRIBUTION
SYSTEM EXTENSIONS

BOOSTER STATION SITE PLAN & DETAILS

DATE: 10/1/91
APPROVED BY: Robert E. Curry
DRAWING NUMBER: 41 OF 43