




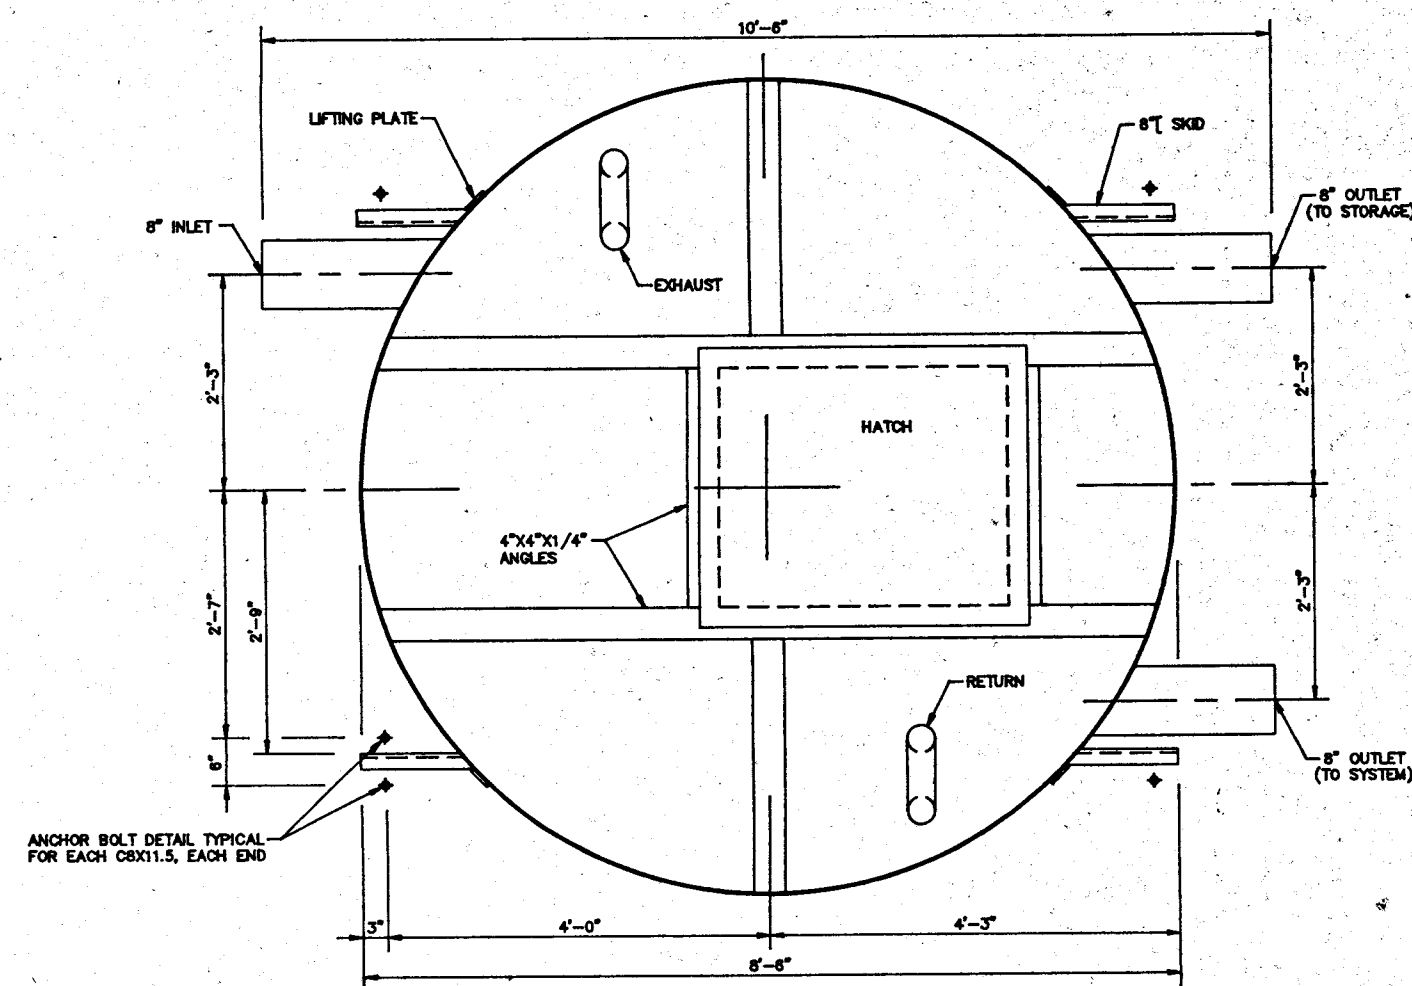

EXTERIOR PLAN

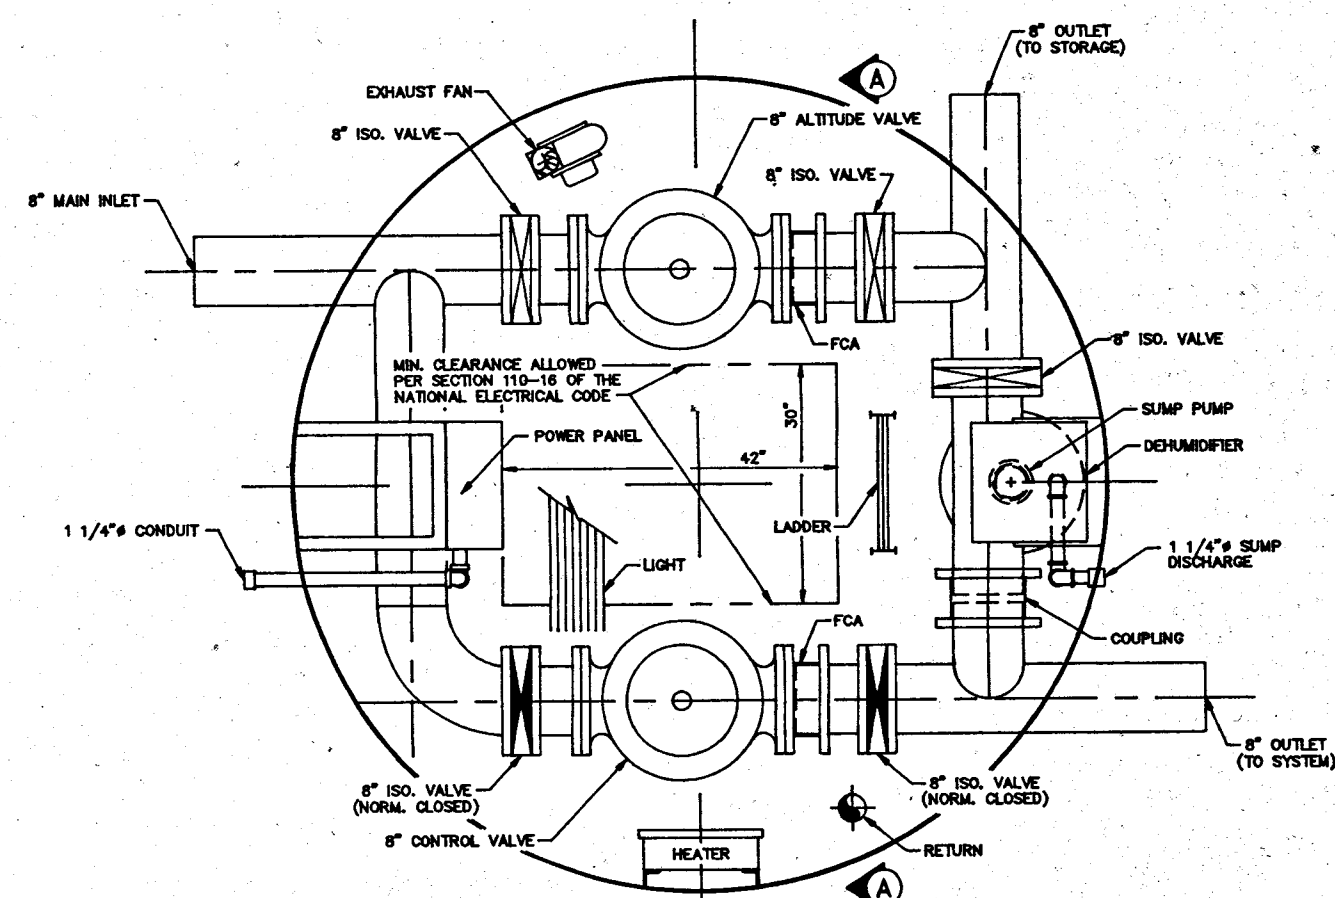


INTERIOR PLAN

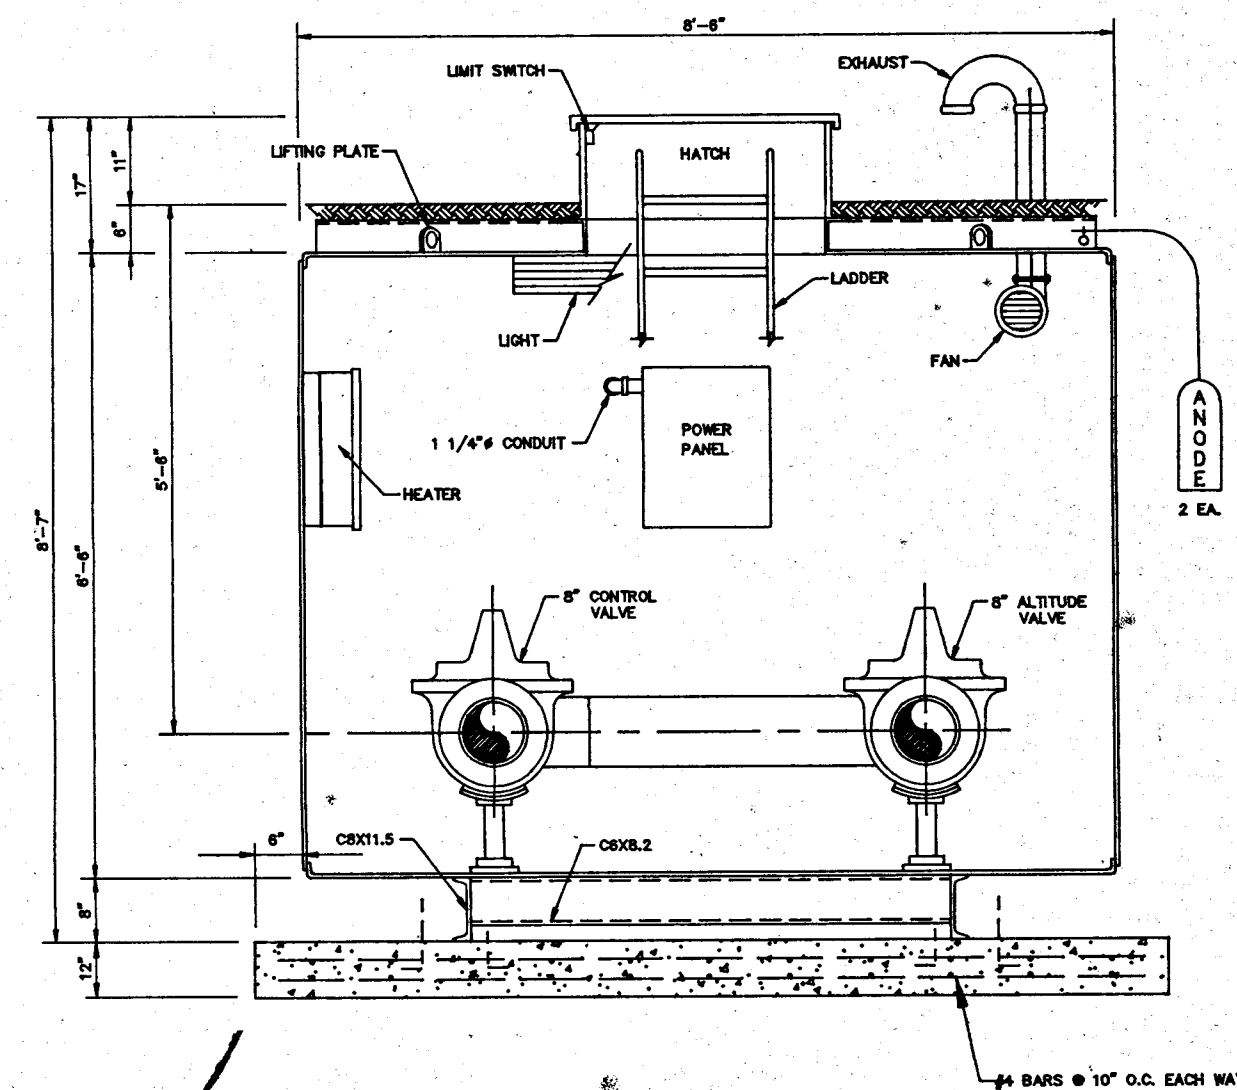


SECTION A-A

ALTITUDE VALVE DETAILS

SCALE: 1/2" = 1'-0"

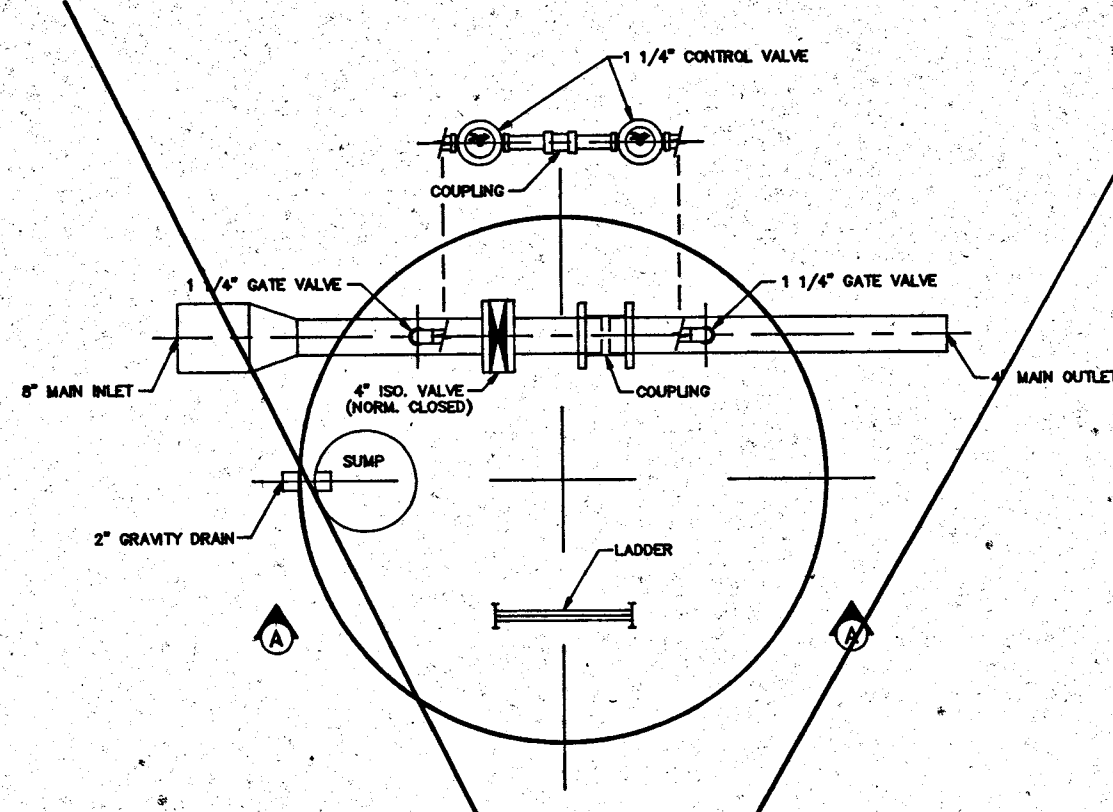


INTERIOR PLAN

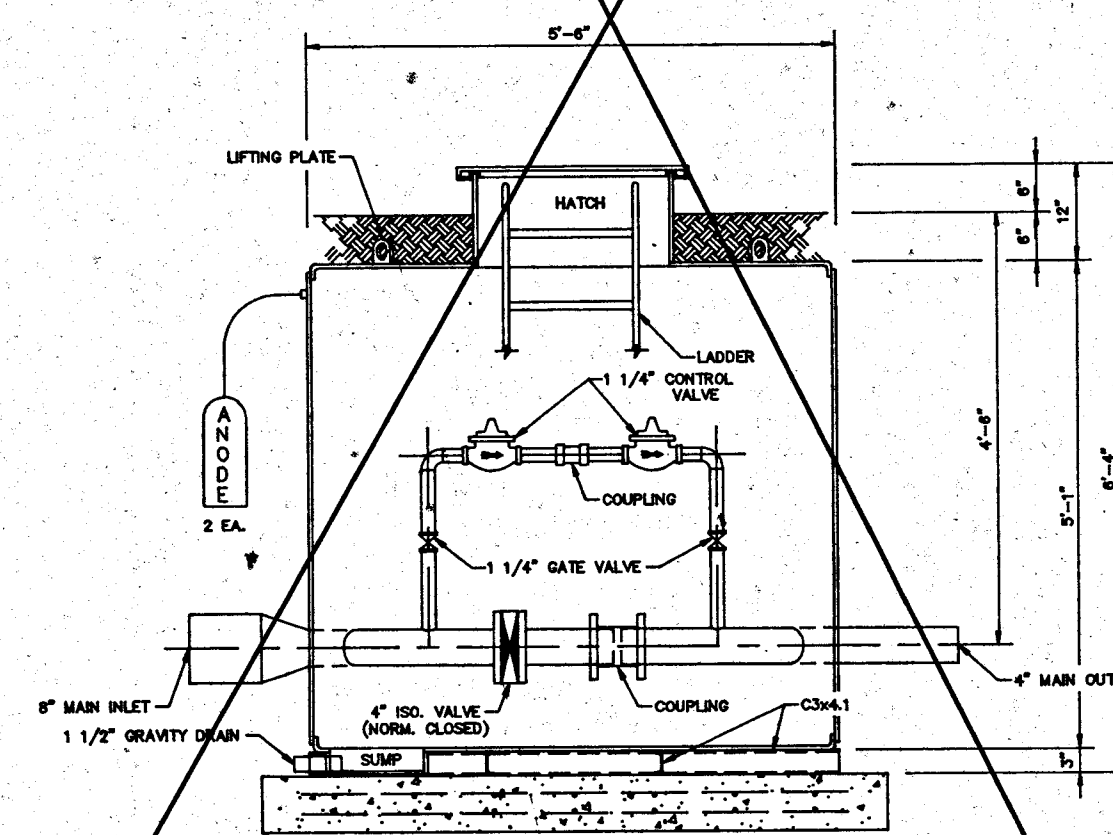

SECTION A-A


PRESSURE REDUCING VALVE DETAILS

SCALE: 1/2" = 1'-0"

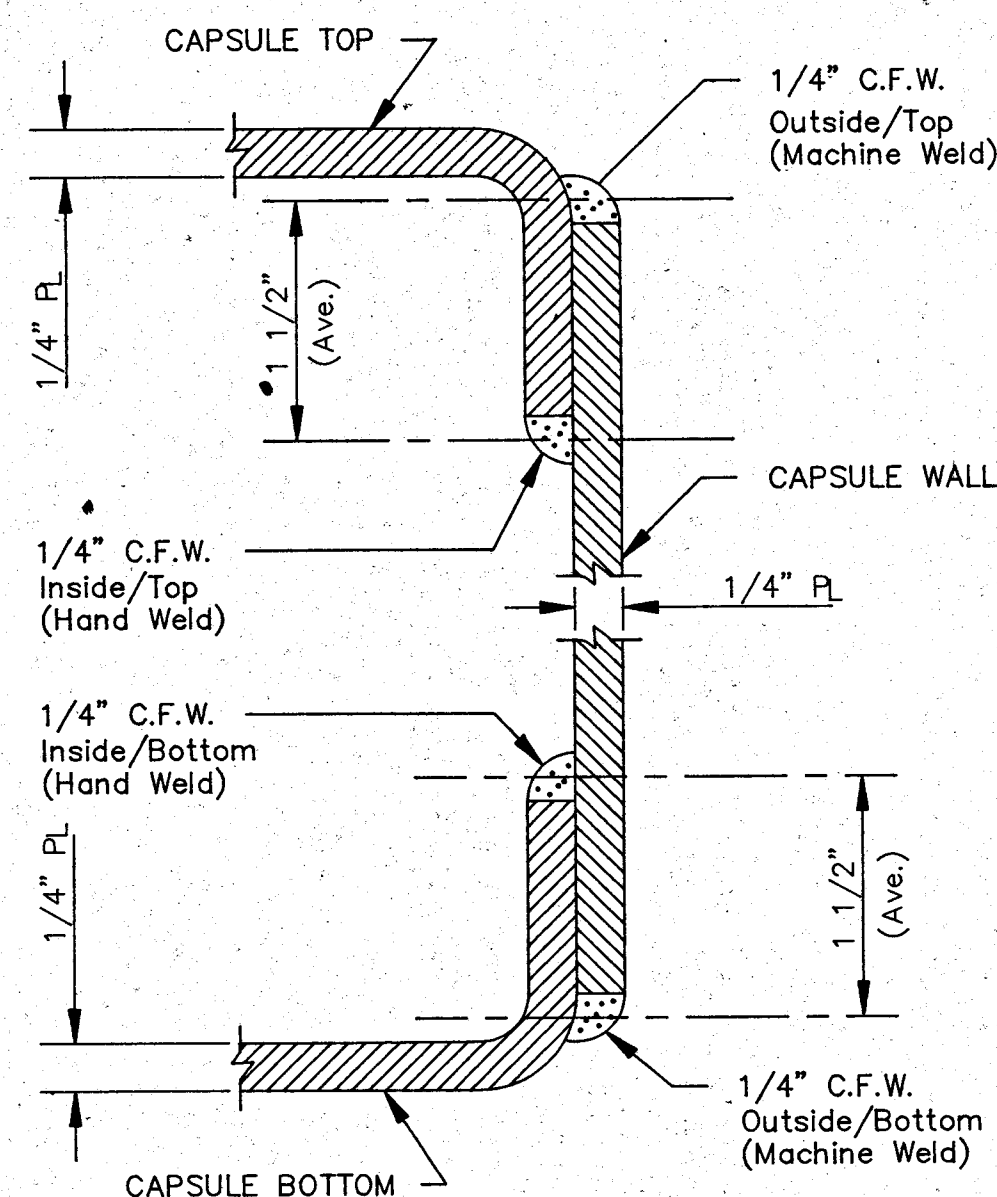

LAP JOINT CONNECTION OF CAPSULE WALL PLATE WITH FLANGE TOP AND BOTTOM

NOTE:
WITHOUT THE ADDITION OF AUTOMATIC FORCED AIR VENTILATION, THIS STATION MAY BE CONSIDERED A PERMIT-REQUIRED CONFINED SPACE AS DETAILED IN THE CONGRESSIONAL FEDERAL REGISTER 1910.146 EFFECTIVE APRIL 15, 1993.

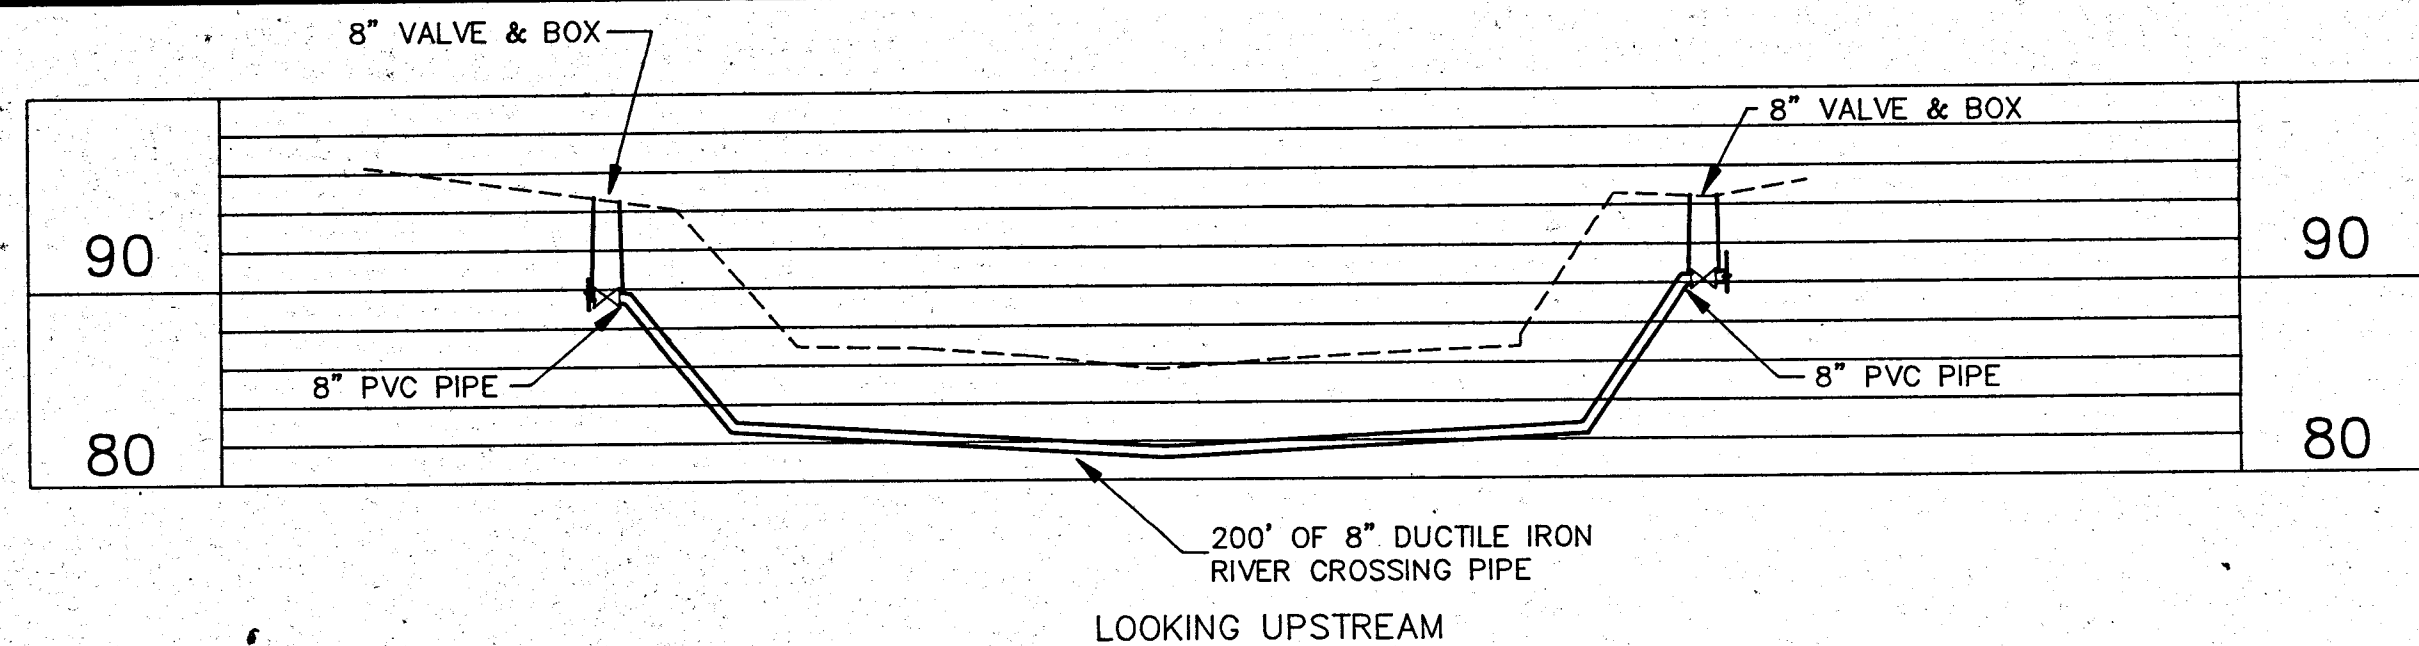


WHITEWATER RIVER CROSSING DETAIL

SCALE: 1" = 40' HORIZ.
1" = 10' VERT.


SEE SHEET A-30

NOTE: RIVER CROSSING PIPE AT WHITEWATER SHALL BE D.I. BALL & SOCKET PIPE

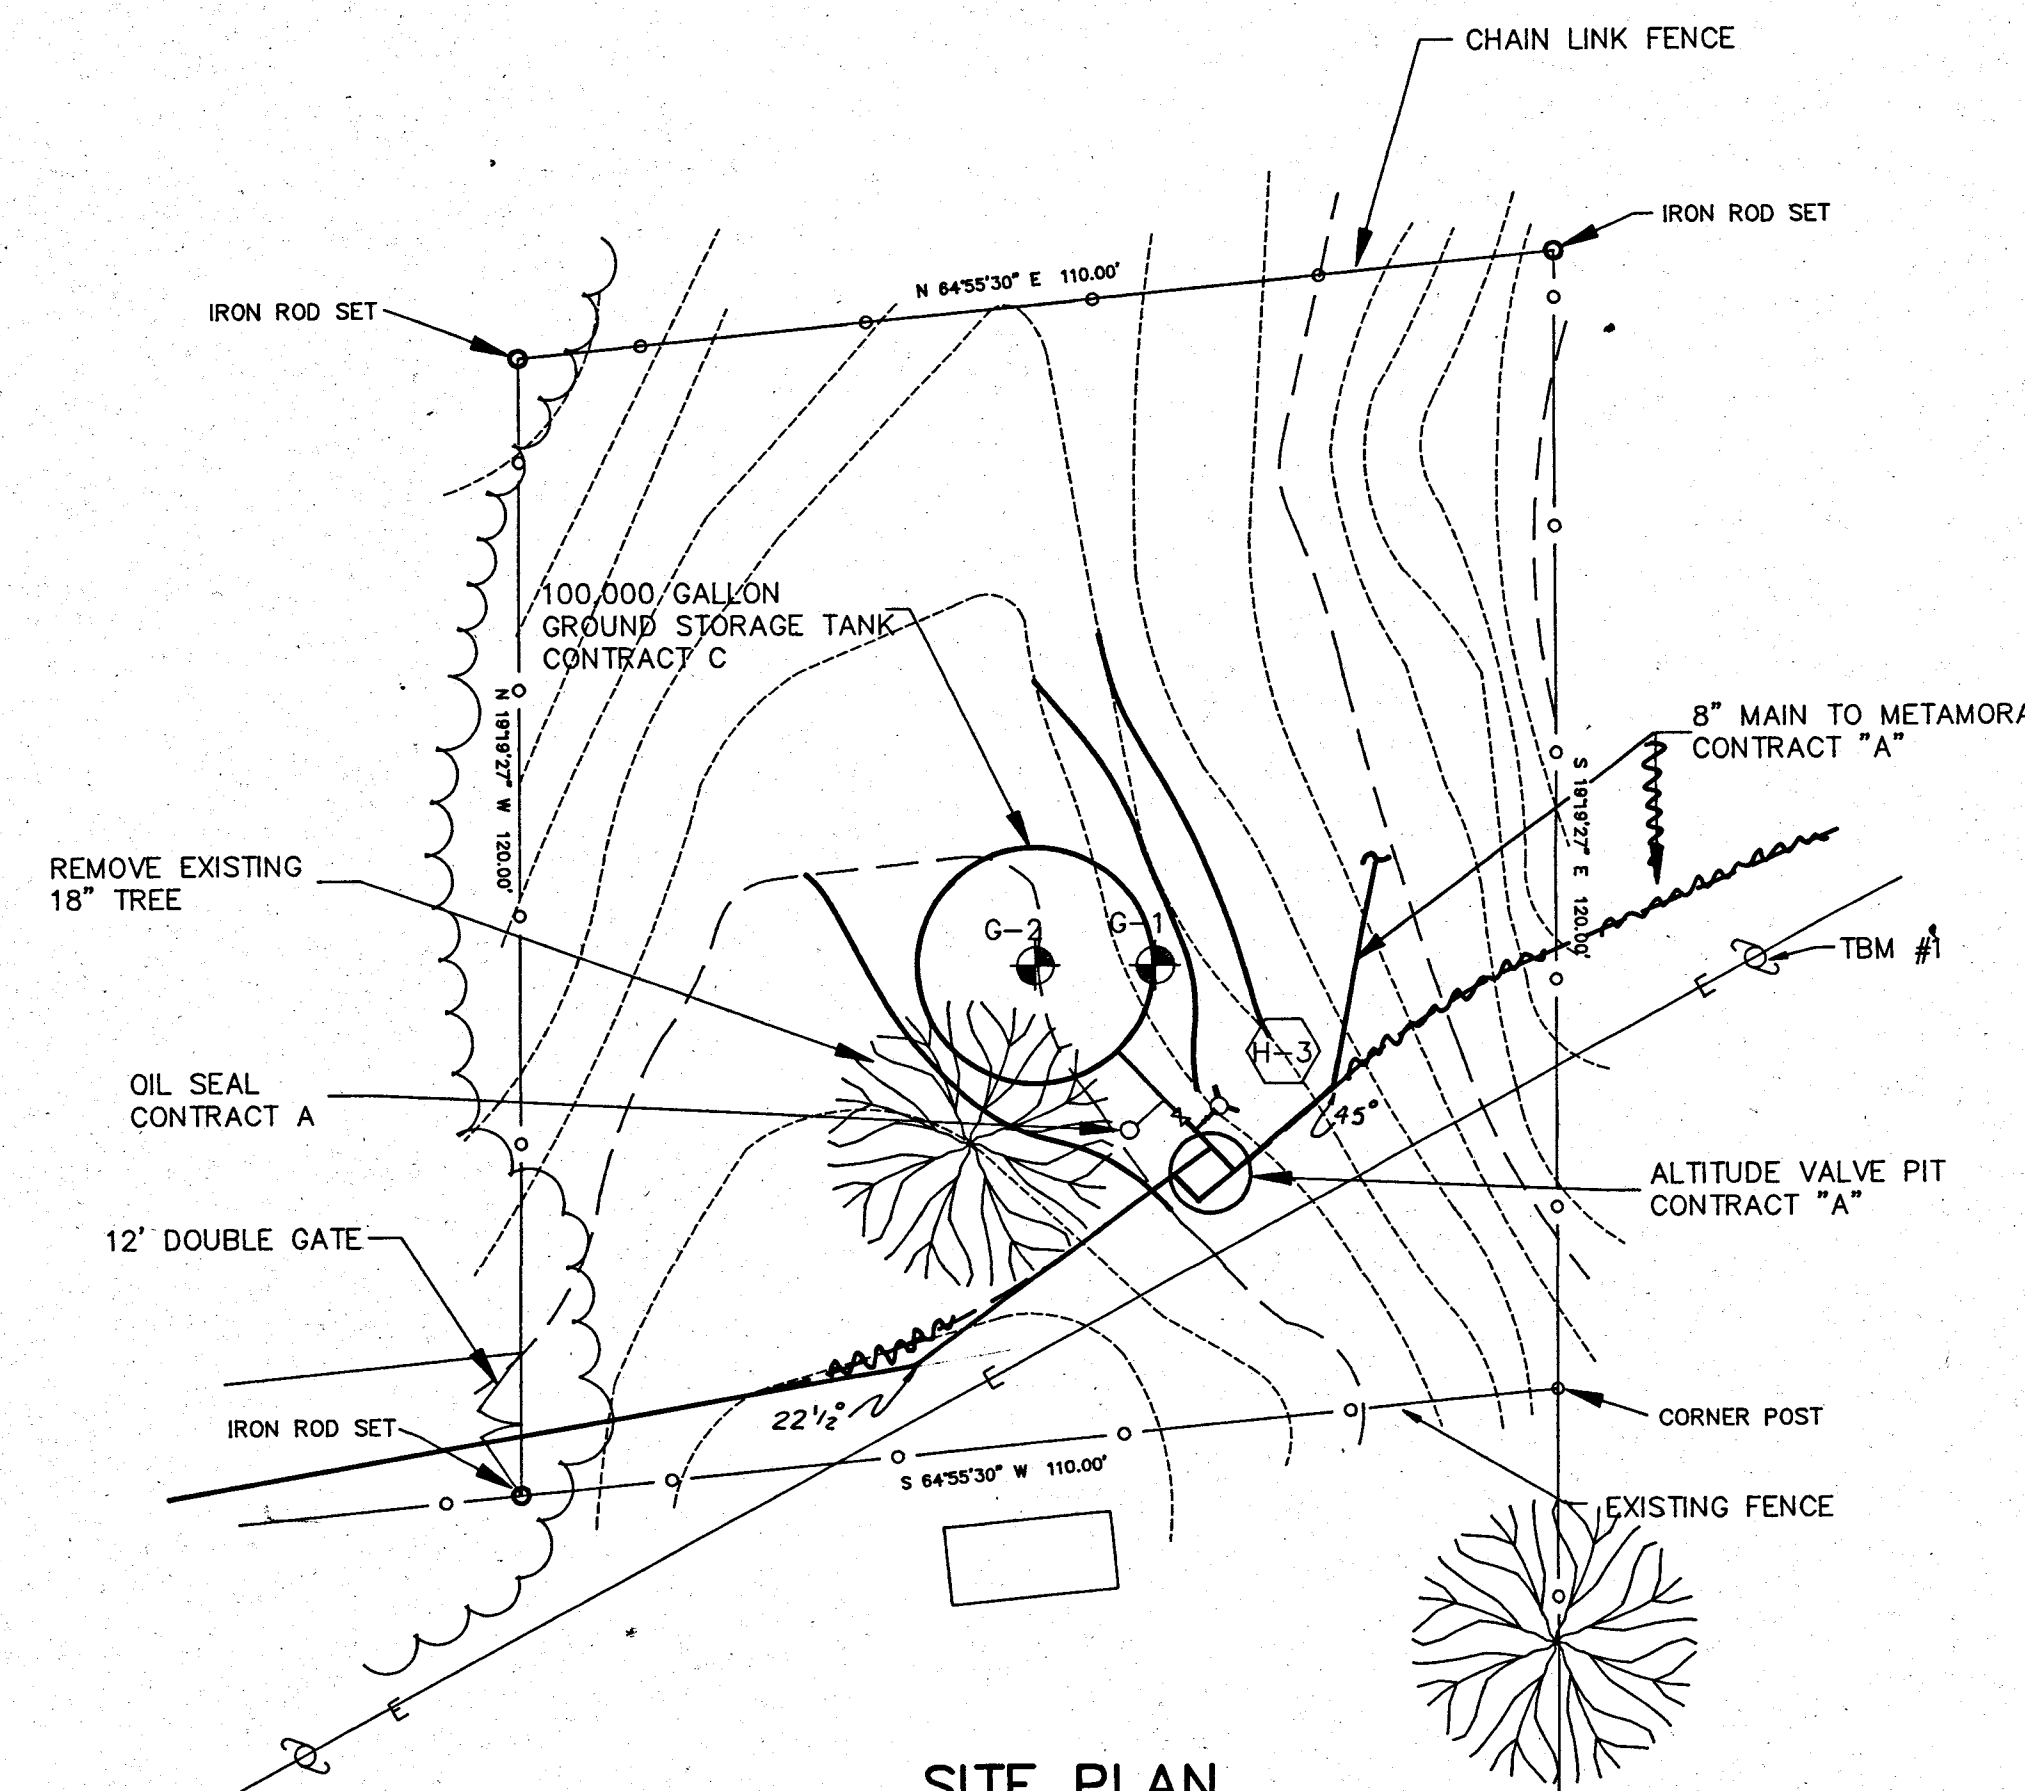

SITE PLAN

SCALE: 1"=20'

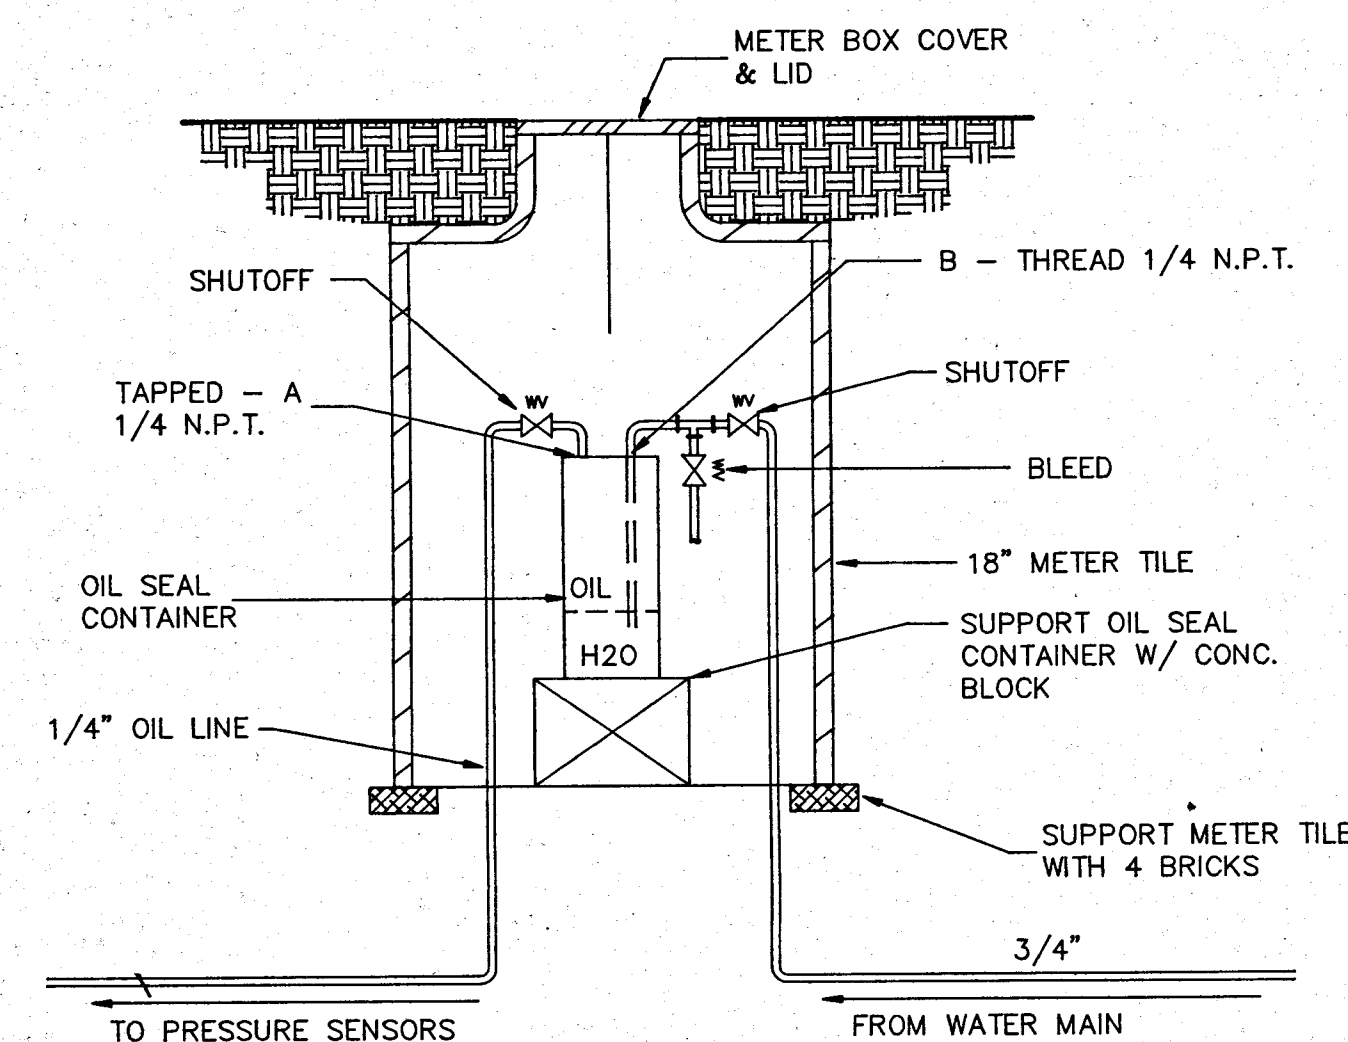

OIL SEAL DETAIL

SCALE: NONE

NOTES:

- POUR 1/2 PINT OF WATER IN OIL SEAL AT "A". FILL OIL SEAL TO TOP WITH MINERAL OIL. (U.S.P.)
- CONNECT PRESSURE LINES TO OIL SEAL AT "A" & "B". CONNECTIONS MUST BE AIR TIGHT.
- COORDINATE LOCATION OF OIL SEAL WITH CONTRACT "A" CONTRACTOR.

RECORD DRAWINGS
These drawings have been prepared from information by others. Engineer will not be responsible for errors and omissions in the information or records from which these drawings are produced.

CONTRACT "A"
WATER MAINS
ALTITUDE VALVE/PRV VAULT DETAILS
ELROD WATER COMPANY, INC.
DIVISION "E"
WATERWORKS SYSTEM IMPROVEMENTS

WESSLER and ASSOCIATES
CONSULTING ENGINEERS
6219 South East Street, Suite A
Indianapolis, Indiana 46227-2148

SCALE: AS SHOWN
DATE: OCT. 14, 1993
PROJECT NO.: 37391.04
DRAWN BY: M.A.W.
APPROVED BY: D.C.C.
PLOTTED: 3/21/94
CAD FILE: 373-444.DWG

NOT PUBLISHED
ALL RIGHTS RESERVED
EXCEPT FOR USES EXPRESSLY PERMITTED IN WRITING, INFORMATION SHOWN OR INCLUDED IN THIS DOCUMENT IS SOLELY THE PROPERTY OF M.D. WESSLER & ASSOCIATES, INC.

DONALD G. CURRY
REGISTERED
NO. 13334
STATE OF INDIANA
PROFESSIONAL ENGINEER

SHEET A 44
OF 45