



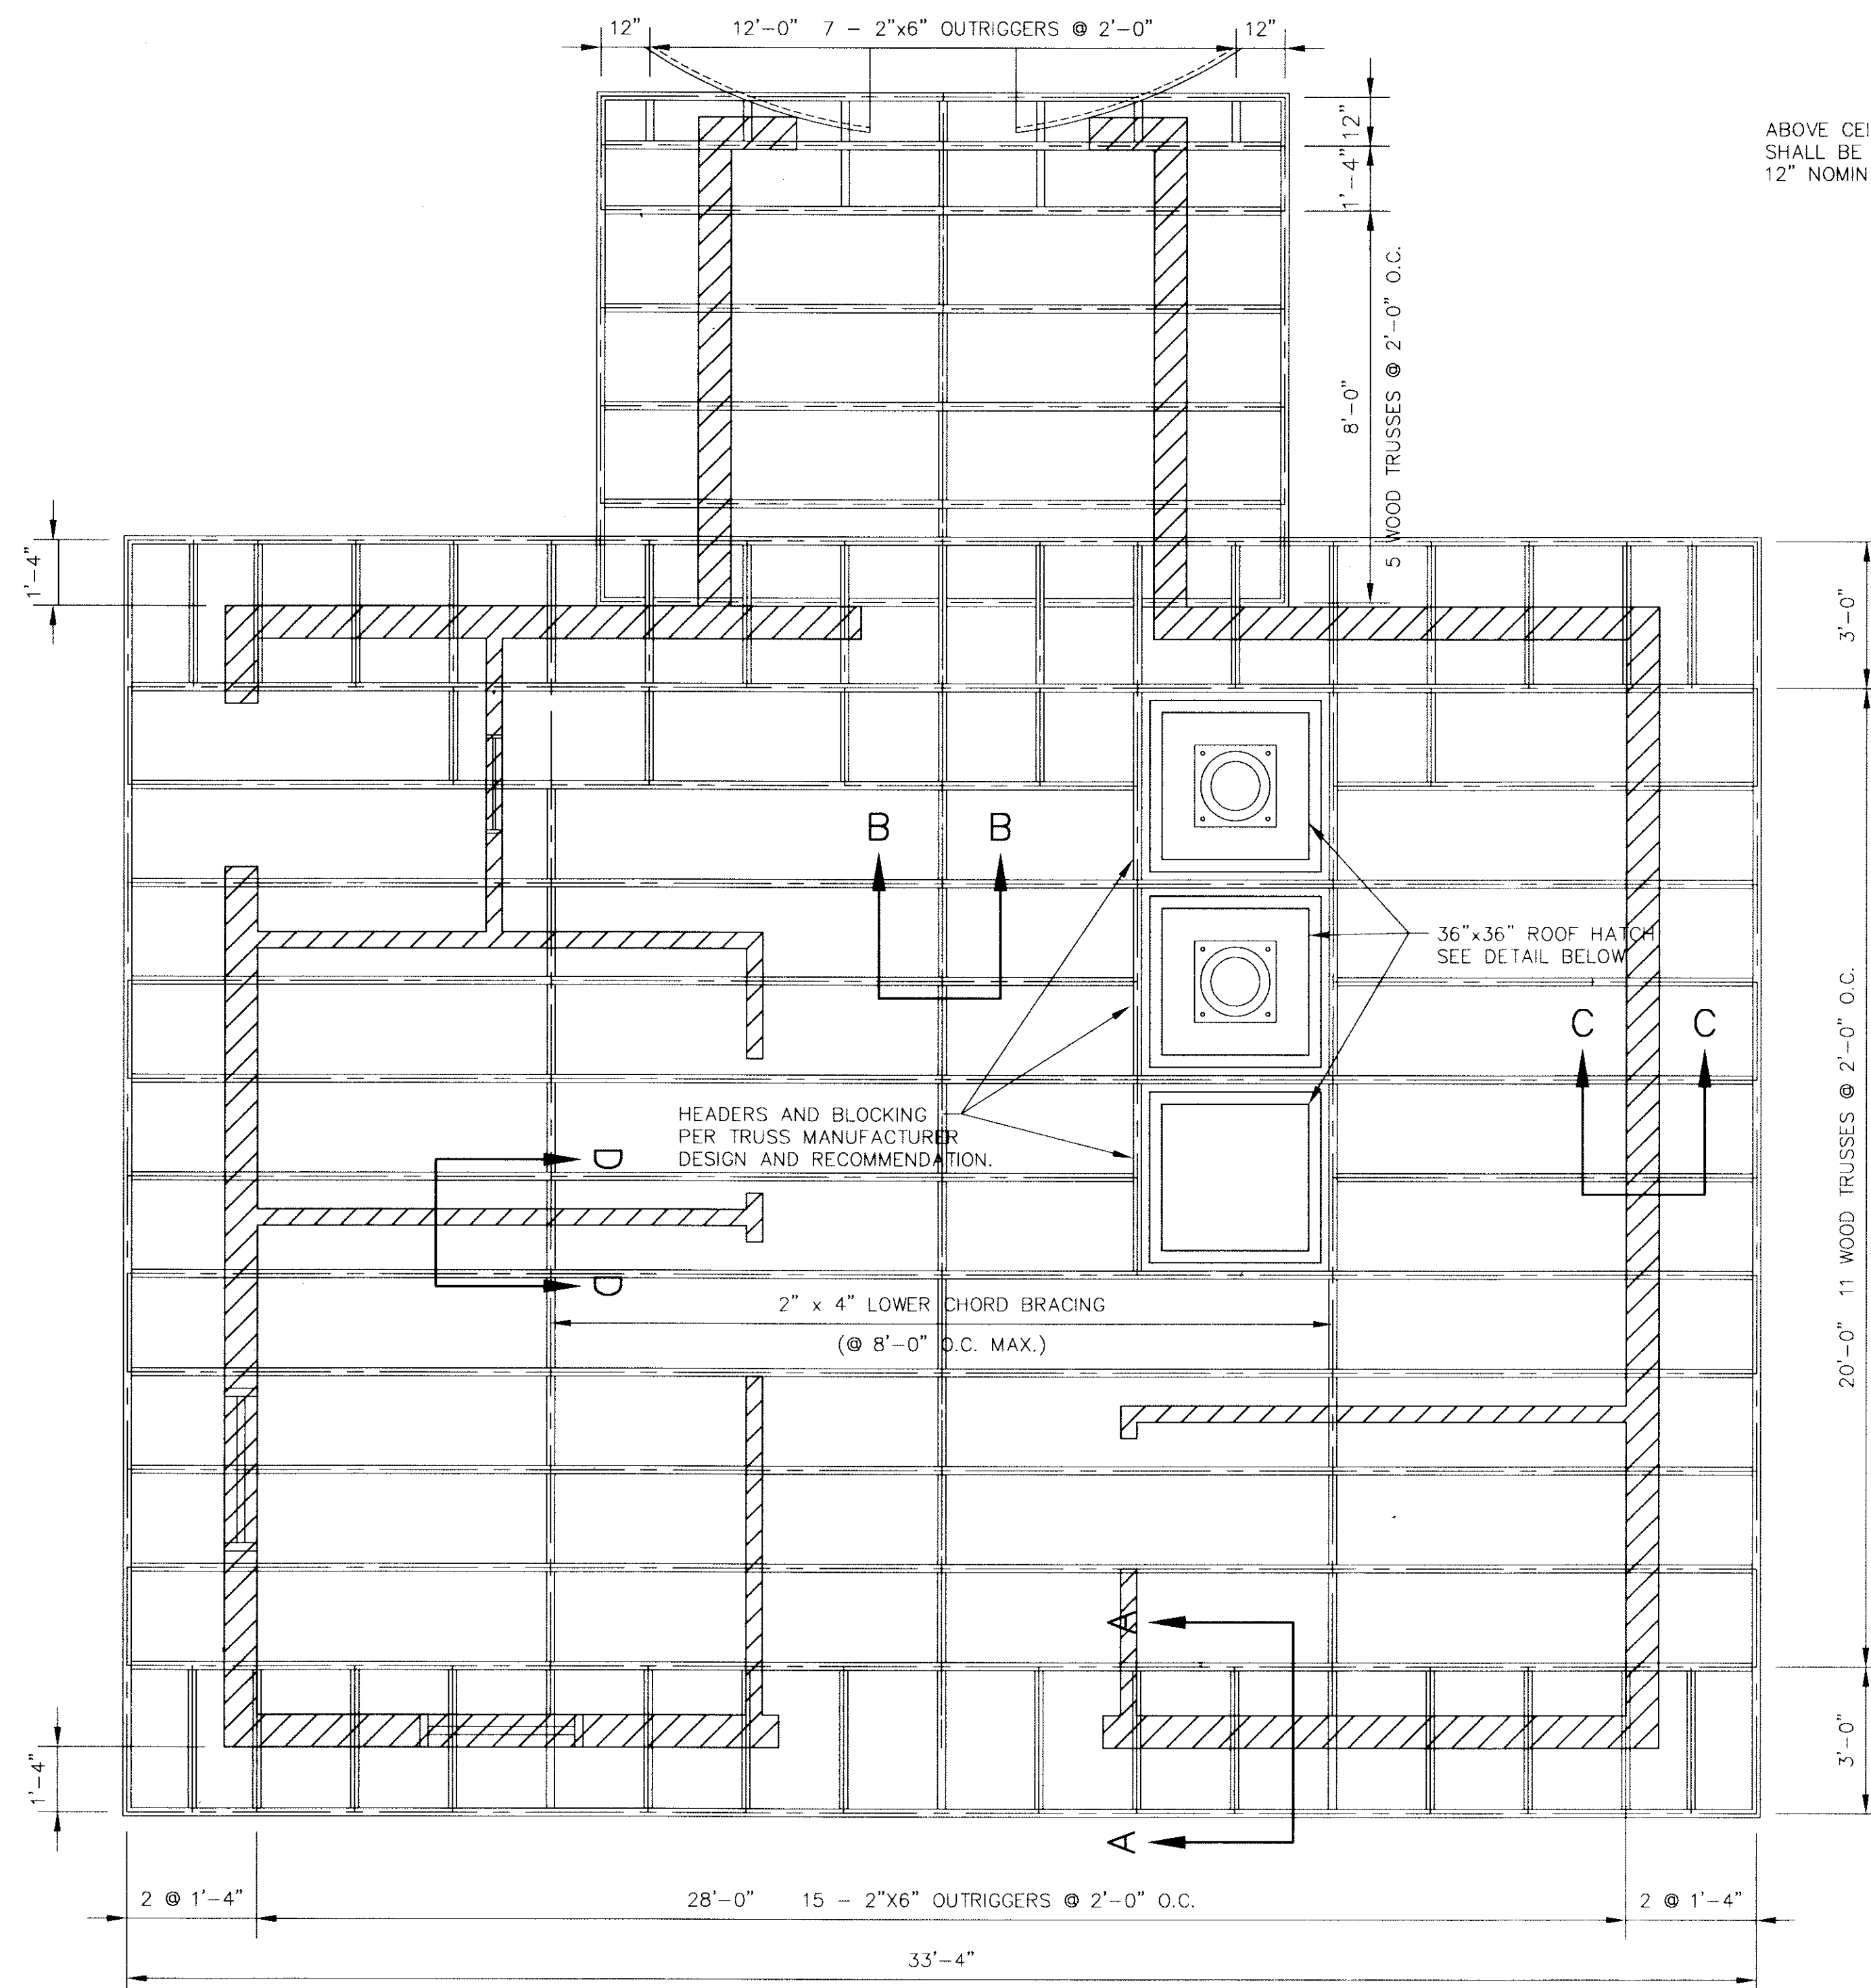


ROOF FRAMING PLAN
SCALE: 3/8" = 1'-0"

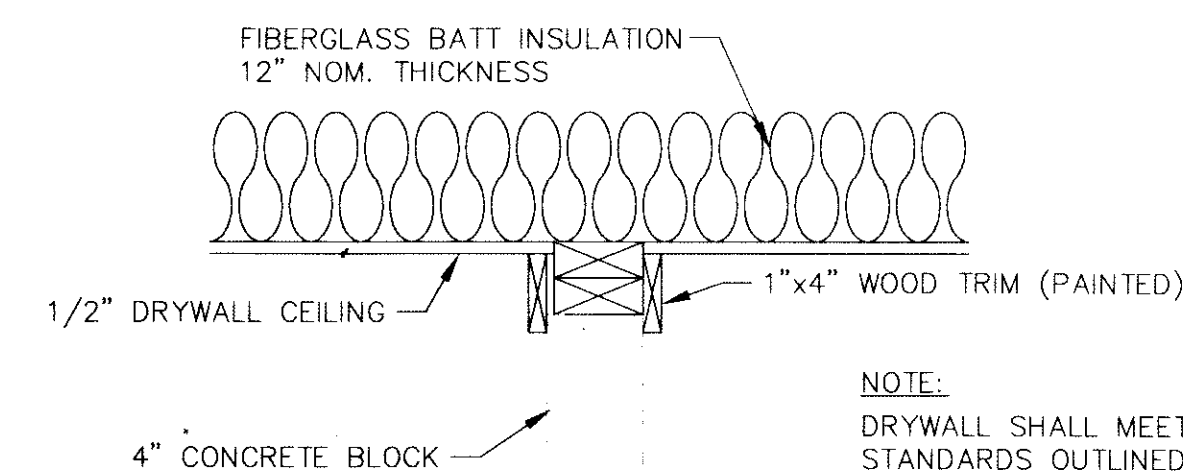


DETAIL SECTION "D-D"
SCALE: 1 1/2" = 1'-0"

NOTE:
DRYWALL SHALL MEET FIRE RESISTANCE STANDARDS OUTLINED IN ASTM E119 AND U.L. 293. WALLBOARD USED AS SURFACE MATERIAL SHALL HAVE A ONE HOUR FIRE RESISTANCE. STANDARD DRYWALL DIMENSION SHALL BE OF MAXIMUM PRACTICAL LENGTH TO PROVIDE A MINIMUM NUMBER OF END JOINTS.

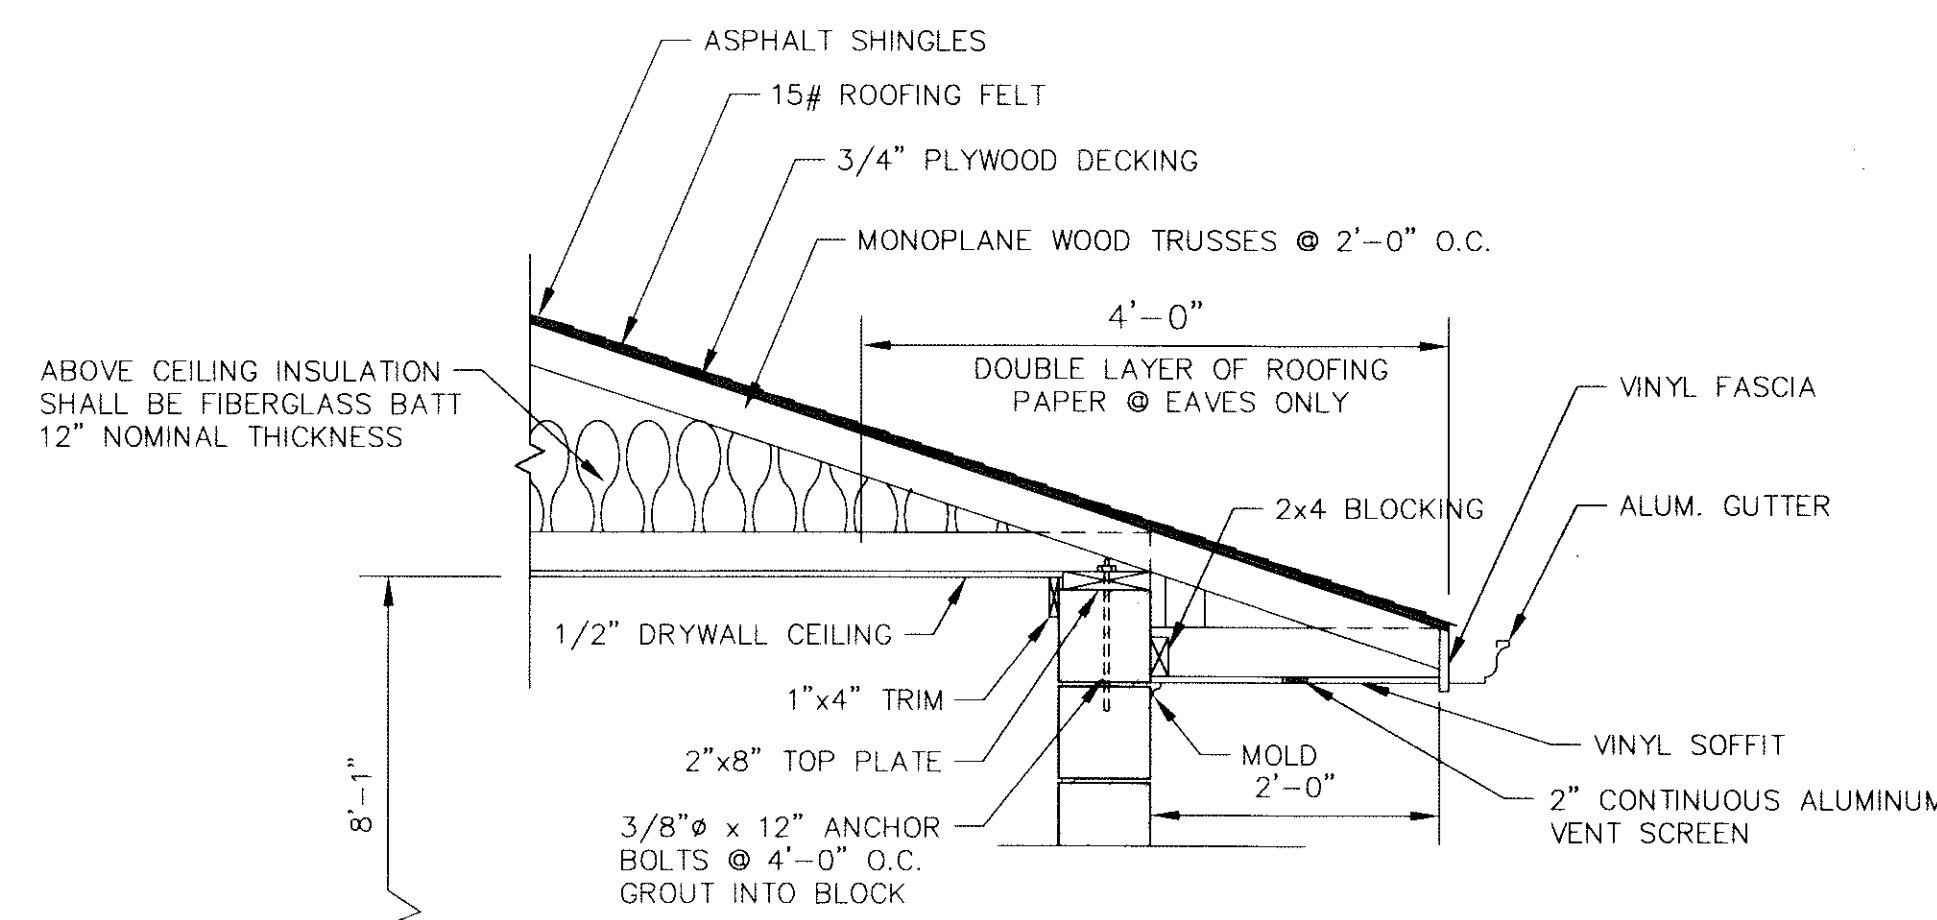


DETAIL SECTION "C-C"
SCALE: 3/4" = 1'-0"

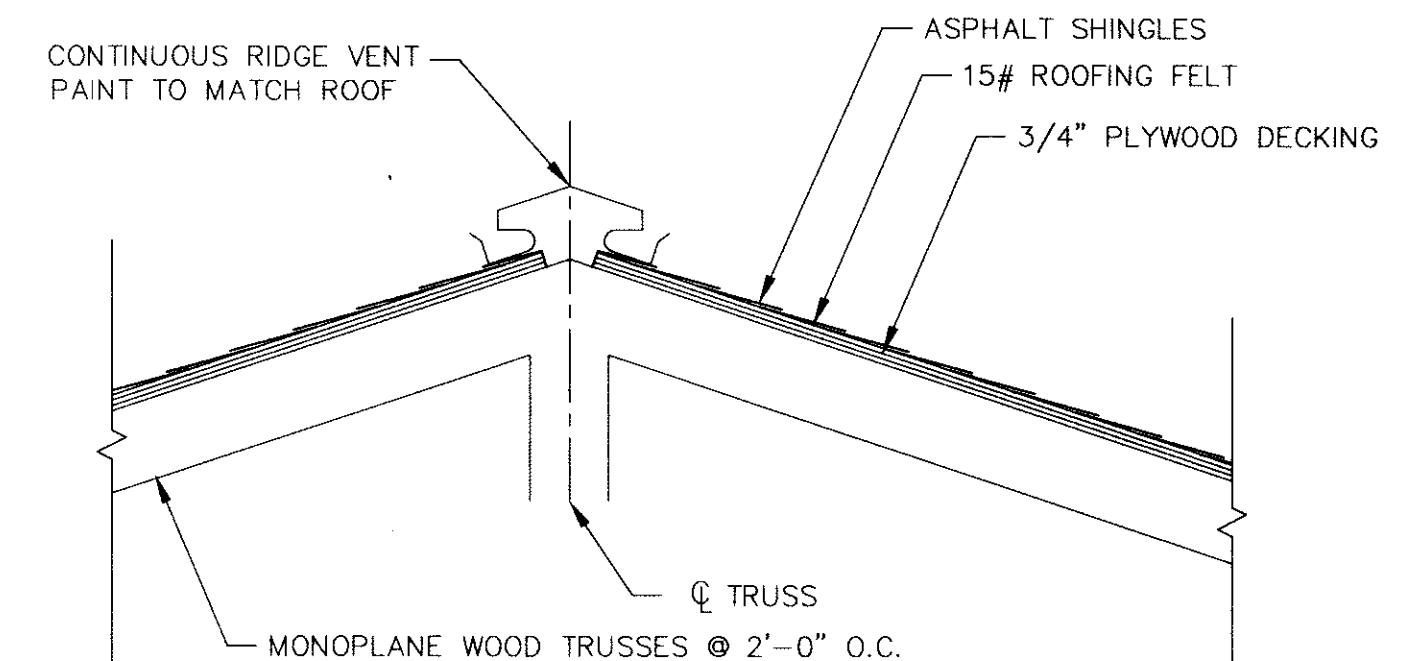

DETAIL SECTION "B-B"
SCALE: 1 1/2" = 1'-0"


NOTE:
CONTRACTOR TO SUBMIT TRUSS SHOP DRAWINGS CERTIFIED BY A REGISTERED PROFESSIONAL ENGINEER SHOWING ALL TRUSSES, HEADERS, BLOCKING, ETC... FOR A COMPLETE FRAMING INSTALLATION.

NOTE:
CONTRACTOR TO PROVIDE FLASHING AND WATERPROOF SEALANT BETWEEN AERIALATER, STEEL, ROOF & CONCRETE BLOCK WALL.

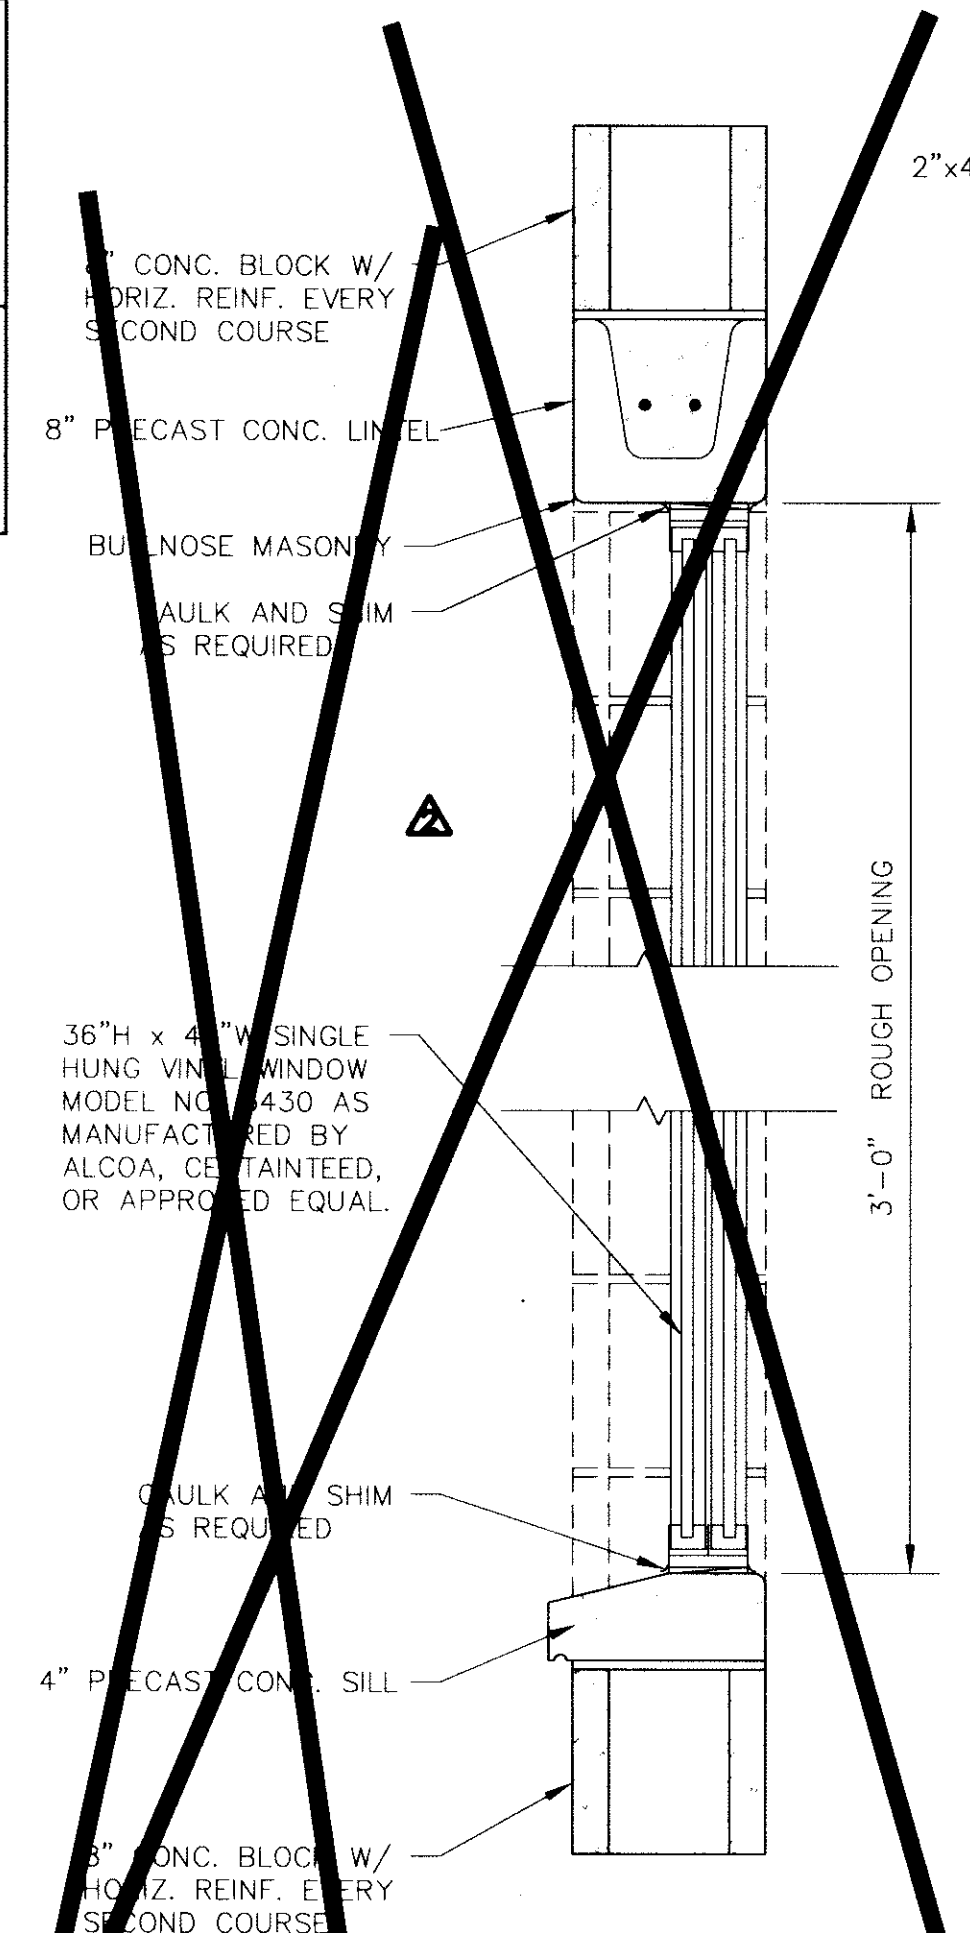


WINDOW SECTION
SCALE: 1 1/2" = 1'-0"

(REMOVED AT OWNERS REQUEST)

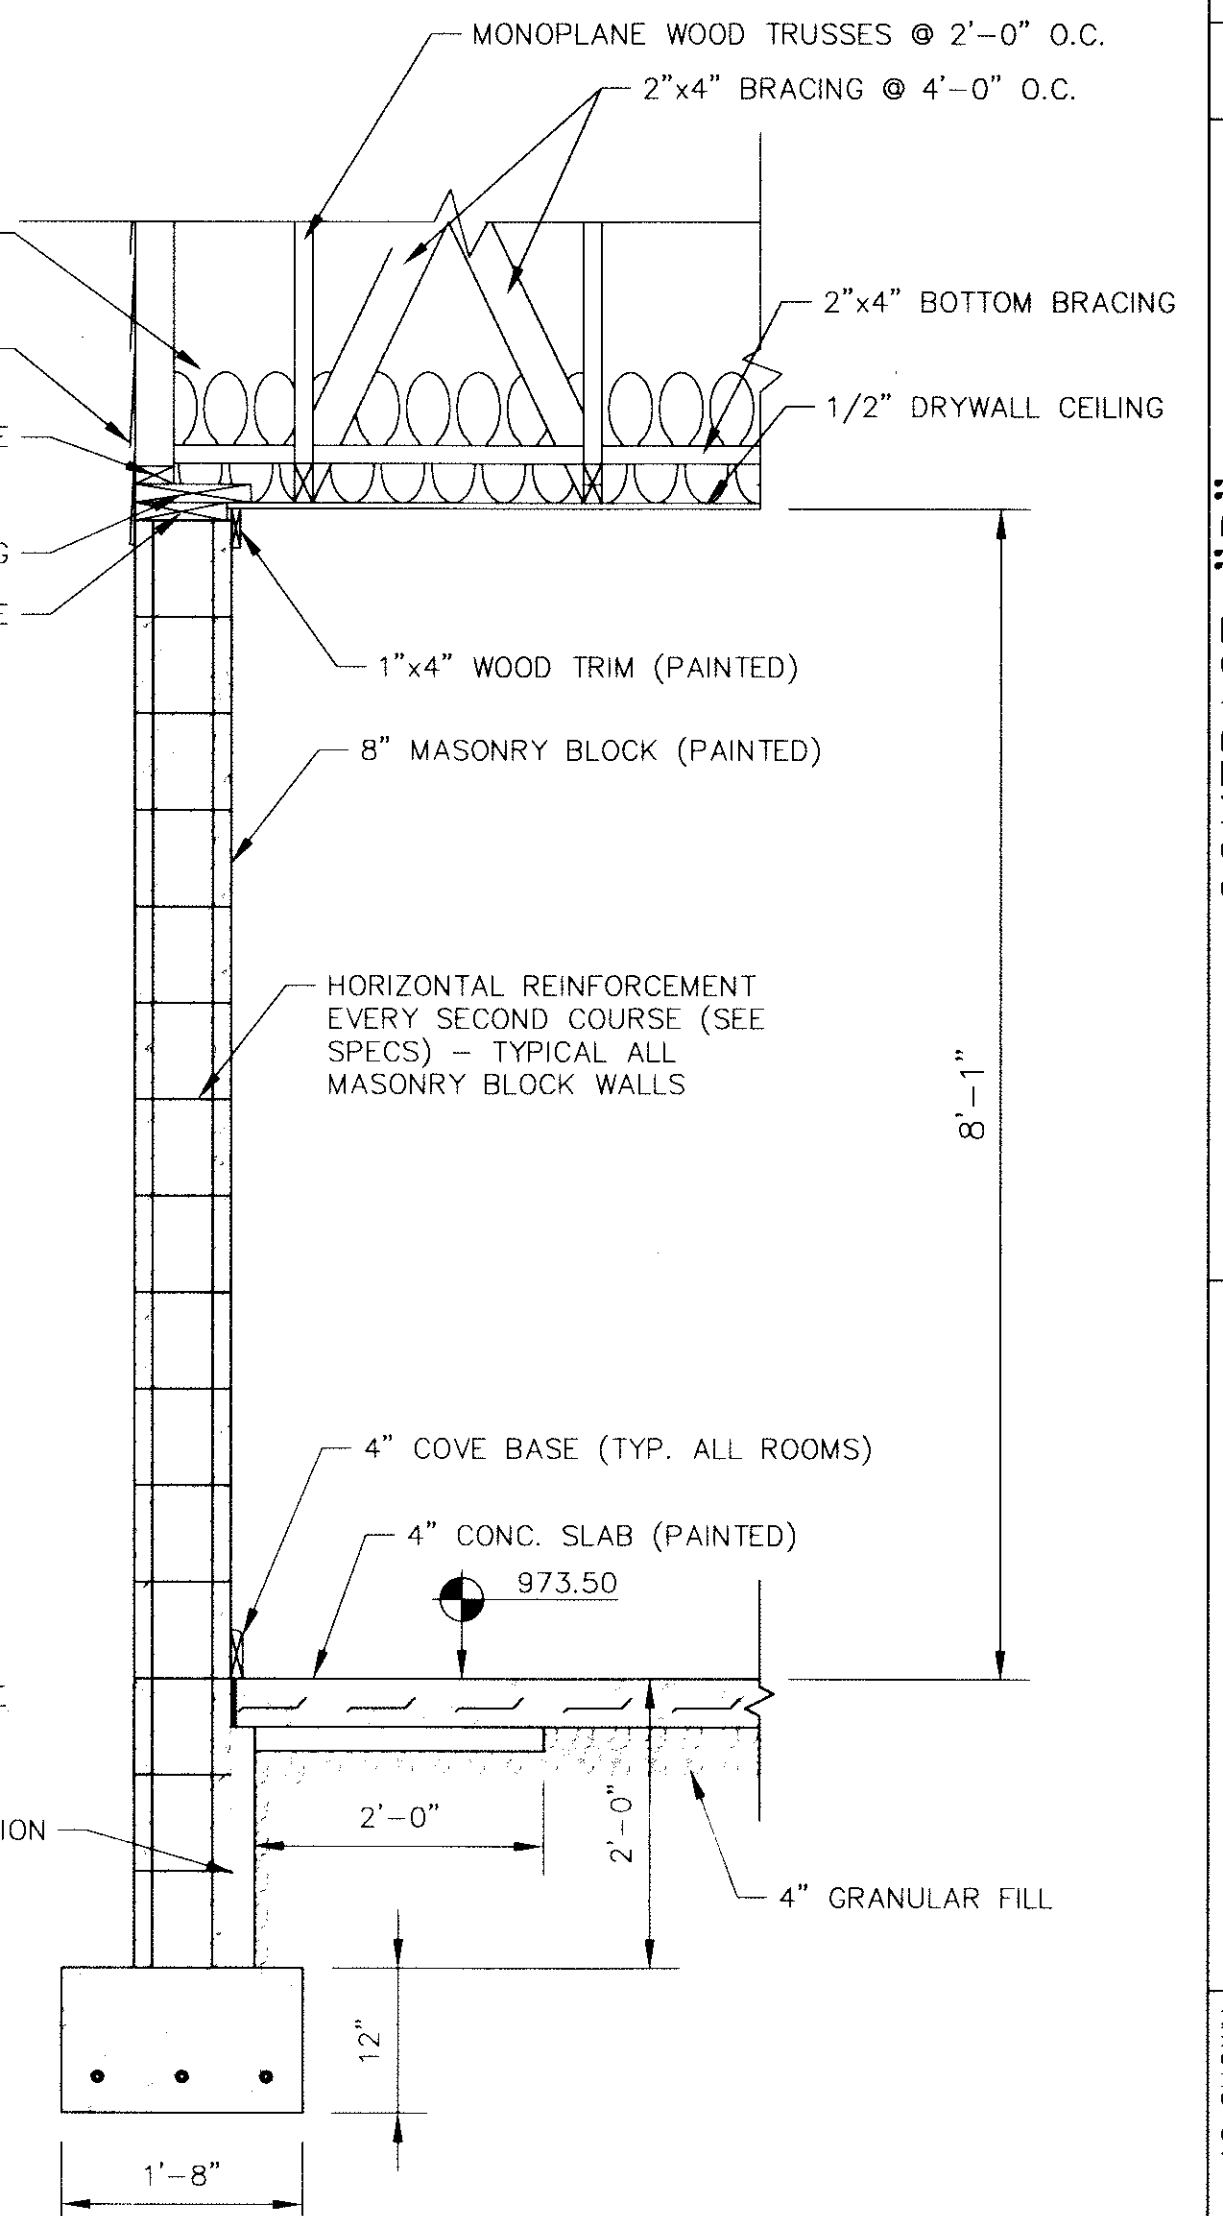

SECTION A-A
SCALE: 3/4" = 1'-0"

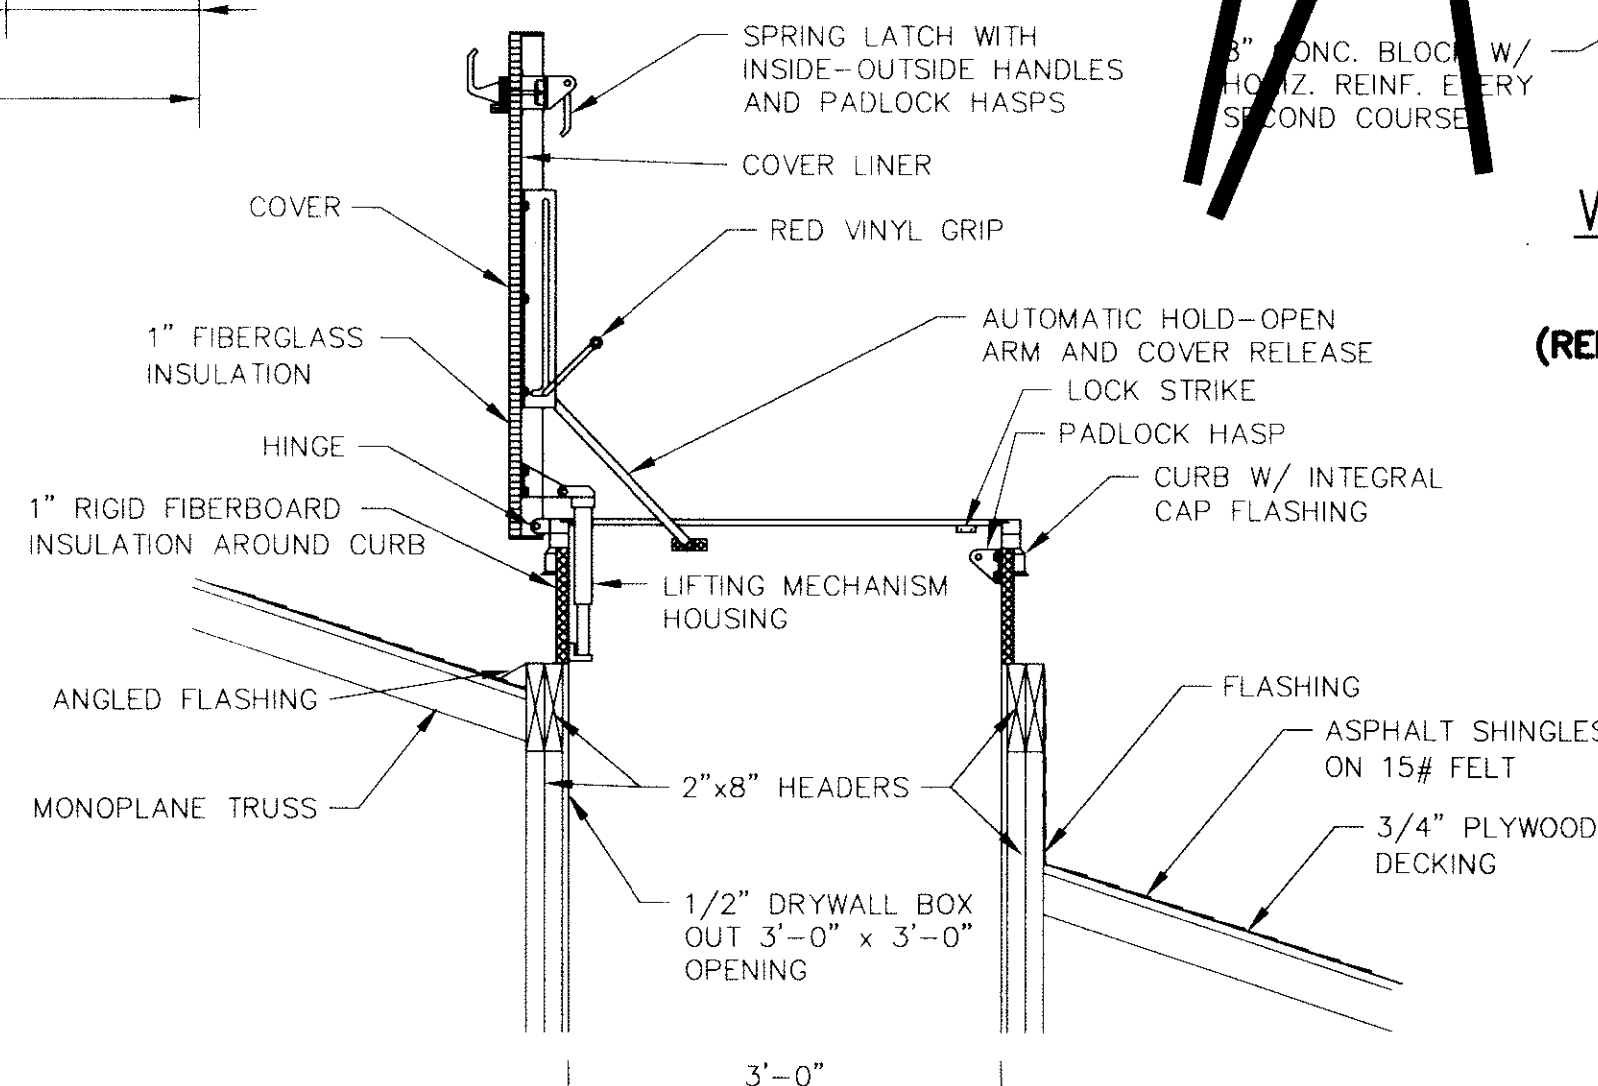

ROOF HATCH DETAIL
SCALE: 3/4" = 1'-0"

RECORD DRAWINGS
THESE DRAWINGS HAVE BEEN PREPARED FROM INFORMATION BY OTHERS. ENGINEER WILL NOT BE RESPONSIBLE FOR ERRORS AND OMISSIONS IN THE INFORMATION OR RECORDS FROM WHICH THESE DRAWINGS ARE PRODUCED.

WESSLER and ASSOCIATES CONSULTING ENGINEERS 6219 South East Street, Suite A Indianapolis, Indiana 46227-2148		CONTRACT "B" WELLS AND TREATMENT FACILITIES ROOF FRAMING PLAN AND SECTIONS ELROD WATER COMPANY, INC. DIVISION "E" WATERWORKS SYSTEM IMPROVEMENTS	
SCALE: AS SHOWN DATE: OCT. 14, 1993 PROJECT NO.: 37391.04 DRAWN BY: M.A.W. APPROVED BY: D.G.C. PLOTTED: 4/13/94 CAD FILE: 373-B12.DWG	RECORD DRAWINGS 2 11/8/96 CLG 1 3/4/94 CLG NO. 1 DATE BY	NOT PUBLISHED ALL RIGHTS RESERVED EXCEPT FOR USES EXPRESSLY PERMITTED IN WRITING, INFORMATION SHOWN OR INCLUDED IN THIS DOCUMENT IS SOLELY THE PROPERTY OF M.D. WESSLER & ASSOCIATES, INC.	
		SHEET B12 OF 19	