




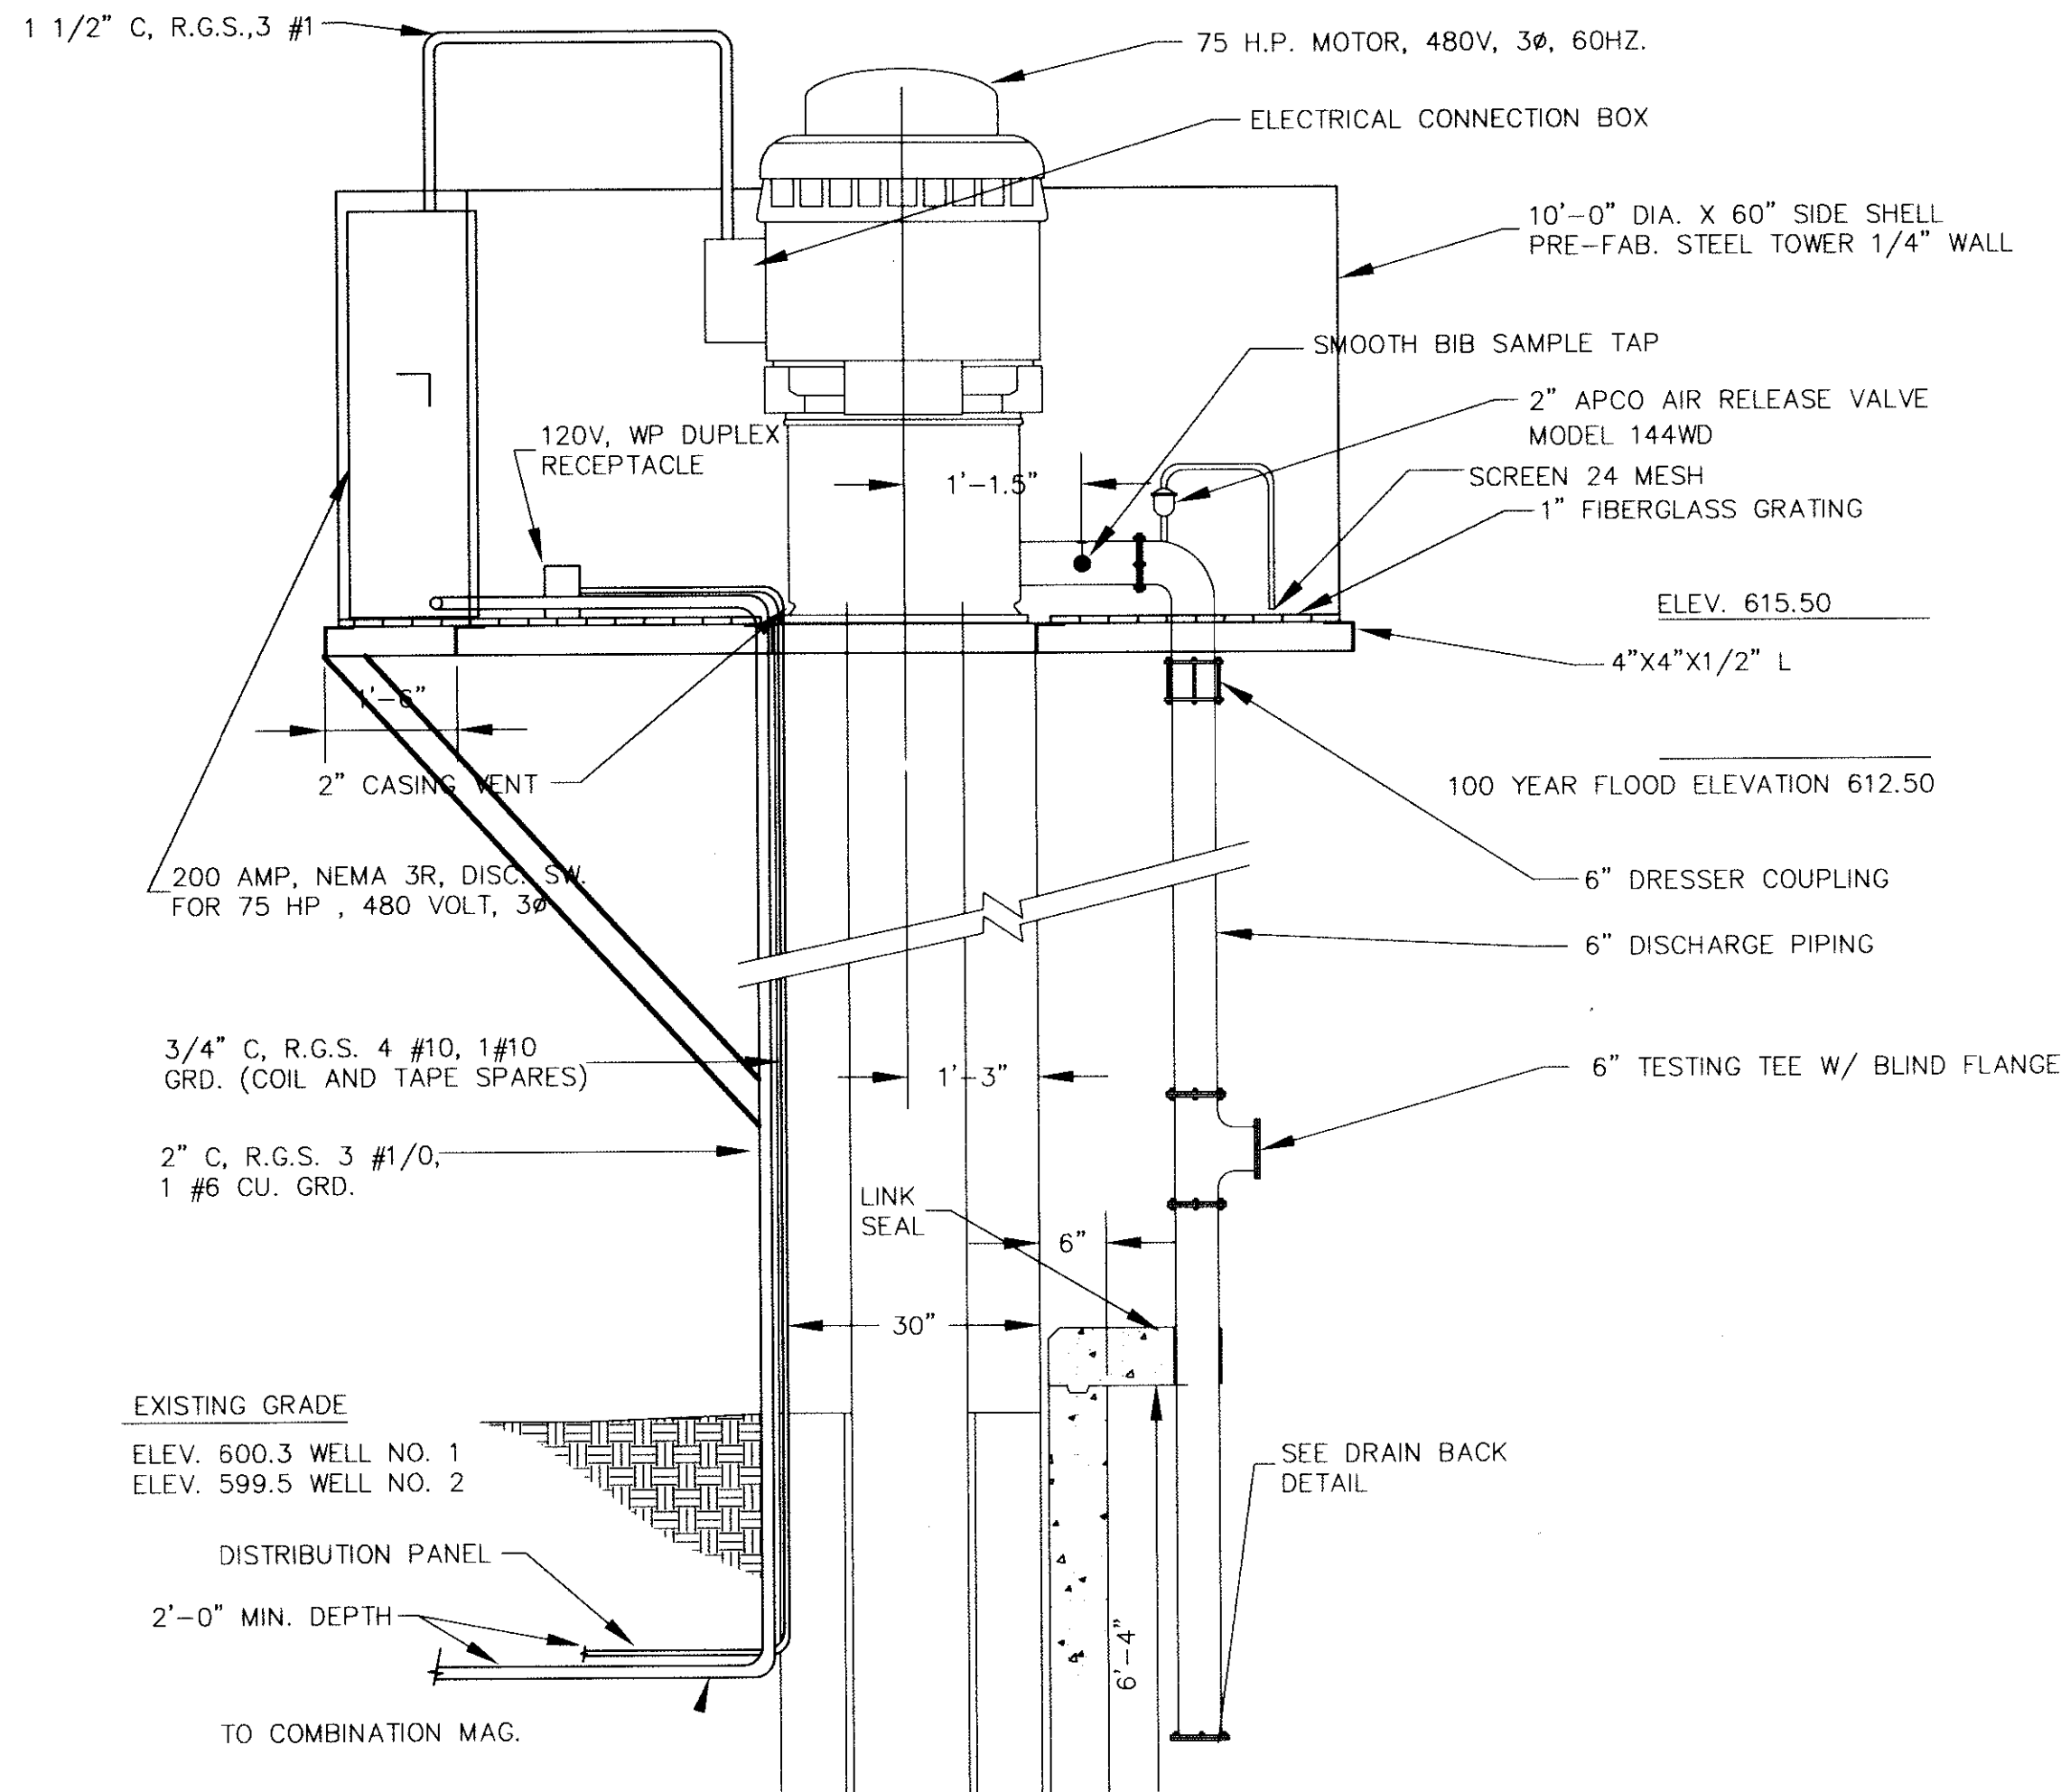


SECTION - WELL NO. 1 SHEET B4
SCALE: 1/2" = 1'-0"

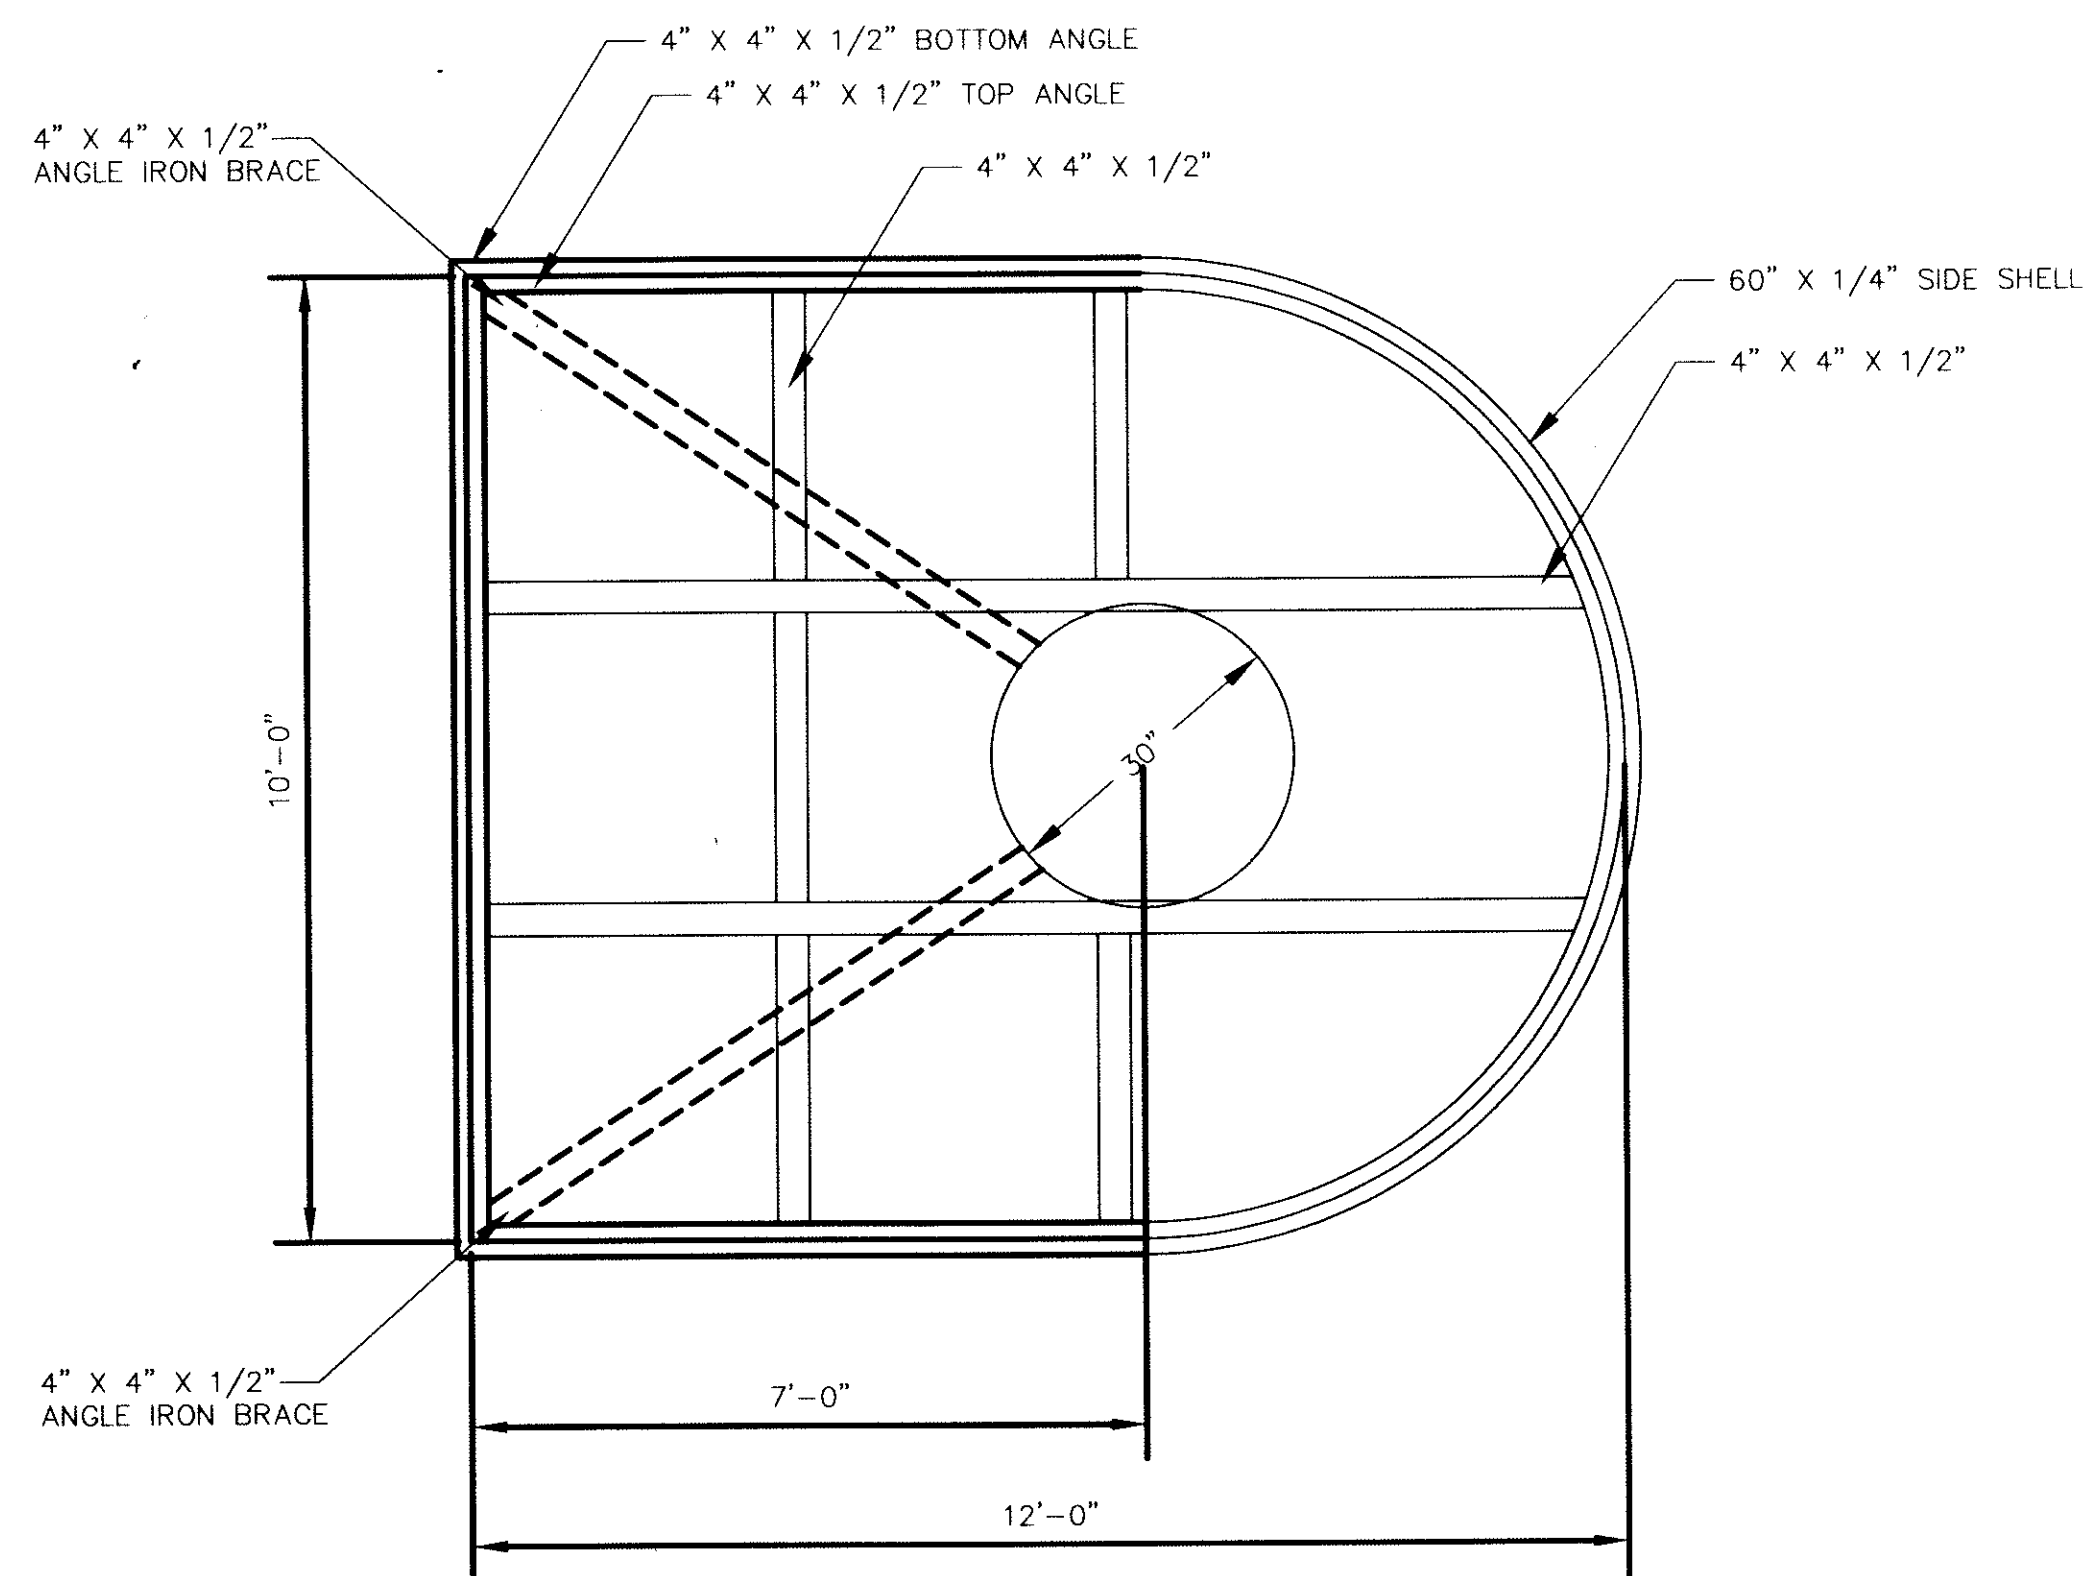


ENLARGED PLATFORM FOR WELL NO. 1 SHEET B4
SCALE: 1/2" = 1'-0"

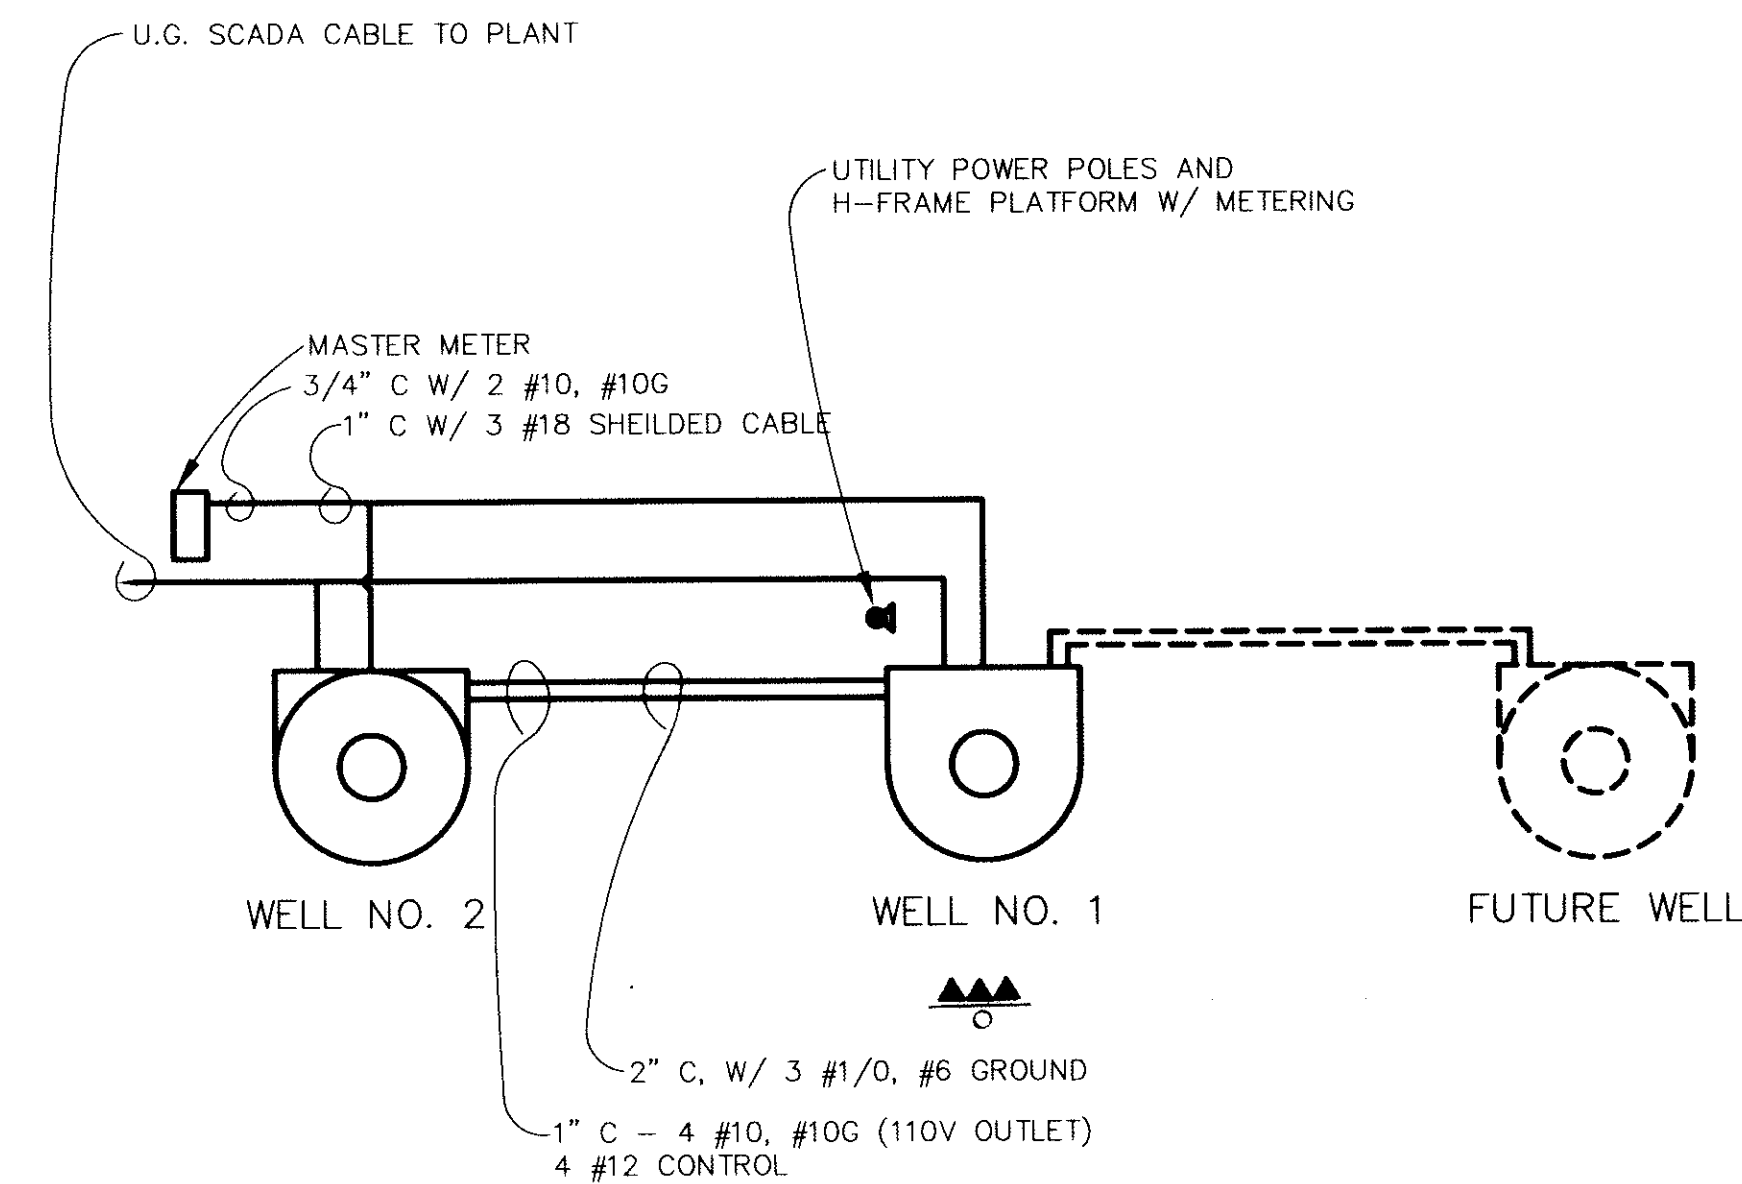

ELECTRICAL SITE PLAN SHEET B5
SCALE: NONE

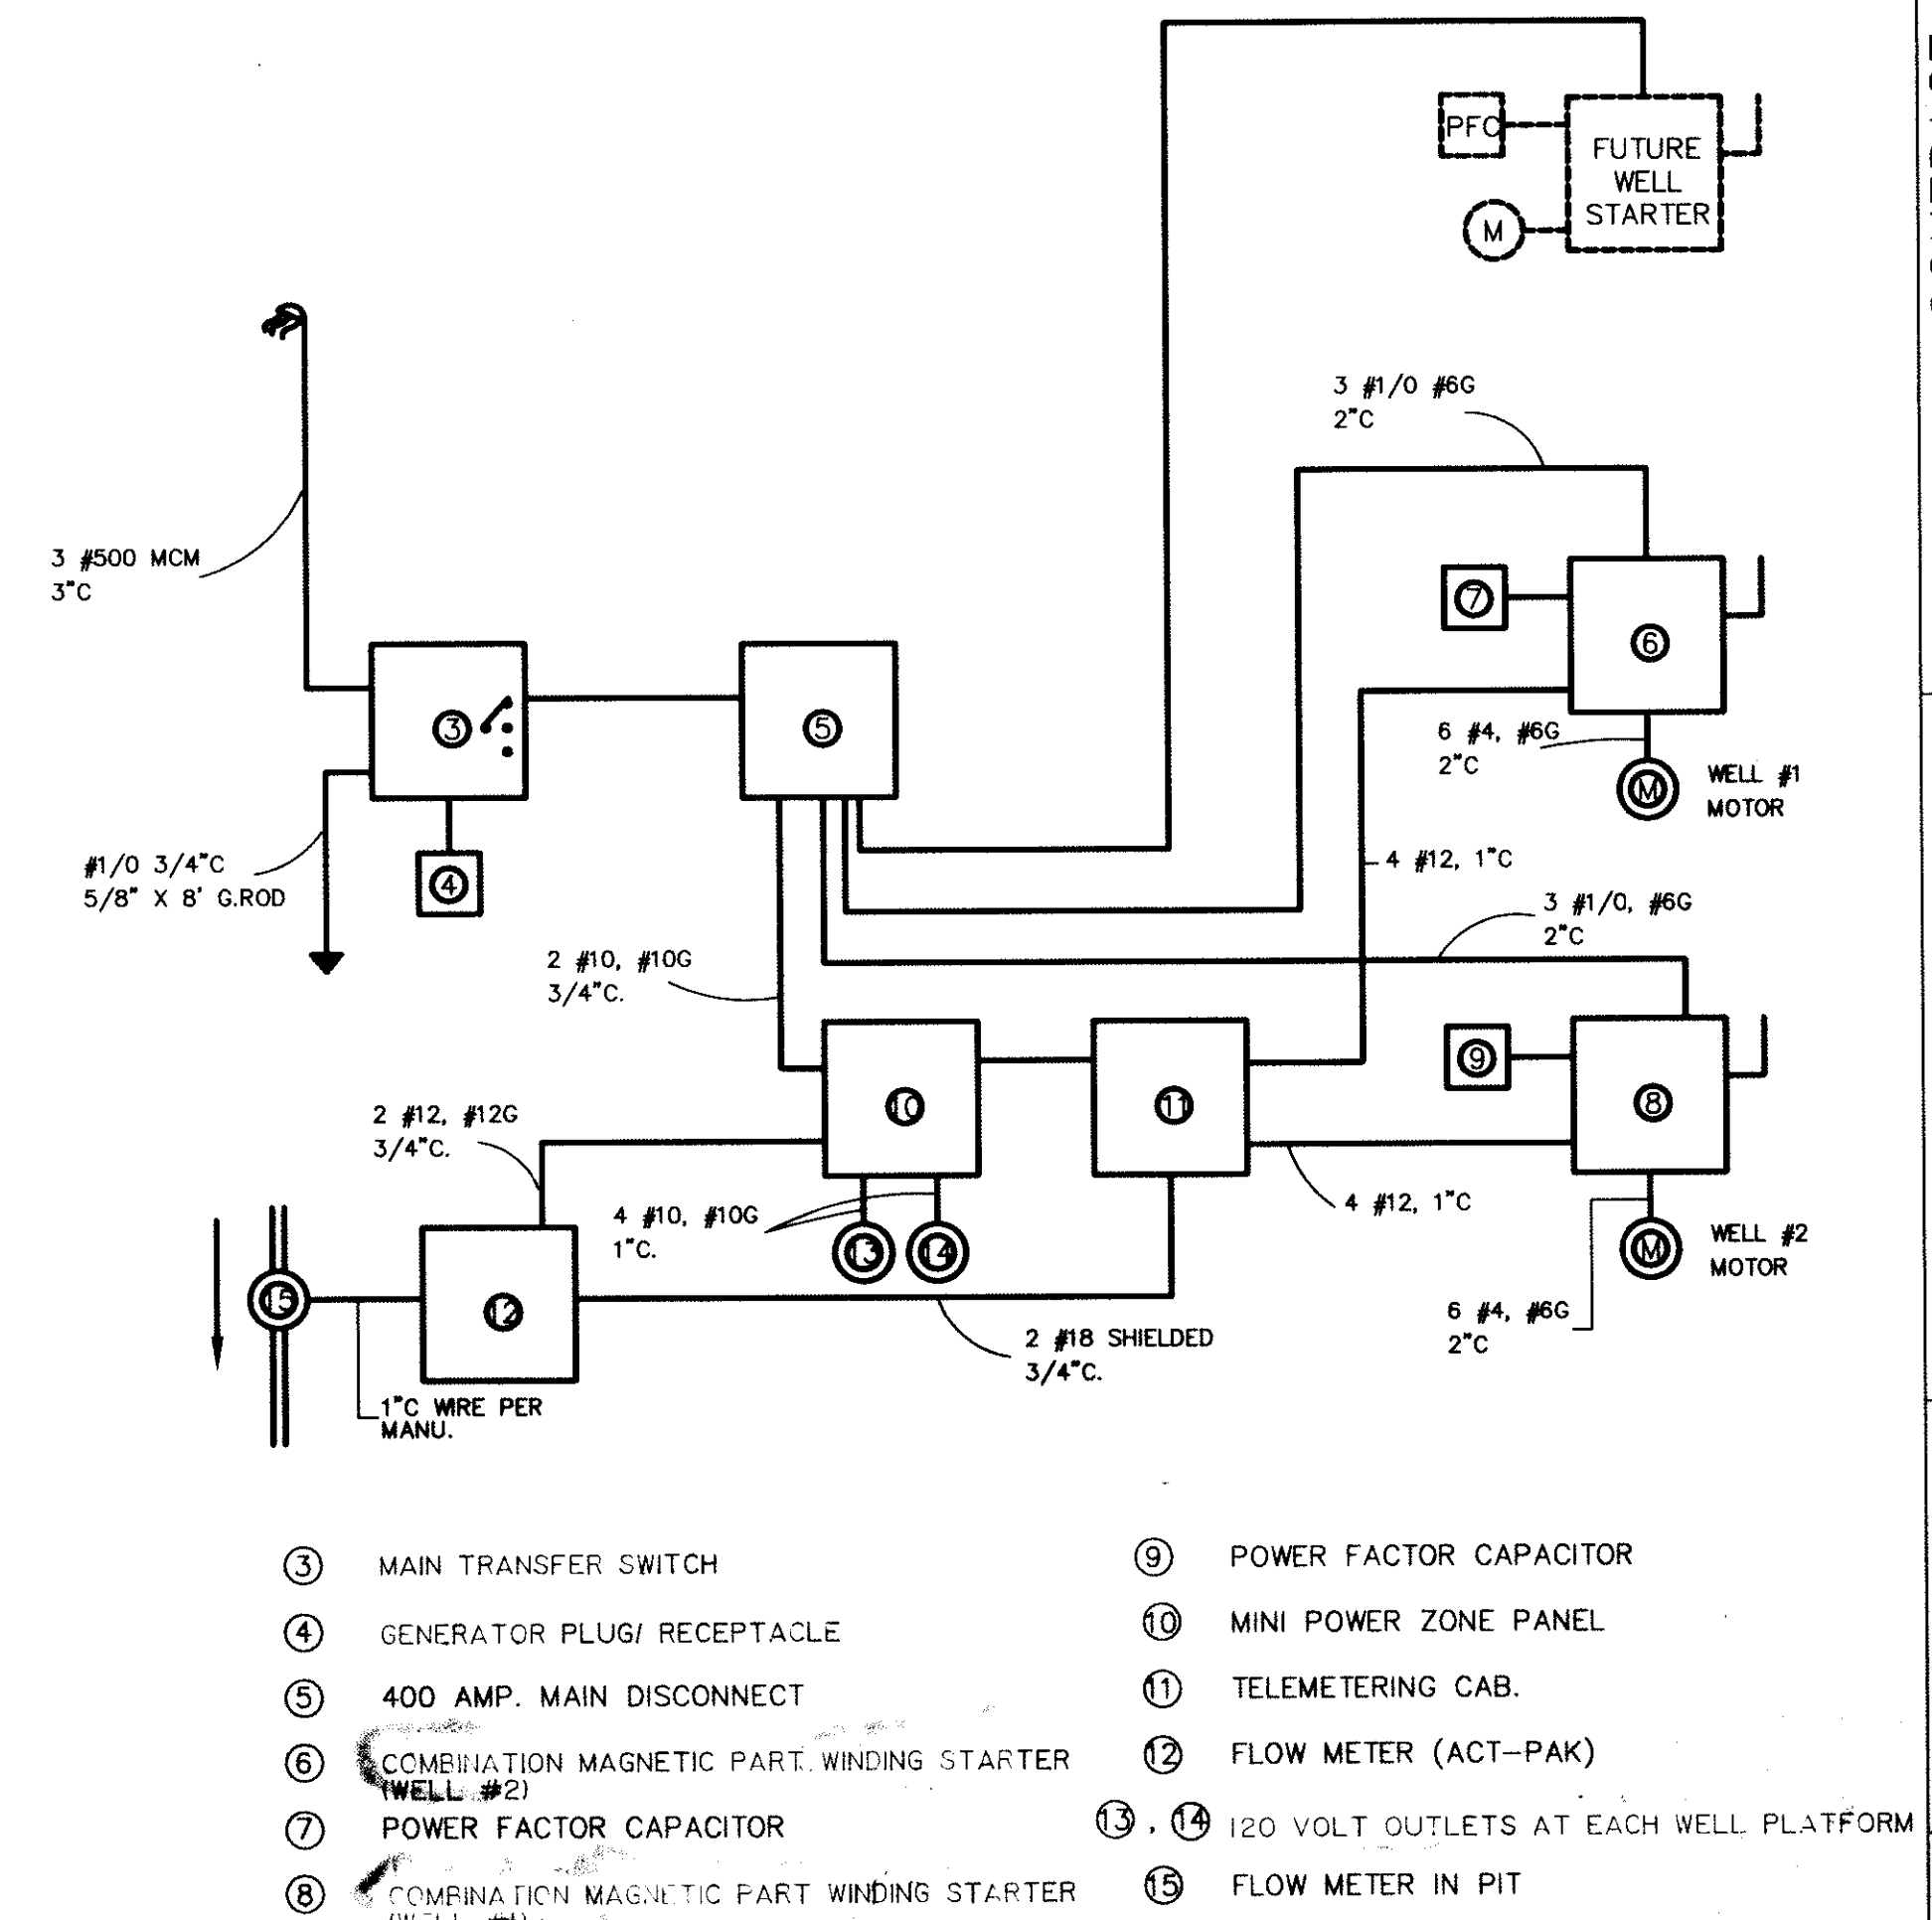

ELECTRICAL ONE LINE WELL FIELD
SCALE: NO SCALE

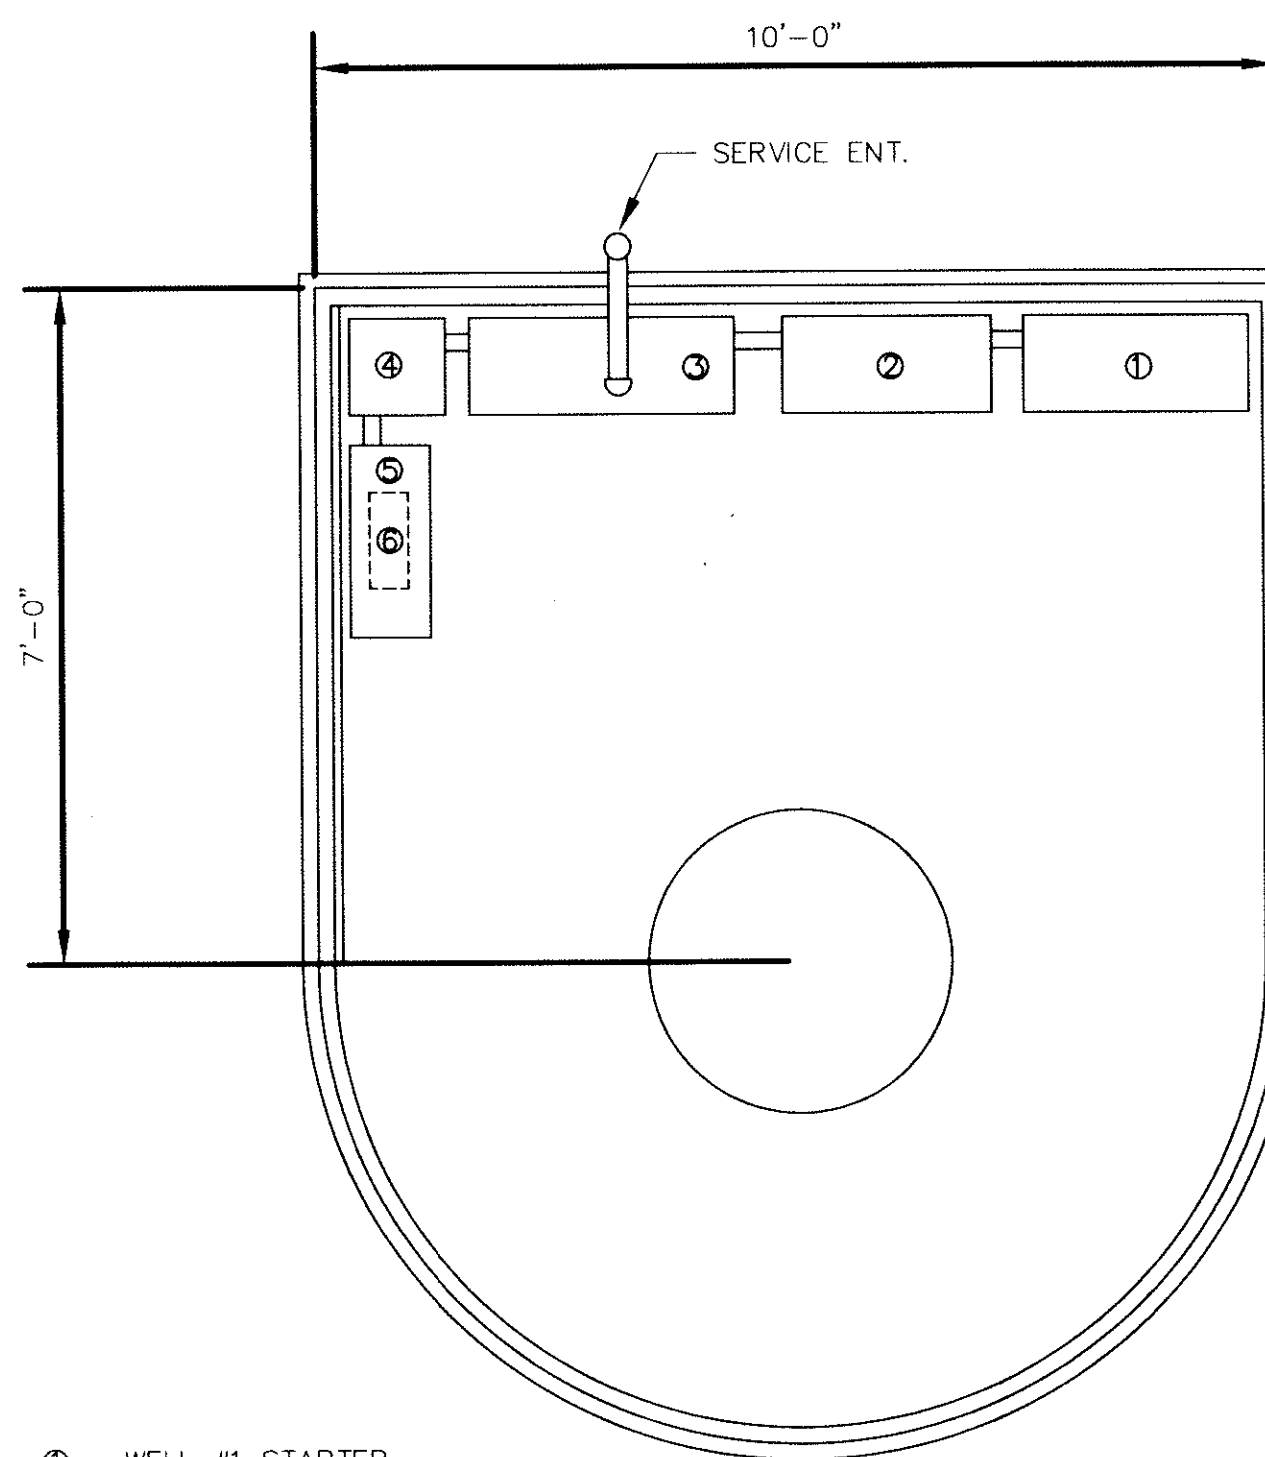

- ① WELL #1 STARTER
- ② 400A MAIN. DISC. SW
- ③ MAN. TRANSFER SW.
- ④ MINI POWER ZONE (480/120-240V)
- ⑤ TELEMETERING CAB.
- ⑥ FLOW INDICATOR/TOTALIZER

ELECTRICAL PLAN VIEW WELL NO. 1
SCALE: 1/2" = 1'-0"

RECORD DRAWINGS
THESE DRAWINGS HAVE BEEN PREPARED FROM INFORMATION BY OTHERS. ENGINEER WILL NOT BE RESPONSIBLE FOR ERRORS AND OMISSIONS IN THE INFORMATION OR RECORDS FROM WHICH THESE DRAWINGS ARE PRODUCED.

CONTRACT "B"
WELLS AND TREATMENT FACILITIES
WELL TOWER AND PIT DETAILS
ELROD WATER COMPANY, INC.
DIVISION "E"
WATERWORKS SYSTEM IMPROVEMENTS

WESSLER and ASSOCIATES
CONSULTING ENGINEERS
6219 South East Street, Suite A
Indianapolis, Indiana 46227-2148

SCALE: AS SHOWN
DATE: JULY 23, 1996
PROJECT NO.: 37391.06
DRAWN BY: J.W.R.
APPROVED BY: D.G.C.
PLOTTED: 7/23/96
CAD FILE: 373REC.DWG

NOT PUBLISHED
ALL RIGHTS RESERVED
EXCEPT FOR USES EXPRESSLY PERMITTED IN WRITING, INFORMATION SHOWN OR INCLUDED IN THIS DOCUMENT IS SOLELY THE PROPERTY OF M.D. WESSLER & ASSOCIATES, INC.

MELVIN D. WESSLER
REGISTERED
No. 12215
STATE OF INDIANA
PROFESSIONAL ENGINEER

SHEET B
OF