



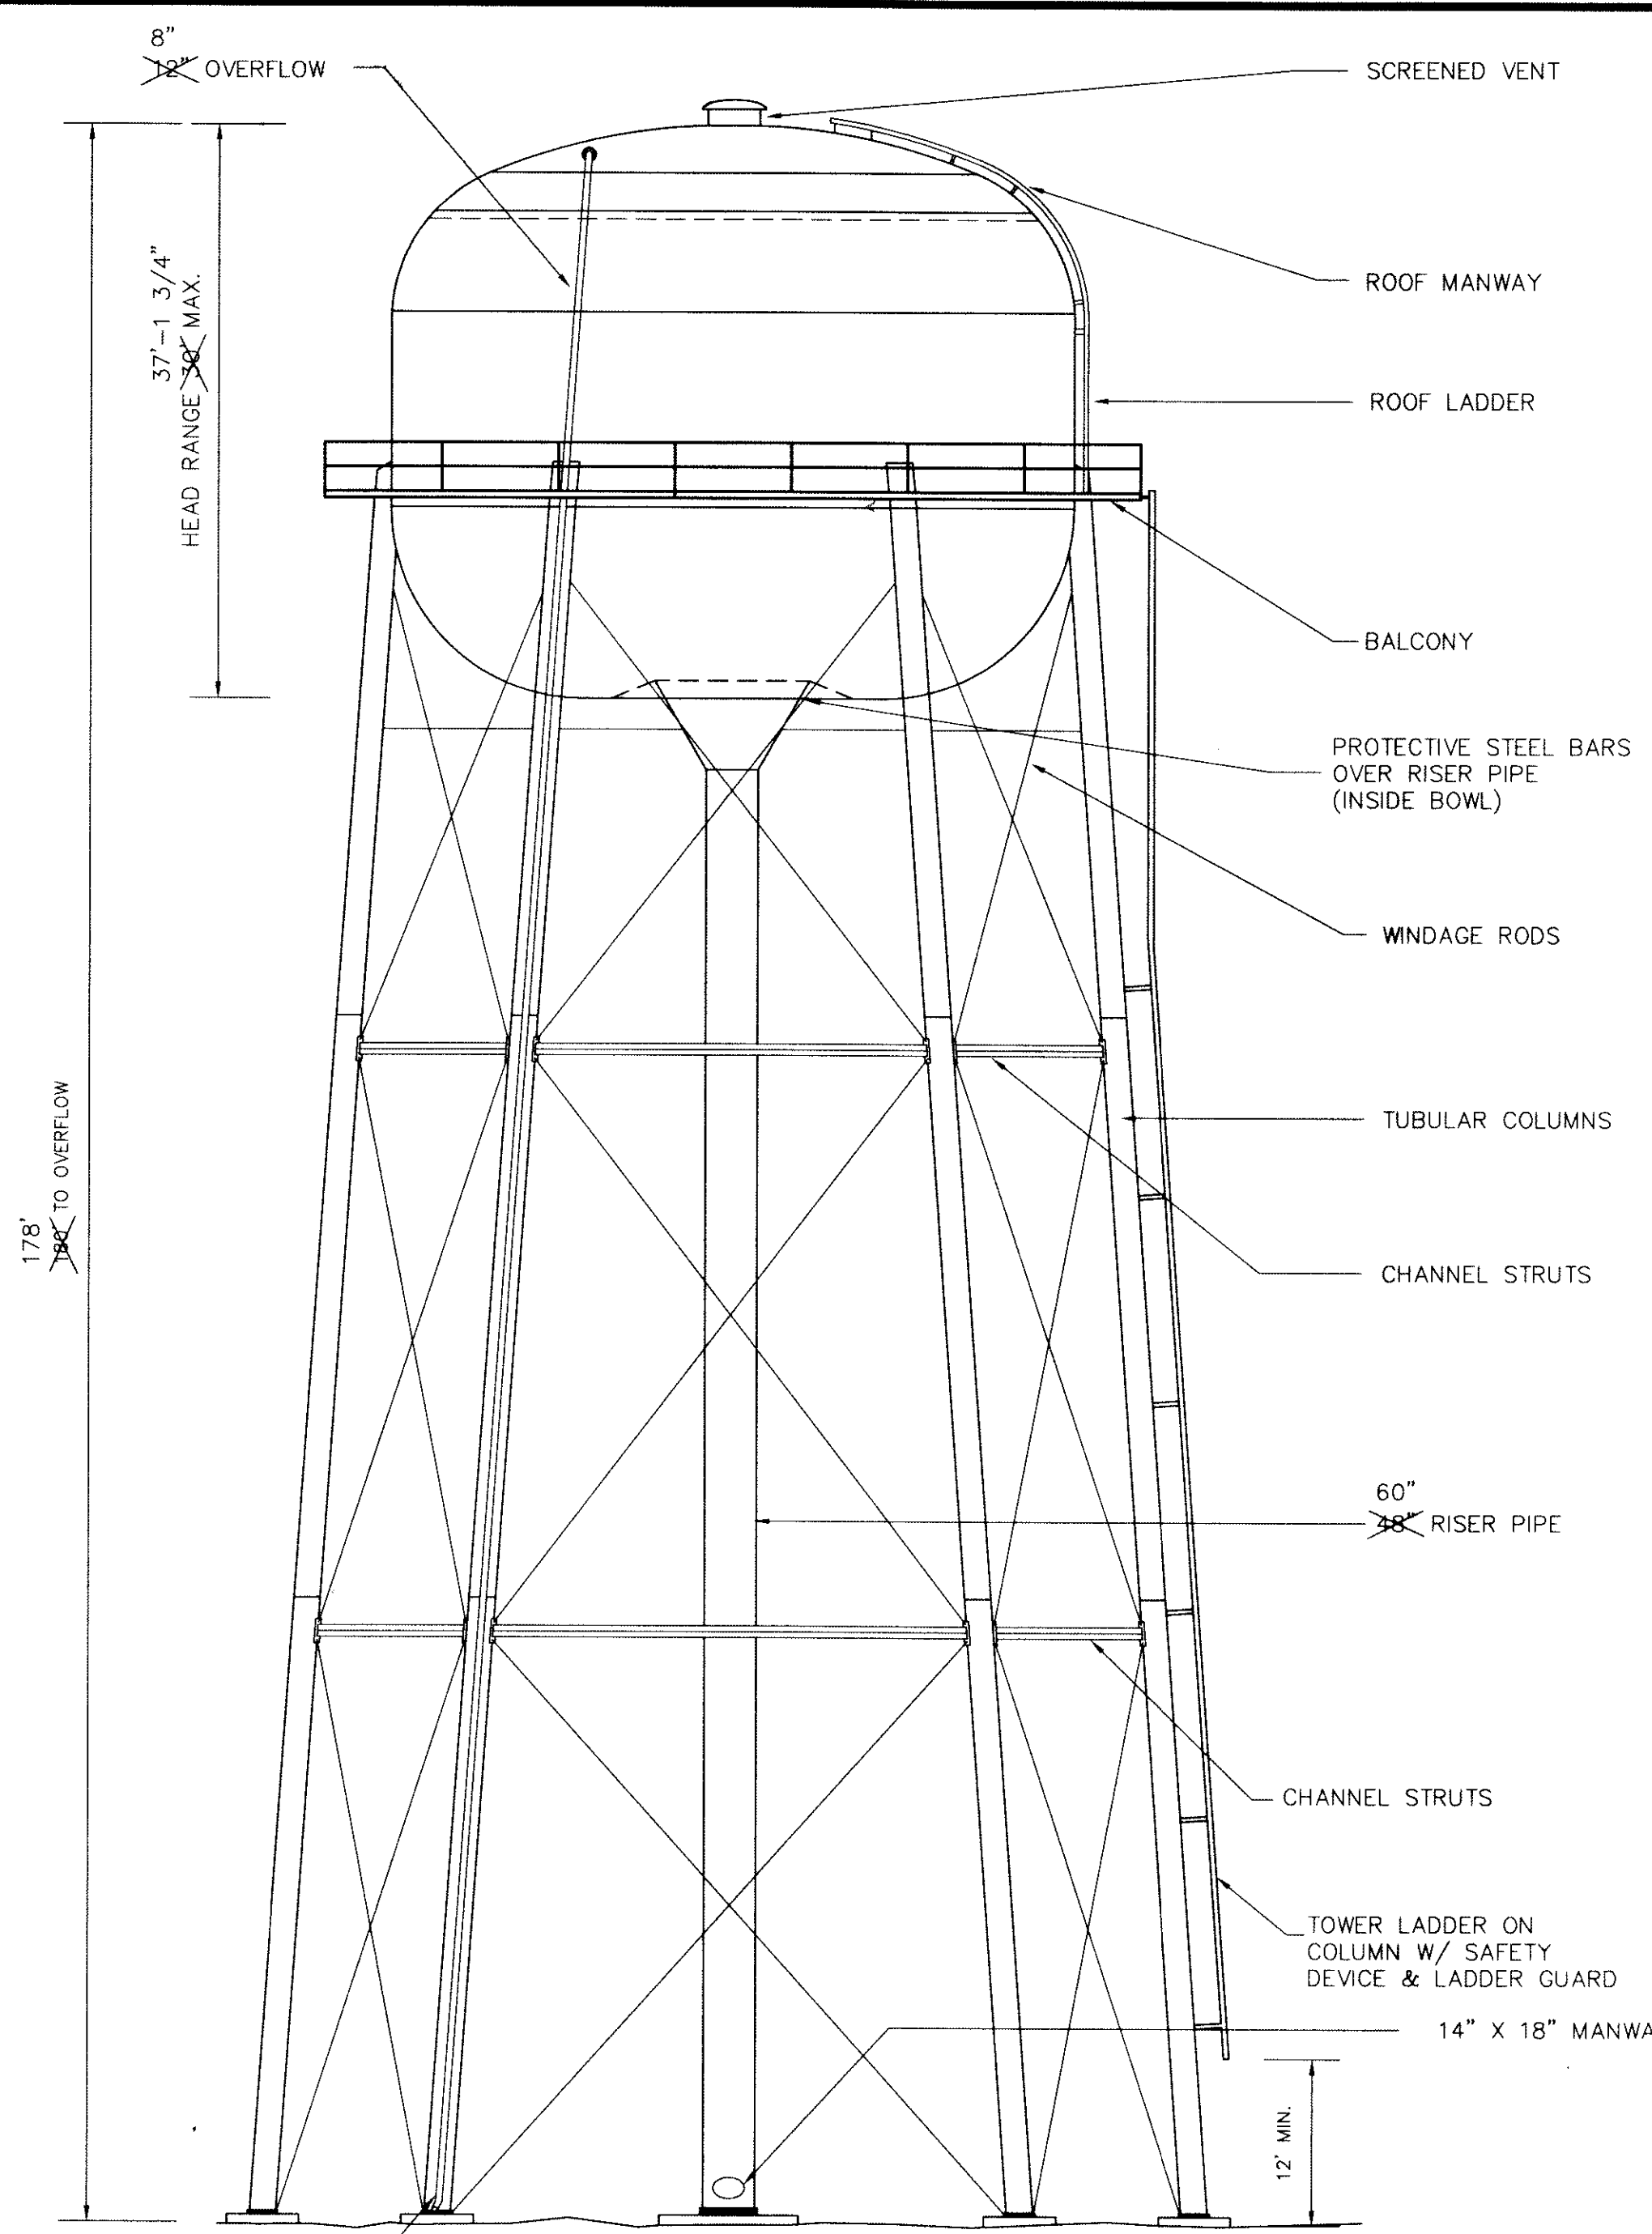


400,000 GALLON ELEVATED TANK ELEVATION
SCALE: NONE

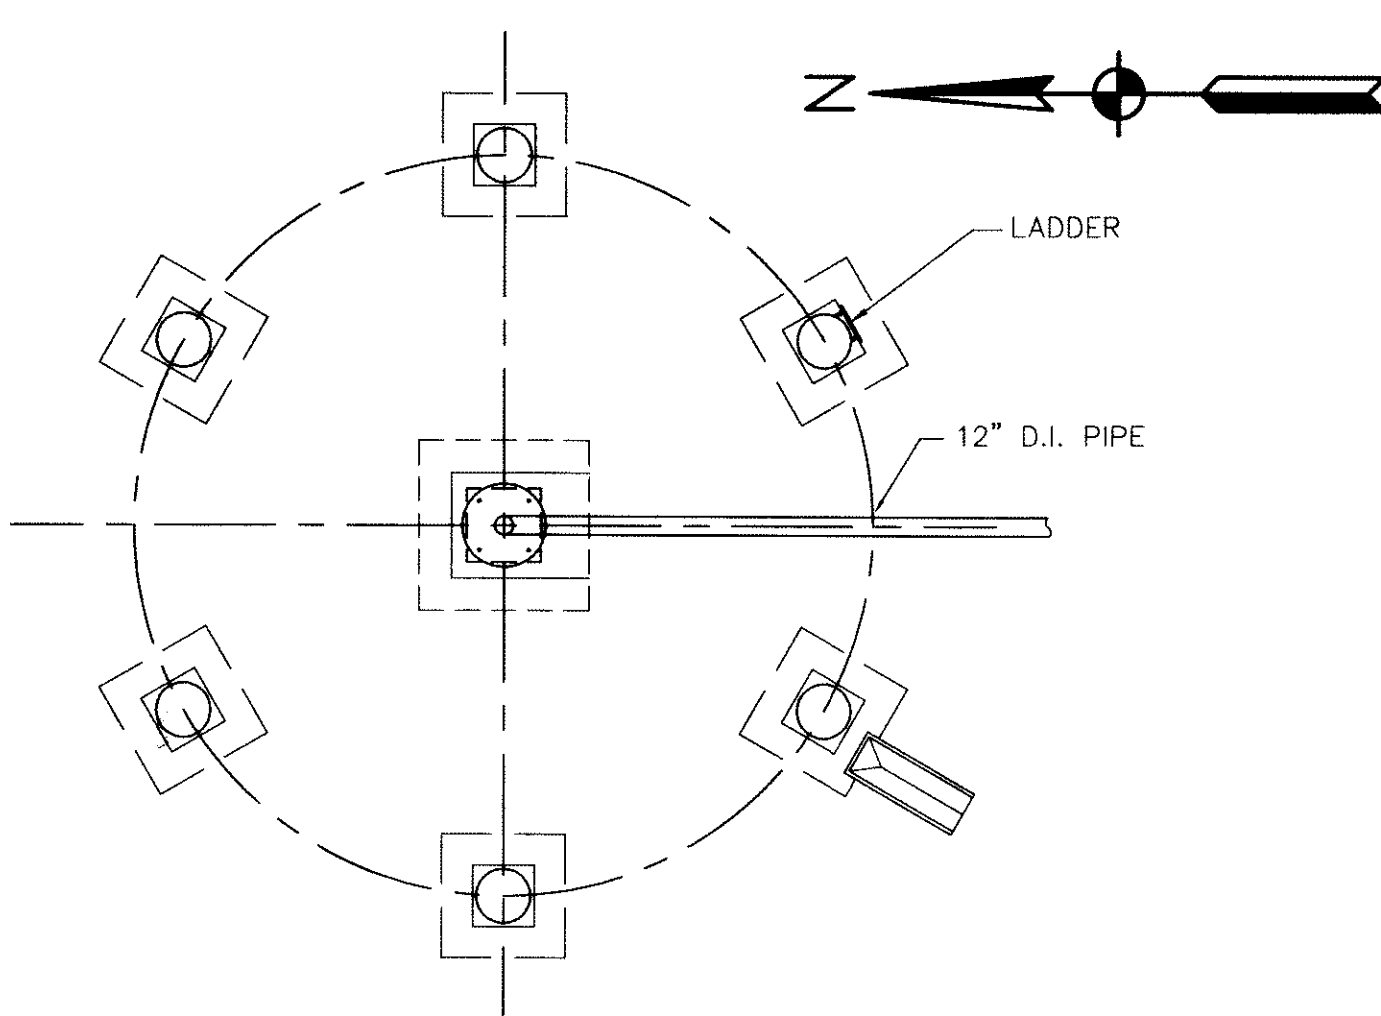

TANK FOUNDATION PLAN
SCALE: NONE


RECORD DRAWINGS
THESE DRAWINGS HAVE BEEN PREPARED FROM INFORMATION BY OTHERS. ENGINEER WILL NOT BE RESPONSIBLE FOR ERRORS AND OMISSIONS IN THE INFORMATION OR RECORDS FROM WHICH THESE DRAWINGS ARE PRODUCED.

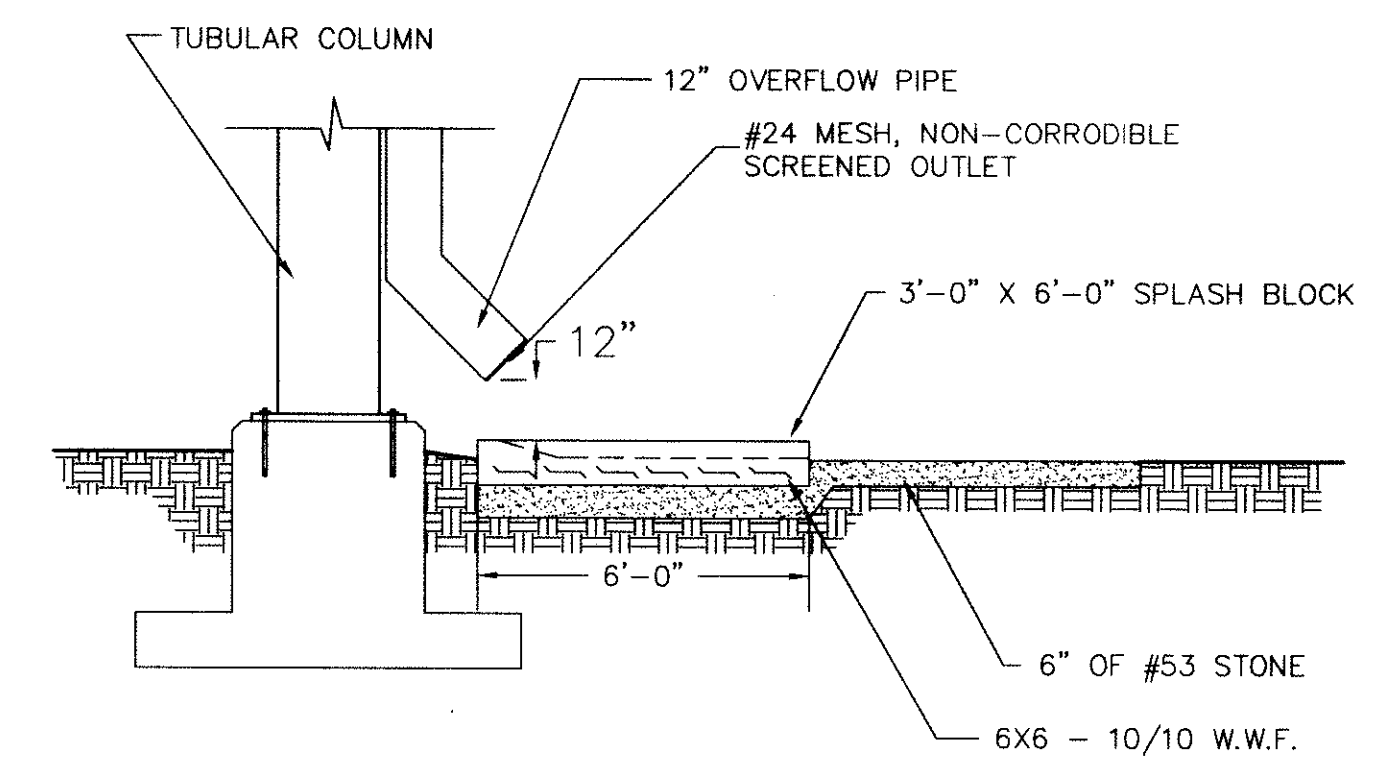


SPLASH BLOCK DETAIL
SCALE: NONE

PLAN NOTES:

1. THE CONTRACTOR IS RESPONSIBLE FOR THE COMPLETE DESIGN OF THE TANK AND FOUNDATIONS FOR THE SIZE OF THE TANK ACCEPTED BY THE OWNER FROM THE BIDS RECEIVED.
2. A COPY OF THE SOILS REPORT FOR THE SUBSURFACE INVESTIGATION IS INCLUDED IN THE SPECIFICATIONS.
3. ACCESS STONE DRIVE SHALL BE CONSTRUCTED IN ACCORDANCE WITH INDOT PERMIT.

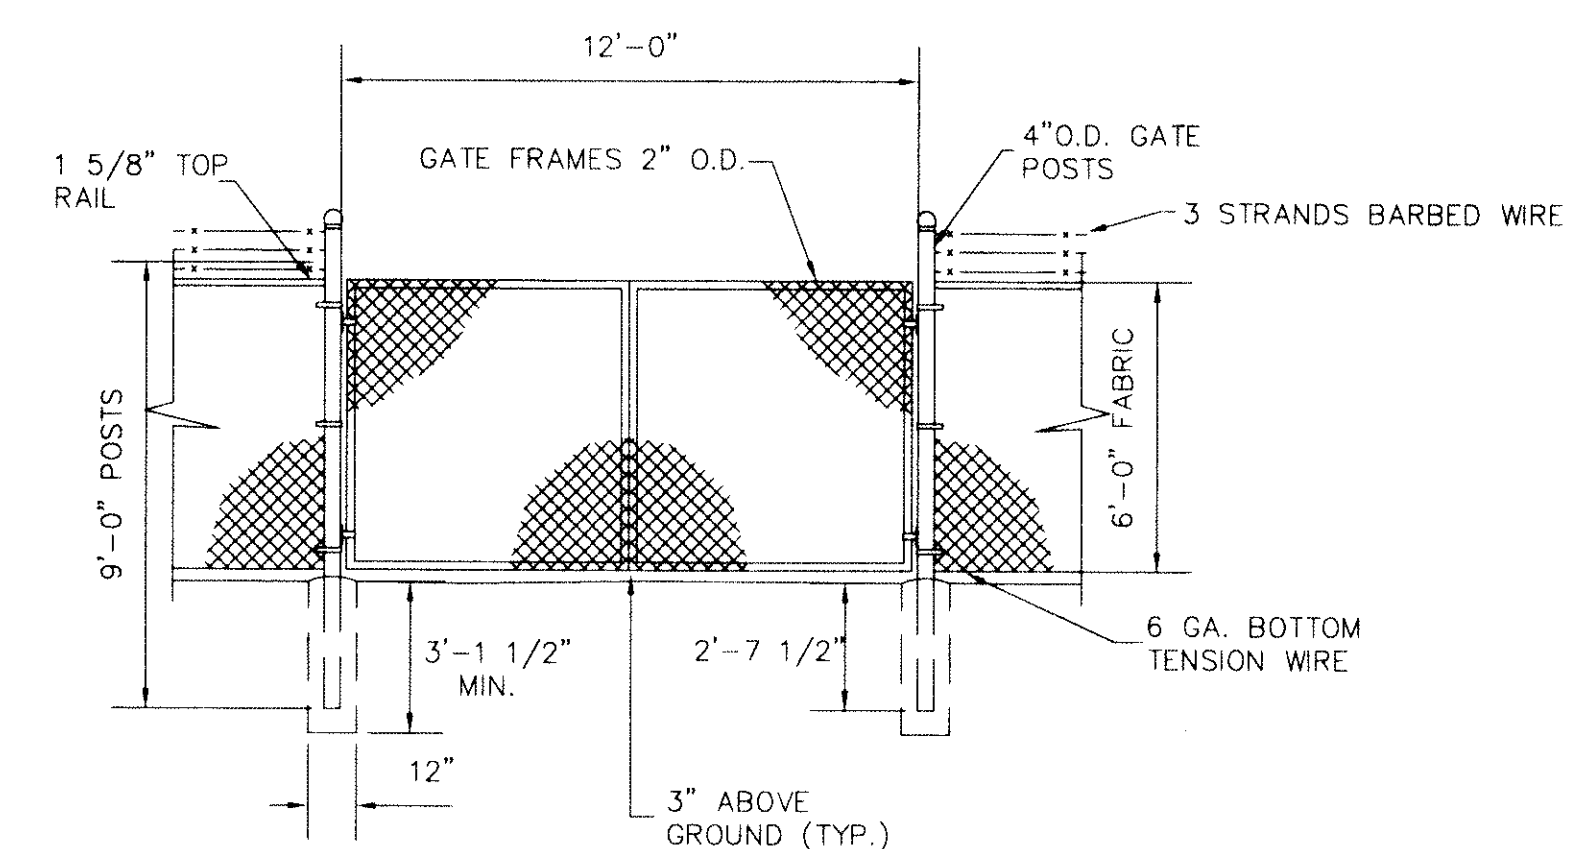


TYPICAL 12' DOUBLE GATE DETAIL
SCALE: NONE

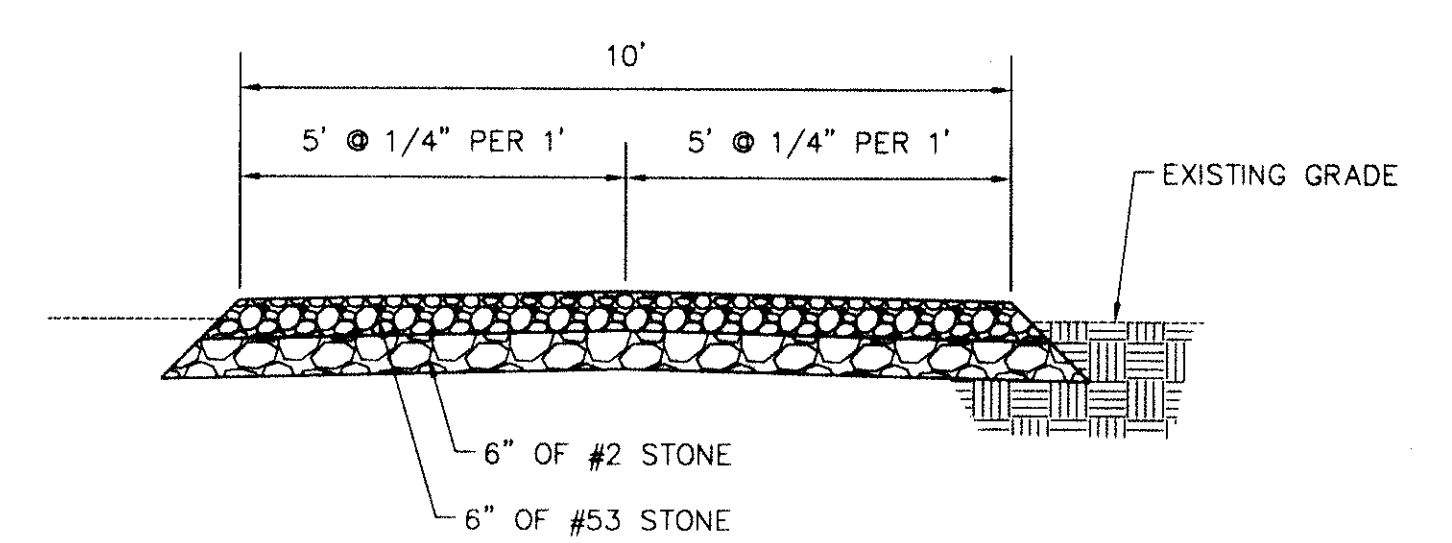


TYPICAL STONE DRIVE SECTION
SCALE: NONE


RECORD DRAWINGS
These drawings have been prepared from information by others. Engineer will not be responsible for errors and omissions in the information or records from which these drawings are produced.

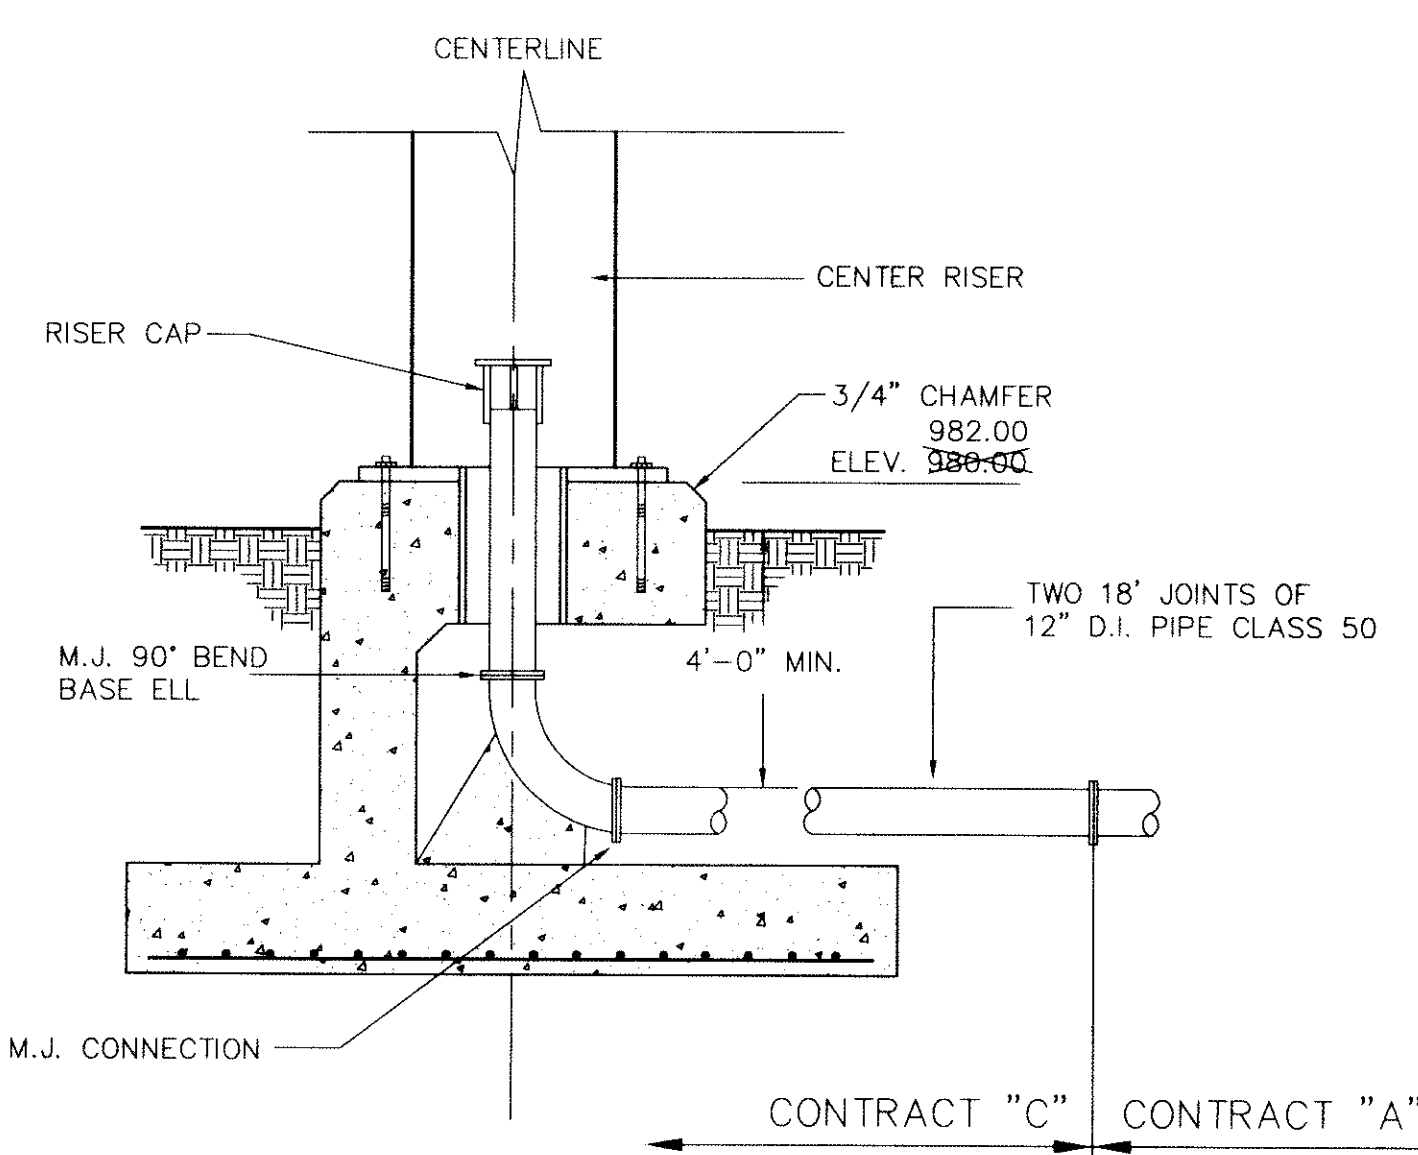

CENTER PIER & RISER DETAIL
SCALE: NONE

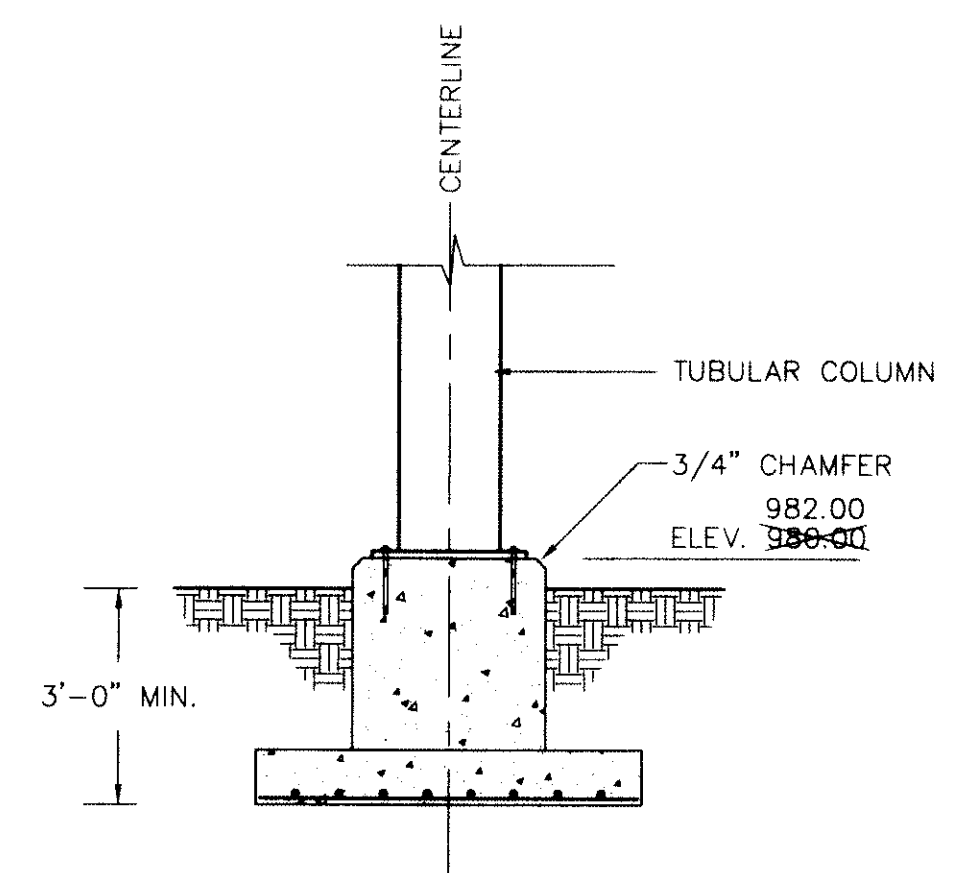

COLUMN PIER DETAIL
SCALE: NONE

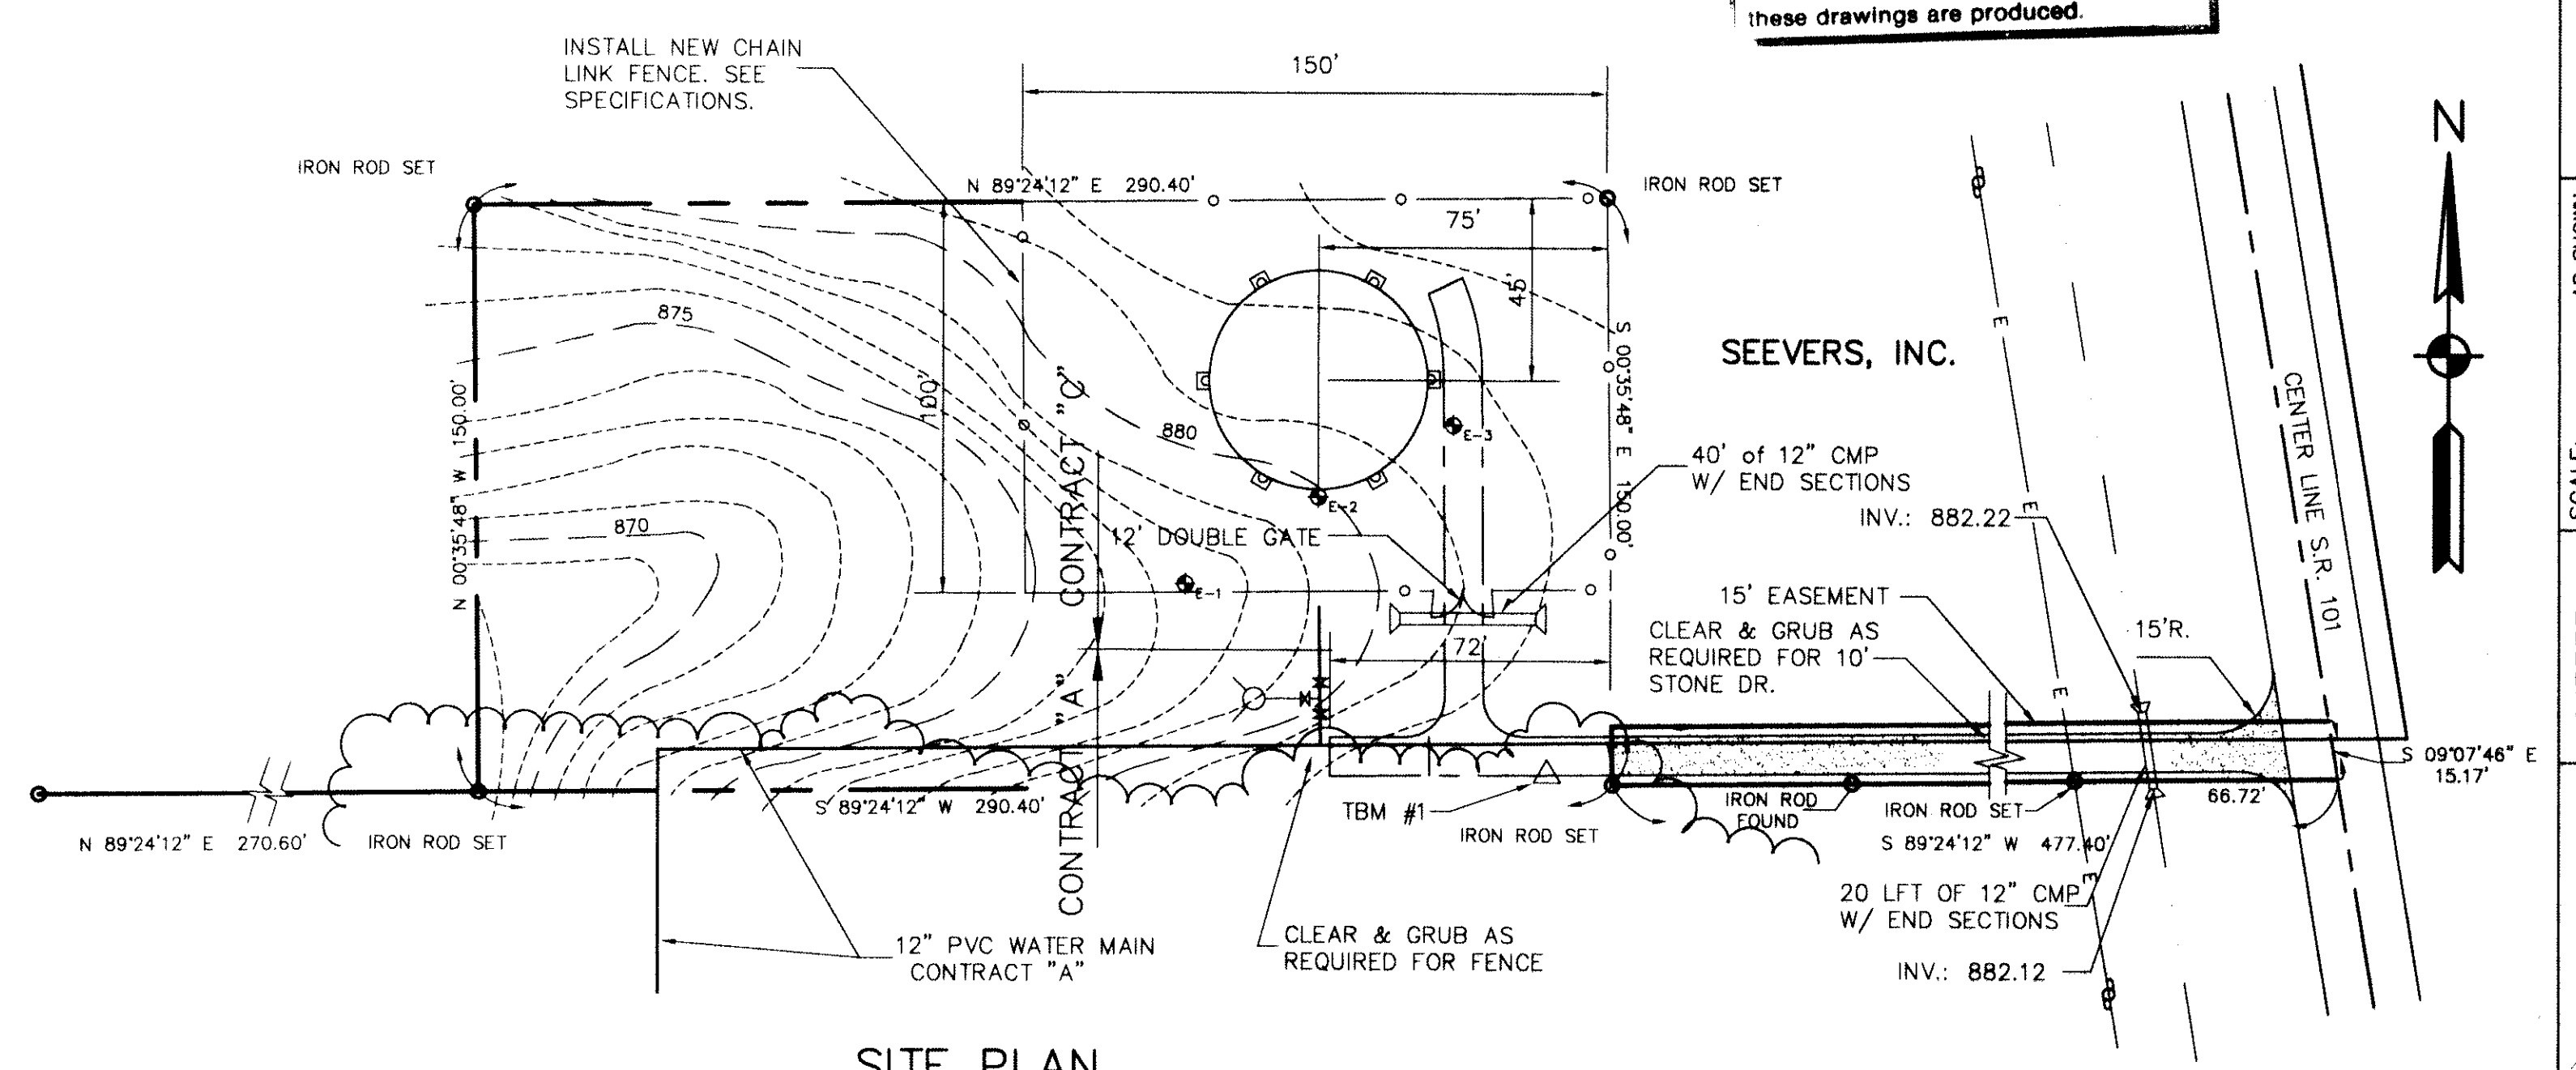

SITE PLAN
SCALE: 1" = 40'

BENCHMARK INFORMATION
TBM #1 RAILROAD SPIKE IN 6" DIA. TREE
ELEV. 983.64

CONTRACT "C"		WATER STORAGE TANKS		400,000 GALLON ELEVATED TANK		ELROD WATER COMPANY, INC.		DIVISION "E"		WATERWORKS SYSTEM IMPROVEMENTS	
NO.	DATE	BY	CLG	RECORD DRAWINGS	CLG	REMOVE ELECTRICAL PLANS THIS CONTRACT	REVISIONS				
2	12/9/96		CLG								
1	3/1/94		CLG								

WESSLER and ASSOCIATES CONSULTING ENGINEERS 6219 South East Street, Suite A Indianapolis, Indiana 46227-2148	AS SHOWN DATE: OCT 14, 1993 PROJECT NO.: 37391.04 DRAWN BY: C.L.G. APPROVED BY: D.C.C. PLOTTED: 1/25/94 CAD FILE: 373-C3.DWG
--	--

NOT PUBLISHED ALL RIGHTS RESERVED EXCEPT FOR USES EXPRESSLY PERMITTED IN WRITING, INFORMATION SHOWN OR INCLUDED IN THIS DOCUMENT IS SOLELY THE PROPERTY OF M.D. WESSLER & ASSOCIATES, INC.	DOUGLAS & COPELAND No. 13334 PROFESSIONAL ENGINEER STATE OF INDIANA [Signature]
--	--

SHEET 3 OF 4