

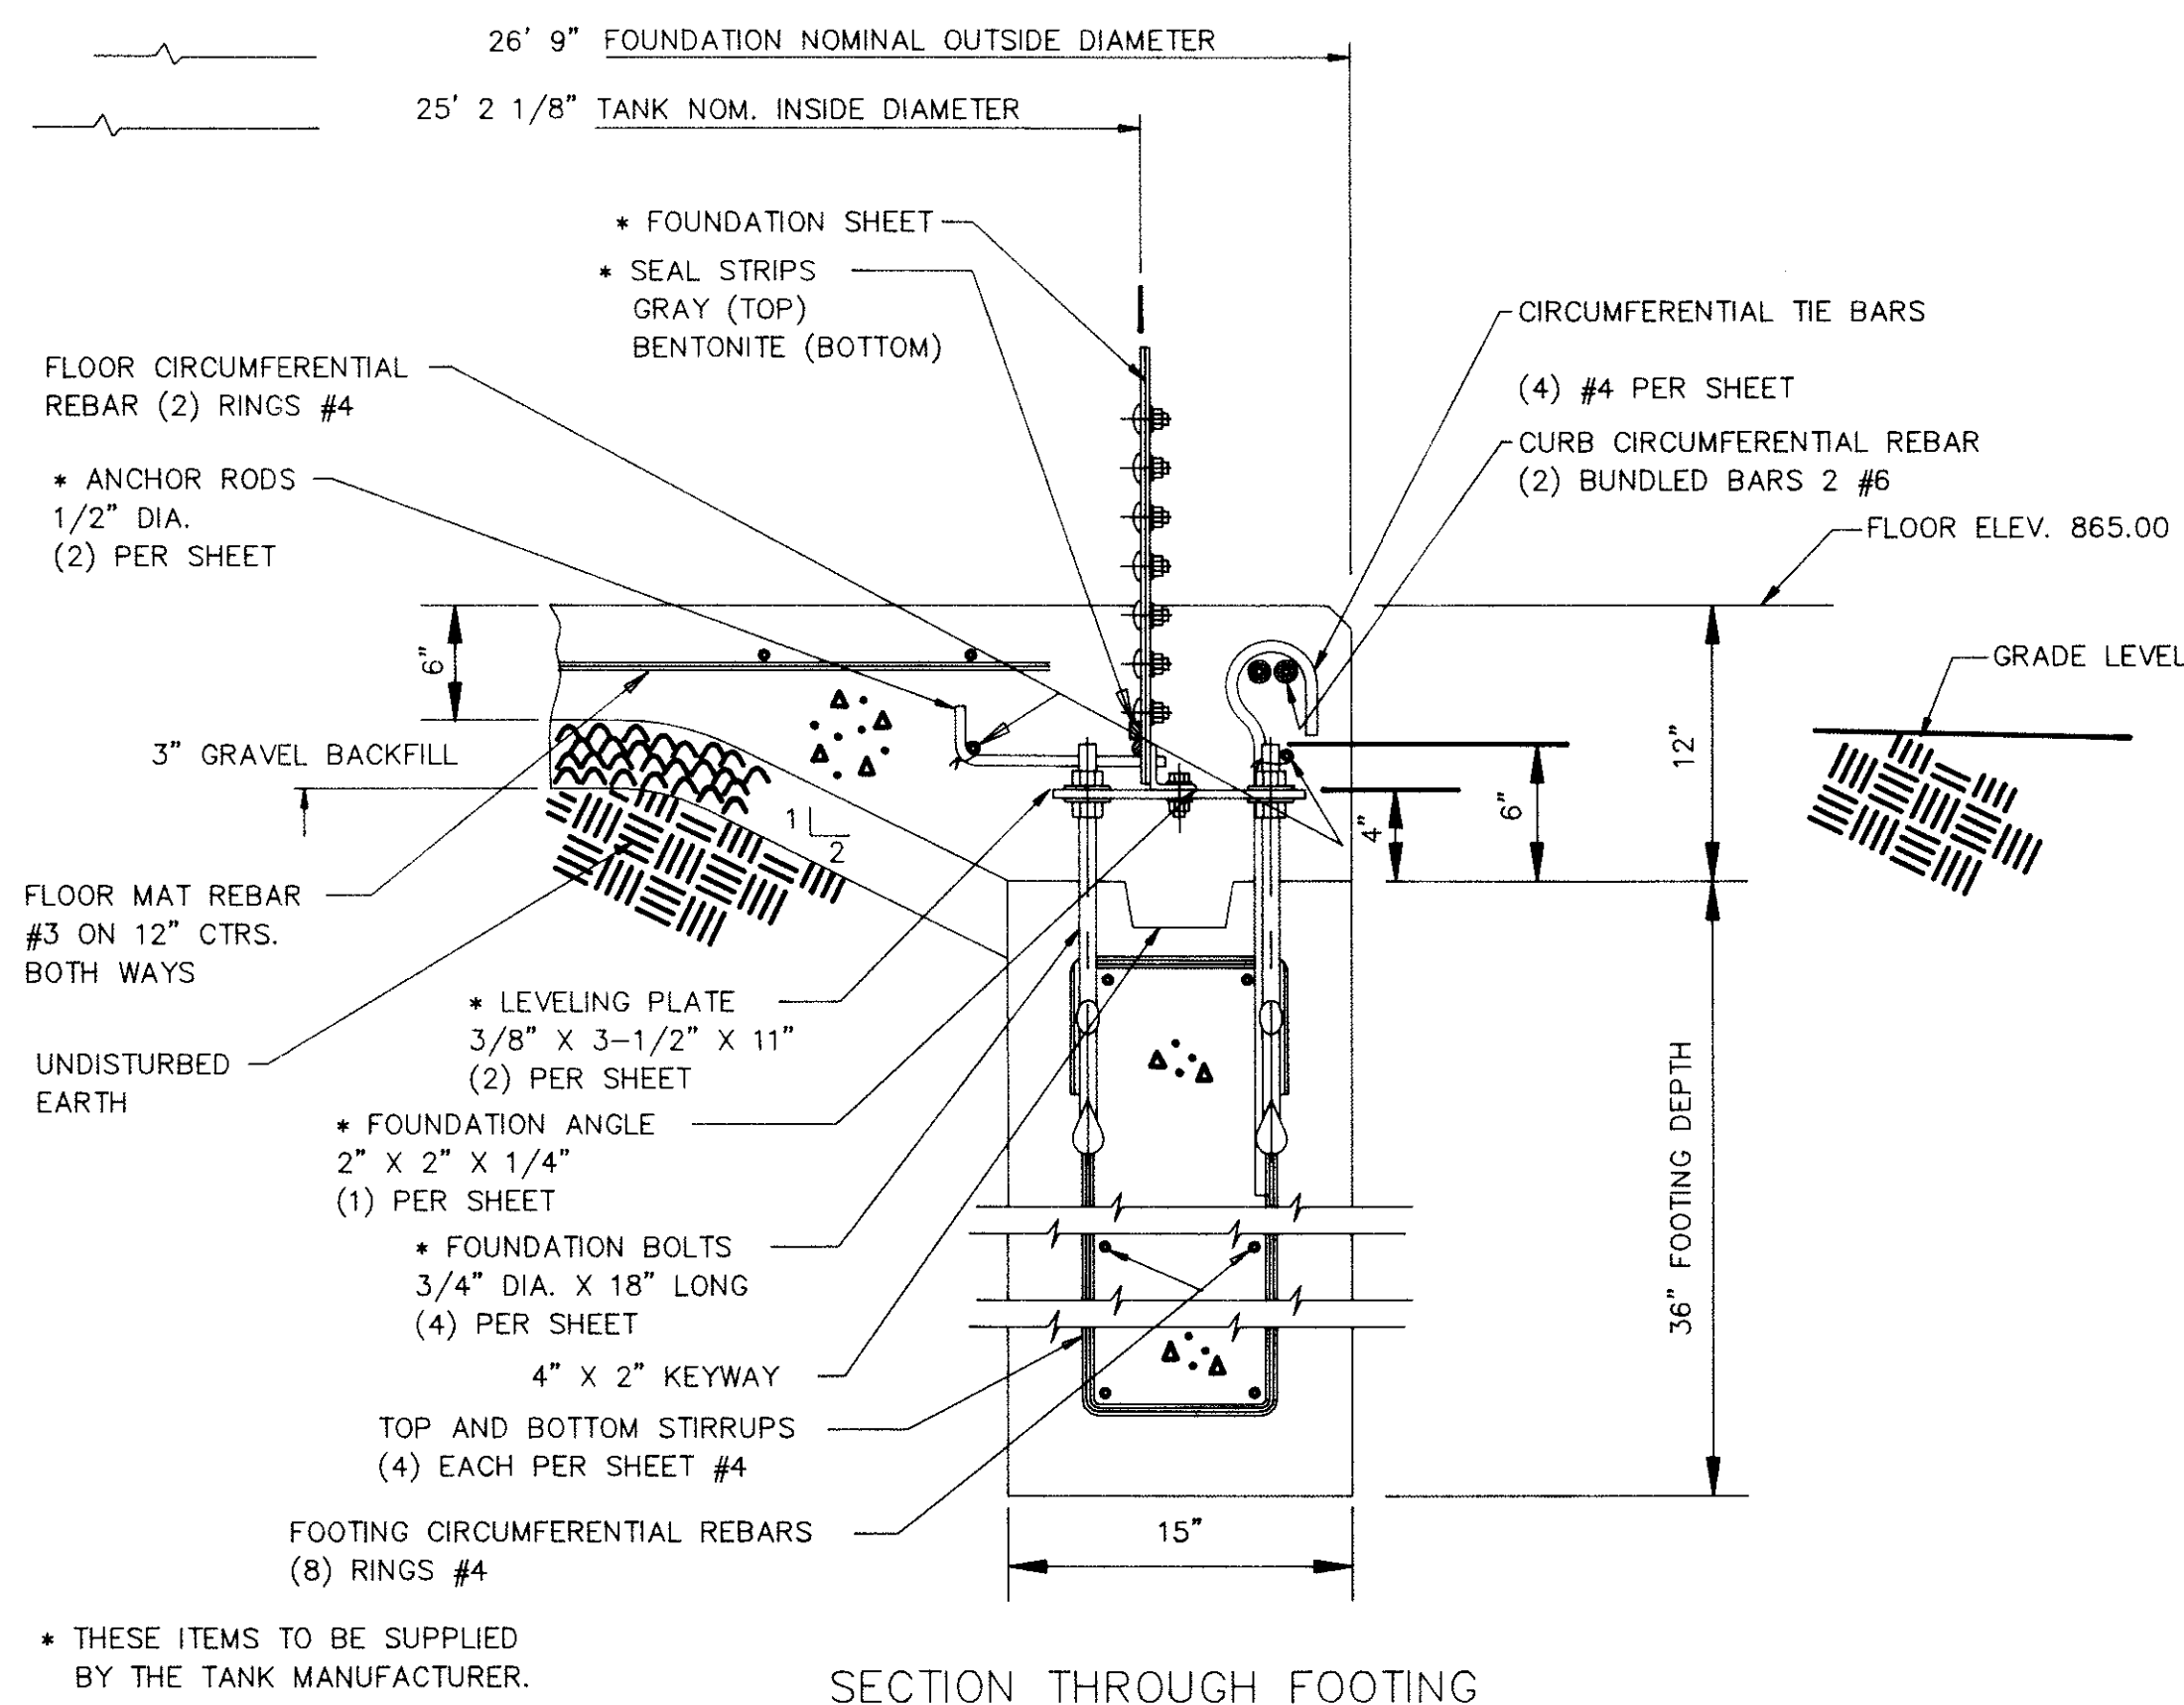


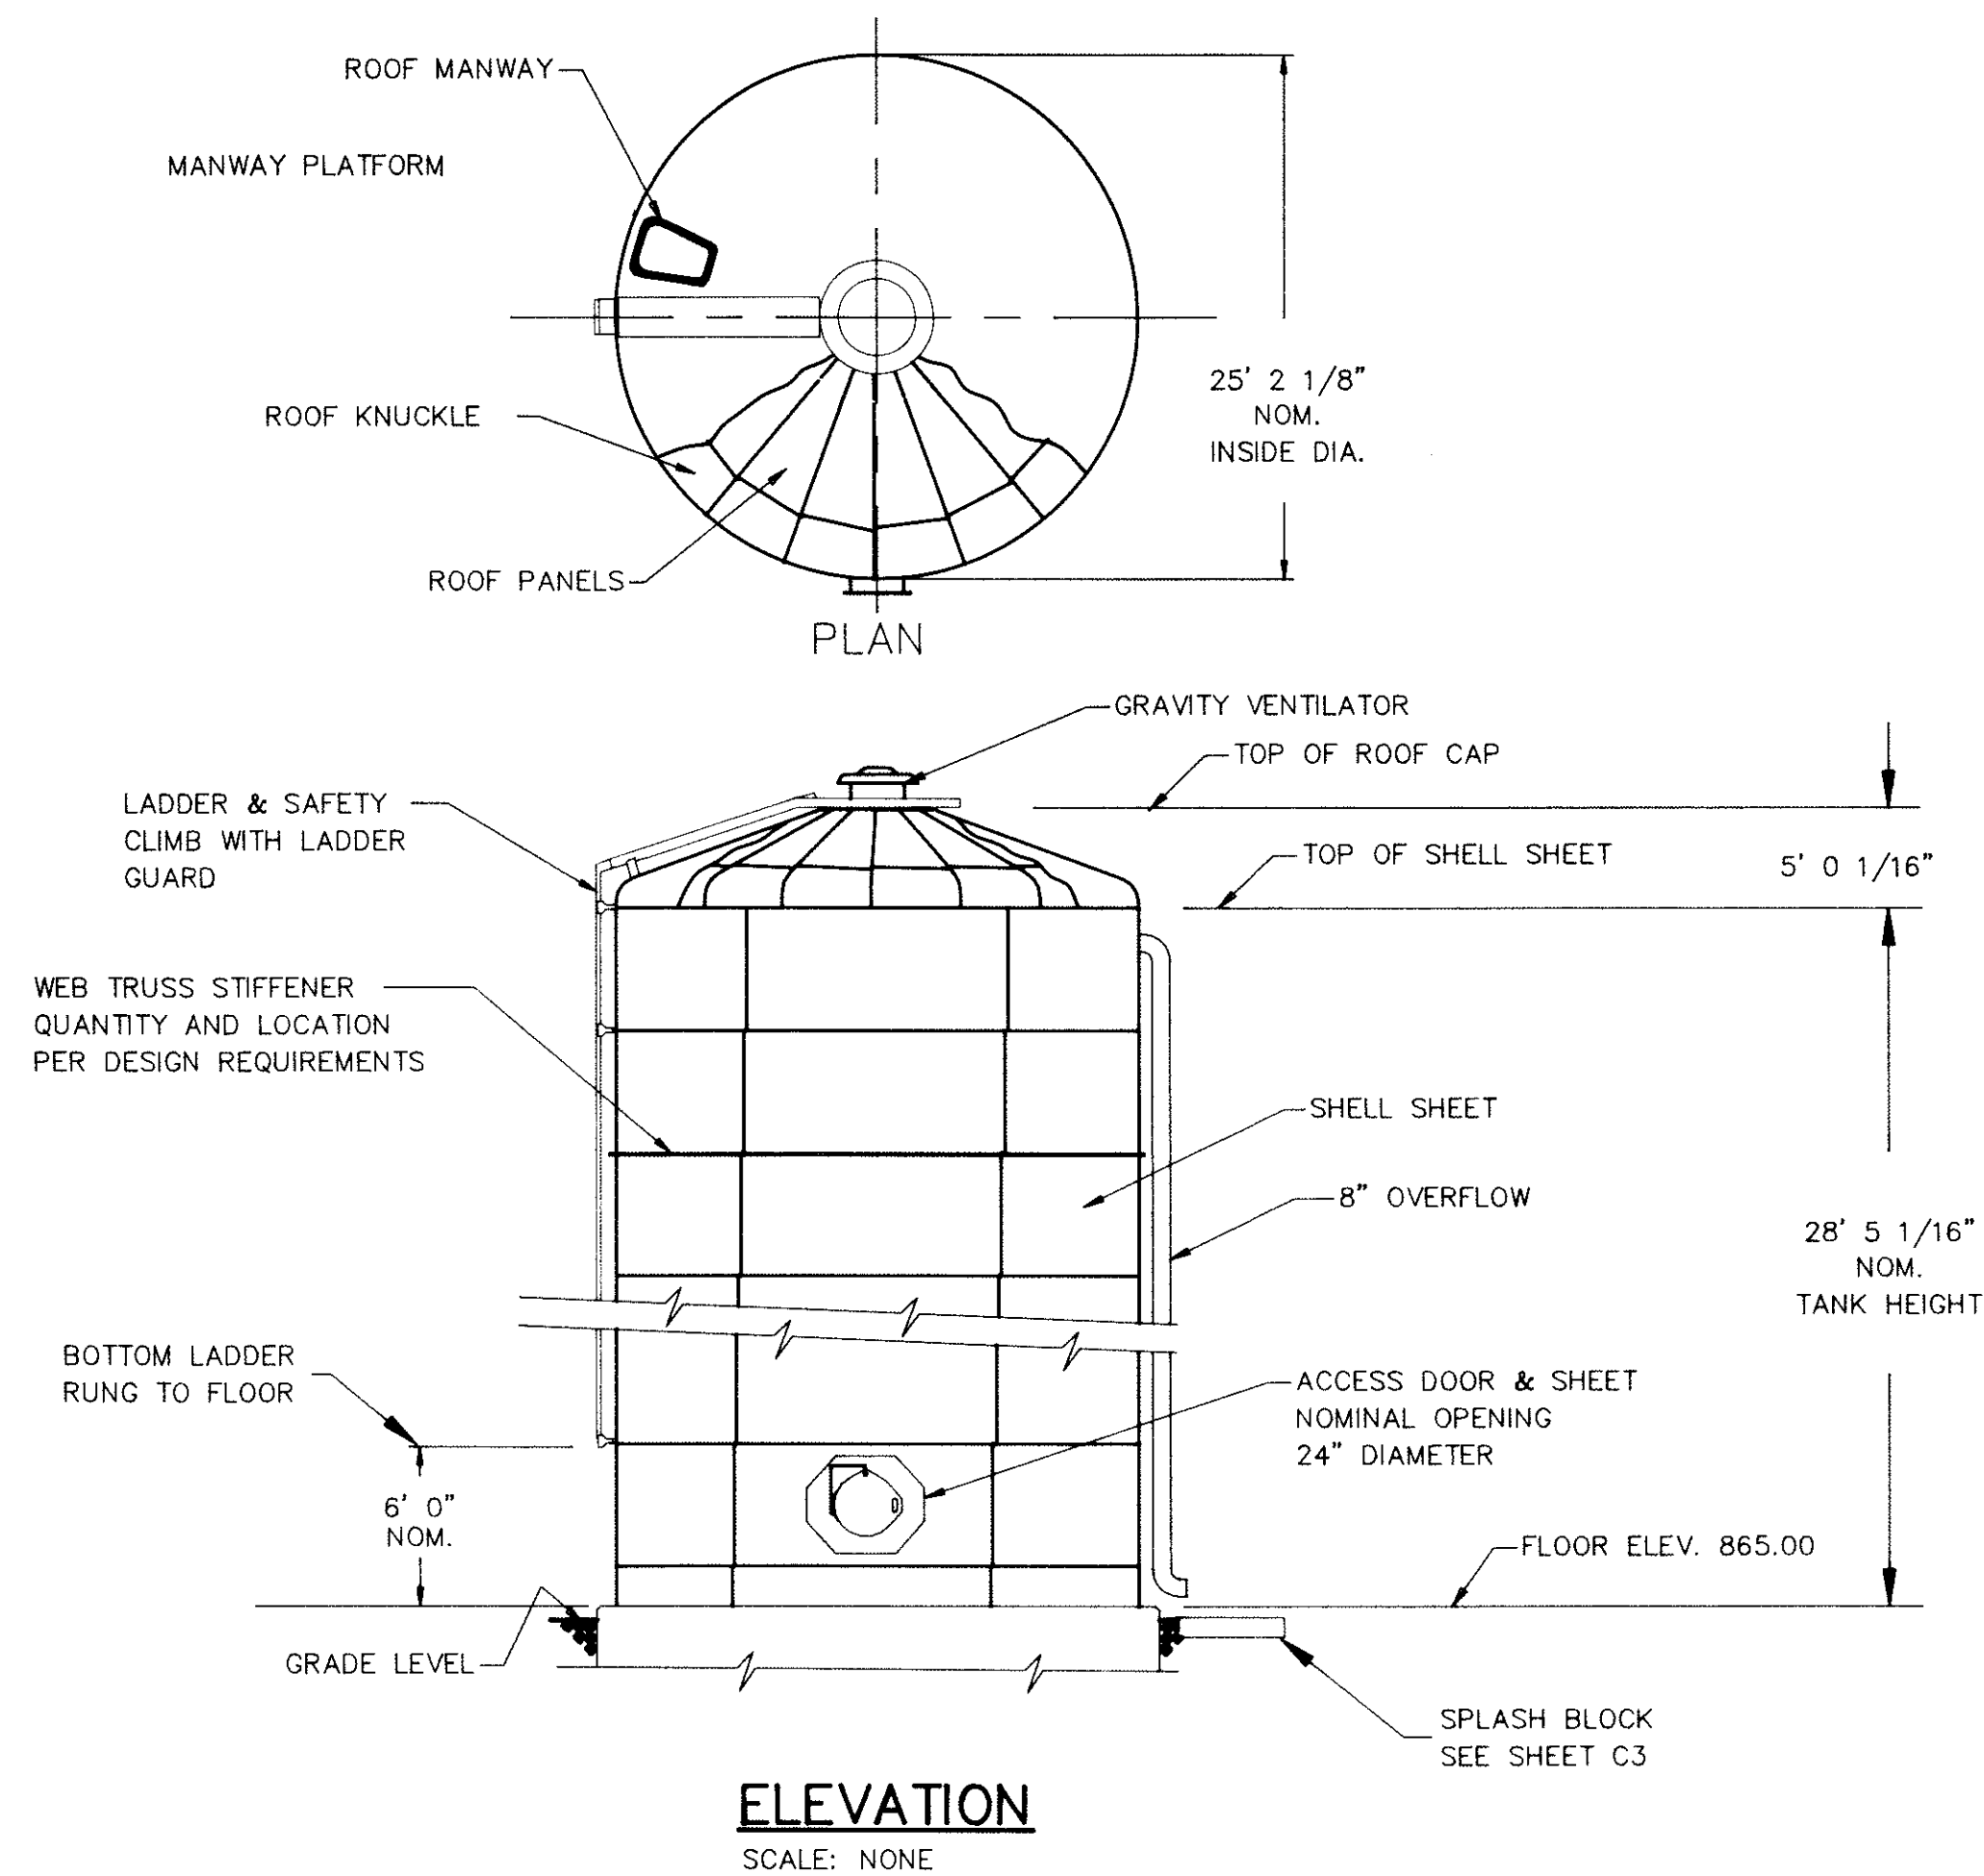


SECTION THROUGH FOOTING

FOUNDATION DETAIL
SCALE: NONE

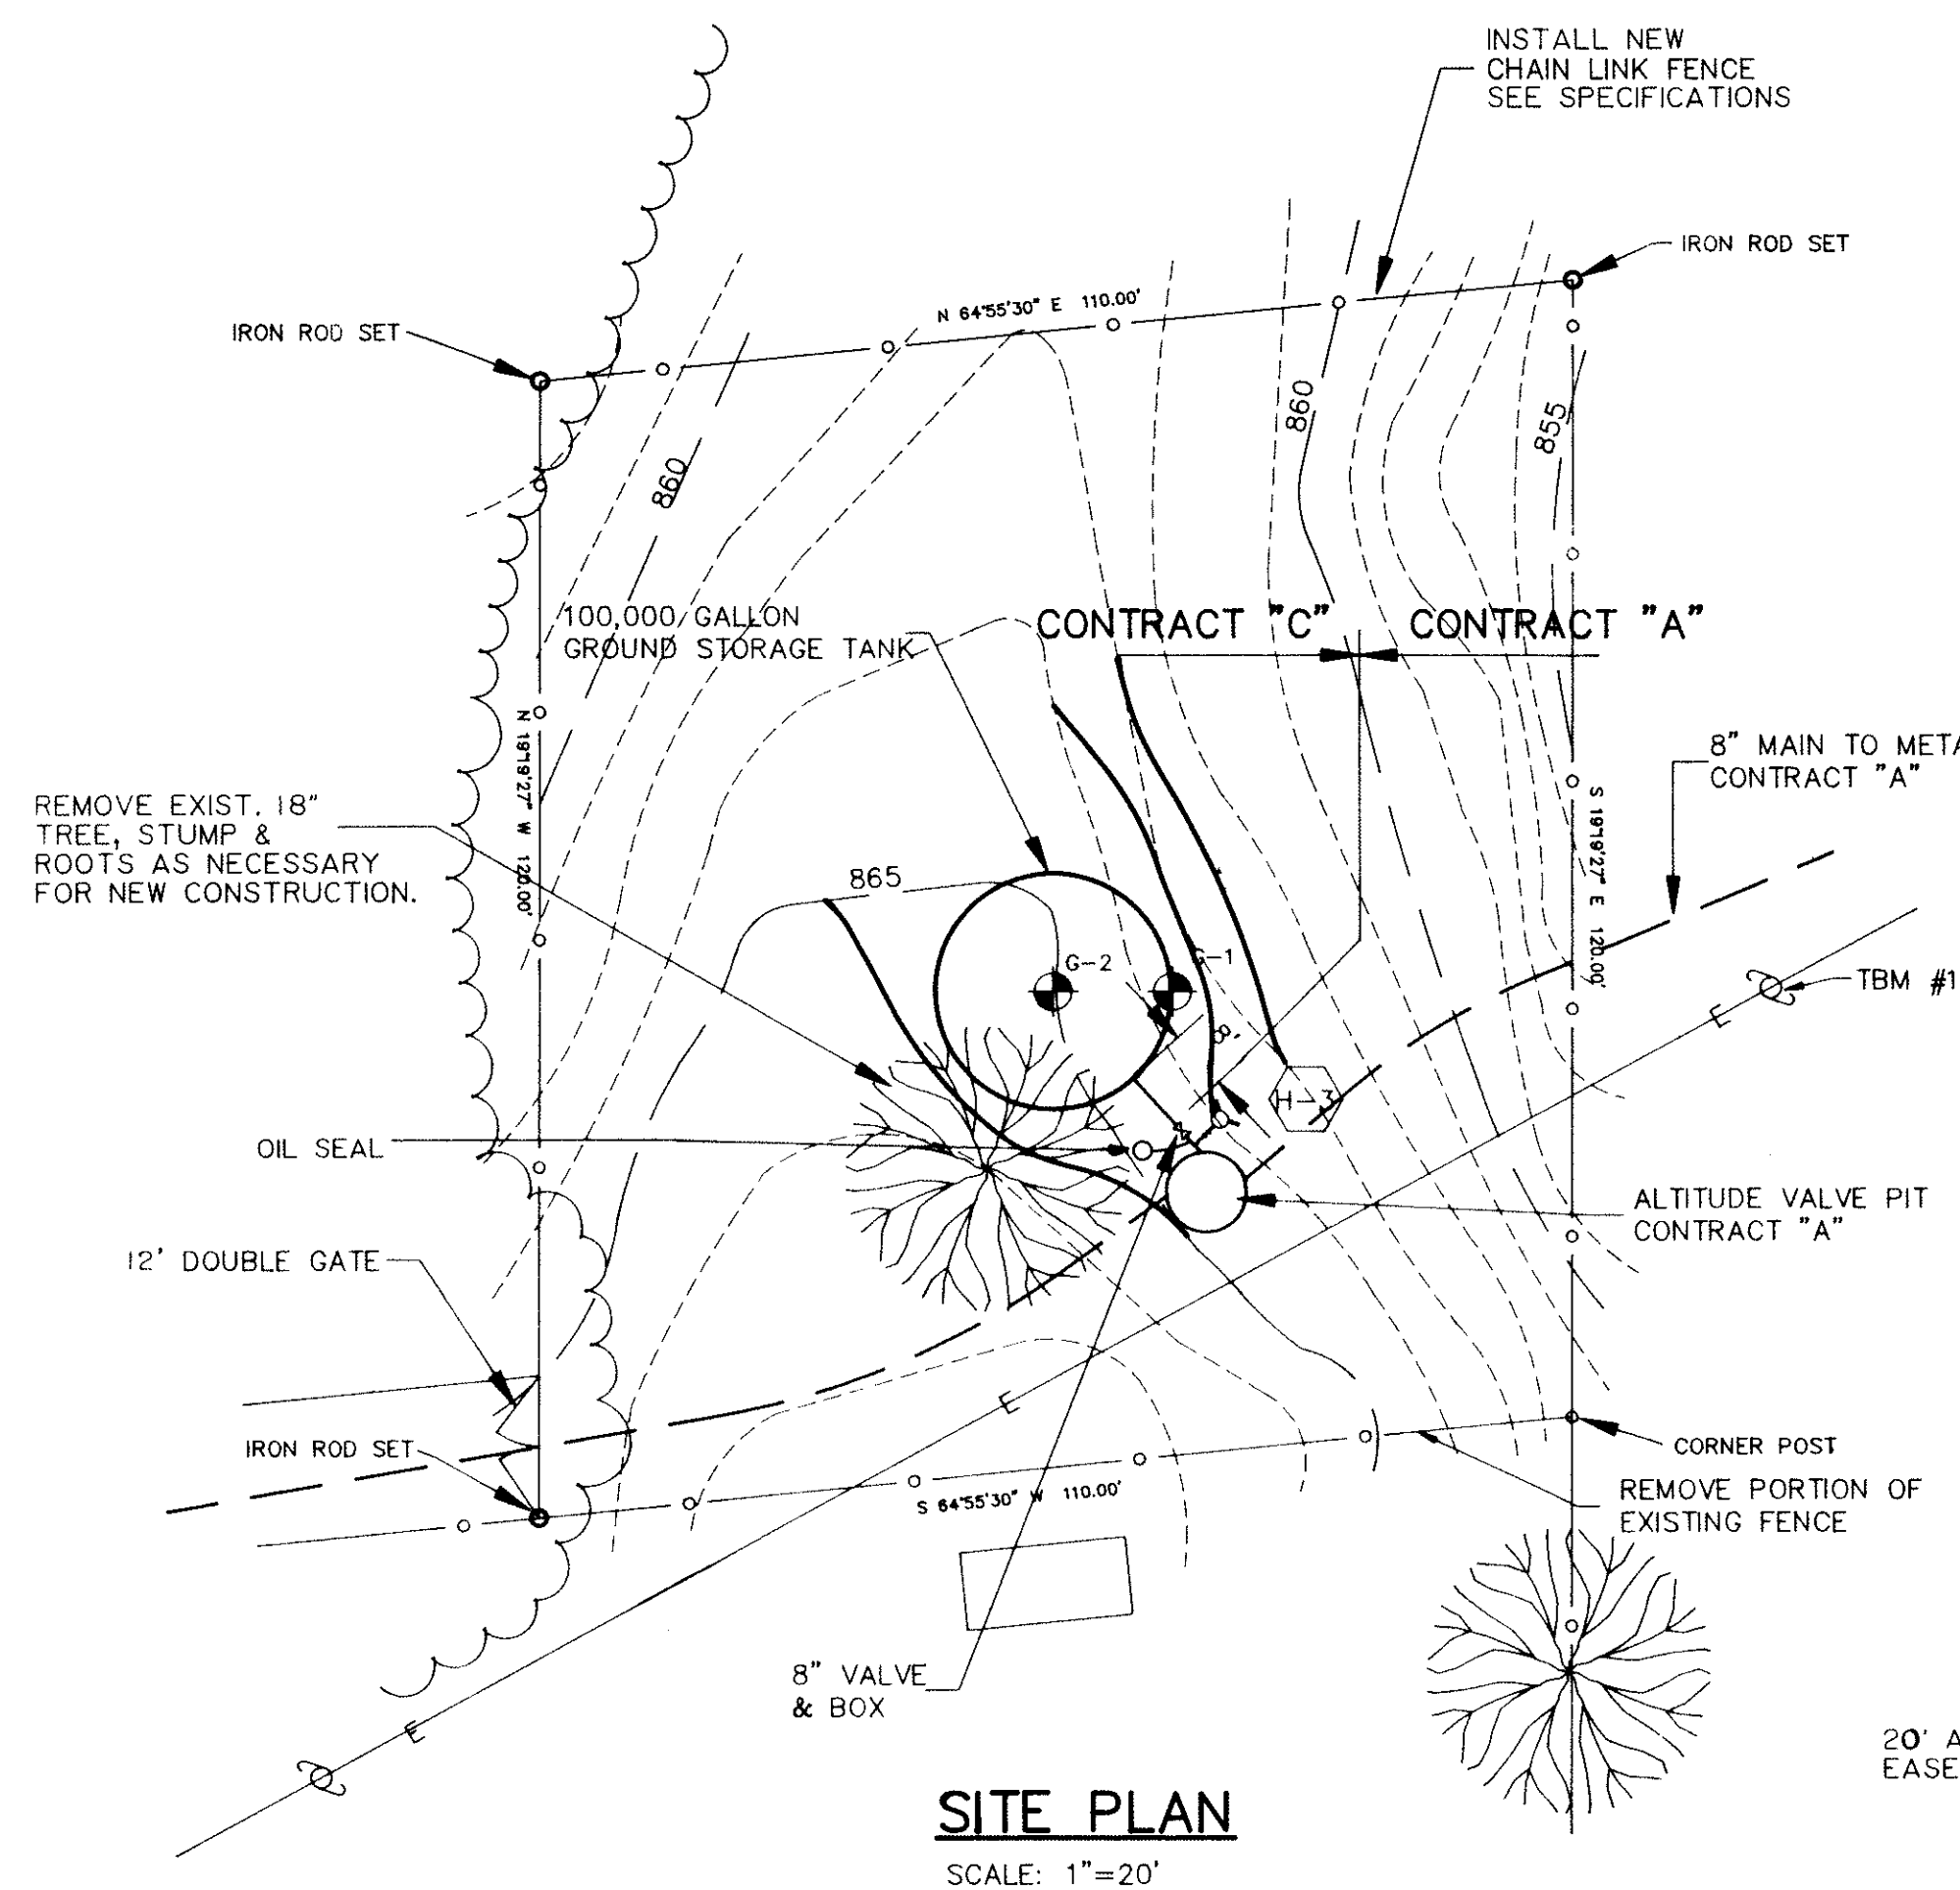

PLAN NOTES:

1. DETAILS AND SECTIONS SHOWN ARE FOR A GLASS LINED, BOLTED STEEL GROUND STORAGE TANK. THE CONTRACTOR IS RESPONSIBLE FOR THE COMPLETE DESIGN OF THE TANK AND FOUNDATIONS FOR THE TYPE OF TANK ACCEPTED BY THE OWNER FROM THE BIDS RECEIVED.
2. A COPY OF THE SOILS REPORT FOR THE SUBSURFACE INVESTIGATION IS INCLUDED IN THE SPECIFICATIONS.
3. CLEARING AND GRUBBING FOR ACCESS SHALL BE IN ACCORDANCE WITH EASEMENTS OBTAINED FOR ACCESS.

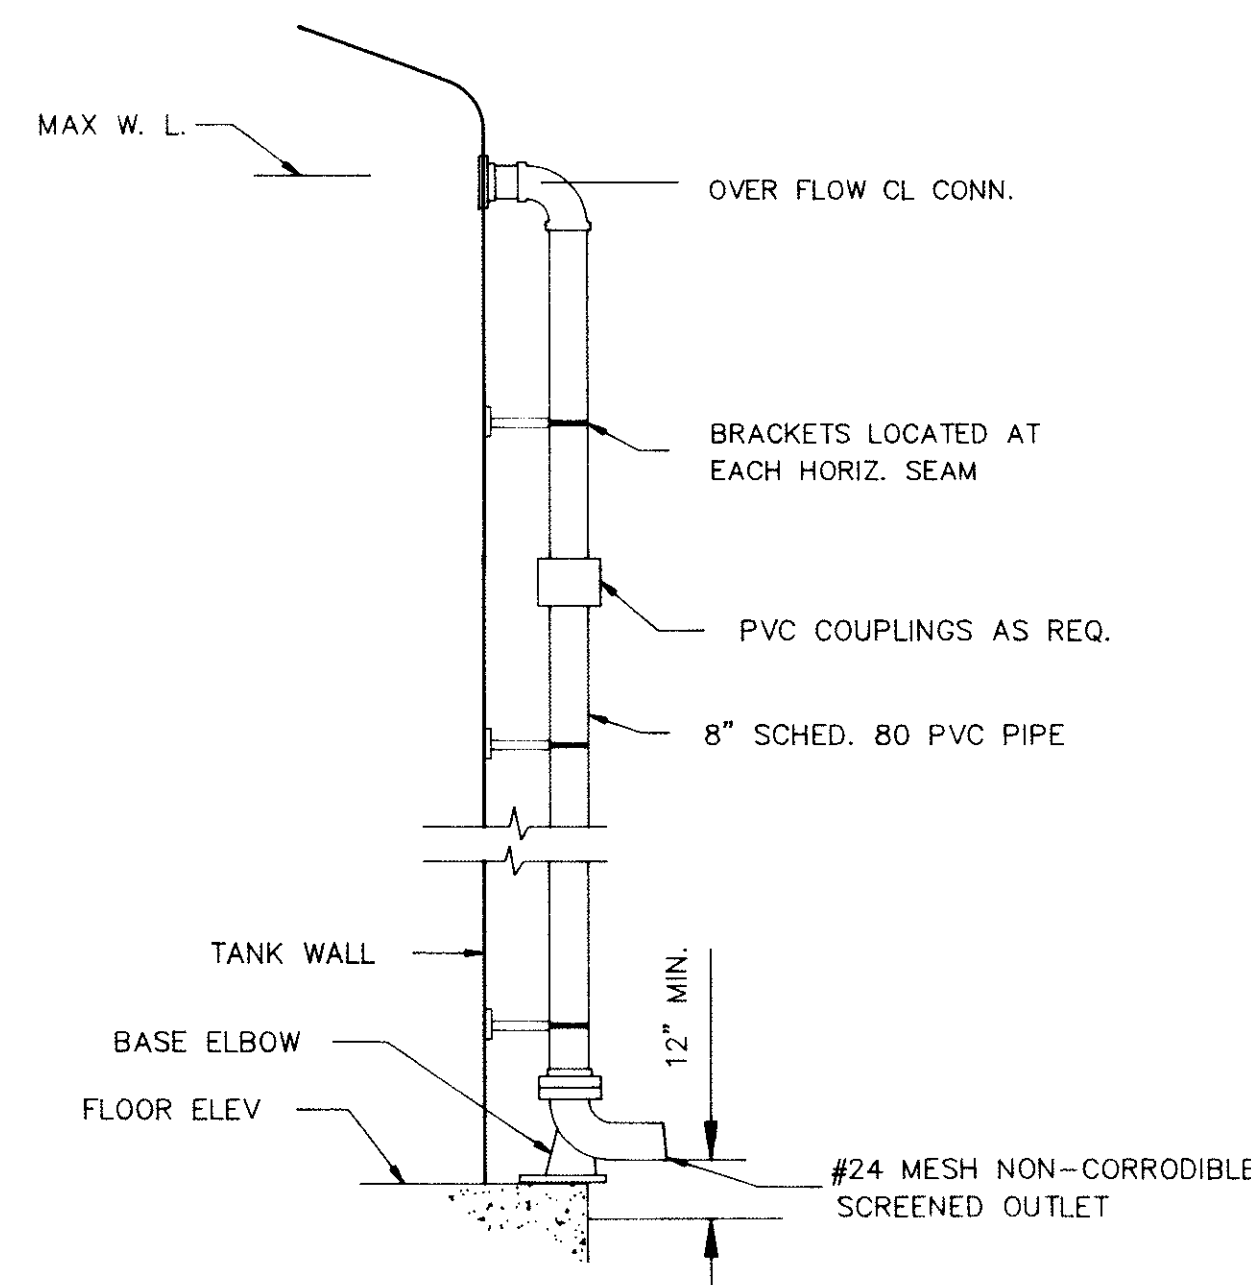

OVERFLOW PIPE DETAIL
SCALE: NONE

WILSON & AUDREY
PENNINGTON

CLEAR & GRUB ENTIRE LENGTH & WIDTH AS REQUIRED FOR ACCESS TO TANK SITE.

CHARLES NEELEY

SITE PLAN
SCALE: 1"=40'

BENCHMARK INFORMATION
TBM #1 RAILROAD SPIKE IN POWERPOLE
ELEV. 854.43

RECORD DRAWINGS
These drawings have been prepared from information by others. Engineer will not be responsible for errors and omissions in the information or records from which these drawings are produced.

CONTRACT "C"				CONTRACT "A"			
WATER STORAGE TANKS				WATER STORAGE TANKS			
100,000 GALLON GROUND TANK				100,000 GALLON GROUND TANK			
ELROD WATER COMPANY, INC.				ELROD WATER COMPANY, INC.			
DIVISION "E"				DIVISION "E"			
WATERWORKS SYSTEM IMPROVEMENTS				WATERWORKS SYSTEM IMPROVEMENTS			
SCALE:	DATE:	PROJECT NO.:	DRAWN BY:	APPROVED BY:	PLOTTED:	CAD FILE:	
AS SHOWN	OCT 14, 1993	37391.04	C.L.G.	D.G.C.	1/25/94	373-CADWG	
NOT PUBLISHED ALL RIGHTS RESERVED				EXCEPT FOR USES EXPRESSLY PERMITTED IN WRITING, INFOR- MATION SHOWN OR INCLUDED IN THIS DOCUMENT IS SOLELY THE PROPERTY OF M.D. WESSLER & ASSOCIATES, INC.			
M.D. WESSLER and ASSOCIATES CONSULTING ENGINEERS				6219 South East Street, Suite A Indianapolis, Indiana 46227-2148			
RECORD DRAWINGS				RECORD DRAWINGS			
2 12/9/96 C.L.G.				2 12/9/96 C.L.G.			
1 3/4/94 C.L.G.				1 3/4/94 C.L.G.			
NO.				NO.			
DATE				DATE			
BY				BY			
REVISIONS				REVISIONS			
REMOVE ELECTRICAL PLAN THIS SHEET				REMOVE ELECTRICAL PLAN THIS SHEET			
SHEET C4				SHEET C4			
OF 4				OF 4			