



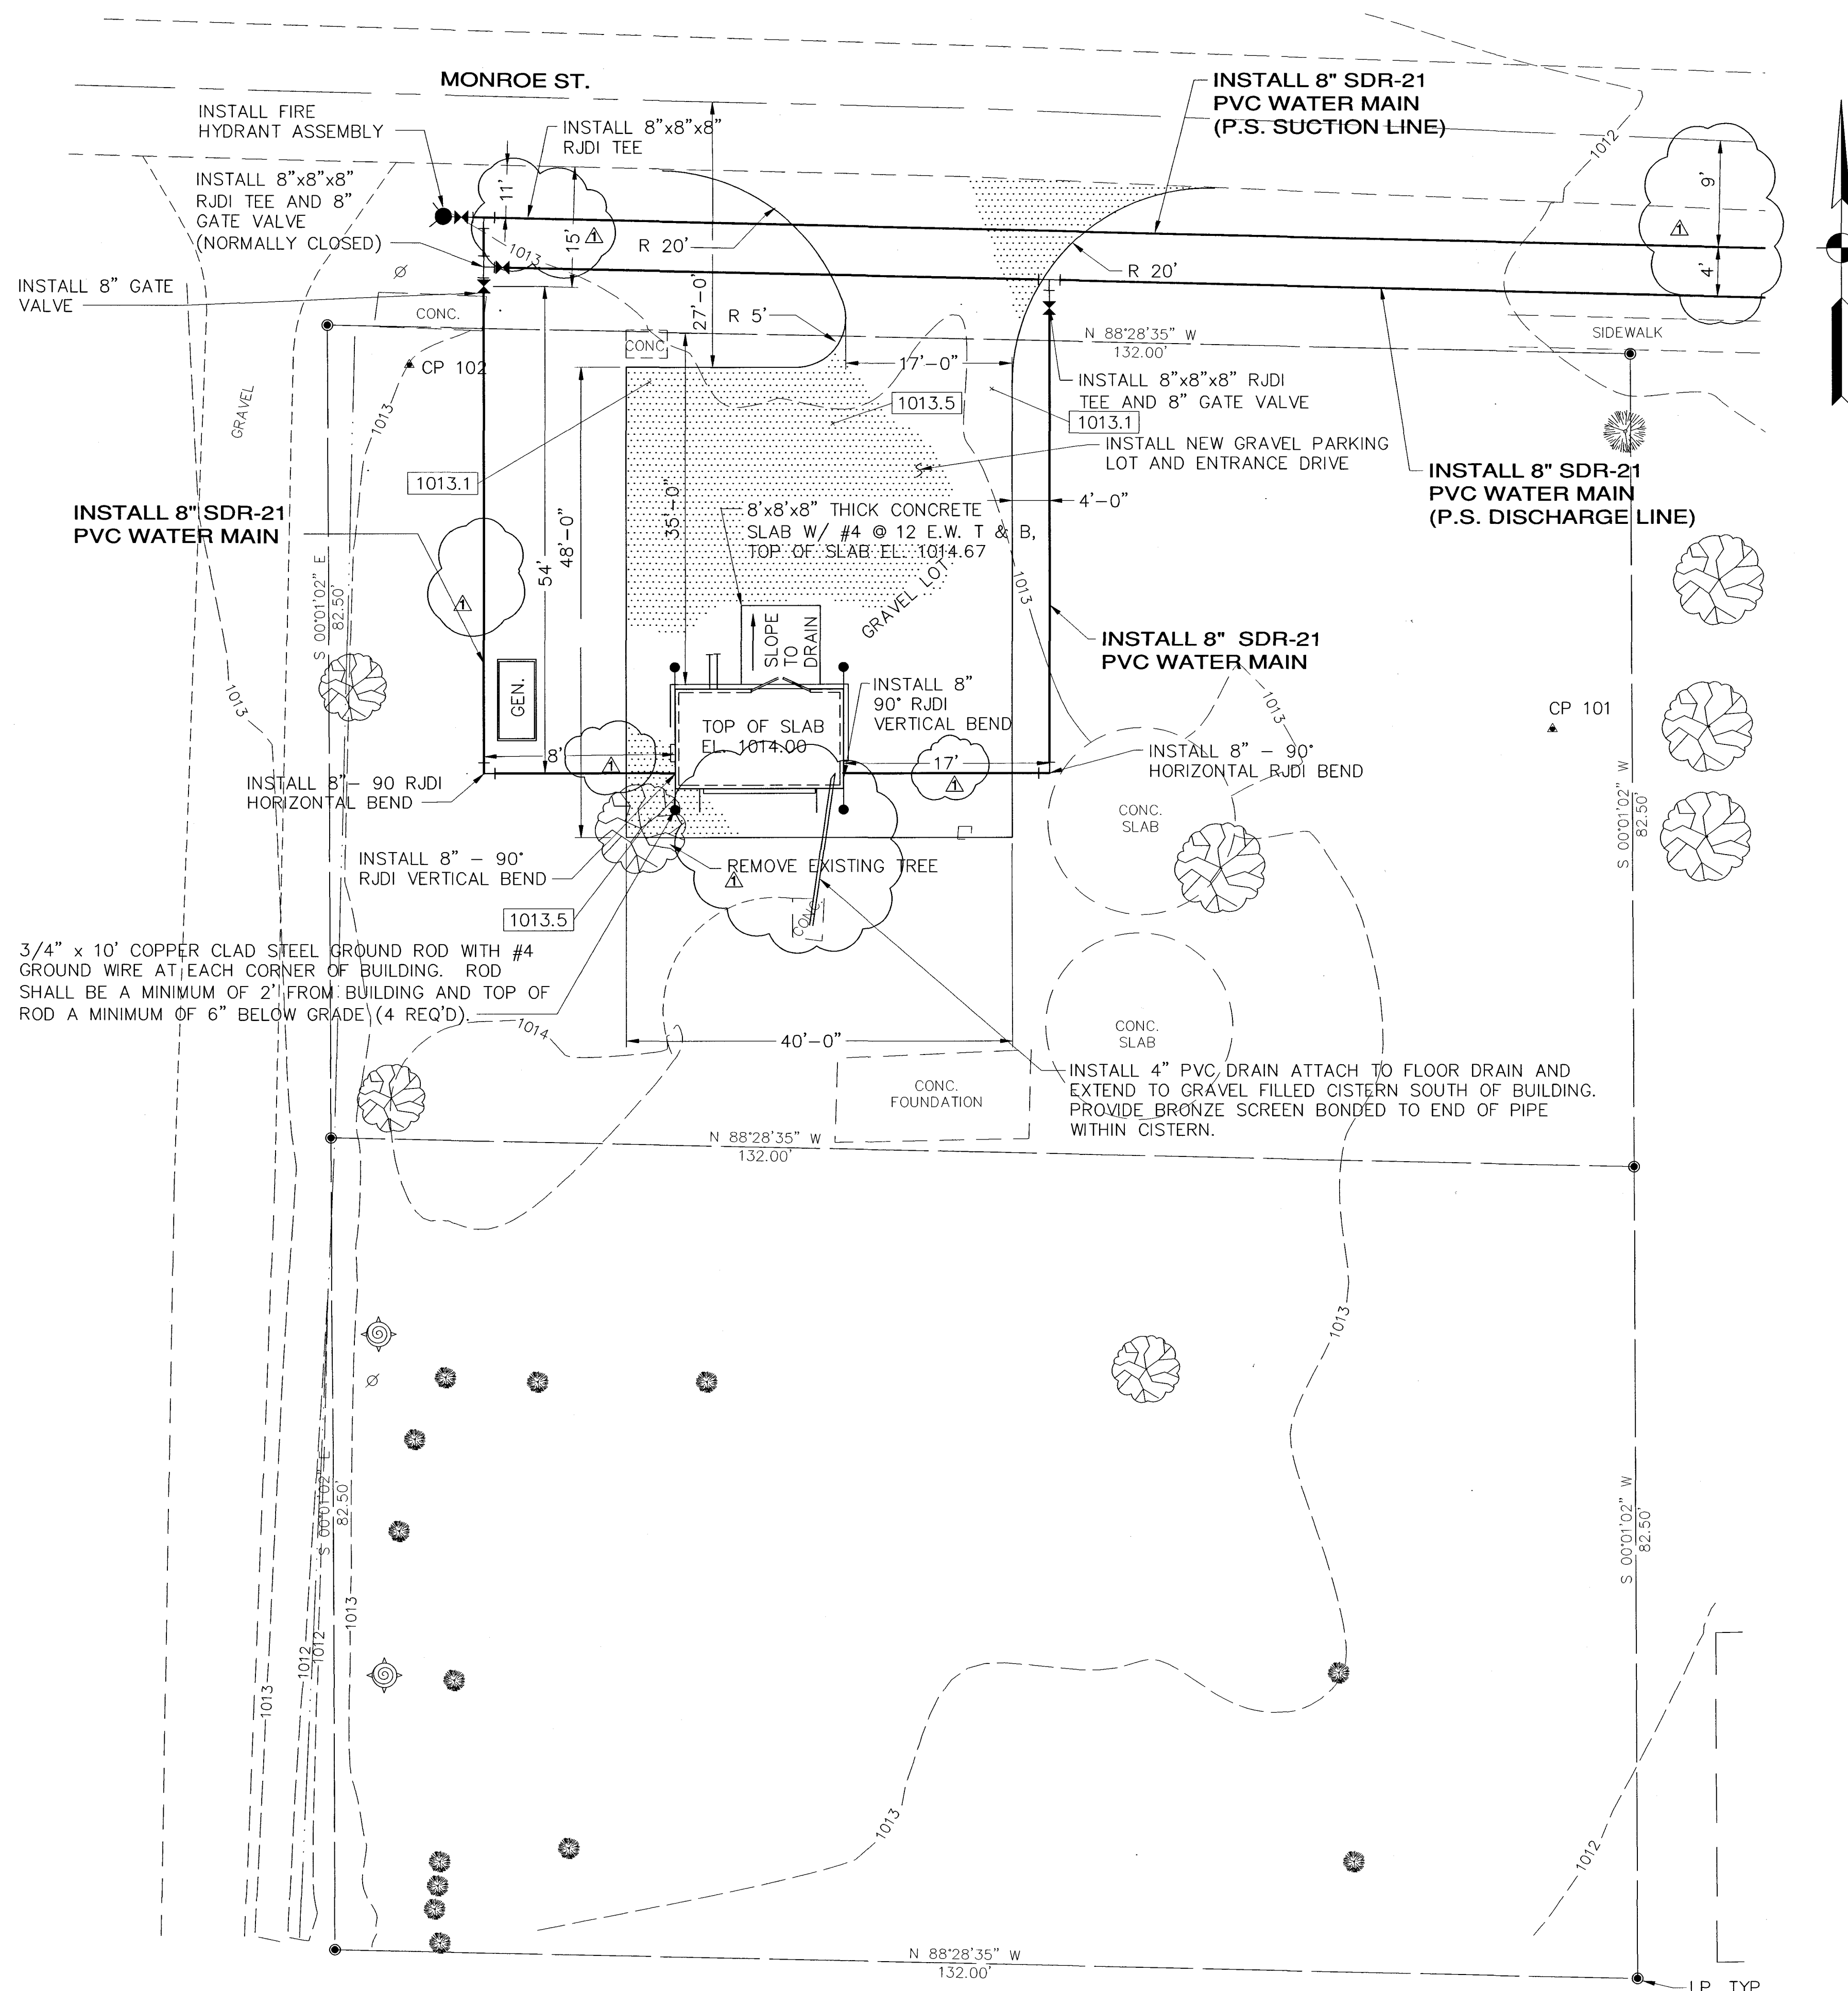

SEE SHEET 525 FOR WATER MAIN CONTINUATION

- NOTES:
1. CONTRACTOR SHALL PROVIDE POSITIVE DRAINAGE FROM THE PUMP STATION THRU GRAVEL PARKING AREA TO THE REST OF THE SITE.
 2. SEE SHEETS 544 & 545 FOR PUMP STATION FOUNDATION & DETAILS.

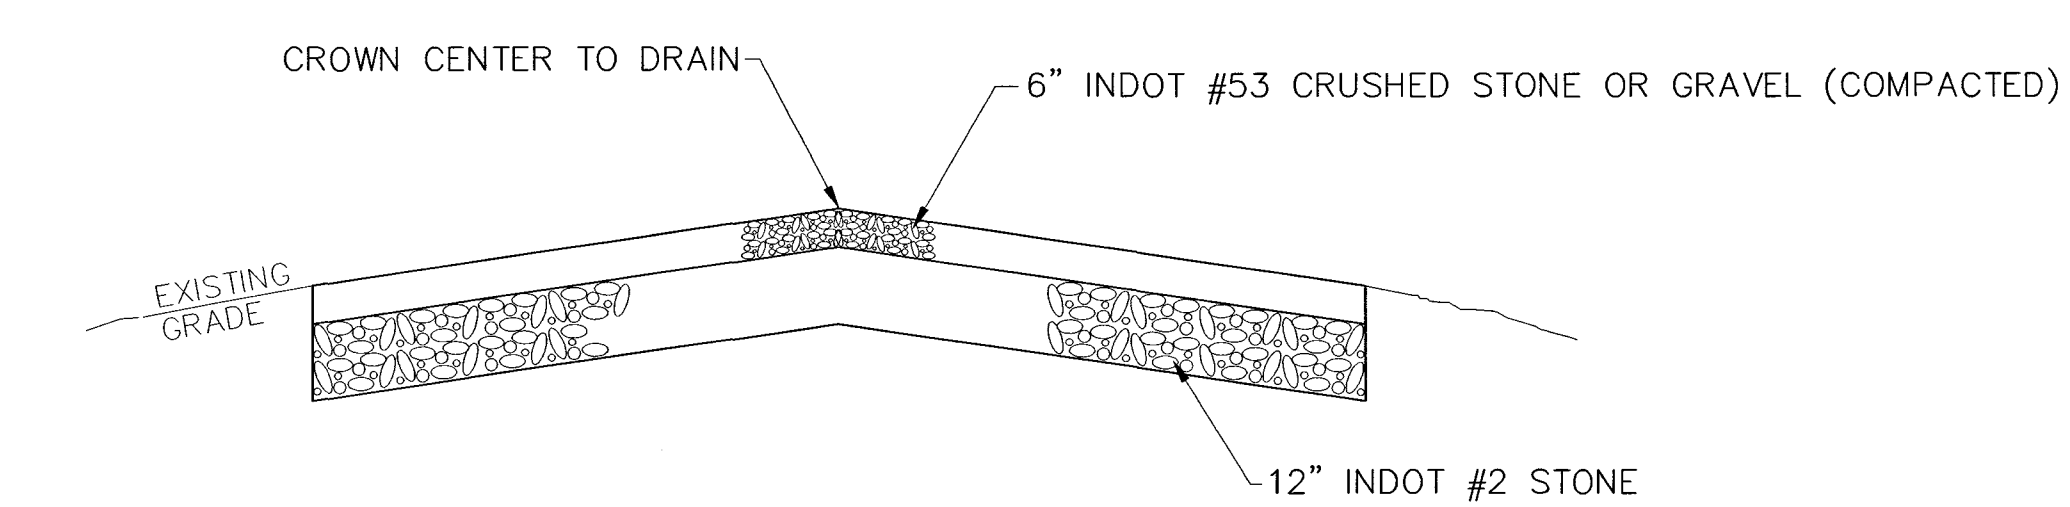

NOTE: ROAD AND PARKING AREA SHALL BE INSTALLED TO PROVIDE POSITIVE DRAINAGE AWAY FROM THE PUMP STATION.

ACCESS DRIVE & PARKING AREA

SCALE: N.T.S.


RECORD DRAWING	
This drawing has been released from the original contract drawings to show minor/major changes made during construction. This drawing is not warranted to be complete and accurate in all respects.	
GRW Engineers, Inc.	
Date: 5/2004	By: MSB

SECTION
SCALE: 1" = 10'

NOTES:

NO.	DESCRIPTION	DATE	BY
1	AS-BUILT REVISIONS	5/2004	MSB
REVISIONS			

HOOSIER HILLS REGIONAL
WATER DISTRICT
DIVISION "F" WATERWORKS SYSTEM IMPROVEMENTS
CONTRACT F-1
PIERCEVILLE PUMP STATION SITE PLAN
GRW PROJECT NO. 2745-04

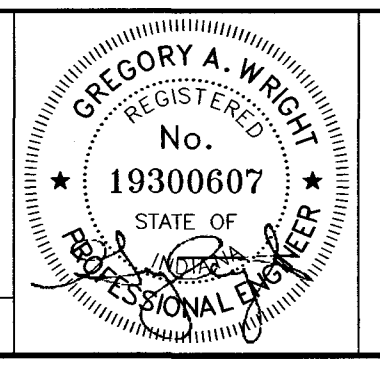

GRW Engineers, Inc.
Engineers, Architects, Planners
INDIANAPOLIS, INDIANA
LOUISVILLE & LEXINGTON, KENTUCKY
CINCINNATI, OHIO
NASHVILLE, TENNESSEE
ARLINGTON, TEXAS

DRAWN: BJD	DATE: JULY 2002
FILE NAME: Sheet543.dwg	SCALE: 1"=10'
CHECKED:	SHEET NO.
APPROVED:	543

I:\2745\dwg\F-1\Record Dwg\Sheet 543.dwg, 11/8/2004, 9:55:21 AM