


DELETED

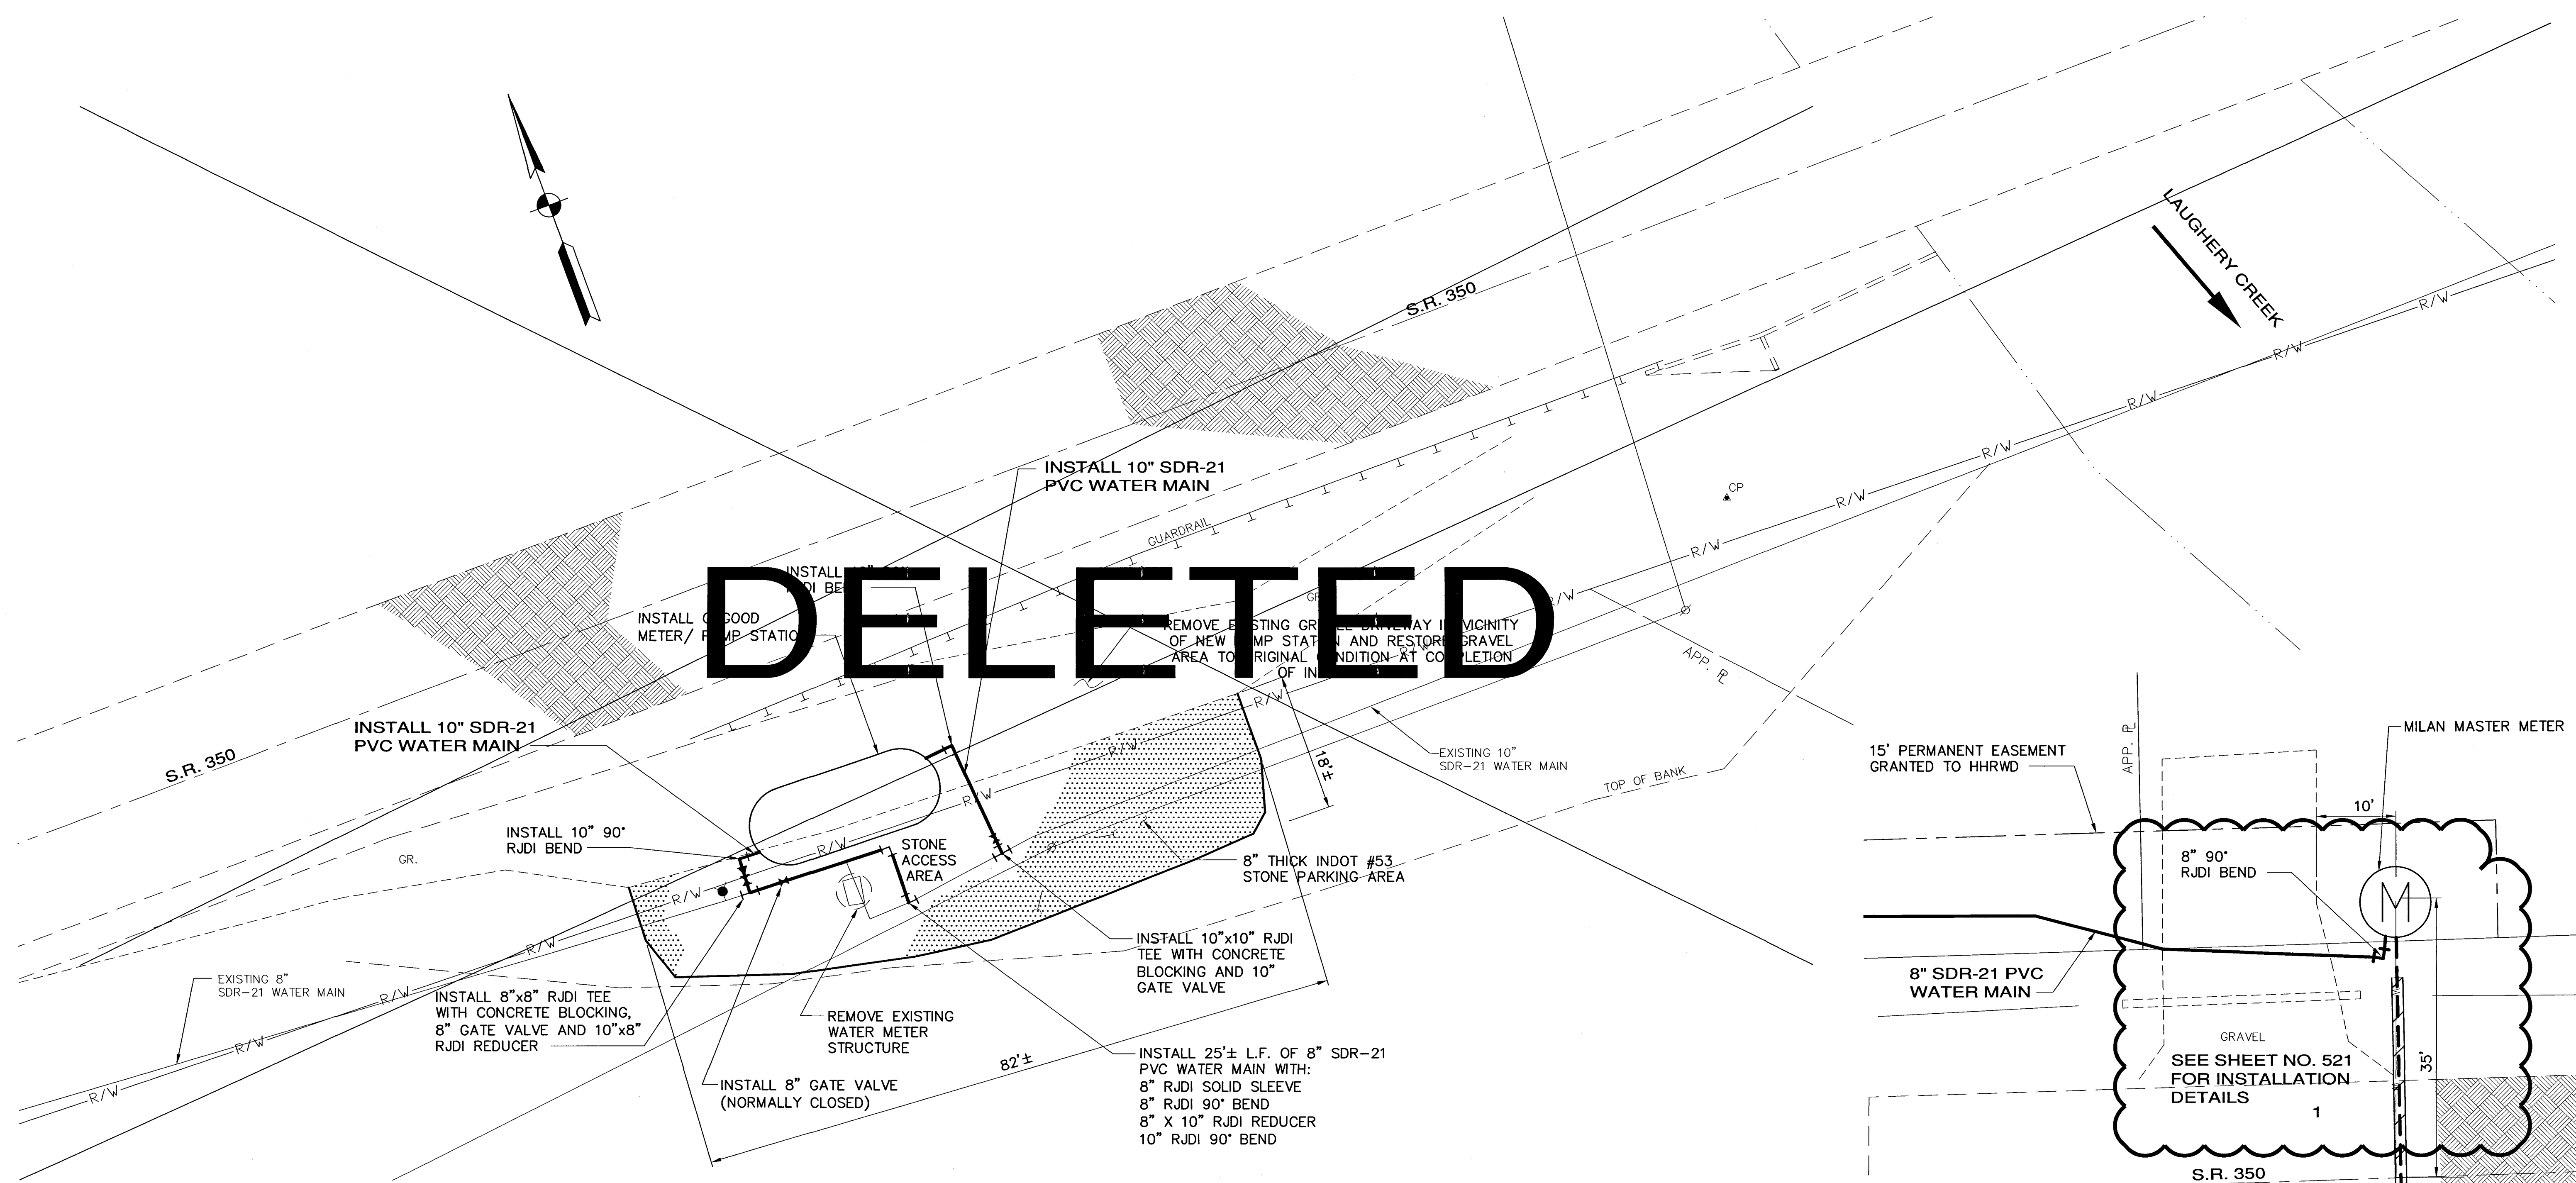

OSGOOD METER/PUMP STATION SITE PLAN

SCALE: 1"=10'


SEE SHEET 547 FOR OSGOOD  
METER/PUMP STATION DETAILS.

RECORD DRAWING

This drawing has been revised from the original  
contract drawing to show minor/modifier changes made  
during construction. This drawing is not warranted to  
be complete and accurate in all respects.

GRW Engineers, Inc.

Date: 5/2004 By: MSB

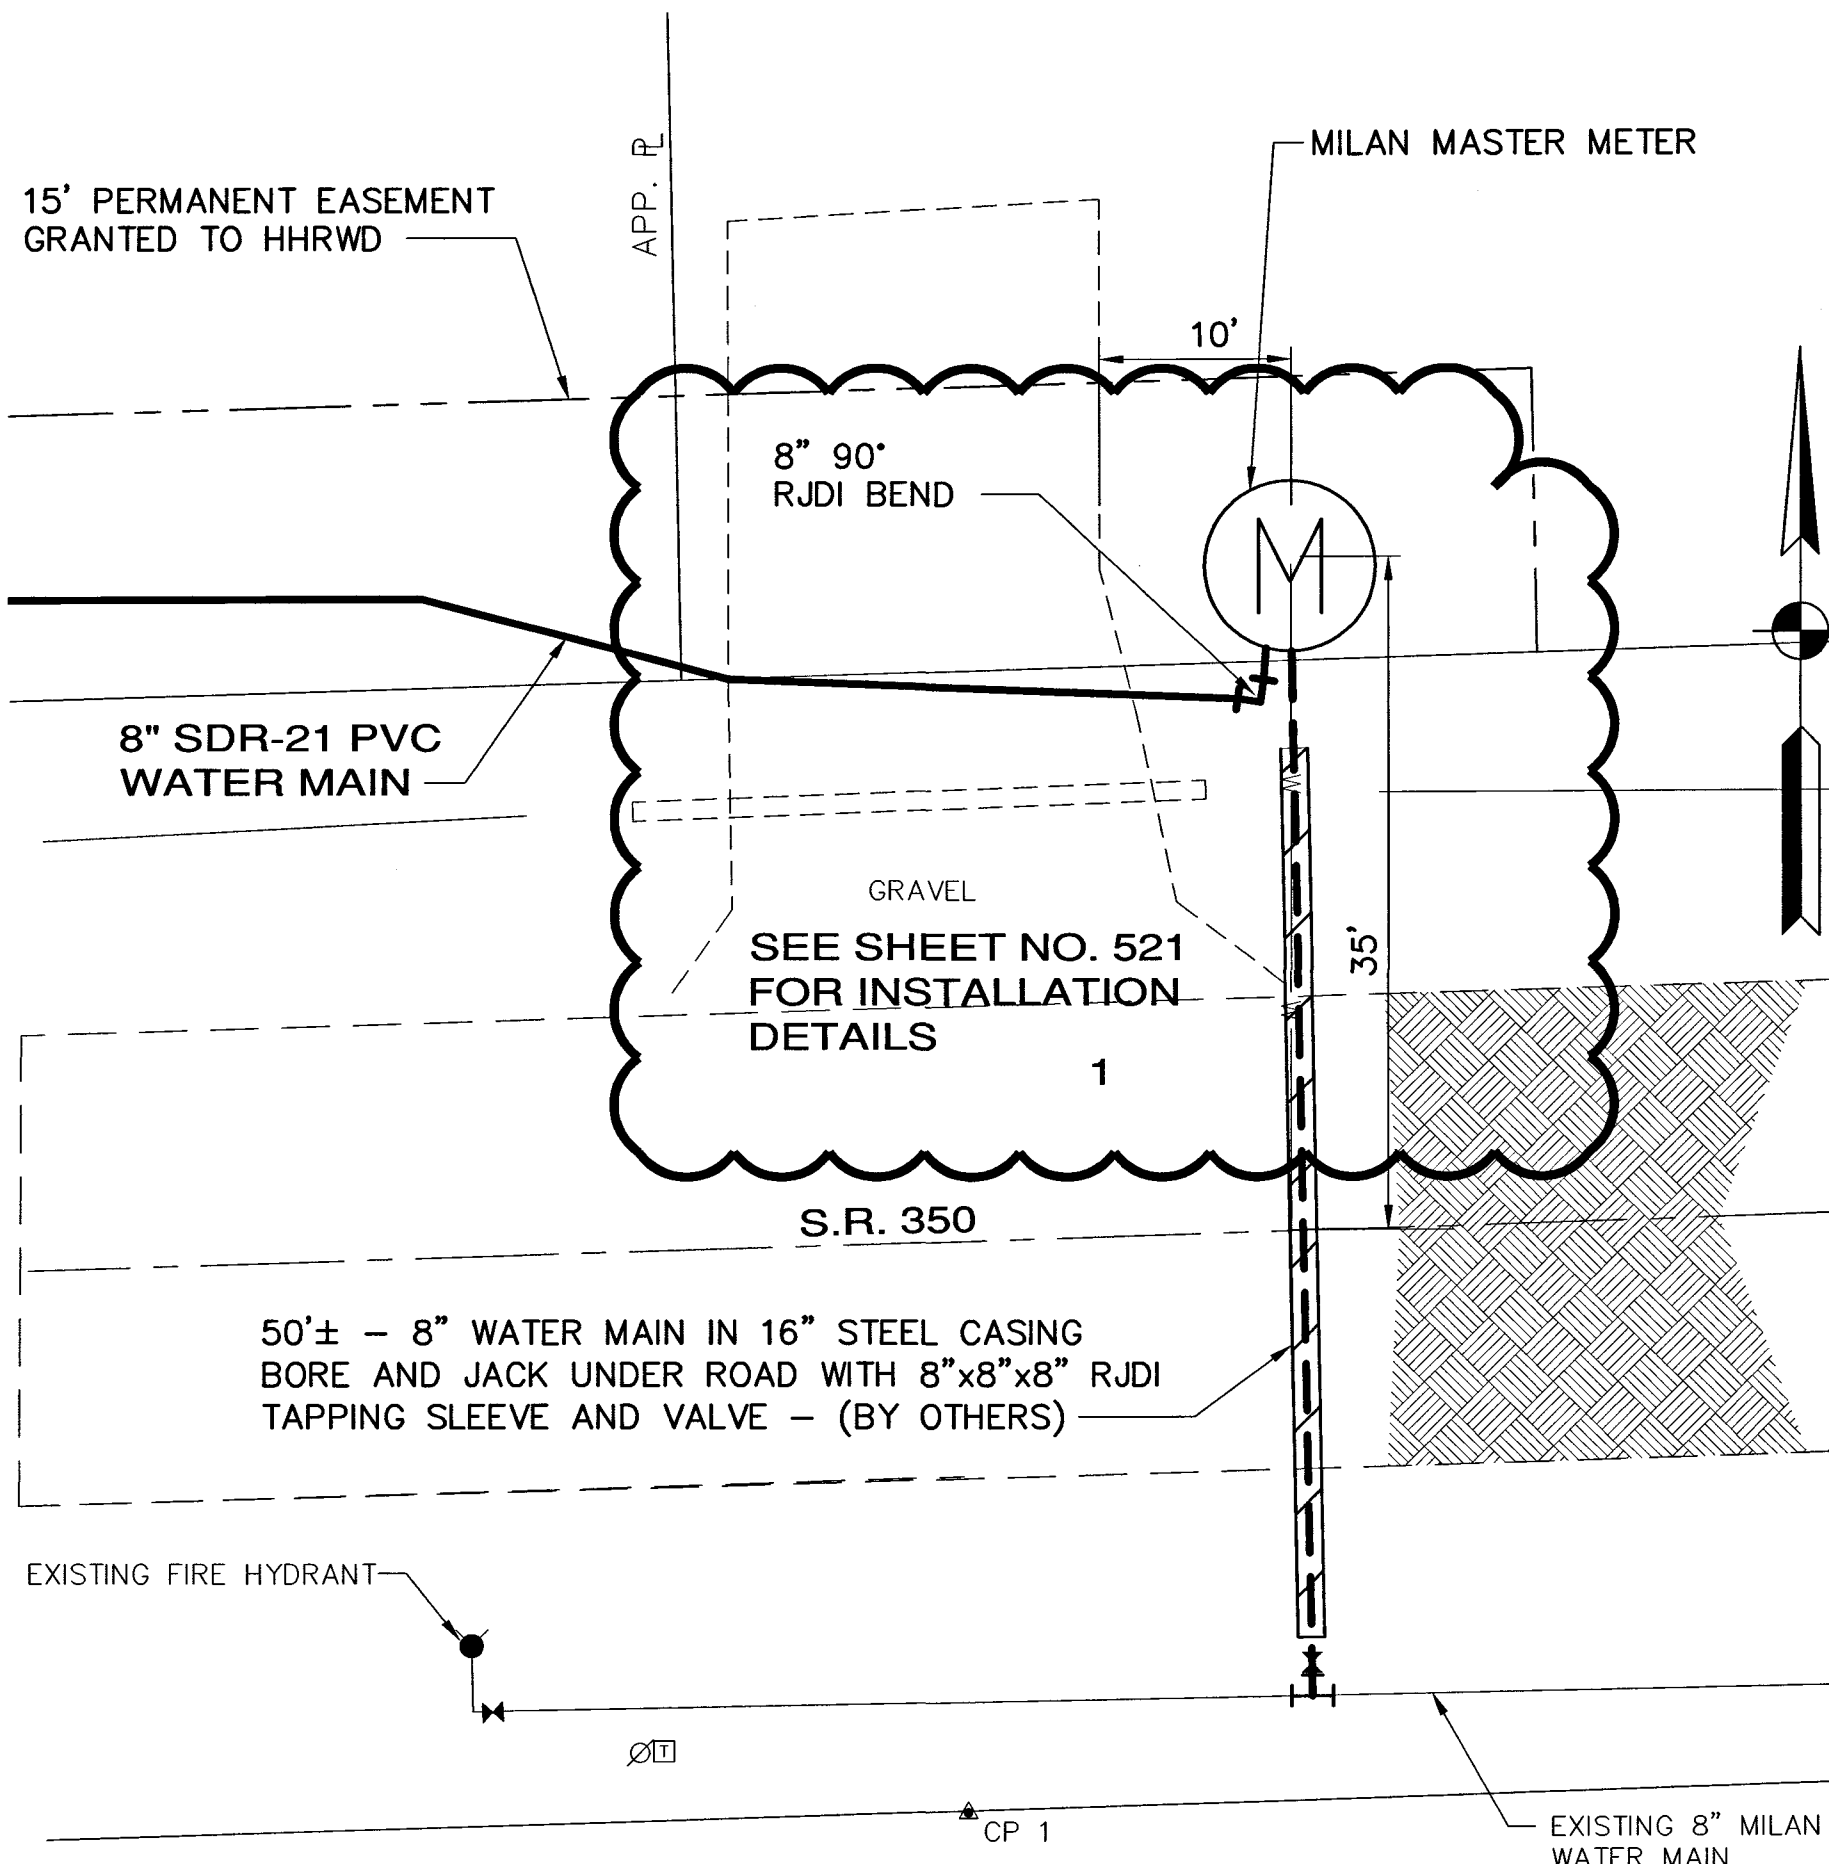

MILAN MASTER METER VAULT SITE PLAN


SCALE: 1"=10'

SEE SHEET 548 FOR MILAN MASTER METER VAULT  
DETAILS & SHEET 521 FOR LOCATION.

NOTES: 1. CONTRACTOR SHALL REMOVE EXISTING METER VAULT AND INSTALL NEW METER VAULT/ PUMP STATION WITHIN A 30 CALENDAR DAY PERIOD OF CONSTRUCTION. OWNER SHALL ISOLATE THE EXISTING METER VAULT & SITE AREA FROM THE CURRENT WATER SUPPLY/ DISTRIBUTION SYSTEM BEGINNING ON THE 16TH OF THE FIRST MONTH THROUGH THE 15TH OF THE SECOND MONTH.

| NO.       | DESCRIPTION        | DATE   | BY  |
|-----------|--------------------|--------|-----|
| 1         | AS-BUILT REVISIONS | 5/2004 | MSB |
| REVISIONS |                    |        |     |

HOOSIER HILLS REGIONAL  
WATER DISTRICT  
DIVISION "F" WATERWORKS SYSTEM IMPROVEMENTS  
CONTRACT F-1  
OSGOOD METER / PUMP STATION SITE PLAN  
GRW PROJECT NO. 2745-04

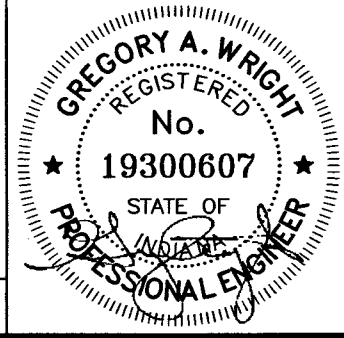

**GRW Engineers, Inc.**  
Engineers, Architects, Planners  
INDIANAPOLIS, INDIANA  
LOUISVILLE & LEXINGTON, KENTUCKY  
CINCINNATI, OHIO  
NASHVILLE, TENNESSEE  
ARLINGTON, TEXAS

|                               |                    |
|-------------------------------|--------------------|
| BJD                           | JULY 2002          |
| FILE NAME:<br>SHEET546-F1.DWG | SCALE:<br>1" = 10' |
| CHECKED:                      | SHEET NO.          |
| APPROVED:                     | 546                |