


I:\2745\dwg\sim - IDEM Elec Submittal\FINAL SET NO-3 July 3, 2002 Set of Draw and Special\FINAL F1 ELEC DWGS\F1AS-BUILT_DRAWINGS\F1-E2_REVIS.DWG, 11/15/2004 2:03:55 PM

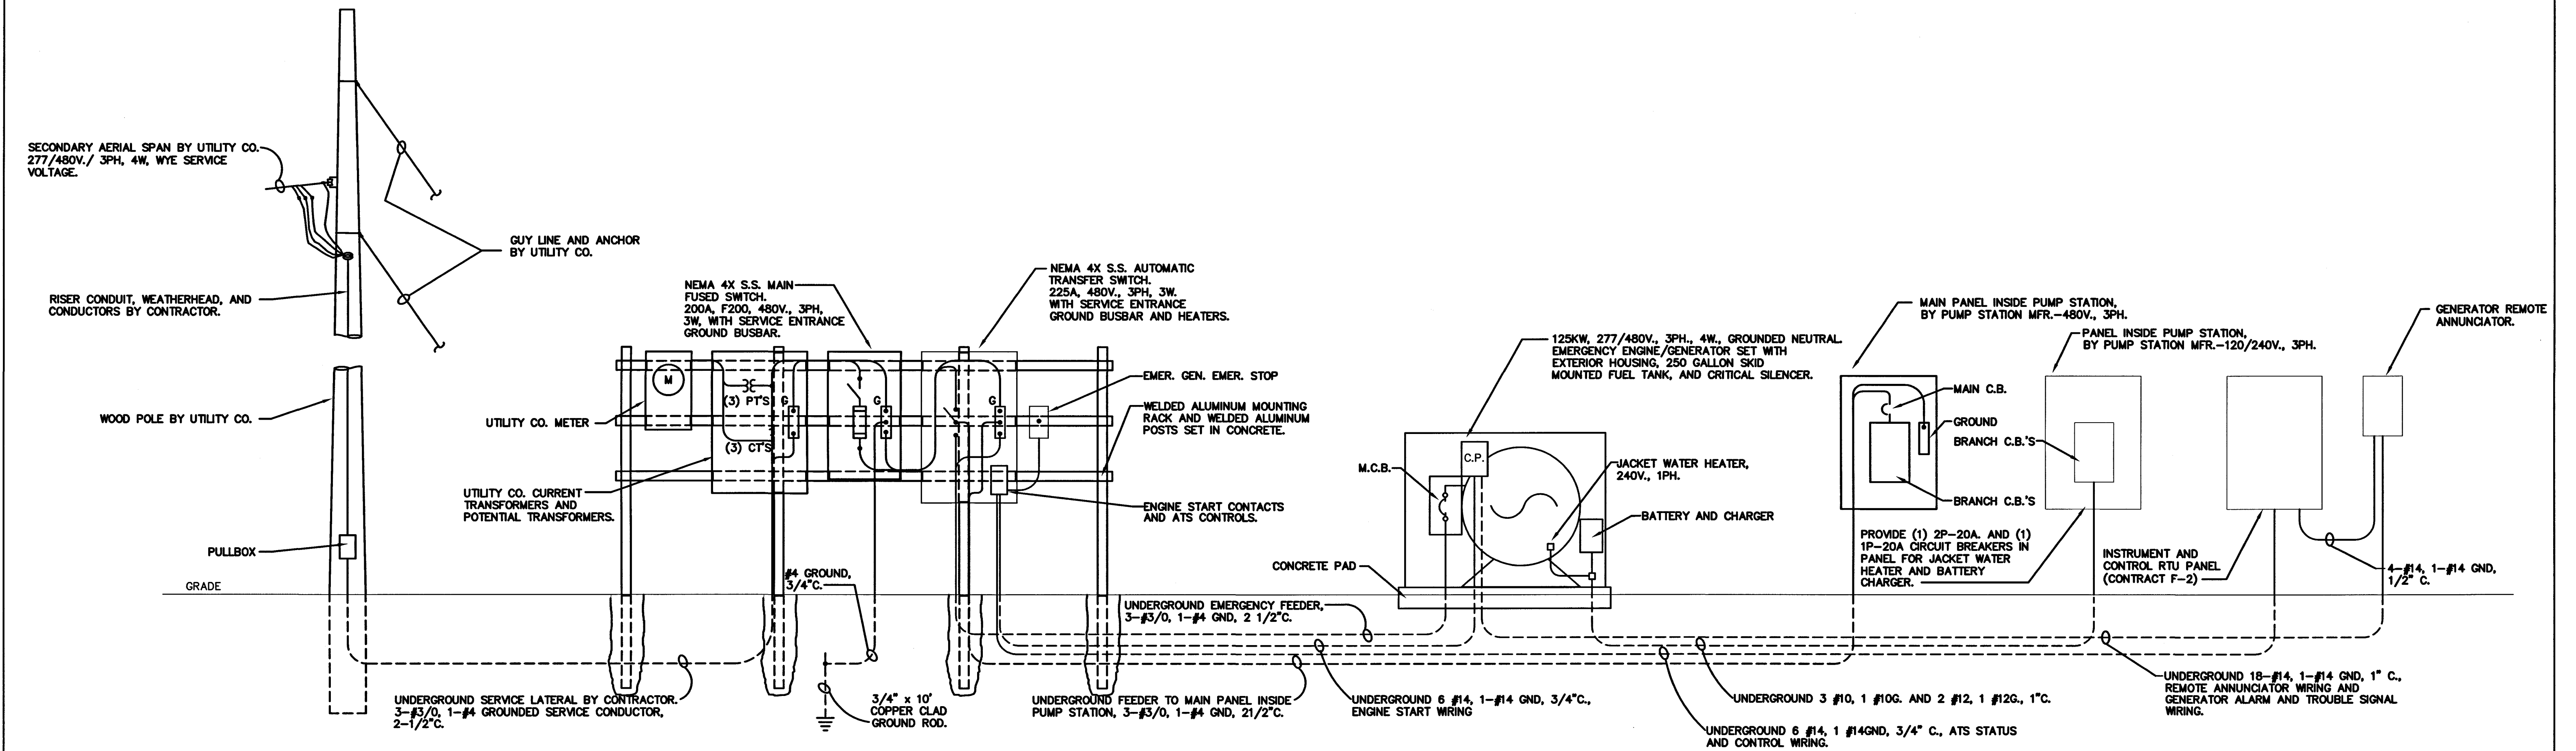

ELECTRICAL SERVICE DETAIL
SCALE: N.T.S.

NOTES:	J. W. SIMS & ASSOCIATES ENGINEERING CO. 1545 COUNTRY CLUB ROAD INDIANAPOLIS, INDIANA 46234 317-209-4035 FAX 209-4036 EMAIL JWSIMS@JWSIMS.COM	REVISIONS		HOOSIER HILLS REGIONAL WATER DISTRICT DIVISION "F" WATERWORKS SYSTEM IMPROVEMENTS CONTRACT F-1 PIERCEVILLE PUMP STATION ELECTRICAL DETAILS		GRW PROJECT NO. 2745	JWSA PROJECT NO. 2001-05		 GRW Engineers, Inc. Engineers, Architects, Planners INDIANAPOLIS, INDIANA LOUISVILLE & LEXINGTON, KENTUCKY CINCINNATI, OHIO NASHVILLE, TENNESSEE ARLINGTON, TEXAS	DRAWN: JBK	DATE: JULY, 2002
		2	RENUMBERED	5/2004	GCR					FILE NAME: F1-E2_REVIS.DWG	SCALE: AS NOTED
		1	AS-BUILT REVISION	5/2004	GCR					CHECKED: JWS	SHEET NO.
		NO.	DESCRIPTION	DATE	BY					APPROVED: JWS	E2/564