


ELROD ELECTRICAL SITE PLAN
SCALE: 1"=10'-0"

ELROD ELECTRICAL PLAN NOTES:

- ① NEW UTILITY CO. METER, FURNISHED BY UTILITY CO., INSTALLED BY THE CONTRACTOR.
- ② NEW FUSED MAIN DISCONNECT SWITCH
- ③ 60A, 120/240V, 1PH, 3W, WITH GND, UNDERGROUND FEEDER TO NEW ALTITUDE VALVE VAULT. 3-#4, 1-#8 GND, 1 1/4" C. SUBMERSIBLE WIRING METHODS INSIDE VALVE VAULT.
- ④ NEW 3/4"x10' COPPER CLAD GROUND ROD
- ⑤ NEW WELDED ALUMINUM MOUNTING RACK AND WELDED ALUMINUM POSTS
- ⑥ EXIST. ELECTRIC UTILITY POLE, WITH NEW TRANSFORMER BANK, FURNISHED AND INSTALLED BY UTILITY CO.
- ⑦ NEW UNDERGROUND SERVICE
- ⑧ NEW POWER DISTRIBUTION PANEL.
- ⑨ NEW ALTITUDE VALVE VAULT.
- ⑩ NEW SERVICE ENTRANCE THROUGH WALL.

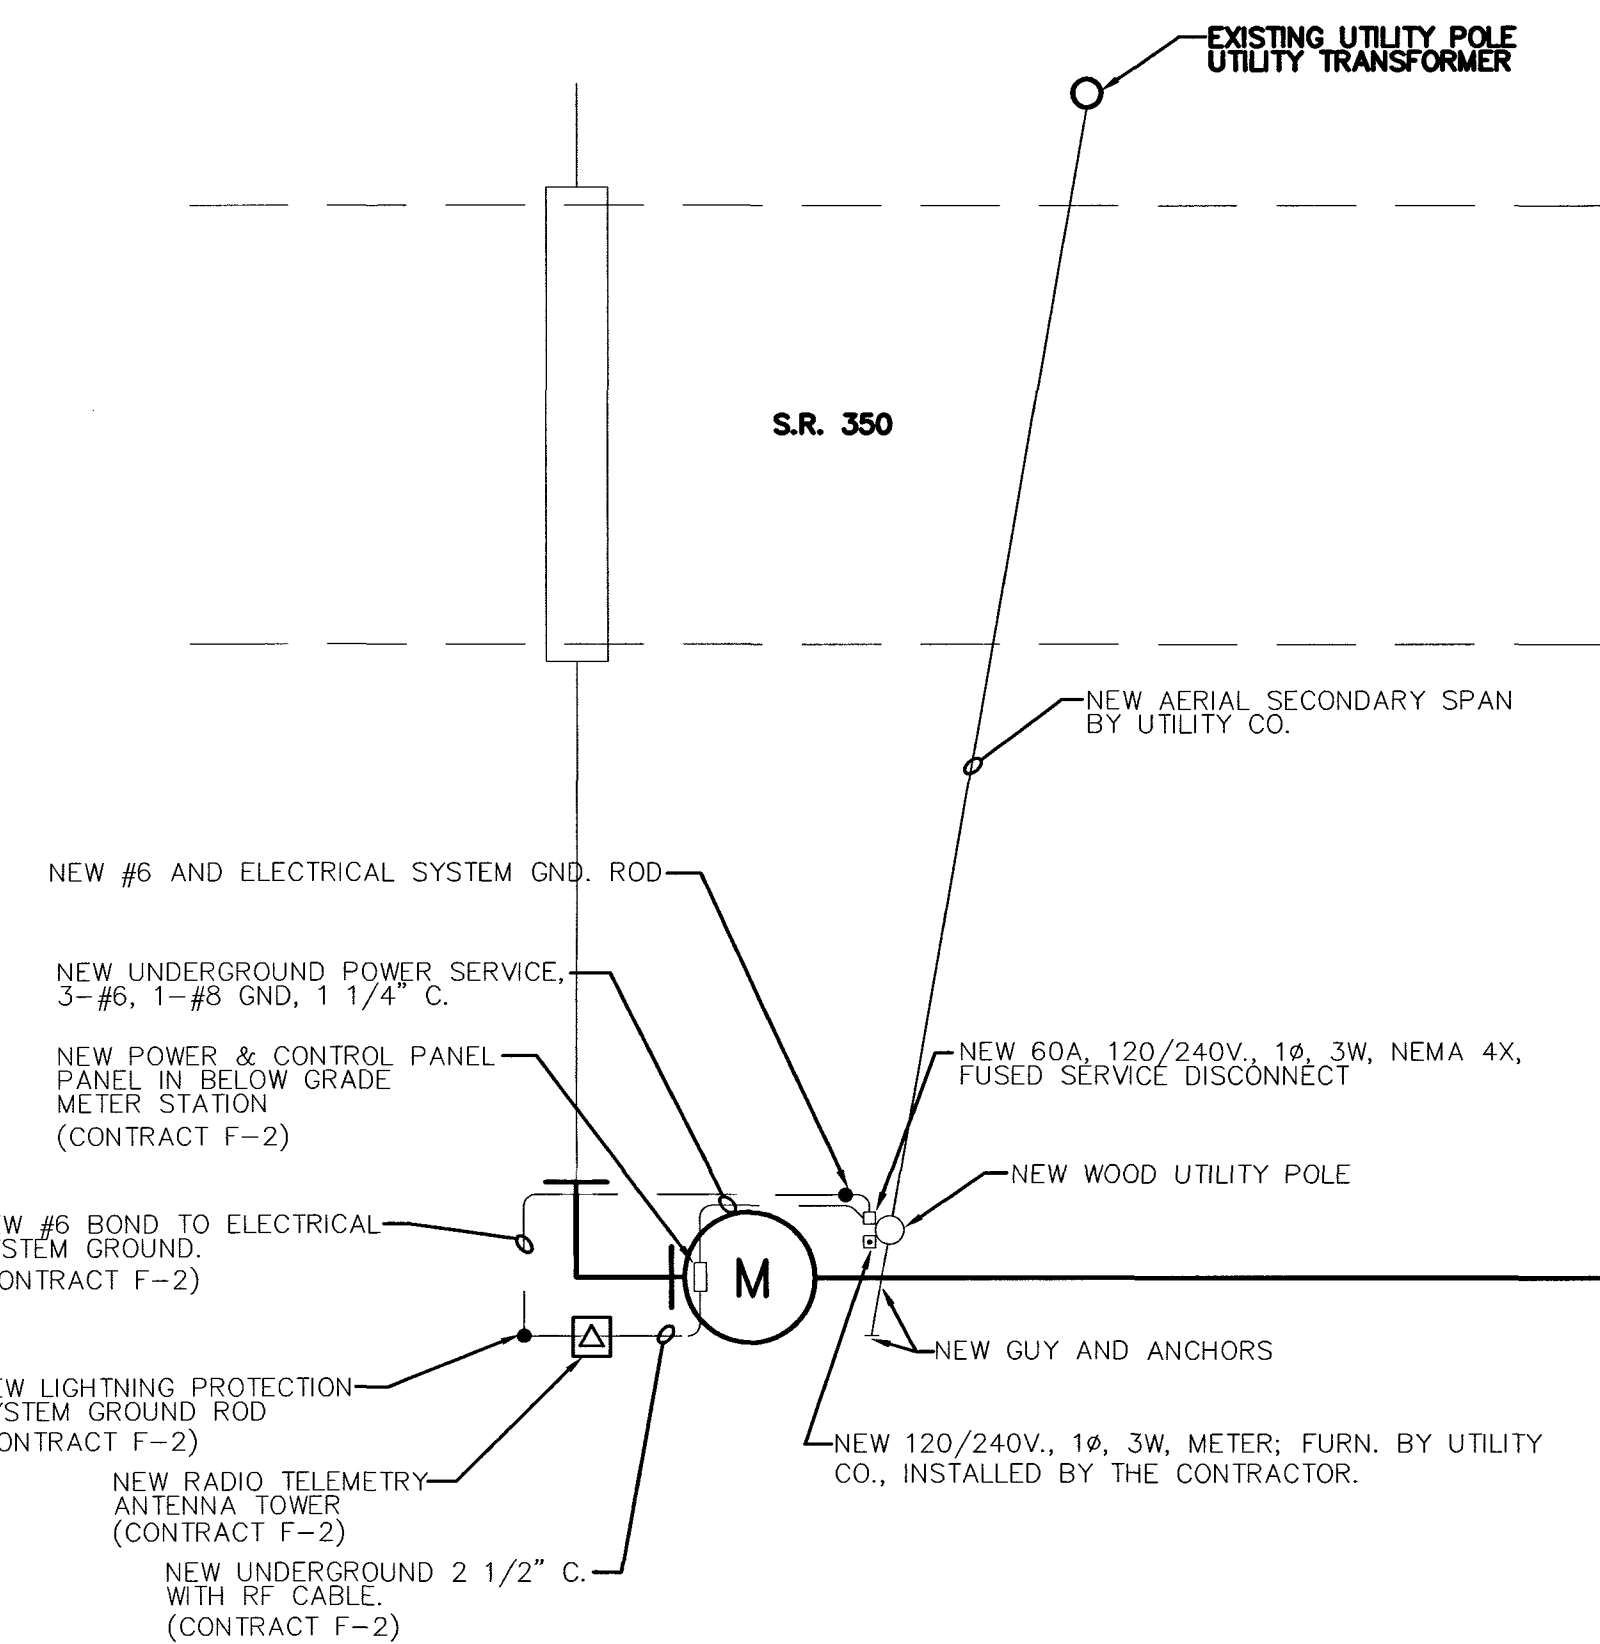

MILAN MASTER METER
ELECTRICAL SITE PLAN
SCALE: 1"=10'-0"

NOTES:


J. W. SIMS
& ASSOCIATES
ENGINEERING CO.
1545 COUNTRY CLUB ROAD
INDIANAPOLIS, INDIANA 46234
317-209-4035 FAX 209-4036
EMAIL JWSIMS@JWSIMS.COM

NO.	DESCRIPTION	DATE	BY
2	RENUMBERED	5/2004	GCR
1	AS-BUILT REVISION	5/2004	GCR

REVISIONS

HOOSIER HILLS REGIONAL WATER DISTRICT
DIVISION "F" WATERWORKS SYSTEM IMPROVEMENTS
CONTRACT F-1

ELROD TANK ELECTRICAL SITE PLAN &
MILAN MASTER METER ELECTRICAL SITE PLAN
GRW PROJECT NO. 2745 JWSA PROJECT NO. 2001-05

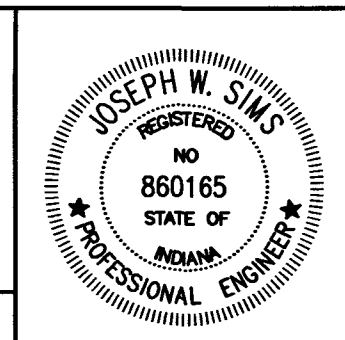

GRW Engineers, Inc.
Engineers, Architects, Planners
INDIANAPOLIS, INDIANA
LOUISVILLE & LEXINGTON, KENTUCKY
CINCINNATI, OHIO
NASHVILLE, TENNESSEE
ARLINGTON, TEXAS

DRAWN: JBK	DATE: JULY, 2002
FILE NAME: F1-E5_REVIS.DWG	SCALE: AS NOTED
CHECKED: JWS	SHEET NO. E5/567
APPROVED: JWS	