



I:\2745\dwg\JWSIMS - IDEN Elec Submittal\FINAL SET NO-3 July 3, 2002 Set of Dwg and Specs\FINAL F1 ELEC DWGS\F1-AS-BUILT_DRAWINGS\F1-E7_REVISED.dwg, 11/15/2004 1:58:49 PM

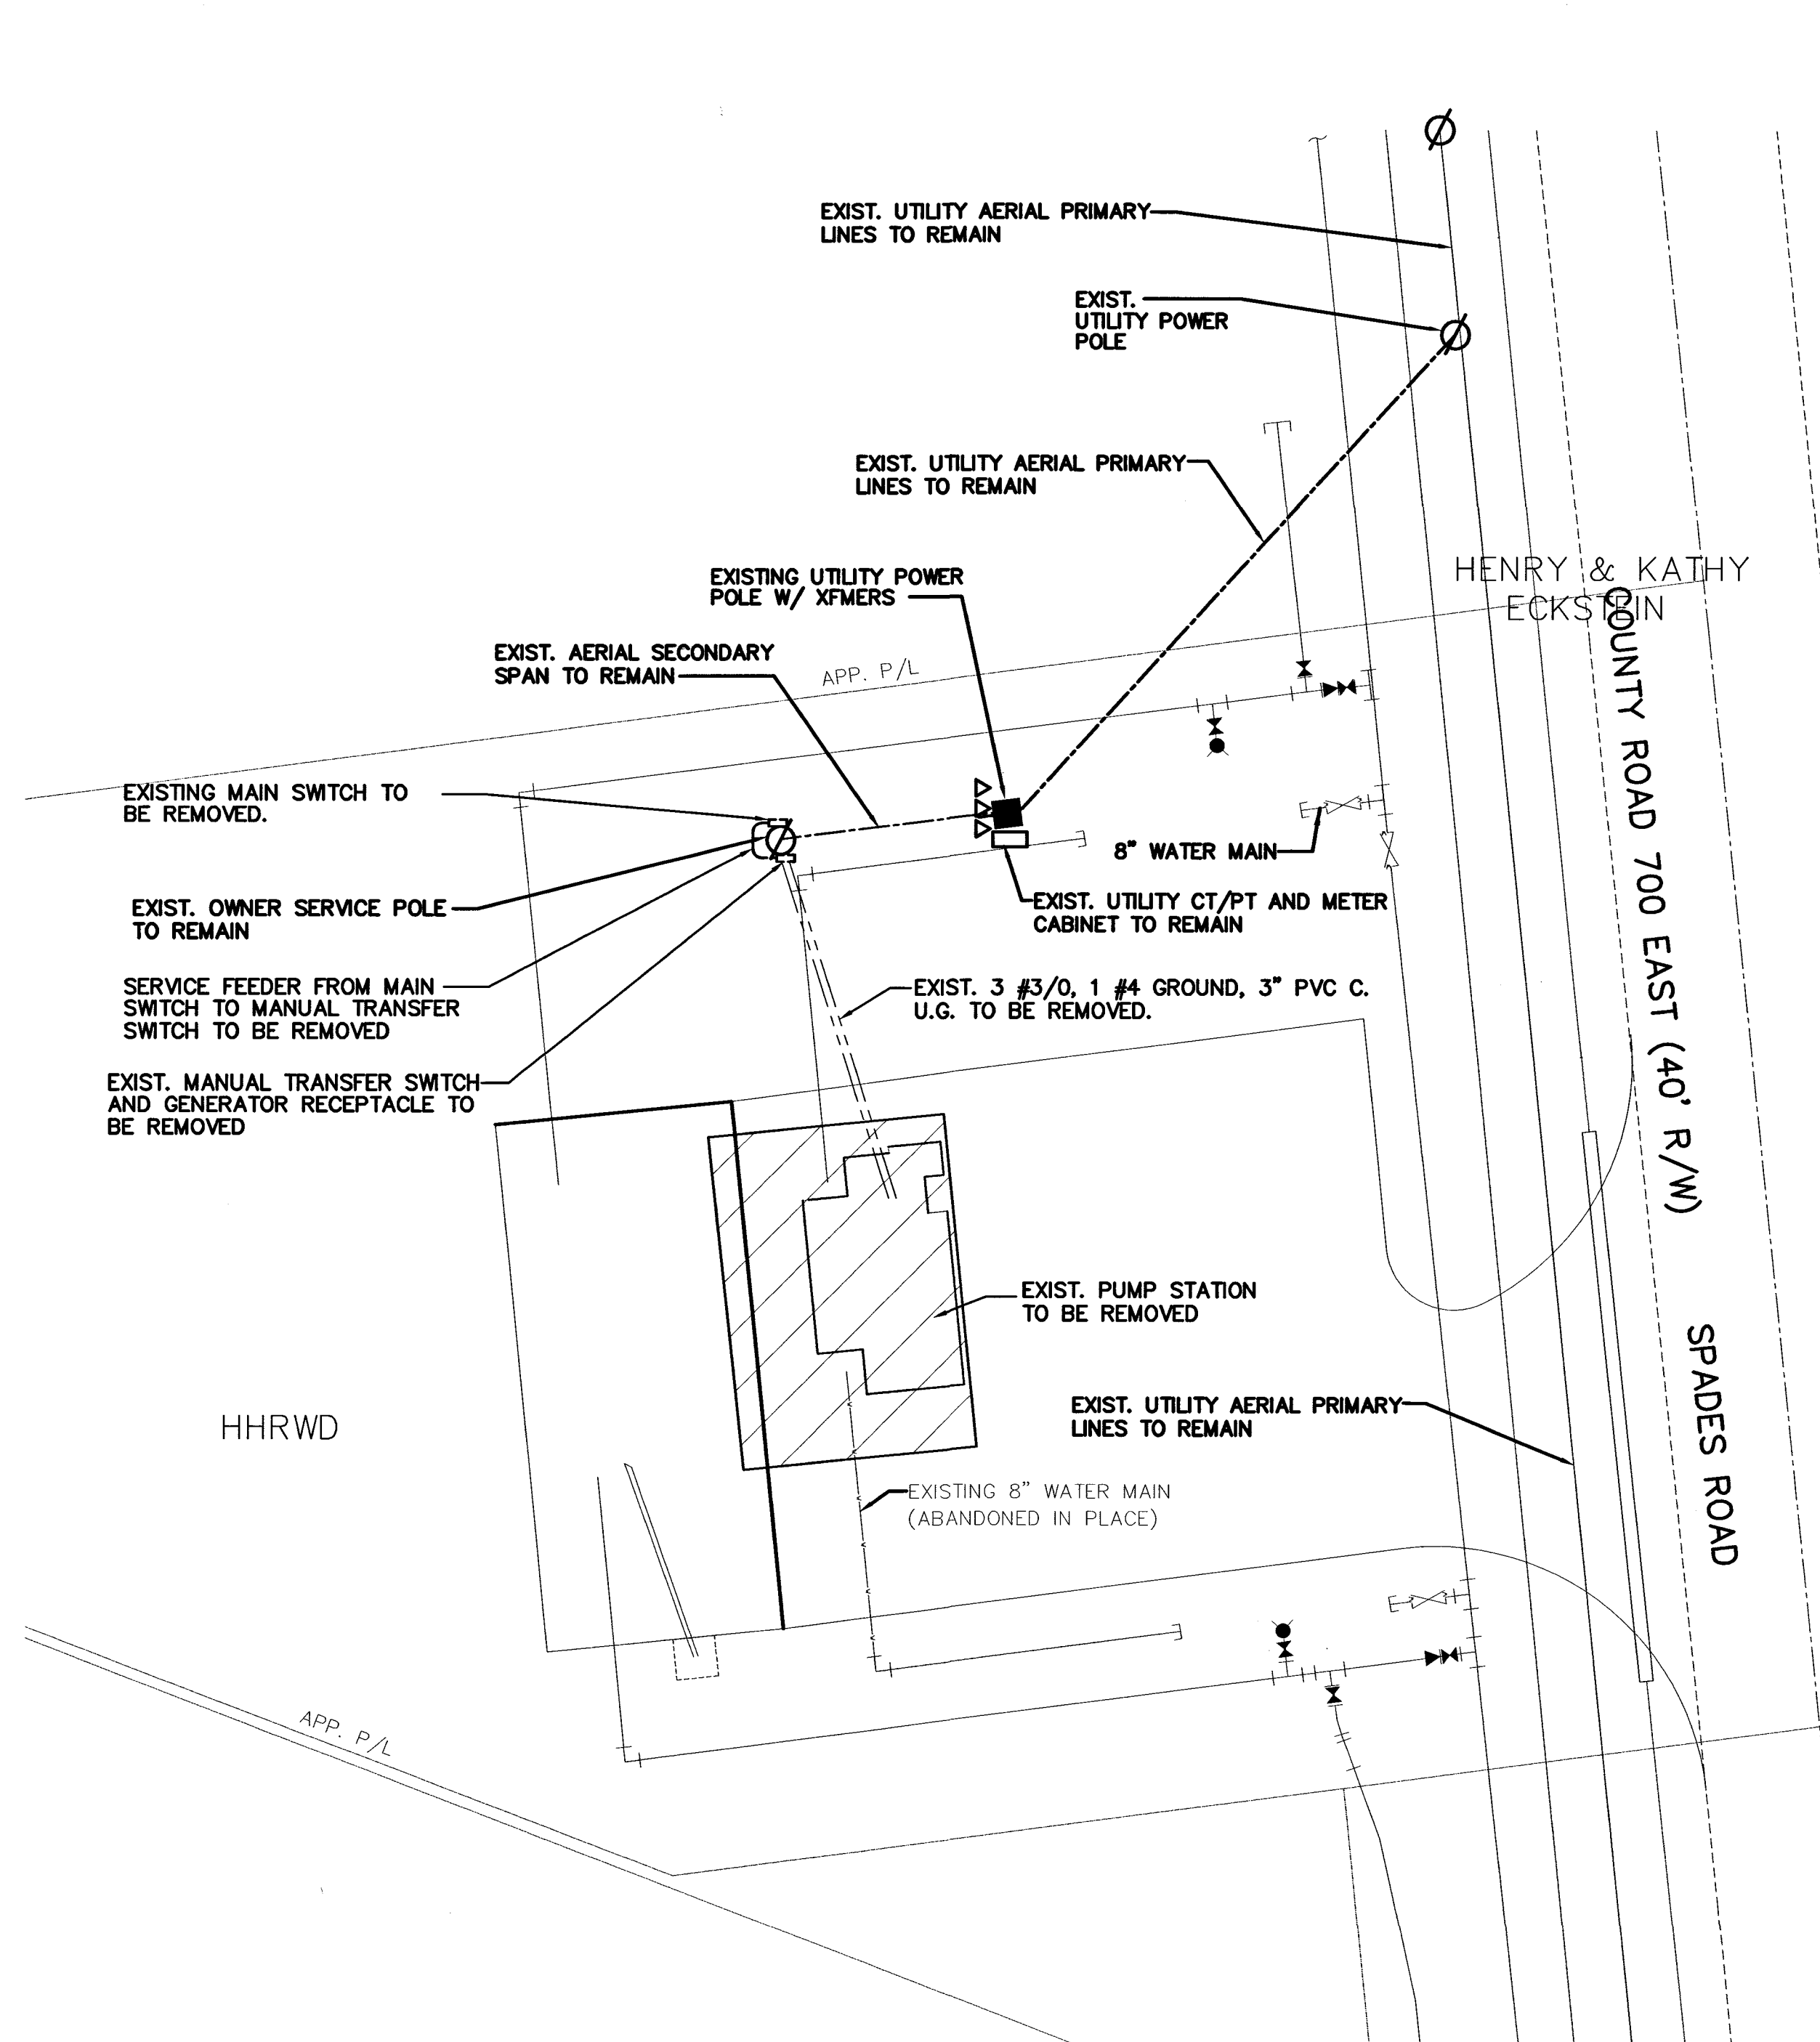

ELECTRICAL DEMOLITION SITE PLAN
SCALE: 1" = 10'

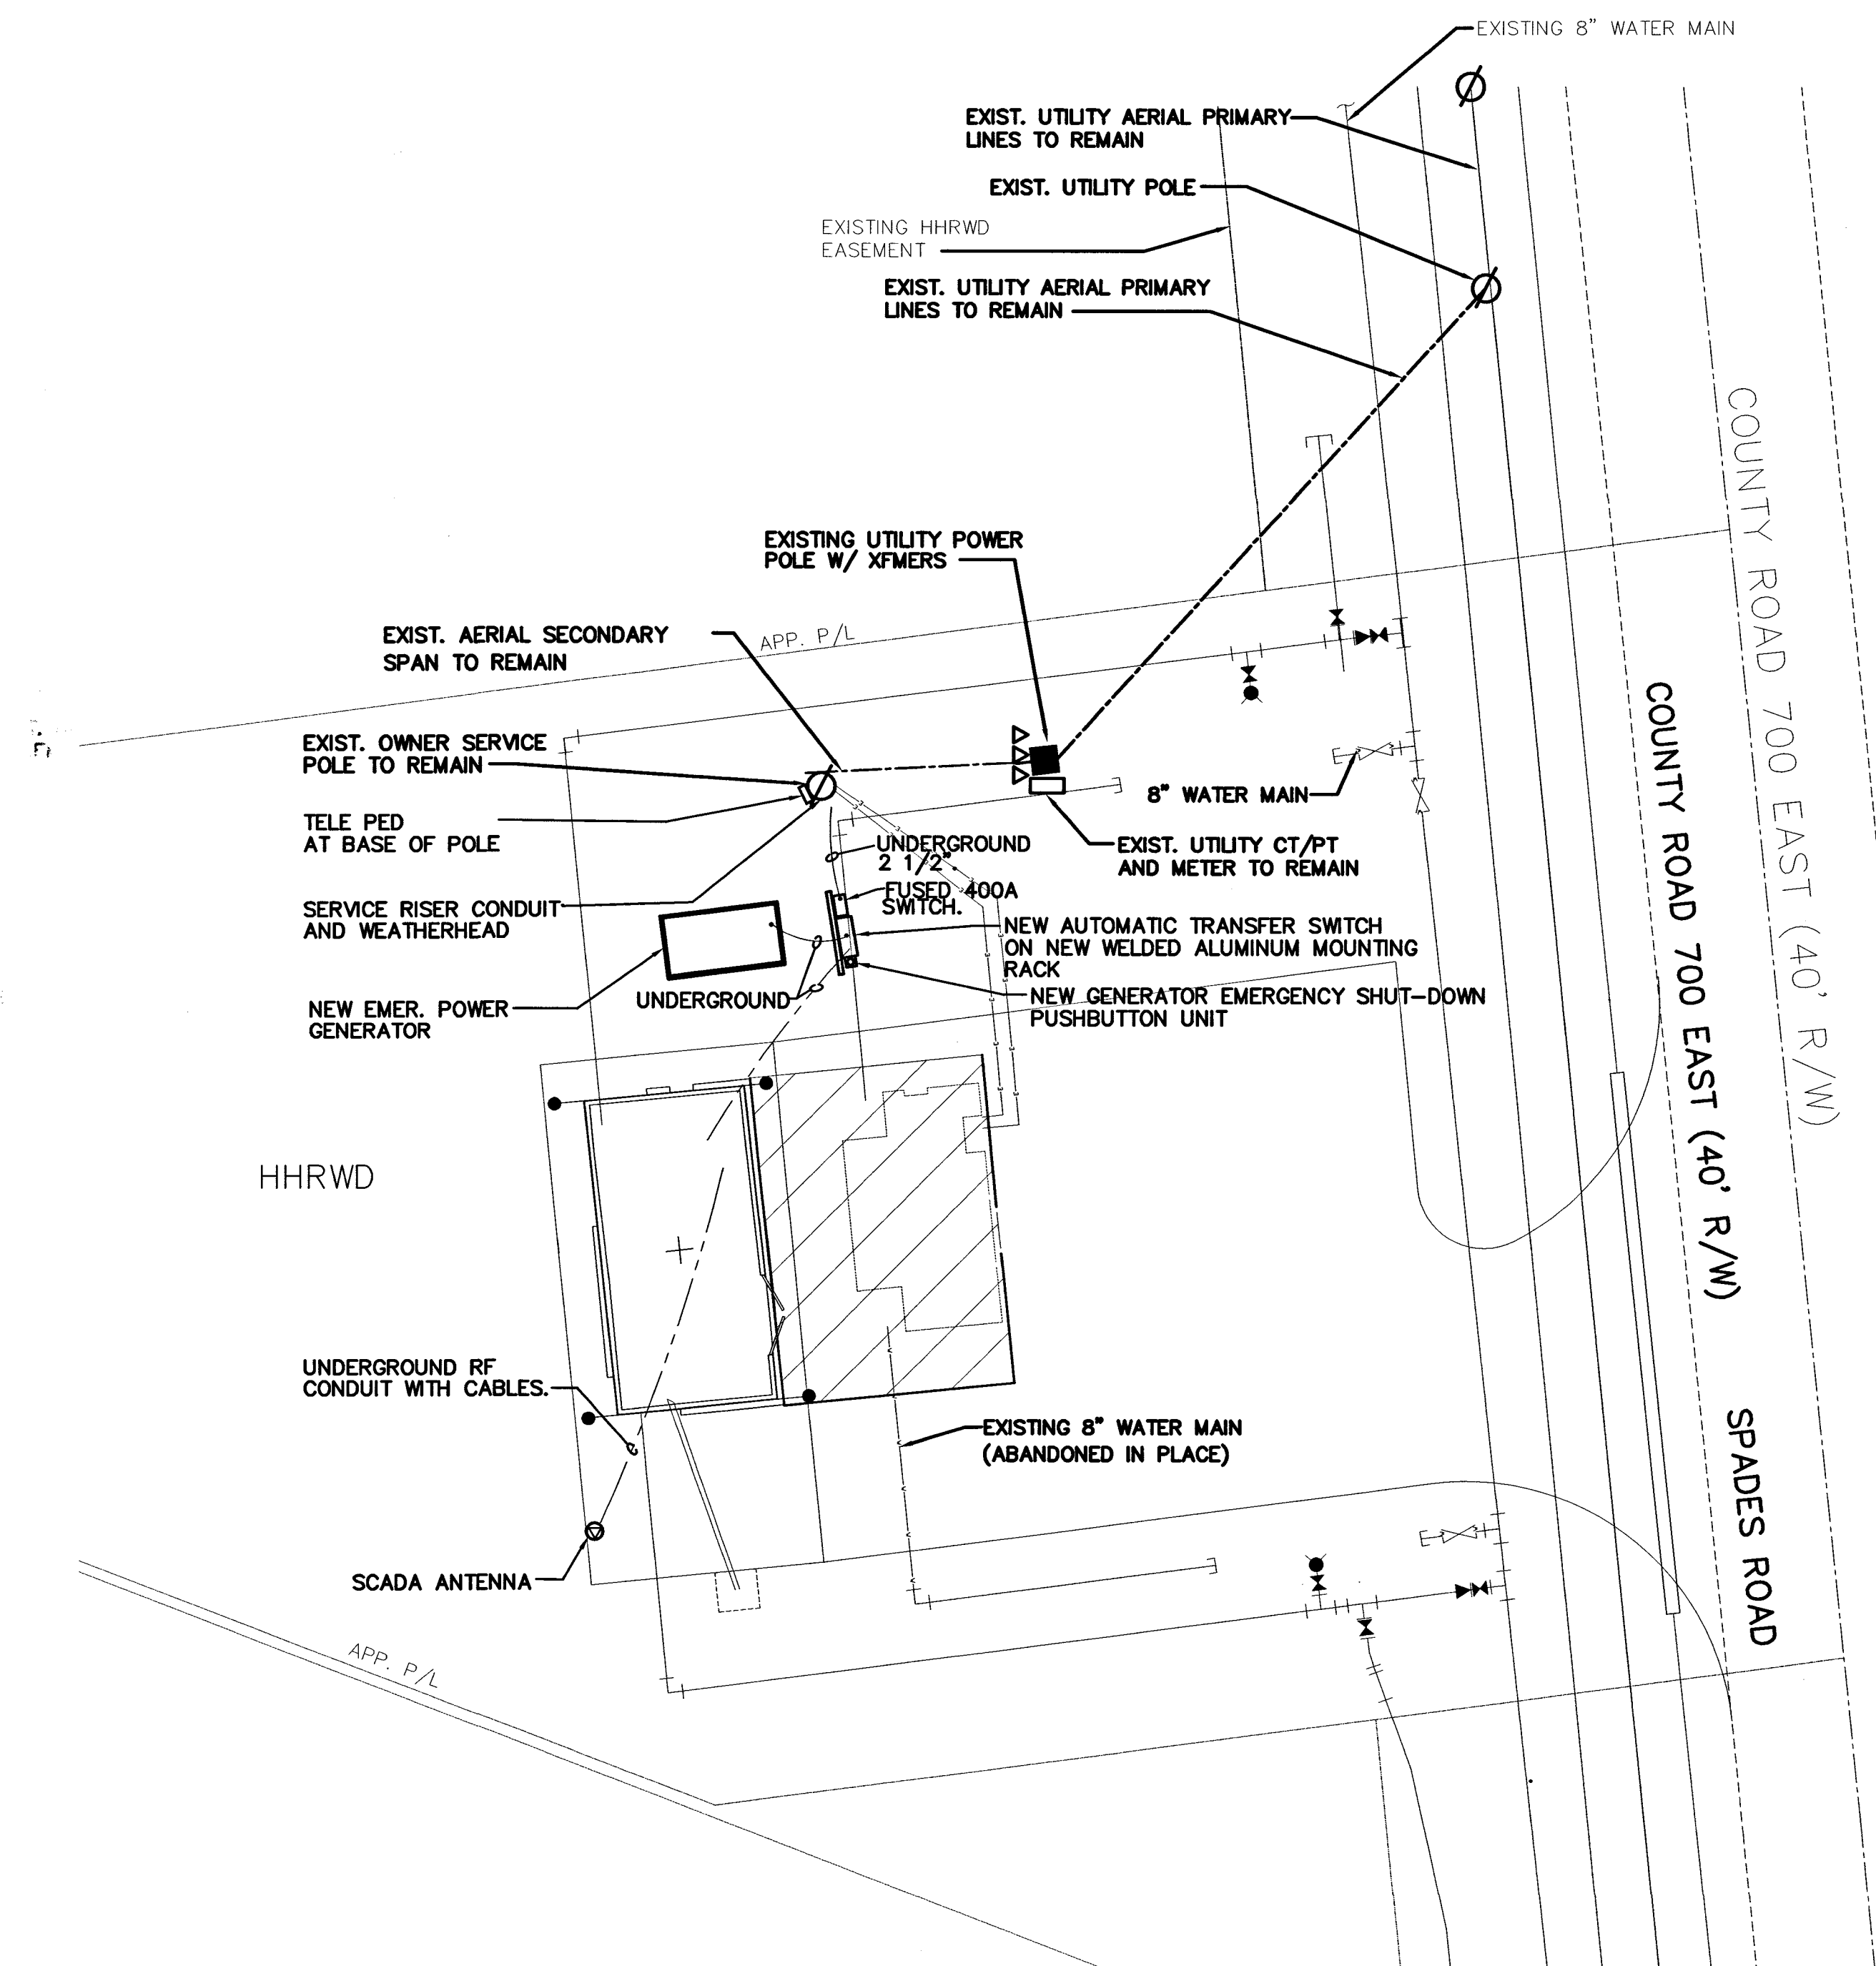

ELECTRICAL NEW WORK SITE PLAN
SCALE: 1" = 10'

NOTES:

**J. W. SIMS
& ASSOCIATES
ENGINEERING CO.**
1545 COUNTRY CLUB ROAD
INDIANAPOLIS, INDIANA 46234
317-209-4035 FAX 209-4036
EMAIL JWSIMS@JWSIMS.COM

NO.	DESCRIPTION	DATE	BY
3	AS-BUILT REVISION	10/2004	JWS
2	RENUMBERED	5/2004	GCR
1	AS-BUILT REVISION	5/2004	GCR
REVISIONS			

HOOSIER HILLS REGIONAL WATER DISTRICT
DIVISION "F" WATERWORKS SYSTEM IMPROVEMENTS
CONTRACT F-1

SPADES ROAD
ELECTRICAL SITE PLANS

GRW PROJECT NO. 2745 JWSA PROJECT NO. 2001-05

GRW
GRW Engineers, Inc.
Engineers, Architects, Planners
INDIANAPOLIS, INDIANA
LOUISVILLE & LEXINGTON, KENTUCKY
CINCINNATI, OHIO
NASHVILLE, TENNESSEE
ARLINGTON, TEXAS

DRAWN: JBK	DATE: JULY, 2002
FILE NAME: F1-E7_REVISED.DWG	SCALE: AS NOTED
CHECKED: JWS	SHEET NO. E7/569
APPROVED: JWS	