



PANELBOARD SCHEDULE									
PANEL: A	LOCATION: EQUIPMENT BUILDING OLD MILAN TANK	MOUNTING: SURFACE	RATING: 100A., 120/240V., 1PH., 3W.	MAIN: 100A. CIRCUIT BREAKER		REMARKS: SERVICE ENTRANCE, GRD. AND NEUTRAL BARS			
LOAD DESIGNATION		CKT. BKR.	CKT. NO.	PHASE		CKT. NO.	CKT. BKR.	LOAD DESIGNATION	
				A	B				
LIGHTING		1P-20	1			2	1P-20	SPARE	
OBSTRUCT. LIGHT		1P-20	3			4	1P-20	SPARE	
RTU PANEL		1P-20	5			6	1P-20	SPARE	
SPARE RECEPTACLE		1P-20	7			8	1P-20	SPARE	
TENNANT RADIO		1P-20	9			10	1P-20	SPARE	
SPARE		1P-20	11			12	1P-20	SPARE	
SPACE		1P-20	13			14	1P-20	SPACE	
SPACE		1P-20	15			16	1P-20	SPACE	
SPACE		1P-20	17			18	1P-20	SPACE	
SPACE		1P-20	19			20	1P-20	SPACE	
UNIT HEATER		2P-20	21			22	2P-20	SPACE	
			23			24			
NOTES: 1. ALL CIRCUIT BREAKERS SHALL BE RATED 10kAIC									
2. PANEL SHALL BE NEMA 1									
3. ALL CIRCUIT BREAKERS SHALL BE BOLT-ON									

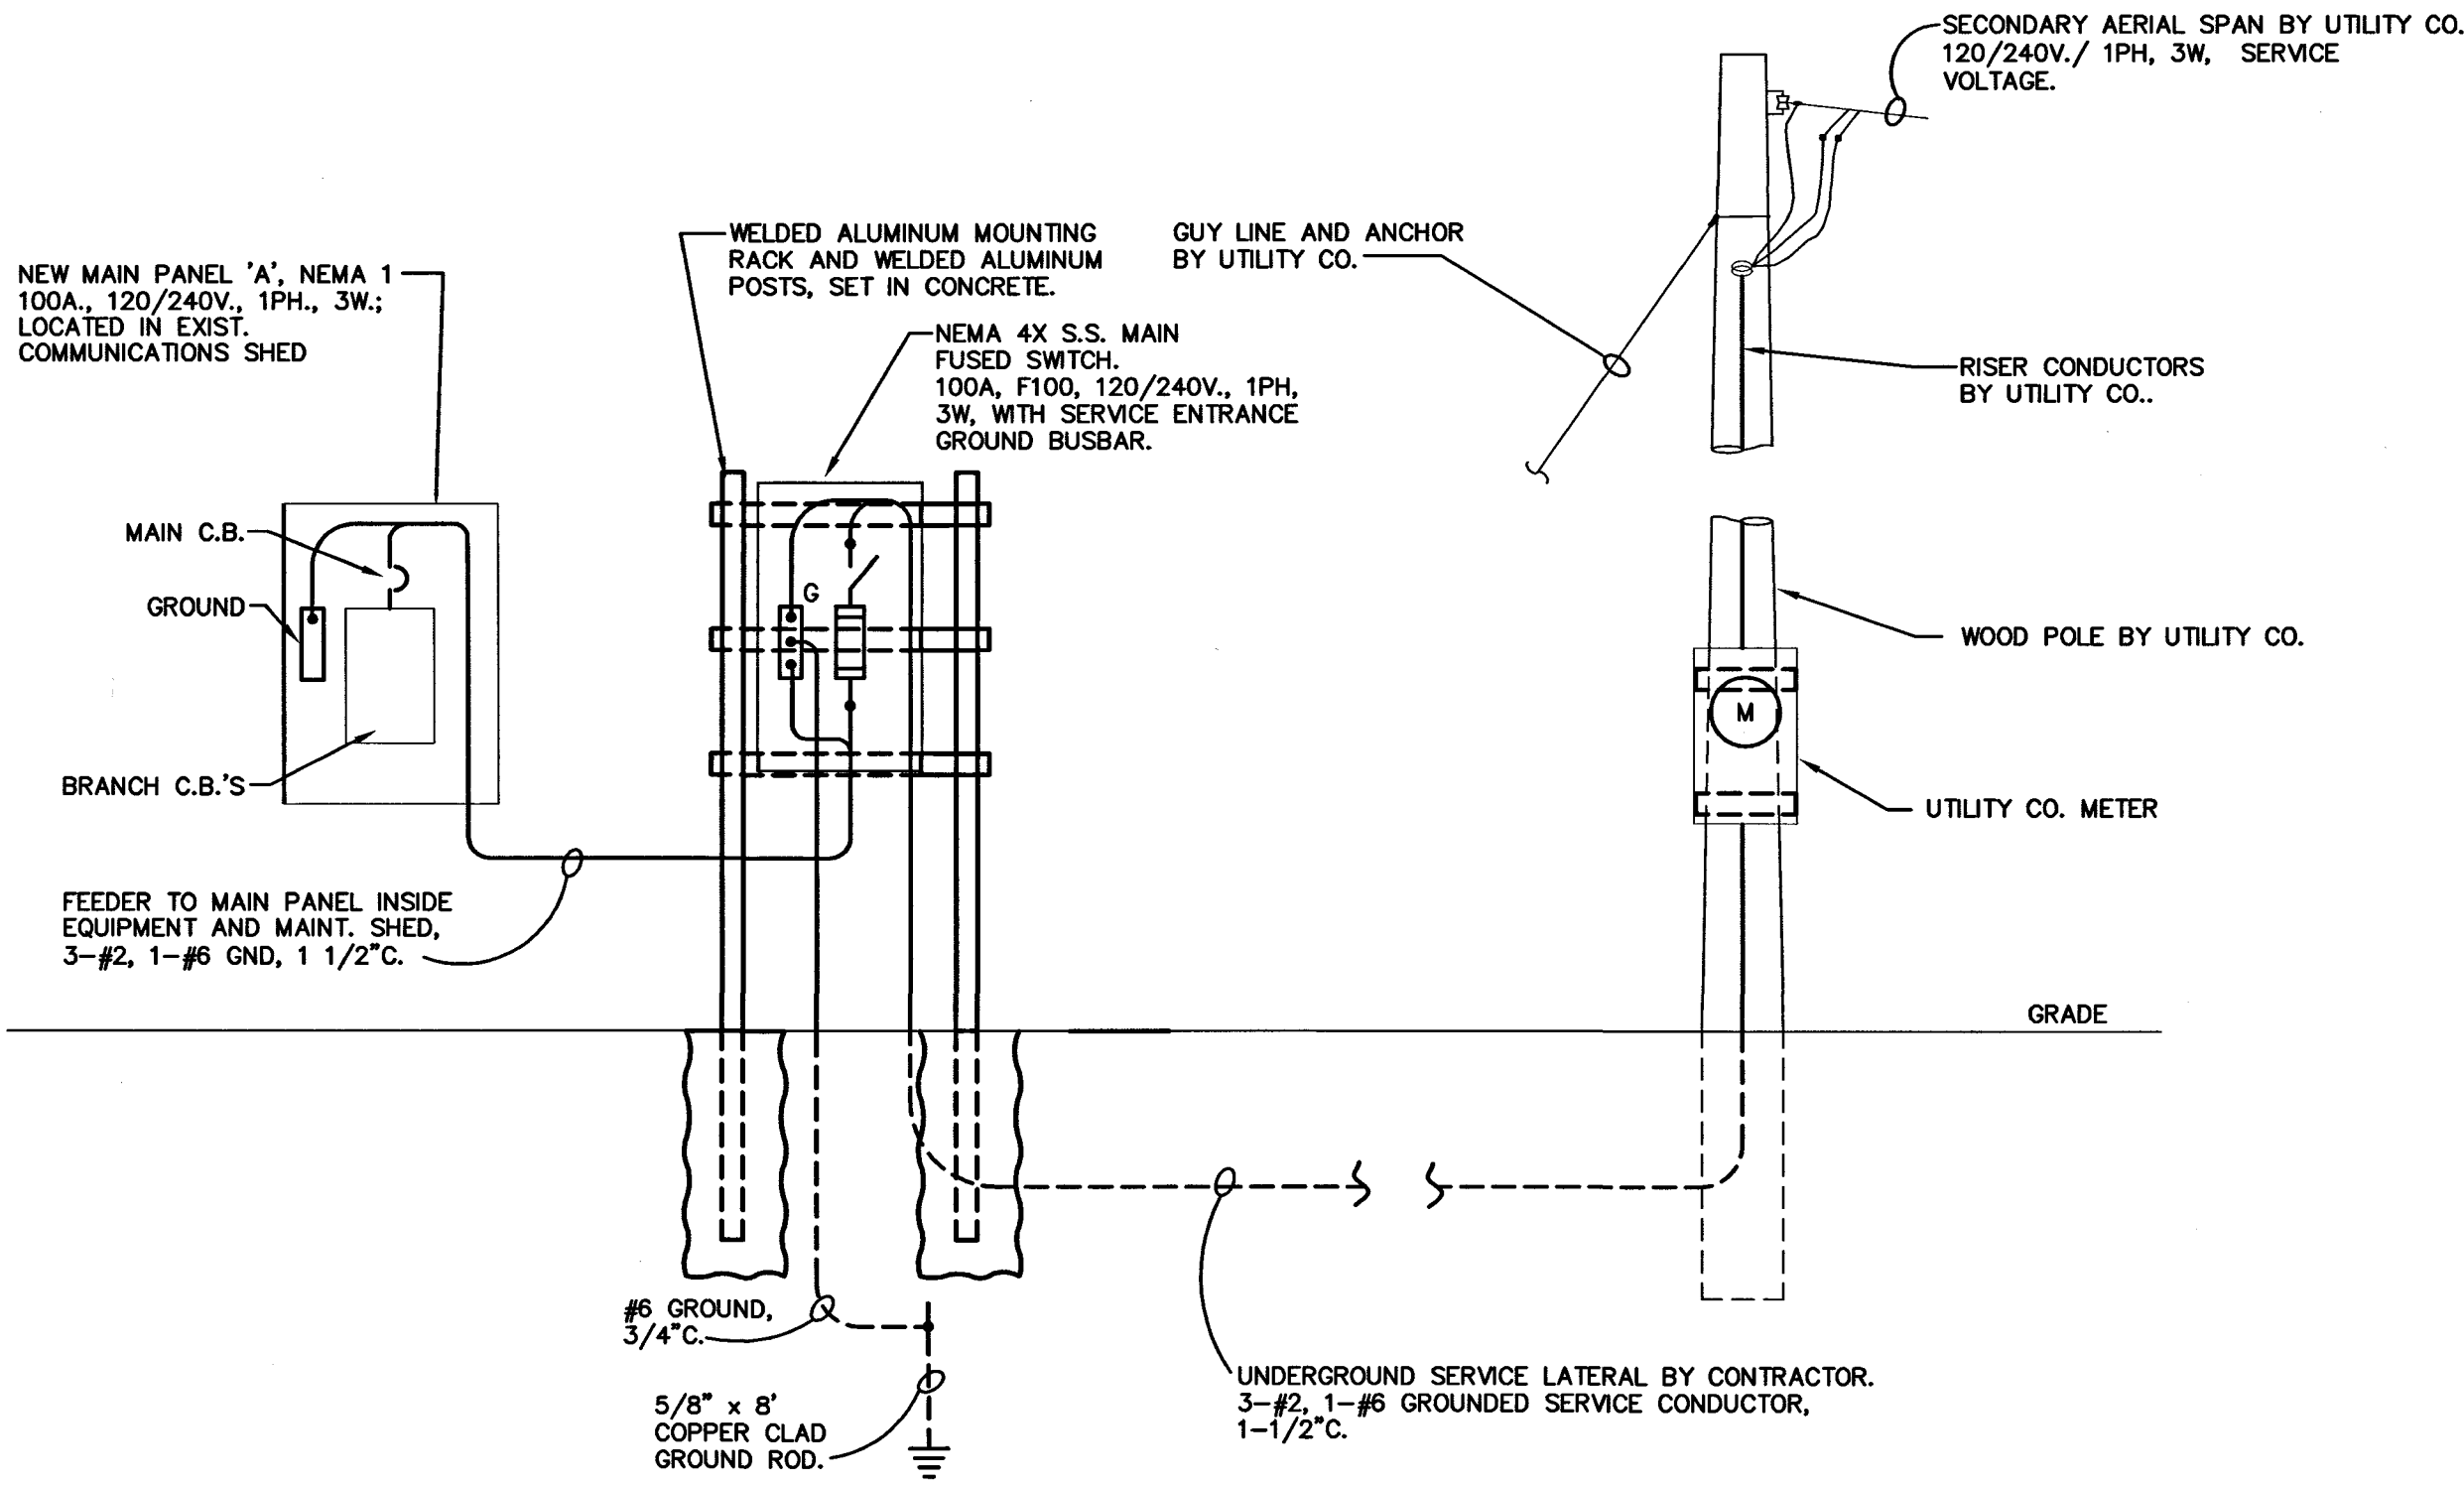

OLD MILAN TANK ELECTRICAL SERVICE DETAIL
SCALE: N.T.S.

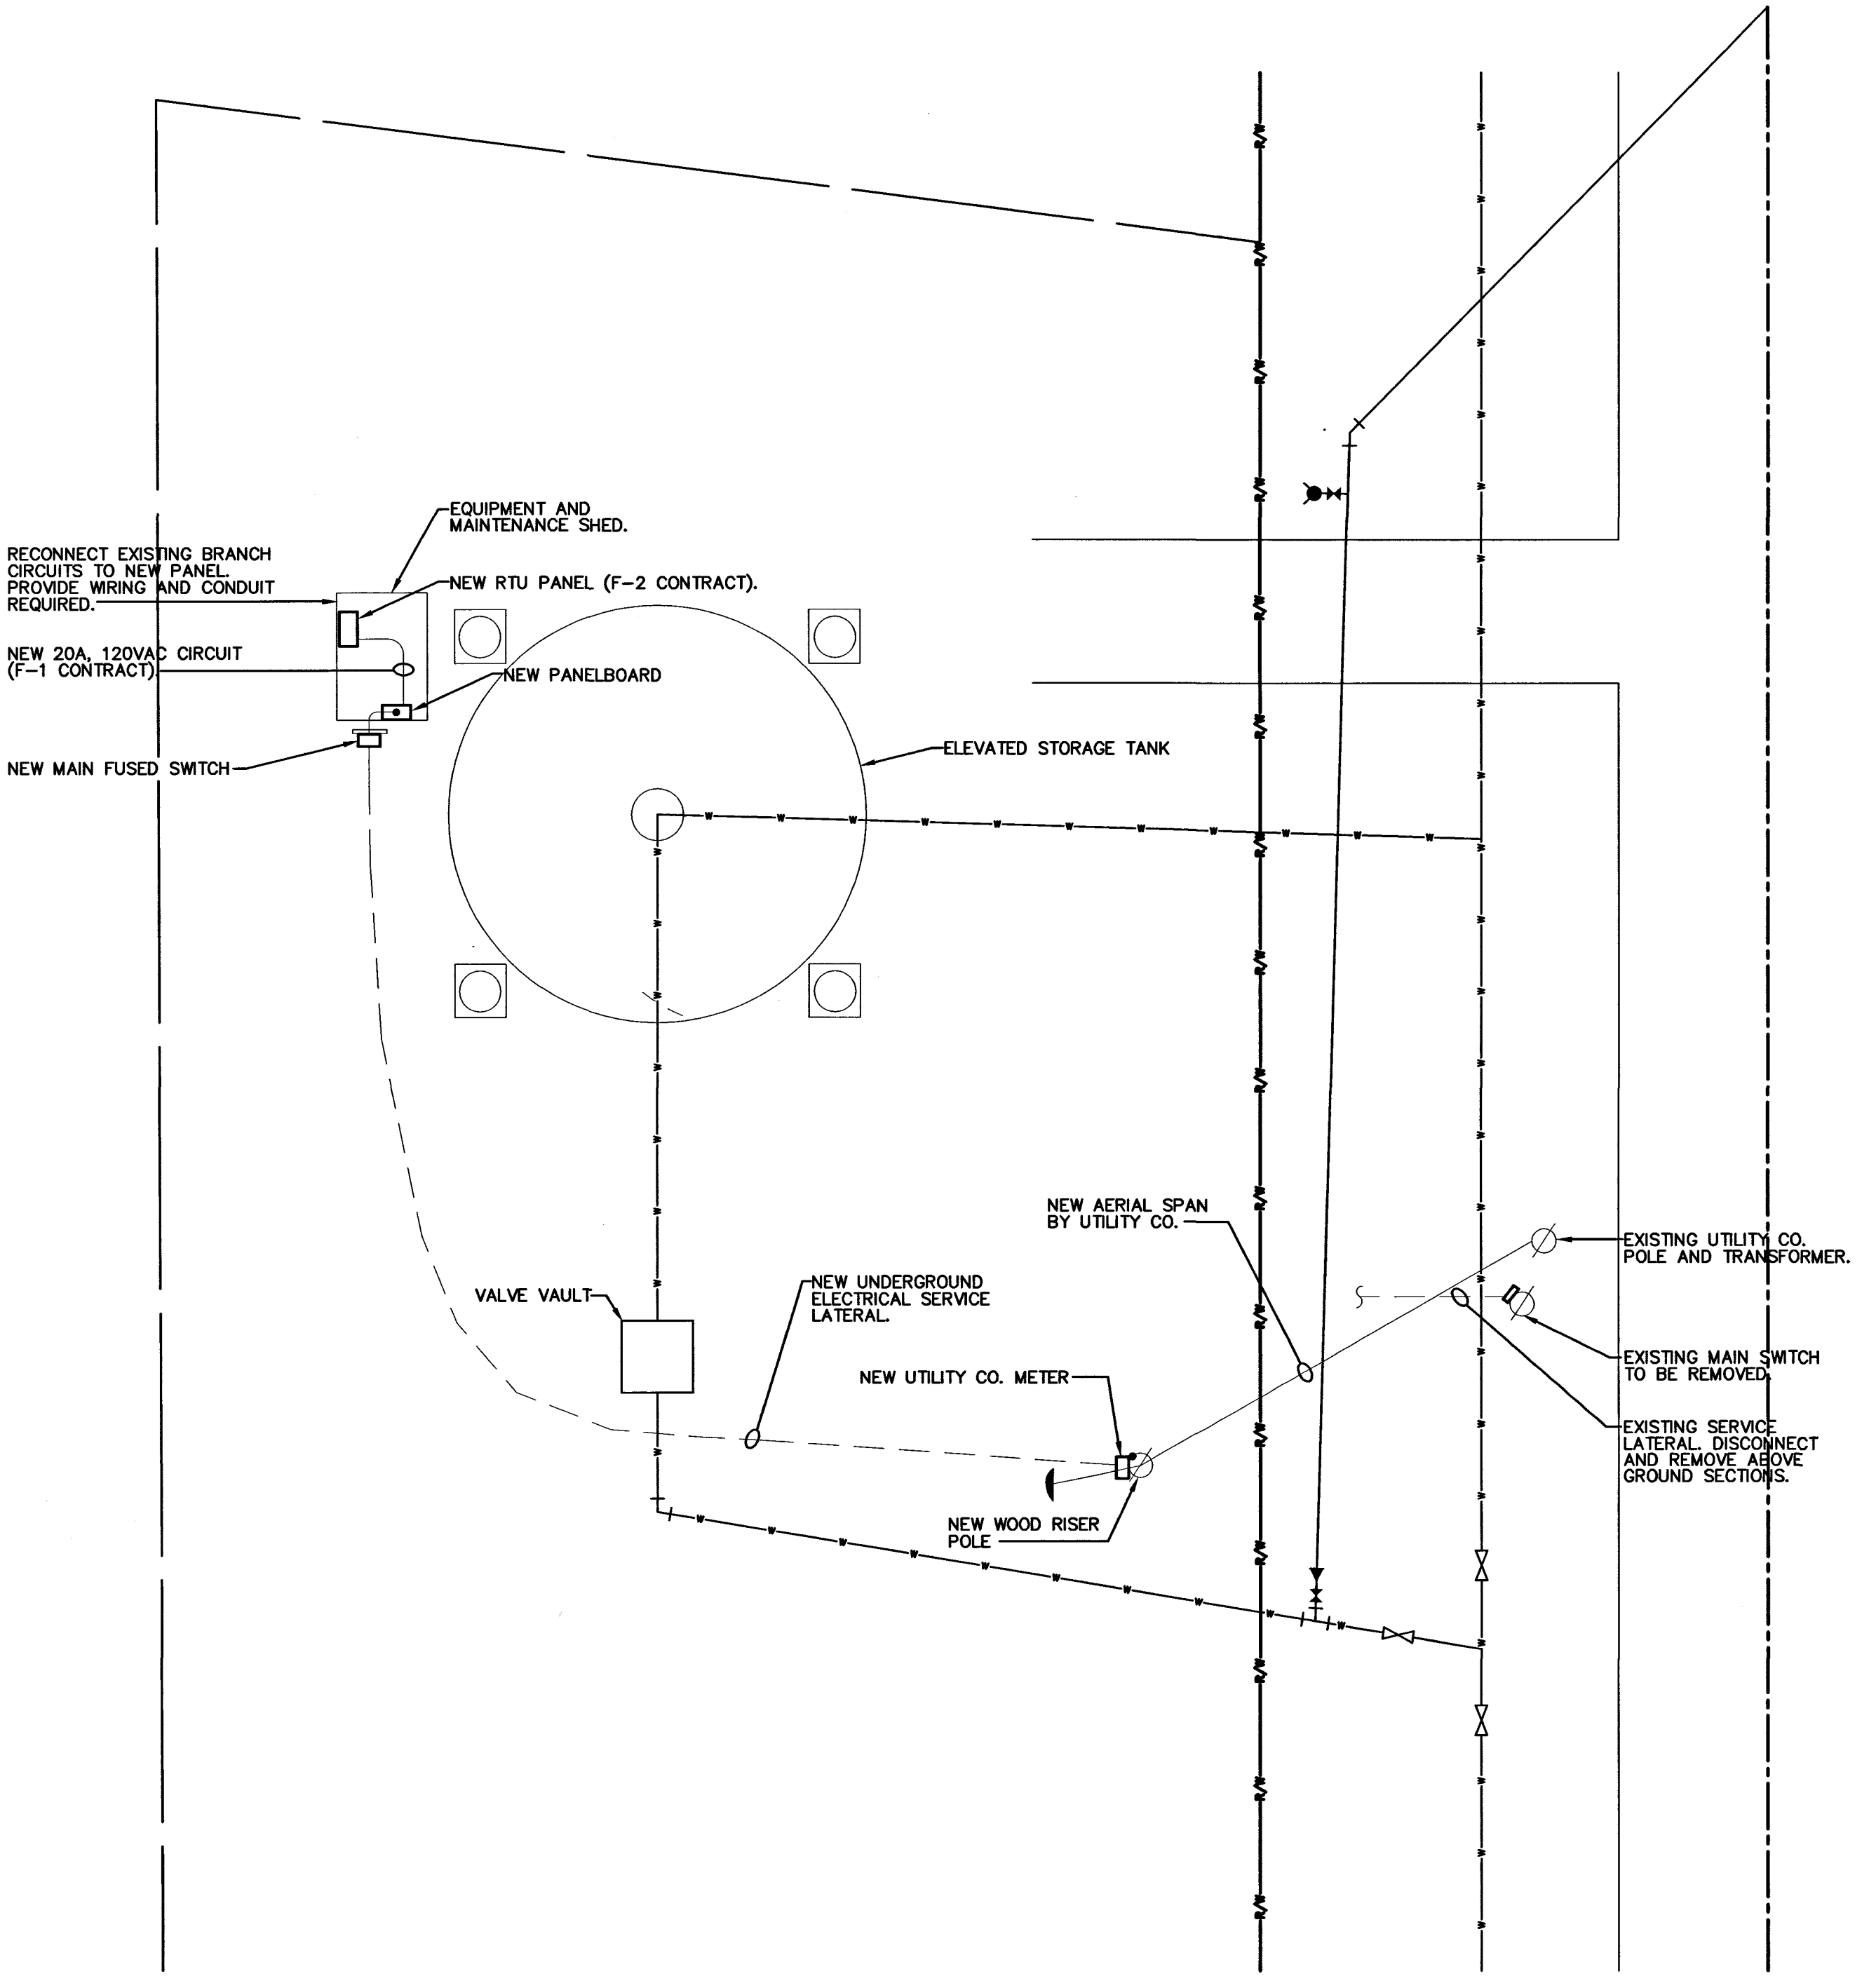


OLD MILAN TANK ELECTRICAL SITE PLAN
SCALE: 1" = 10'

NOTES:

J. W. SIMS
& ASSOCIATES
ENGINEERING CO.
1545 COUNTRY CLUB ROAD
INDIANAPOLIS, INDIANA 46234
317-209-4035 FAX 209-4036
EMAIL JWSIMS@JWSIMS.COM

NO.	DESCRIPTION	DATE	BY
2	RENUMBERED	5/2004	GCR
1	AS-BUILT REVISION	5/2004	GCR

HOOSIER HILLS REGIONAL WATER DISTRICT
DIVISION "F" WATERWORKS SYSTEM IMPROVEMENTS
CONTRACT F-1
OLD MILAN TANK ELECTRICAL SITE PLAN AND DETAILS
GRW PROJECT NO. 2745 JWSA PROJECT NO. 2001-05

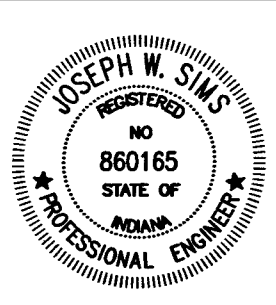

GRW Engineers, Inc.
Engineers, Architects, Planners
INDIANAPOLIS, INDIANA
LOUISVILLE & LEXINGTON, KENTUCKY
CINCINNATI, OHIO
NASHVILLE, TENNESSEE
ARLINGTON, TEXAS

DRAWN: JWS/JMS	DATE: JULY, 2002
FILE NAME: F1-E9_REVISED.DWG	SCALE: AS NOTED
CHECKED: JWS	SHEET NO.
APPROVED: JWS	E9/571