
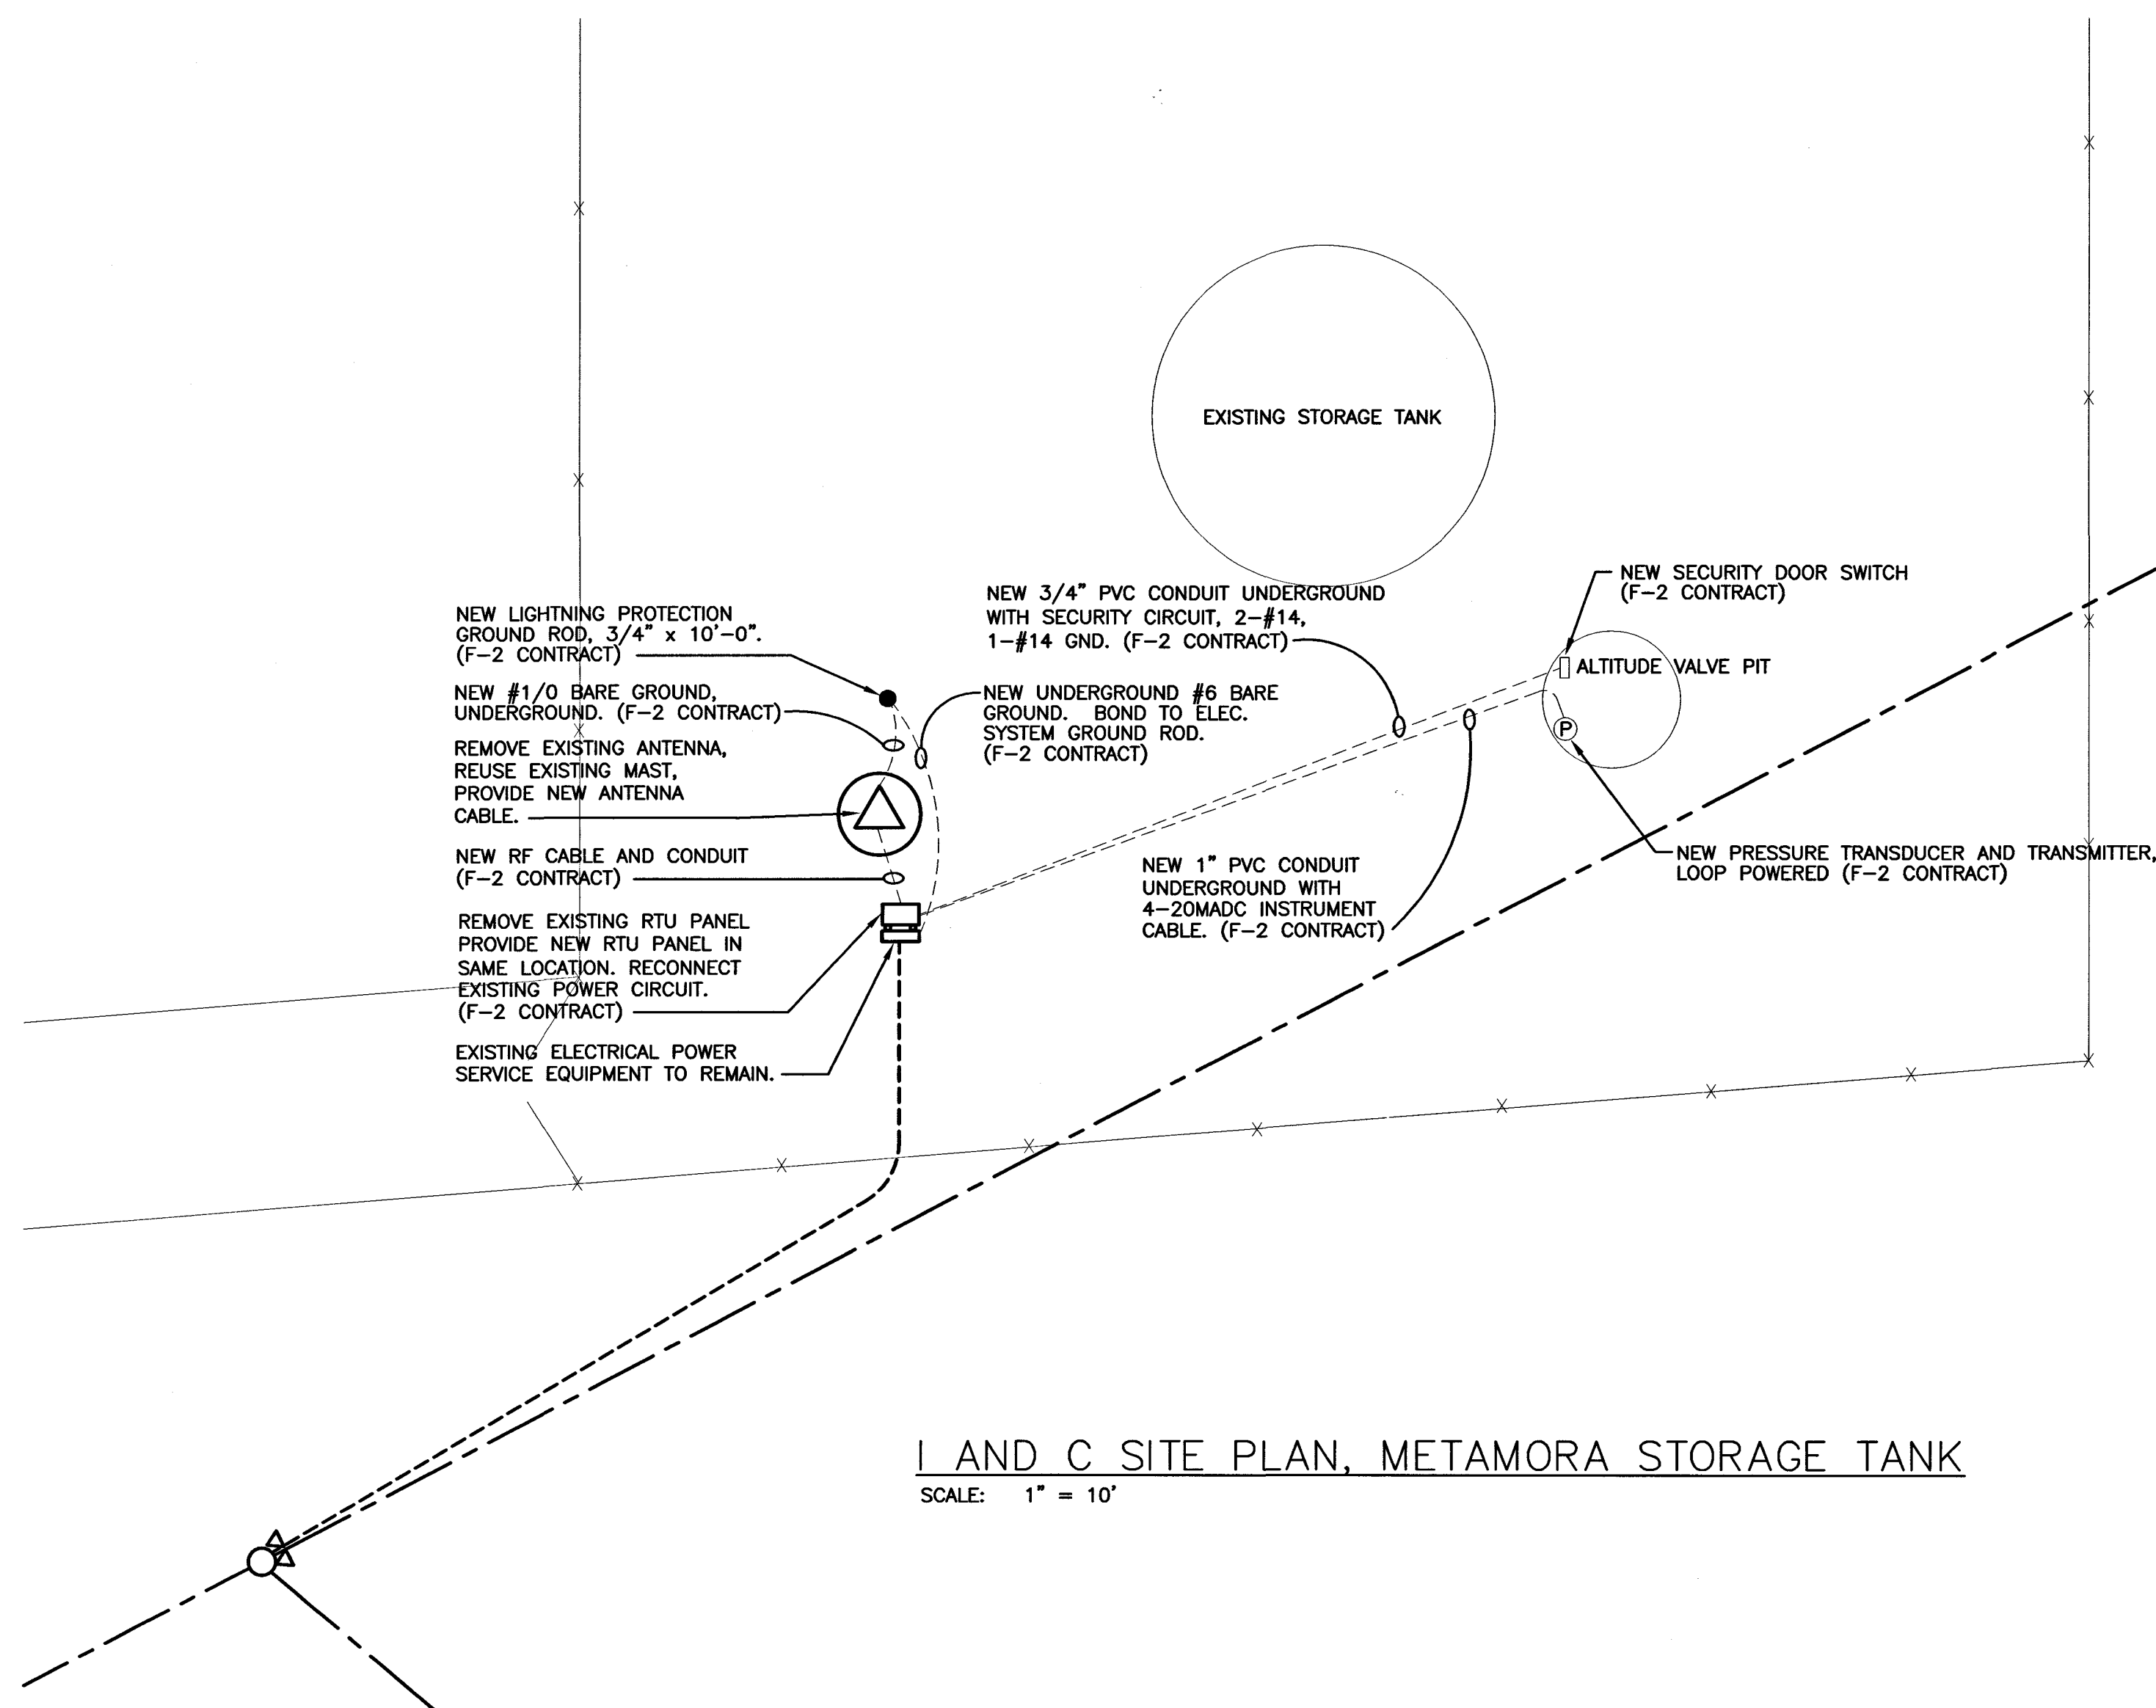


WELL FIELD
I AND C SITE PLAN
SCALE: 1" = 50'-0"

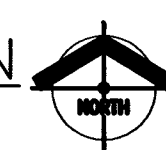


I AND C SITE PLAN, METAMORA STORAGE TANK
SCALE: 1" = 10'

NOTES:

J. W. SIMS
& ASSOCIATES
ENGINEERING COMPANY
1545 COUNTRY CLUB ROAD
INDIANAPOLIS, INDIANA 46234
(317) 209-4035 (FAX) 209-4036

NO.	DESCRIPTION	DATE	BY
1	AS-BUILT REVISION	5/2004	GCR
REVISIONS			

HOOSIER HILLS REGIONAL WATER DISTRICT
DIVISION "F" WATERWORKS SYSTEM IMPROVEMENTS
CONTRACT F-2
METAMORA TANK
I AND C SITE PLAN AND DETAILS
GRW PROJECT NO. 2745 JWSA PROJECT NO. 2001-05

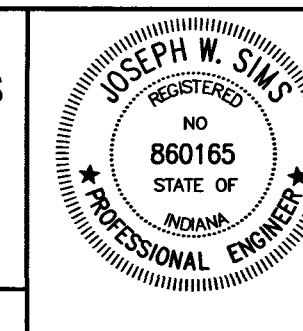

GRW Engineers, Inc.
Engineers, Architects, Planners
INDIANAPOLIS, INDIANA
LOUISVILLE & LEXINGTON, KENTUCKY
CINCINNATI, OHIO
NASHVILLE, TENNESSEE
ARLINGTON, TEXAS

DRAWN: JWS	DATE: NOVEMBER, 2001
FILE NAME: F2-E10_REVISED.DWG	SCALE: AS NOTED
CHECKED: JWS	SHEET NO.
APPROVED: JWS	E10/591