



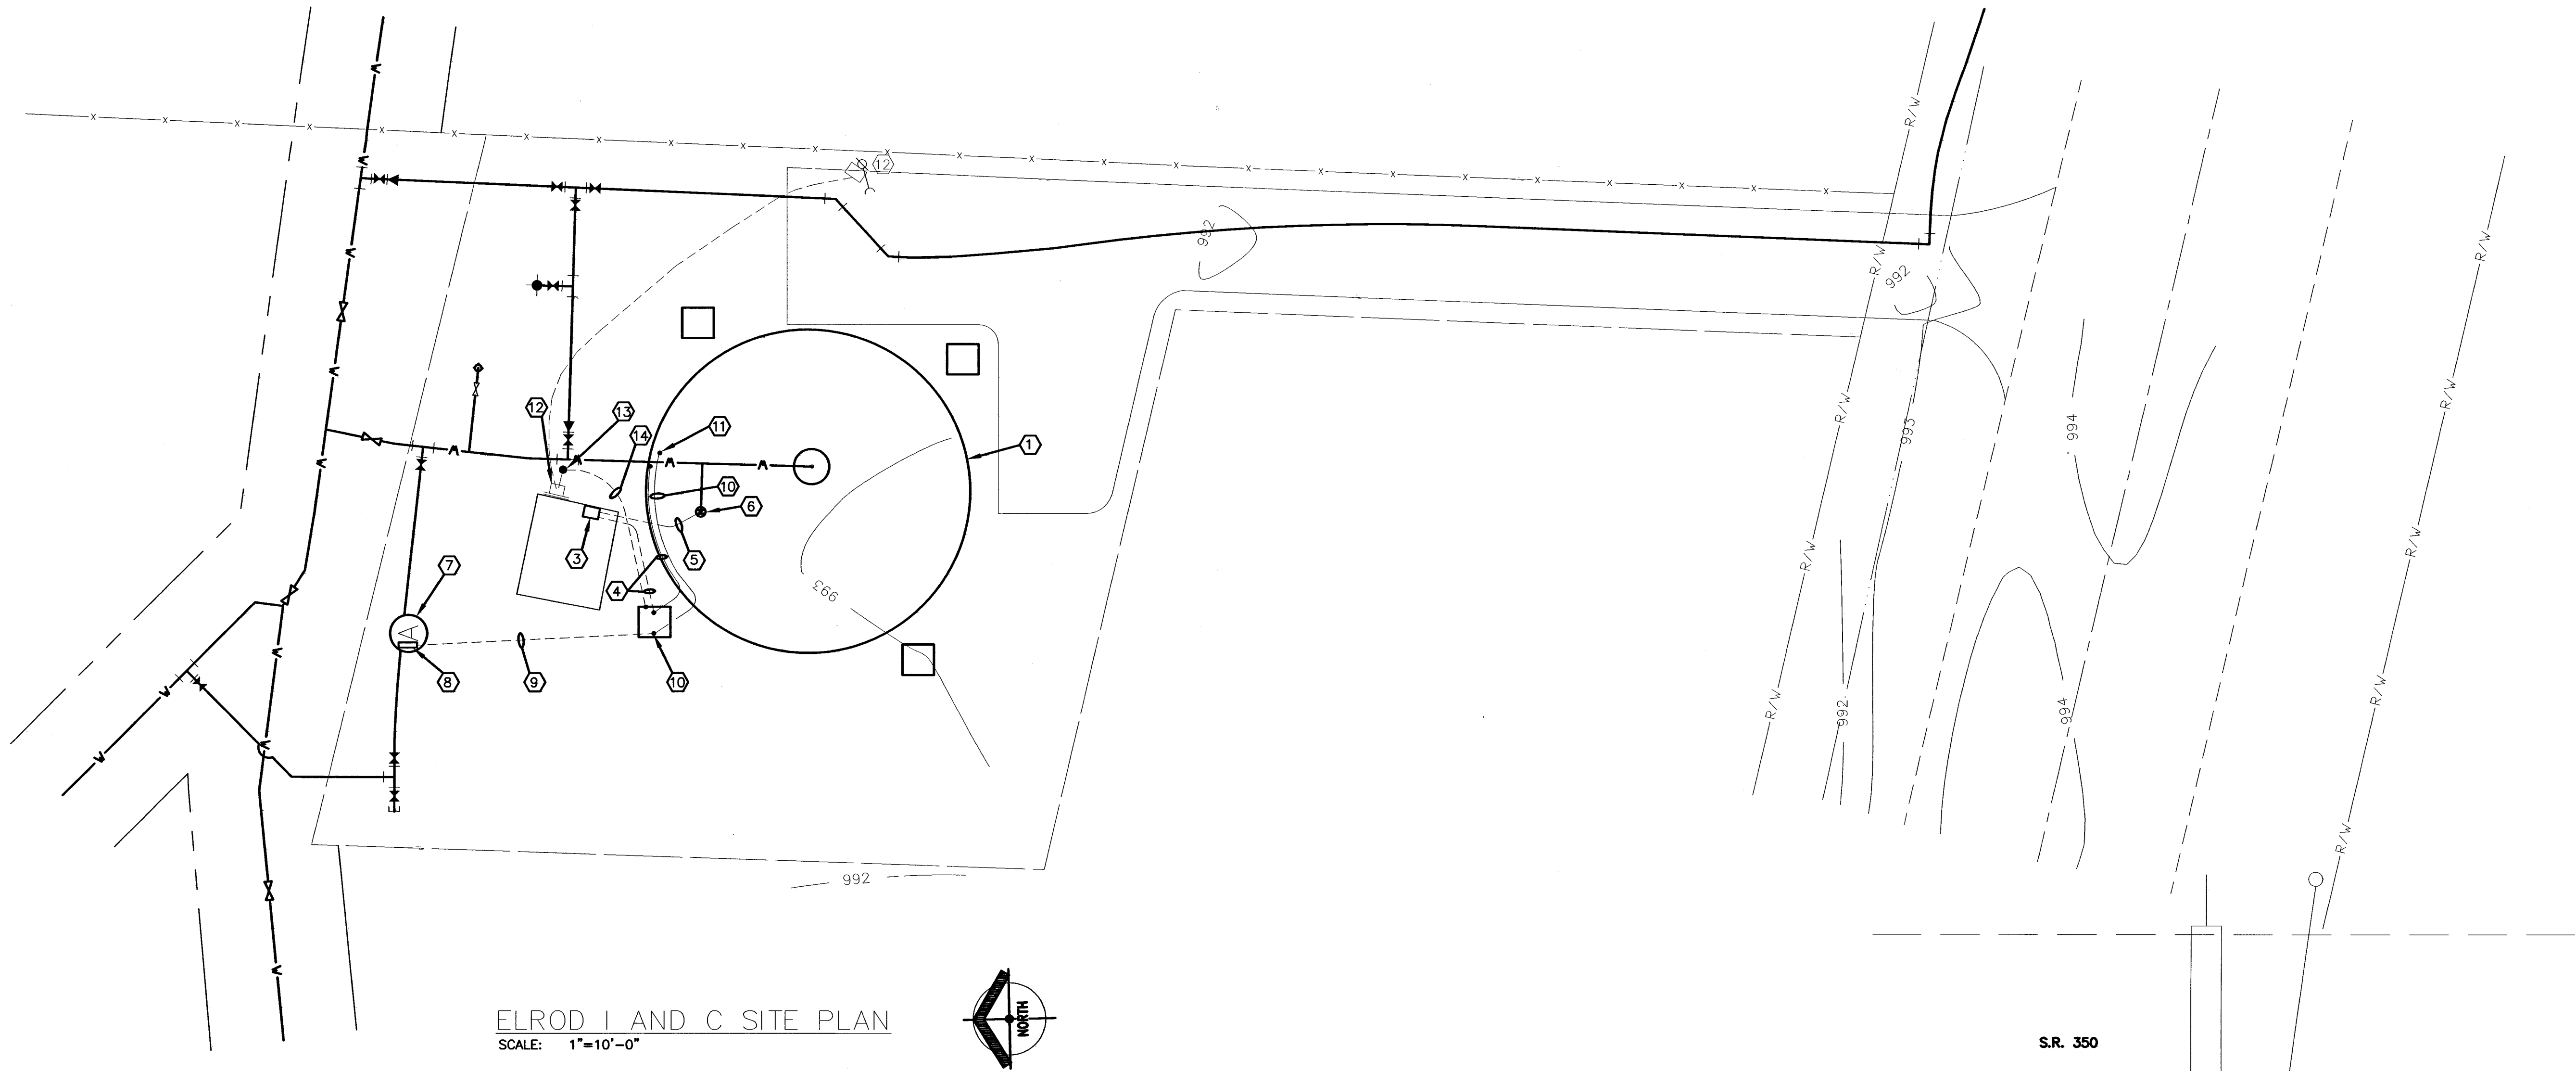

ELROD I AND C SITE PLAN
SCALE: 1"=10'-0"

ELROD ELECTRICAL PLAN NOTES:

- ① EXISTING ELEVATED WATER STORAGE TANK.
- ② EXISTING EQUIPMENT BUILDING.
- ③ REMOVE EXISTING RTU PANEL (F-2 CONTRACT).
- ④ REMOVE EXISTING SCADA SYSTEM RF CABLE AND ANTENNA (F-2 CONTRACT). OTHER EXISTING CABLE AND ANTENNA TO REMAIN.
- ⑤ REMOVE EXISTING PRESSURE SENSING LINE (F-2 CONTRACT).
- ⑥ REMOVE EXISTING PRESSURE SENSING HYDRAULIC/OIL SENDING UNIT (F-2 CONTRACT).
- ⑦ BELOW GRADE ALTITUDE VALVE VAULT.
- ⑧ I & C REMOTE TERMINAL UNIT PANEL AND SCADA SYSTEM RADIO TRANSCEIVER, INSIDE ALTITUDE VALVE VAULT (F-2 CONTRACT).
- ⑨ UNDERGROUND 2" CONDUIT WITH RF CABLE (F-2 CONTRACT).
- ⑩ SCADA SYSTEM RF CABLE ON TANK STRUCTURE (F-2 CONTRACT).
- ⑪ SCADA SYSTEM ANTENNA MAST AND ANTENNA ON WATER TANK STRUCTURE, NORTH SIDE RAILING (F-2 CONTRACT).
- ⑫ ELECTRICAL SYSTEM EQUIPMENT(F-1 CONTRACT).
- ⑬ ELECTRICAL SYSTEM GROUND ROD (F-1 CONTRACT).
- ⑭ #4 UNDERGROUND BARE GROUND. BOND ELECTRICAL SYSTEM GROUND ROD TO STEEL STRUCTURE OF WATER TANK (F-2 CONTRACT).

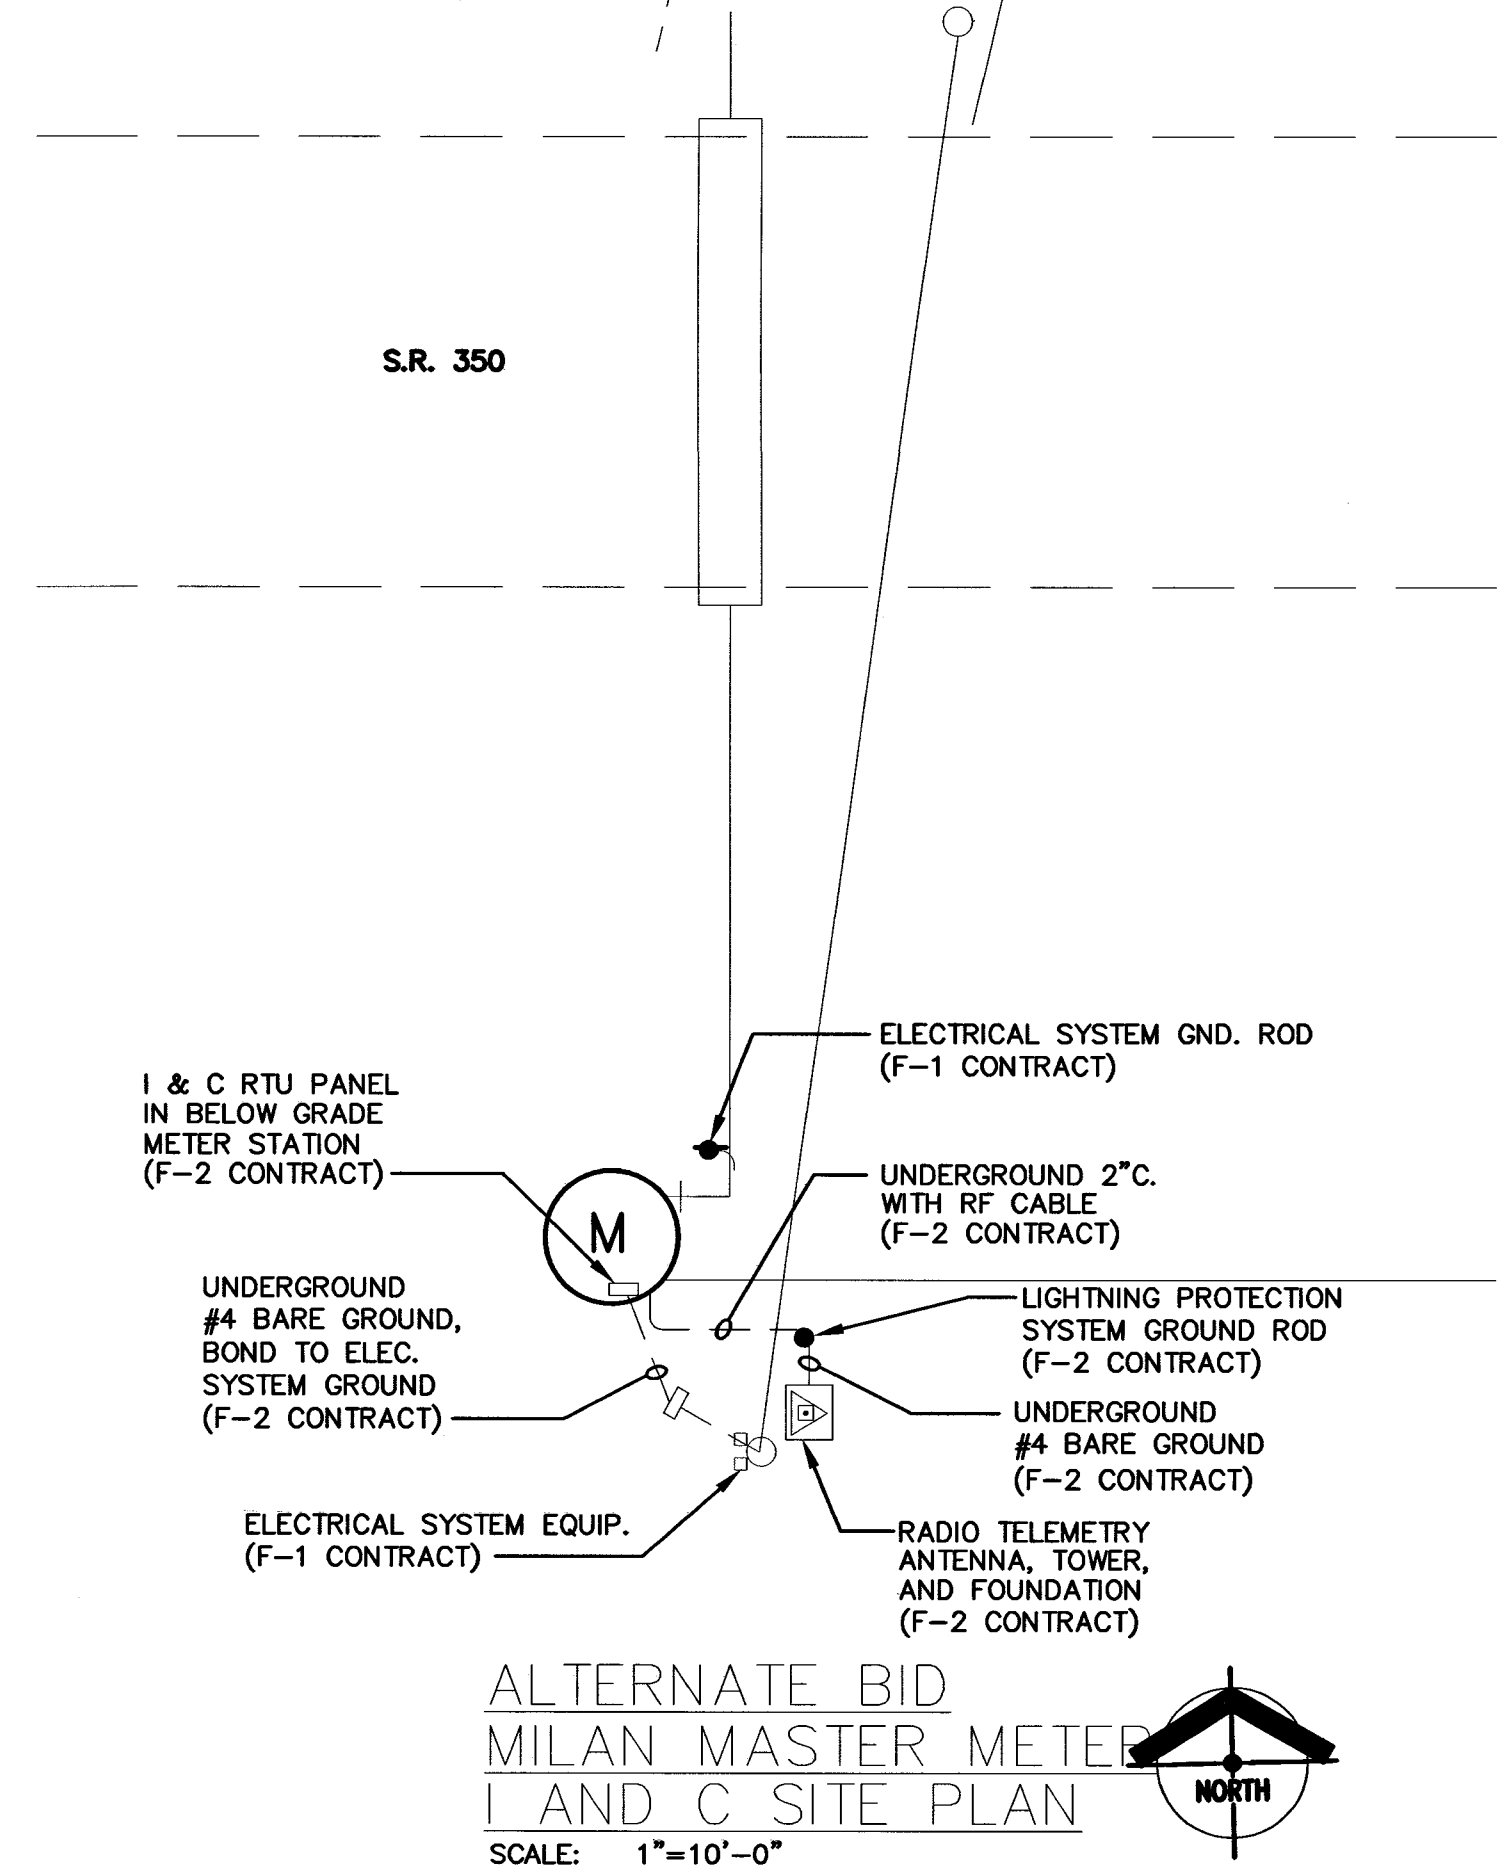

ALTERNATE BID
MILAN MASTER METER
I AND C SITE PLAN
SCALE: 1"=10'-0"


NOTES:

J. W. SIMS & ASSOCIATES
ENGINEERING COMPANY
1545 COUNTRY CLUB ROAD
INDIANAPOLIS, INDIANA 46234
(317) 209-4035 (FAX) 209-4035

NO.	DESCRIPTION	DATE	BY
1	AS-BUILT REVISION	5/2004	GCR
REVISIONS			

HOOSIER HILLS REGIONAL WATER DISTRICT
DIVISION "F" WATERWORKS SYSTEM IMPROVEMENTS
CONTRACT F-2

**ELROD TANK I AND C SITE PLAN &
MILAN MASTER METER I AND C SITE PLAN**
GRW PROJECT NO. 2745 JWSA PROJECT NO. 2001-05

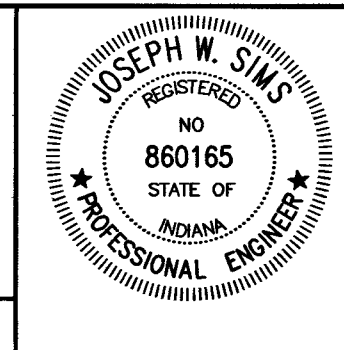

GRW Engineers, Inc.
Engineers, Architects, Planners
INDIANAPOLIS, INDIANA
LOUISVILLE & LEXINGTON, KENTUCKY
CINCINNATI, OHIO
NASHVILLE, TENNESSEE
ARLINGTON, TEXAS

DRAWN: JWS	DATE: NOVEMBER, 2001
FILE NAME: F2-E7_REVIS.DWG	SCALE: AS NOTED
CHECKED: JWS	SHEET NO. E7/588
APPROVED: JWS	