



I:\2745\dwg\JWS - IDEM Elec Submittal\FINAL SET NO-3 July 3, 2002 Set of Dwg and Specs\FINAL F2 ELEC DWGS\F2As-Built_Drawings\F2-E14_REVIS.DWG, 11/15/2004 12:38:10 PM

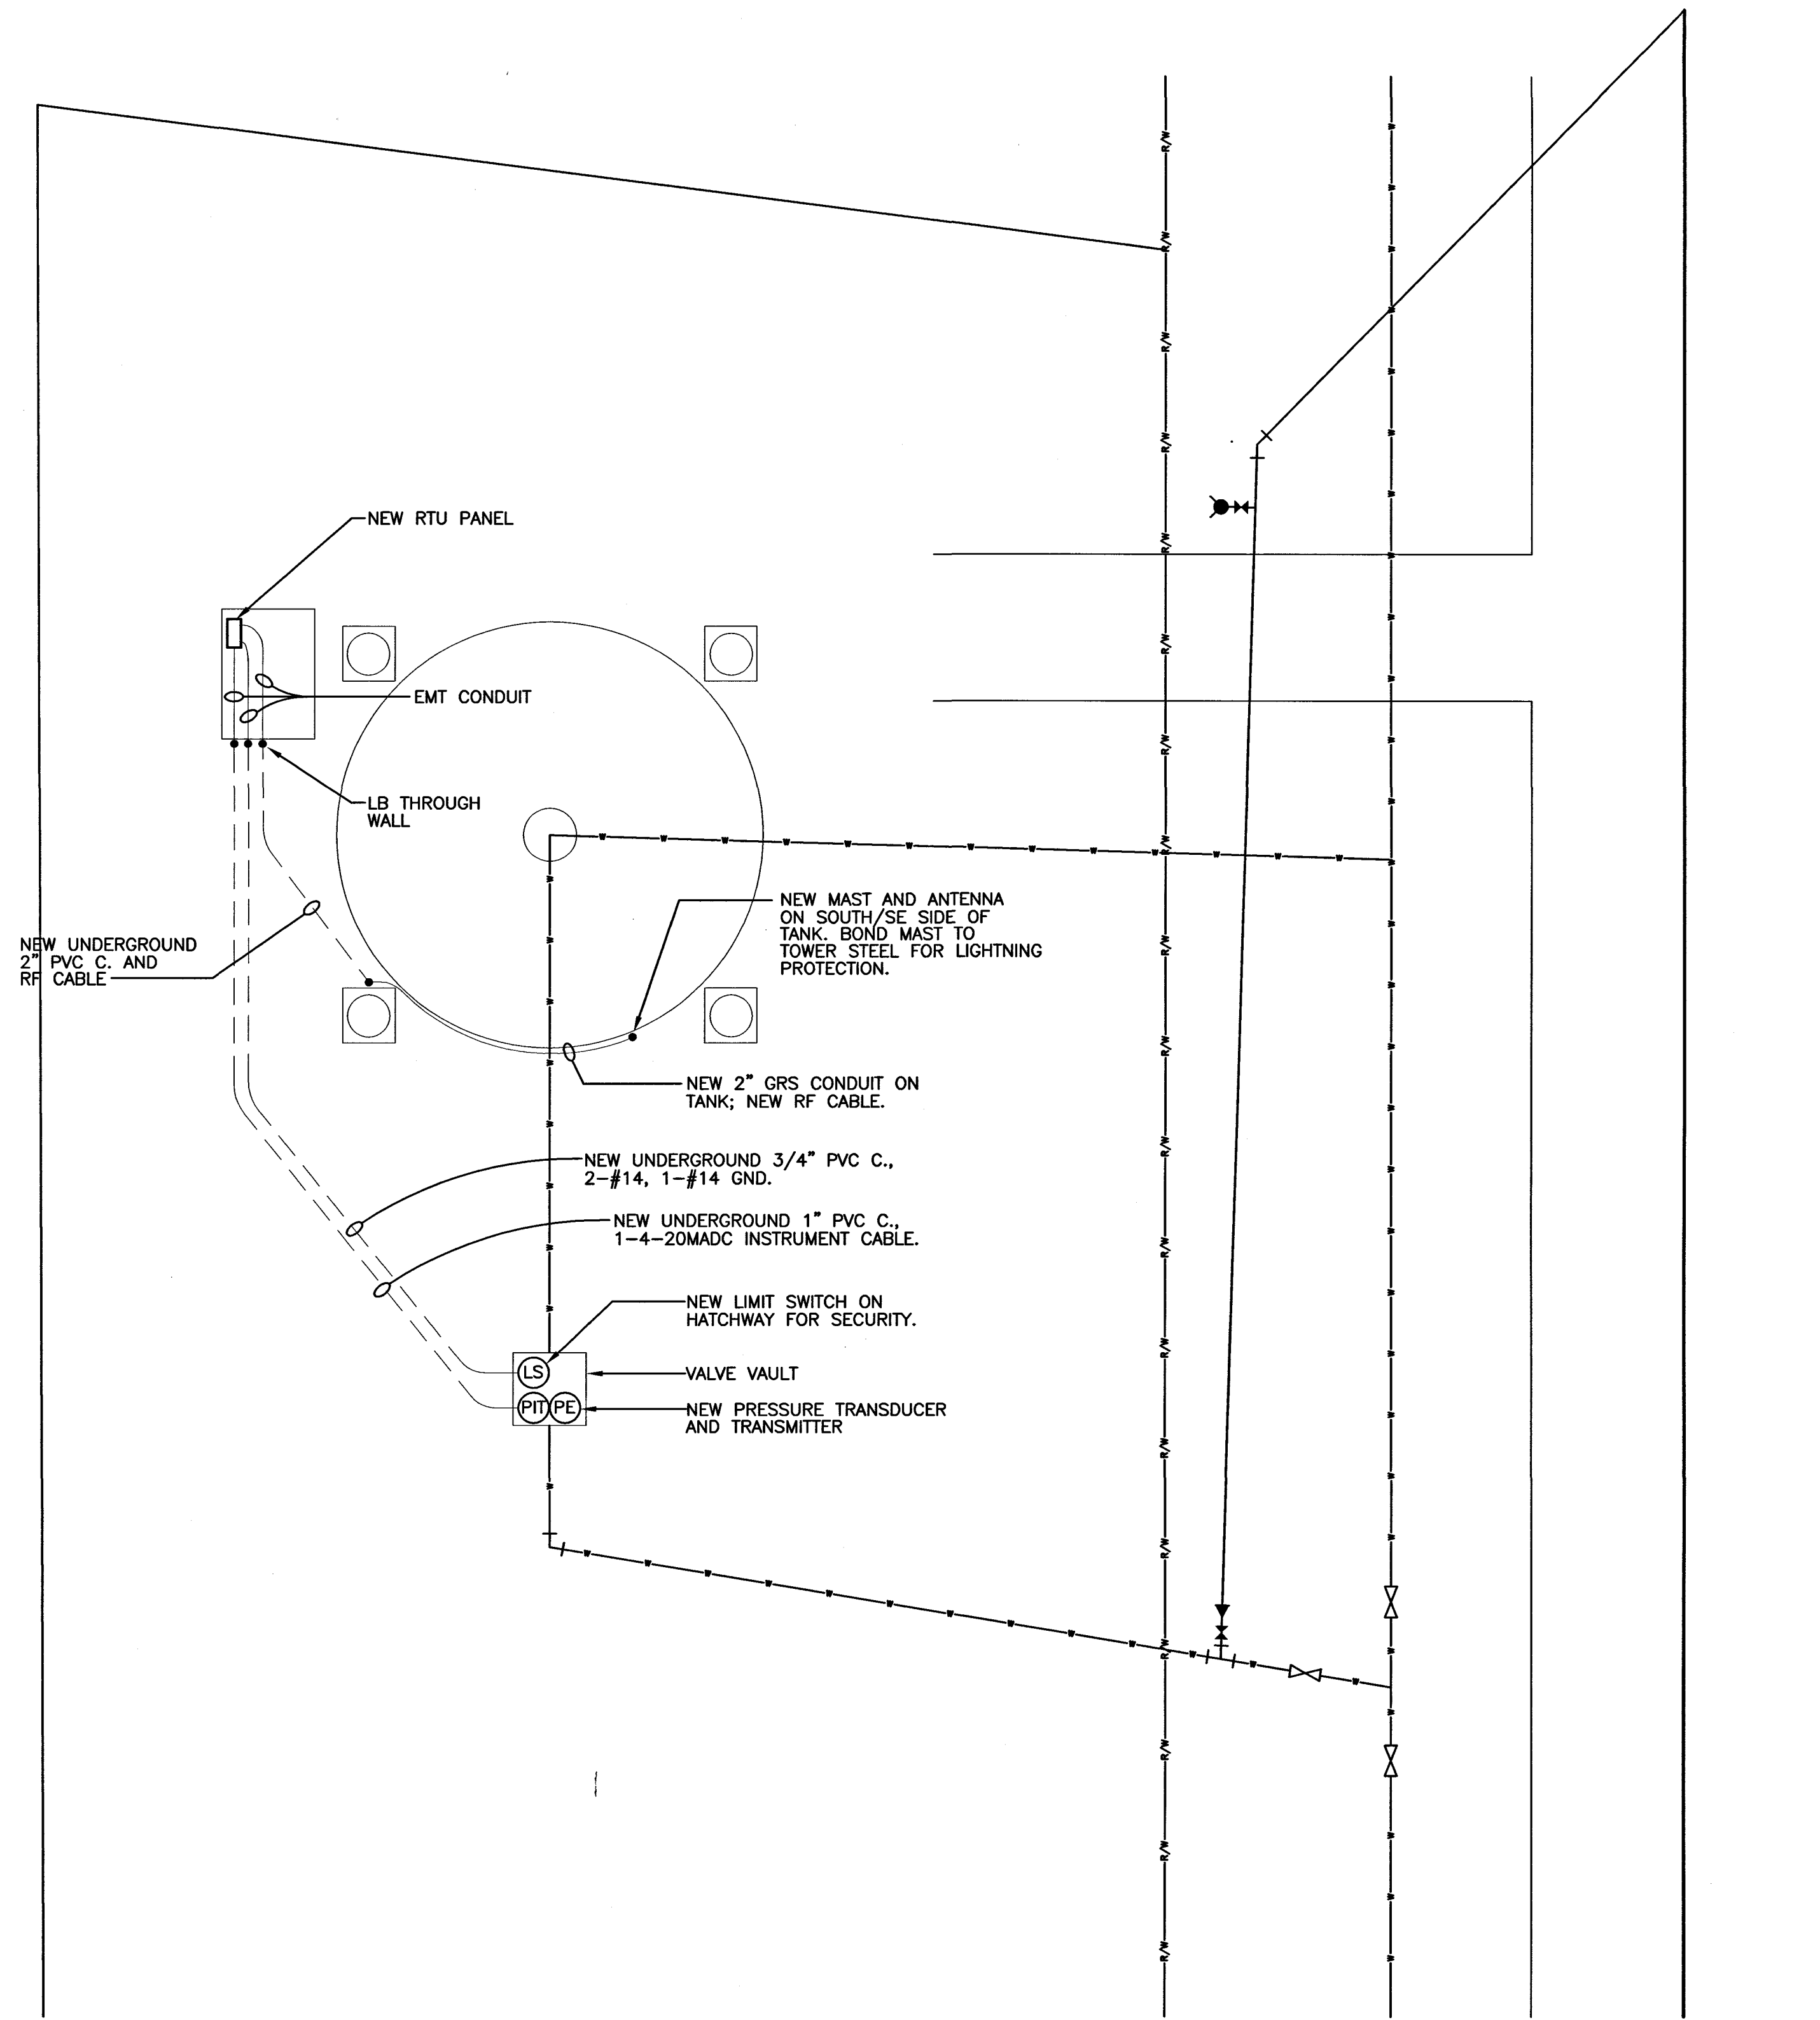

OLD MILAN TANK I AND C SITE PLAN
SCALE: 1" = 10'

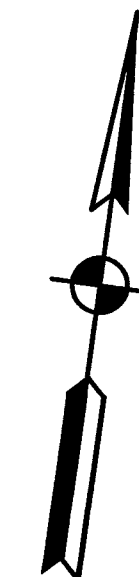

NOTES:


J. W. SIMS
& ASSOCIATES
ENGINEERING COMPANY
1545 COUNTRY CLUB ROAD
INDIANAPOLIS, INDIANA 46234
(317) 209-4035 (FAX) 209-4035

NO.	DESCRIPTION	DATE	BY
1	AS-BUILT REVISION	5/2004	GCR
REVISIONS			

HOOSIER HILLS REGIONAL WATER DISTRICT
DIVISION "F" WATERWORKS SYSTEM IMPROVEMENTS
CONTRACT F-2

OLD MILAN TANK
I AND C SITE PLAN AND DETAILS

GRW PROJECT NO. 2745
JWSA PROJECT NO. 2001-05

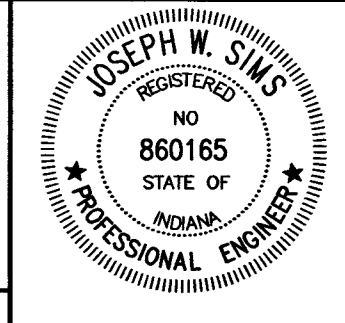

GRW
GRW Engineers, Inc.
Engineers, Architects, Planners
INDIANAPOLIS, INDIANA
LOUISVILLE & LEXINGTON, KENTUCKY
CINCINNATI, OHIO
NASHVILLE, TENNESSEE
ARLINGTON, TEXAS

DRAWN: JWS/JMS	DATE: NOVEMBER, 2001
FILE NAME: F2-E14_REVIS.DWG	SCALE: AS NOTED
CHECKED: JWS	SHEET NO. E14/595
APPROVED: JWS	