


HOOSIER HILLS REGIONAL WATER DISTRICT DIVISION  
"F" WATERWORKS SYSTEM IMPROVEMENTS  
CONTRACT "F-3"  
SOUTH MILAN TANK

SITE VICINITY MAP

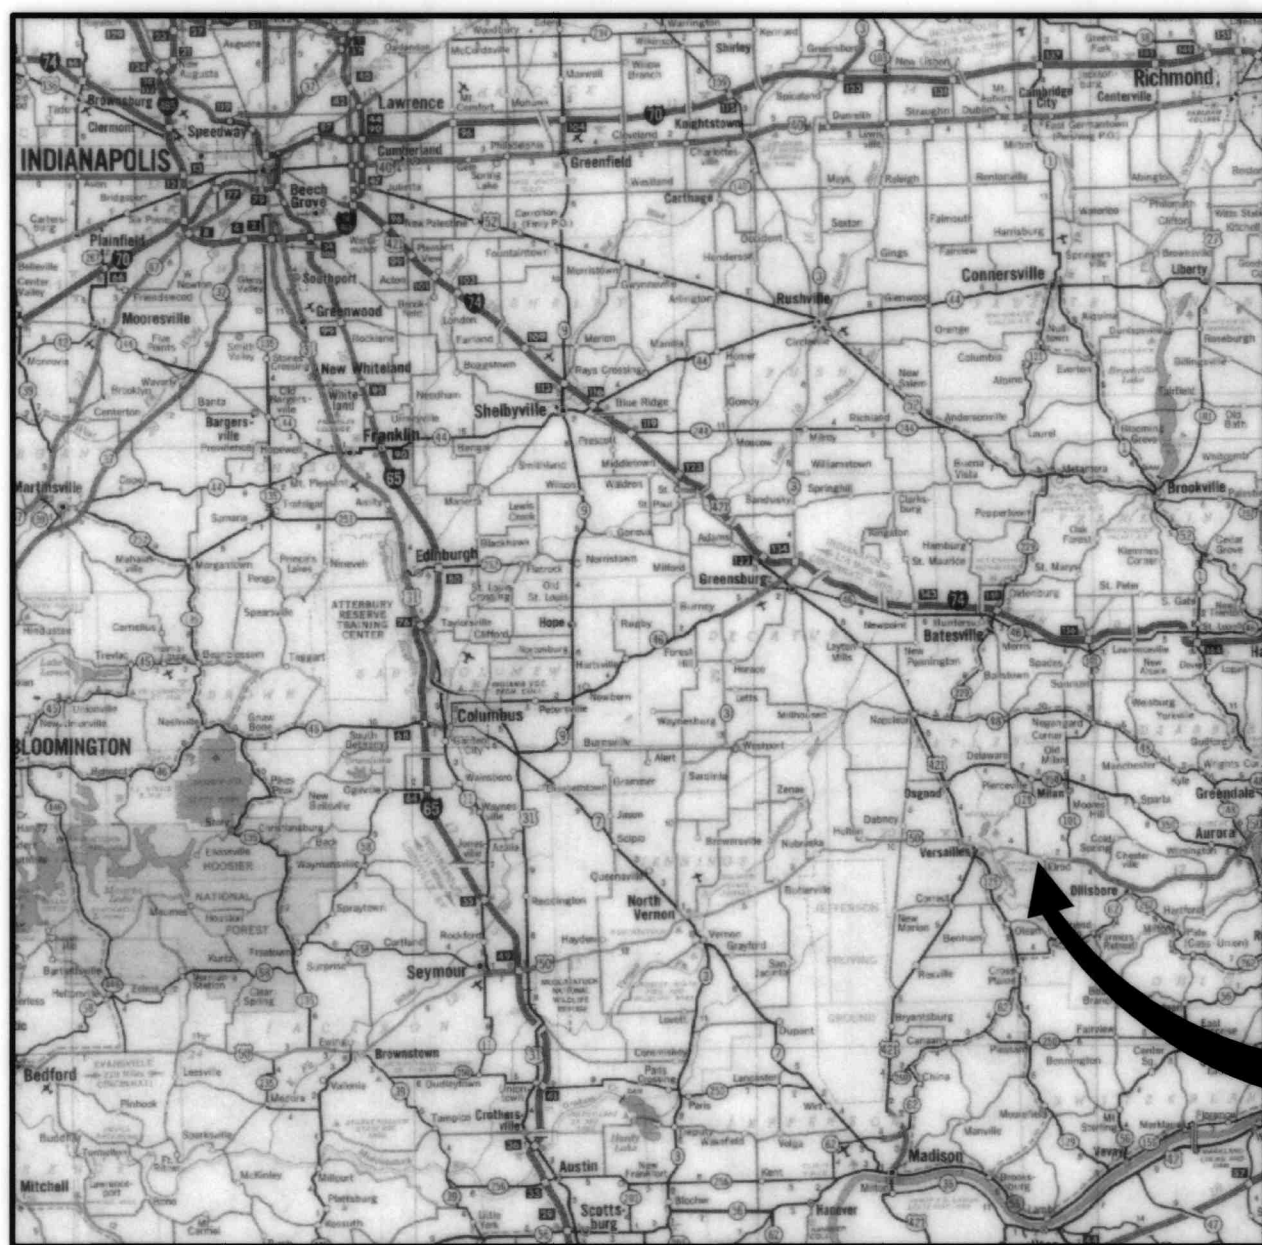


PROJECT LOCATION

RECORD DRAWING

This drawing has been revised from the original contract drawing to show minor/ major changes made during construction. This drawing is not warranted to be complete and accurate in all respects.

GRW Engineers, Inc.

Date: 5/2004 By: MB

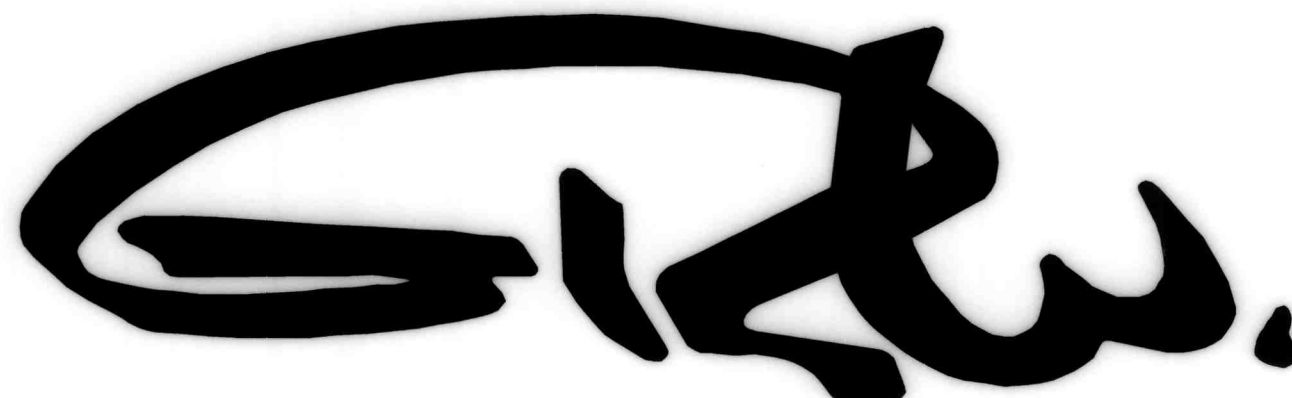

GRW Engineers, Inc.


7112 WALDEMAR DRIVE  
INDIANAPOLIS, IN. 46268  
(317) 347-3650

INDIANAPOLIS, INDIANA  
LEXINGTON & LOUISVILLE, KENTUCKY  
NASHVILLE, TENNESSEE  
ARLINGTON, TEXAS  
CINCINNATI, OHIO

INDEX OF DRAWINGS

SHEET NO.	DESCRIPTION
---	COVER SHEET
596	SOUTH MILAN TANK SITE PLAN
597	SOUTH MILAN TANK DETAILS
598	WATER MAIN DETAILS
599	EROSION CONTROL DETAILS
E1/600	SOUTH MILAN TANK ELECTRICAL SITE PLAN
E2/601	SOUTH MILAN TANK ELECTRICAL DETAILS

SITE LOCATION MAP

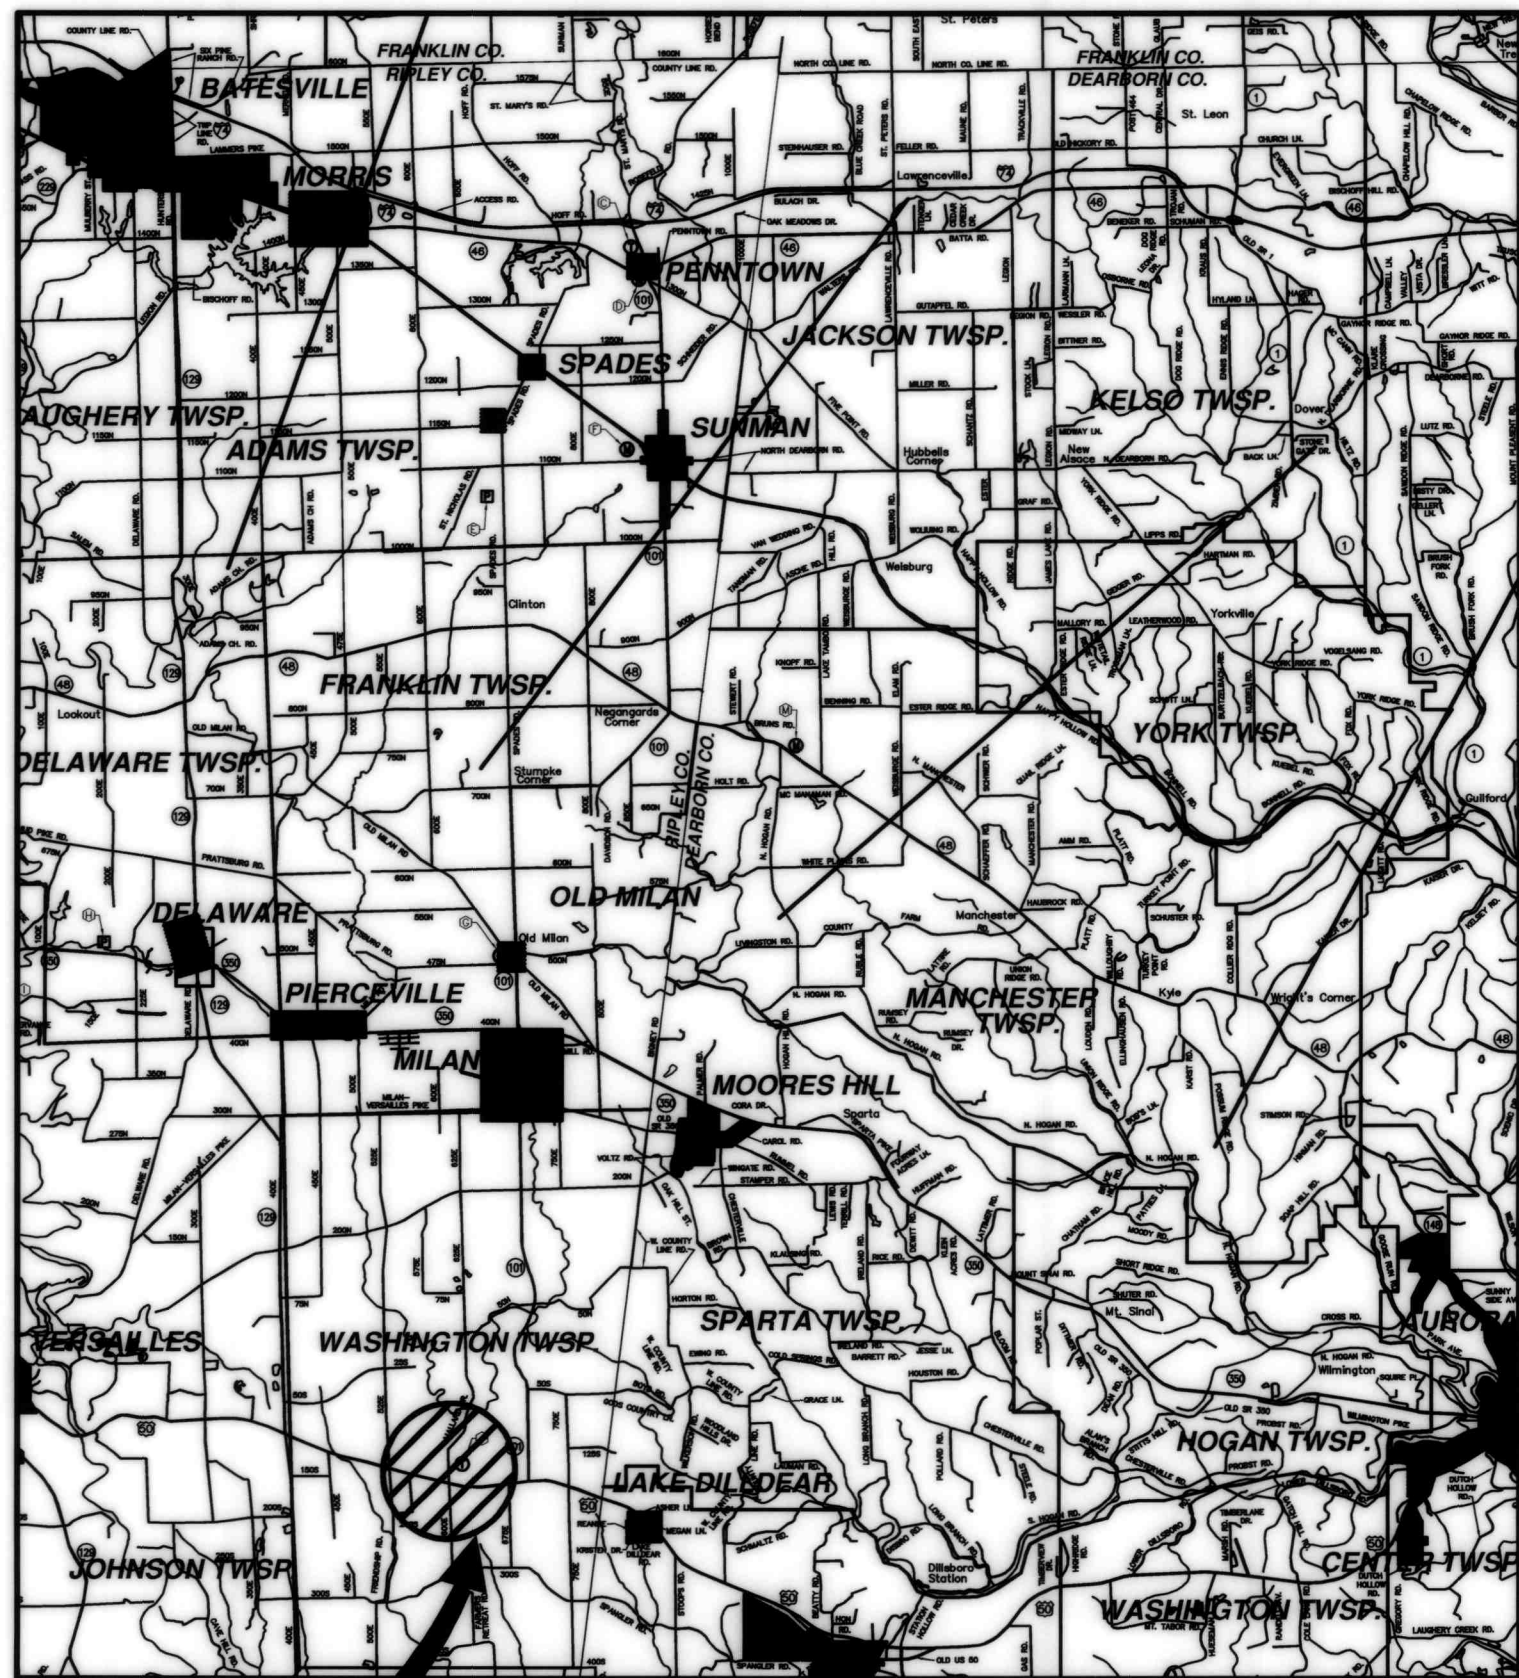


PROPOSED WATER  
TANK LOCATION

HOOSIER HILLS REGIONAL WATER  
DISTRICT BOARD OF DIRECTORS

GREGORY DOLE - PRESIDENT	TED MEER - BOARD MEMBER
ANDREW WEISENBACH - VICE PRESIDENT	WILLIAM SHECKLES - BOARD MEMBER
HELEN GRIGSBY - TREASURER	JOHN J. AMBERGER - BOARD MEMBER
ALREENA HORTON - SECRETARY & ASST. TREASURER	WILLIAM BLYSHAK - BOARD MEMBER
CHUCK FOLZ - BOARD MEMBER	SCOTT STIRN - GENERAL MANAGER

JULY 2002

GREGORY A. WRIGHT, P.E.  
INDIANA REG. NO. 19300607  
DATE 5/2004

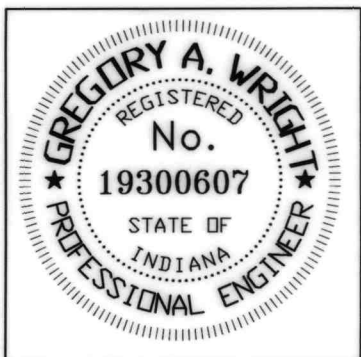

GRW PROJECT NO. 2745-04