


WATER LINE EXTENSIONS

CITY OF LOBELVILLE, TENNESSEE

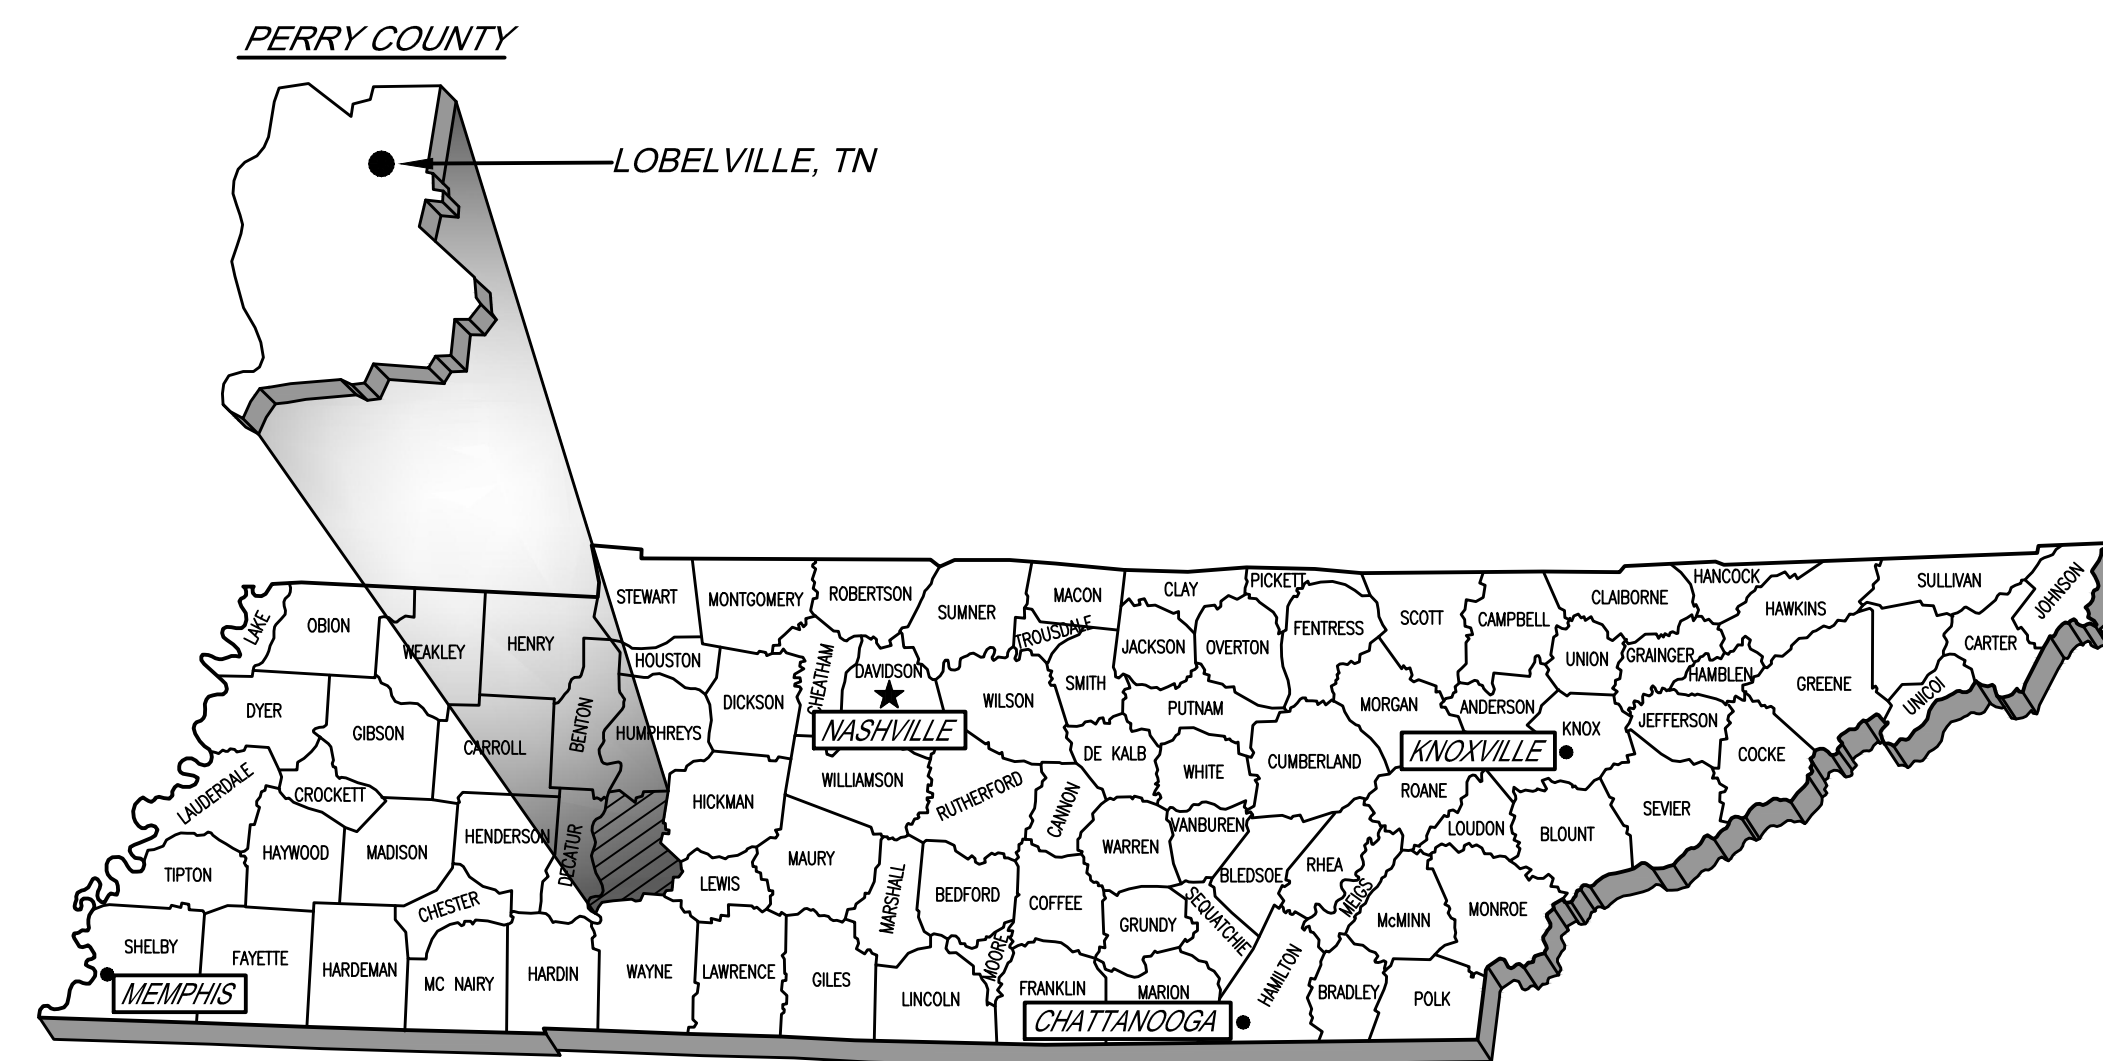

VICINITY MAP
NOT TO SCALE

DWG. No.	INDEX OF DRAWINGS
1 -	VICINITY MAP, LEGEND & GENERAL NOTES
2 -	JONES HOLLOW RD. - STA. 0+00 TO STA. 47+00
3 -	JONES HOLLOW RD. - 47+00 TO STA. 81+80 E.O.L. LAGOON RD. - STA. 0+00 TO STA. 35+00 JAYBIRD RD. (WEST) - STA. 0+00 TO STA. 42+95 E.O.L. JAYBIRD RD. (EAST) - STA. 0+00 TO STA. 16+80 E.O.L.
4 -	LAGOON RD. - STA. 35+00 TO STA. 84+50 E.O.L.
5 -	STANDARD WATER LINE DETAILS
6 -	STANDARD WATER LINE DETAILS
7 -	EROSION CONTROL STANDARD DETAILS



GRW Engineers, Inc.
Engineers, Architects, Planners

801 CORPORATE DRIVE - LEXINGTON, KY. 40503
PH. (859)223-3999 FAX (859)223-8917
LEXINGTON LOUISVILLE NASHVILLE INDIANAPOLIS
FORT MITCHELL KNOXVILLE ARLINGTON



APRIL, 2009

GRW PROJECT NO. 3827-01