


DEER CREEK WATER LINE EXTENSION CDBG CONTRACT NO. GG-10-31406-00


CITY OF LOBELVILLE, TENNESSEE STANDPIPE WATER STORAGE TANK

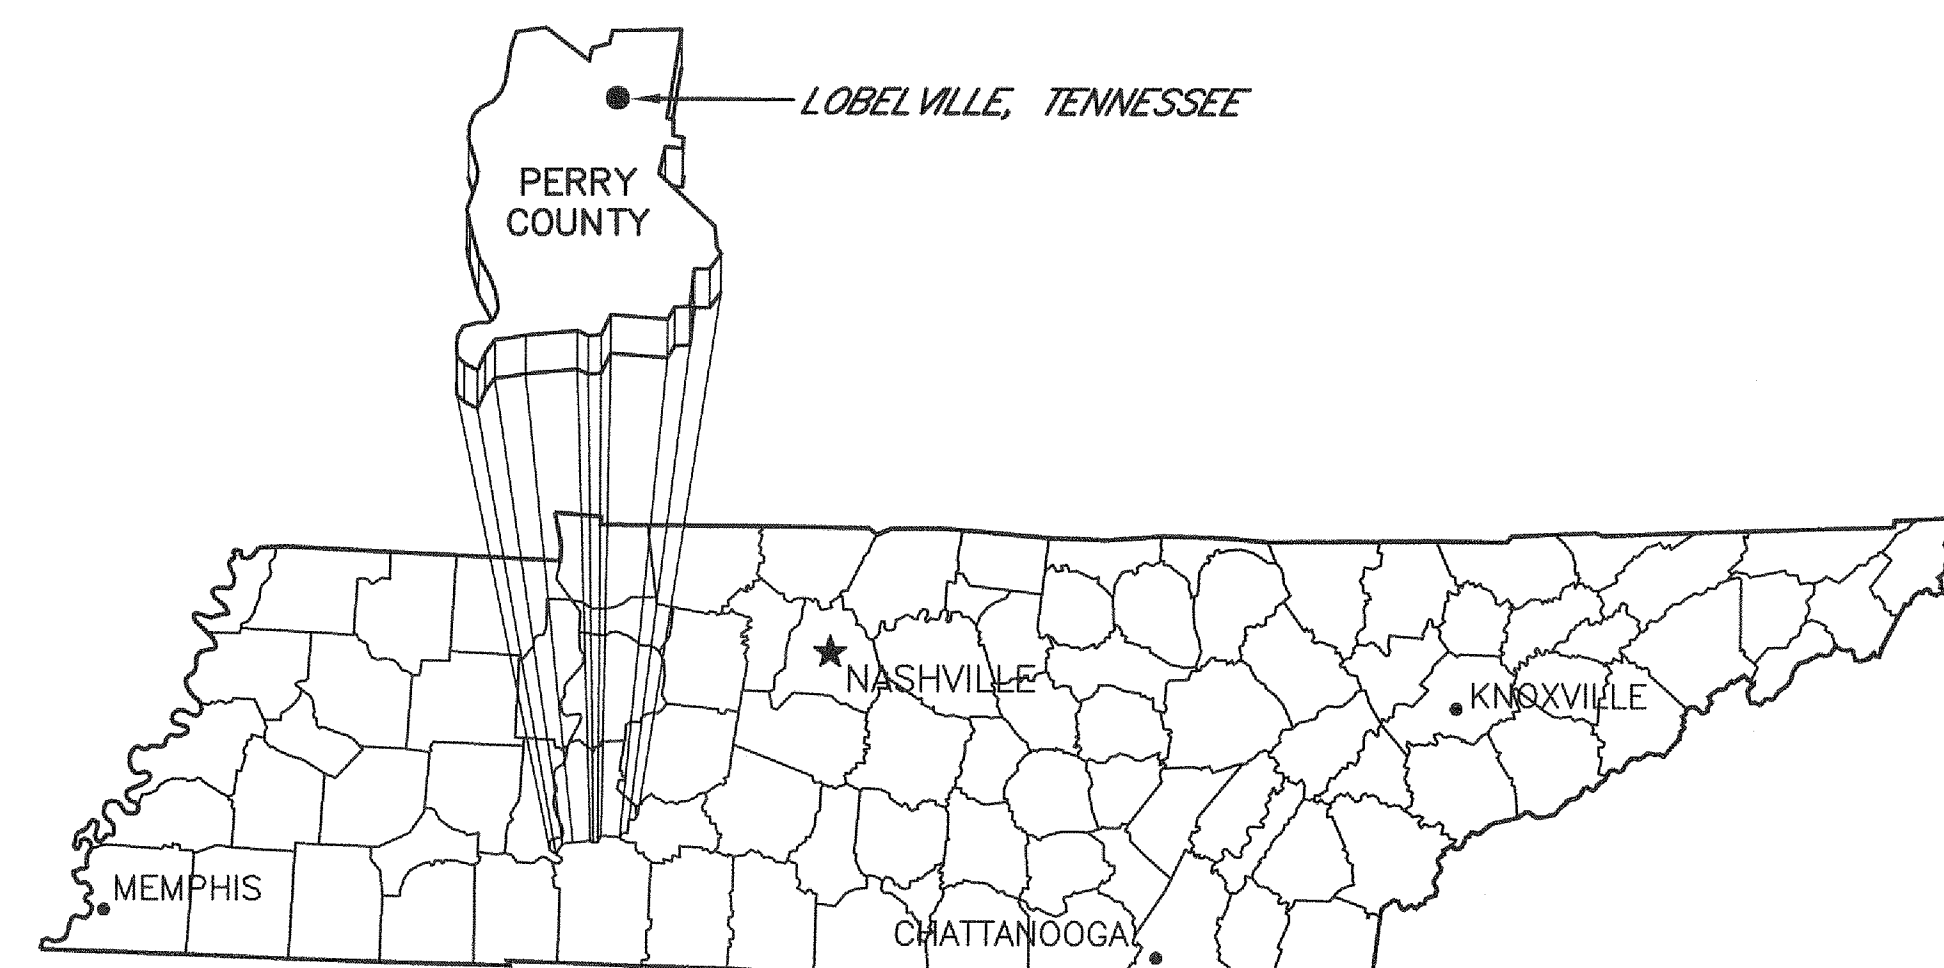

TENNESSEE VICINITY MAP
NOT TO SCALE


DWG. No. INDEX OF DRAWINGS

- C-00 - COVER
- C-01 - GENERAL NOTES, LEGEND, PROJECT AREA MAP
- C-02 - STANDPIPE STORAGE TANK
ELEVATION AND PLANS
- C-03 - STANDARD TANK SITE DETAILS
- C-04 - STANDARD WATER LINE DETAILS
- C-05 - STANDARD EROSION CONTROL DETAILS

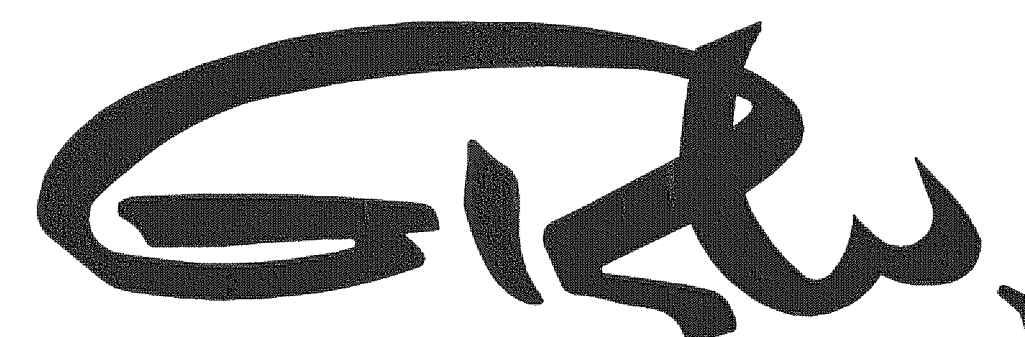

GRW Engineers, Inc.
Engineers, Architects, Planners

404 BNA DRIVE - NASHVILLE, TN. 37217
PH. (615)366-1600 FAX (615)366-0406
LEXINGTON LOUISVILLE NASHVILLE INDIANAPOLIS
FORT MITCHELL KNOXVILLE ARLINGTON

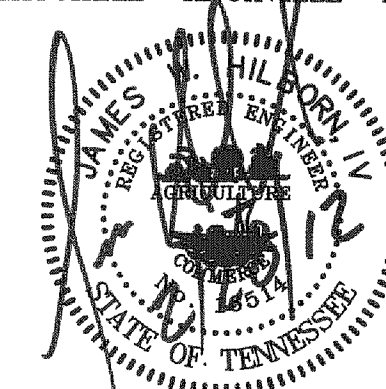

MARCH 2011

GRW PROJECT NO. 3827