


STATE HIGHWAY 13 WATER LINE INTERCONNECTION CDBG CONTRACT

CITY OF LOBELVILLE, TENNESSEE

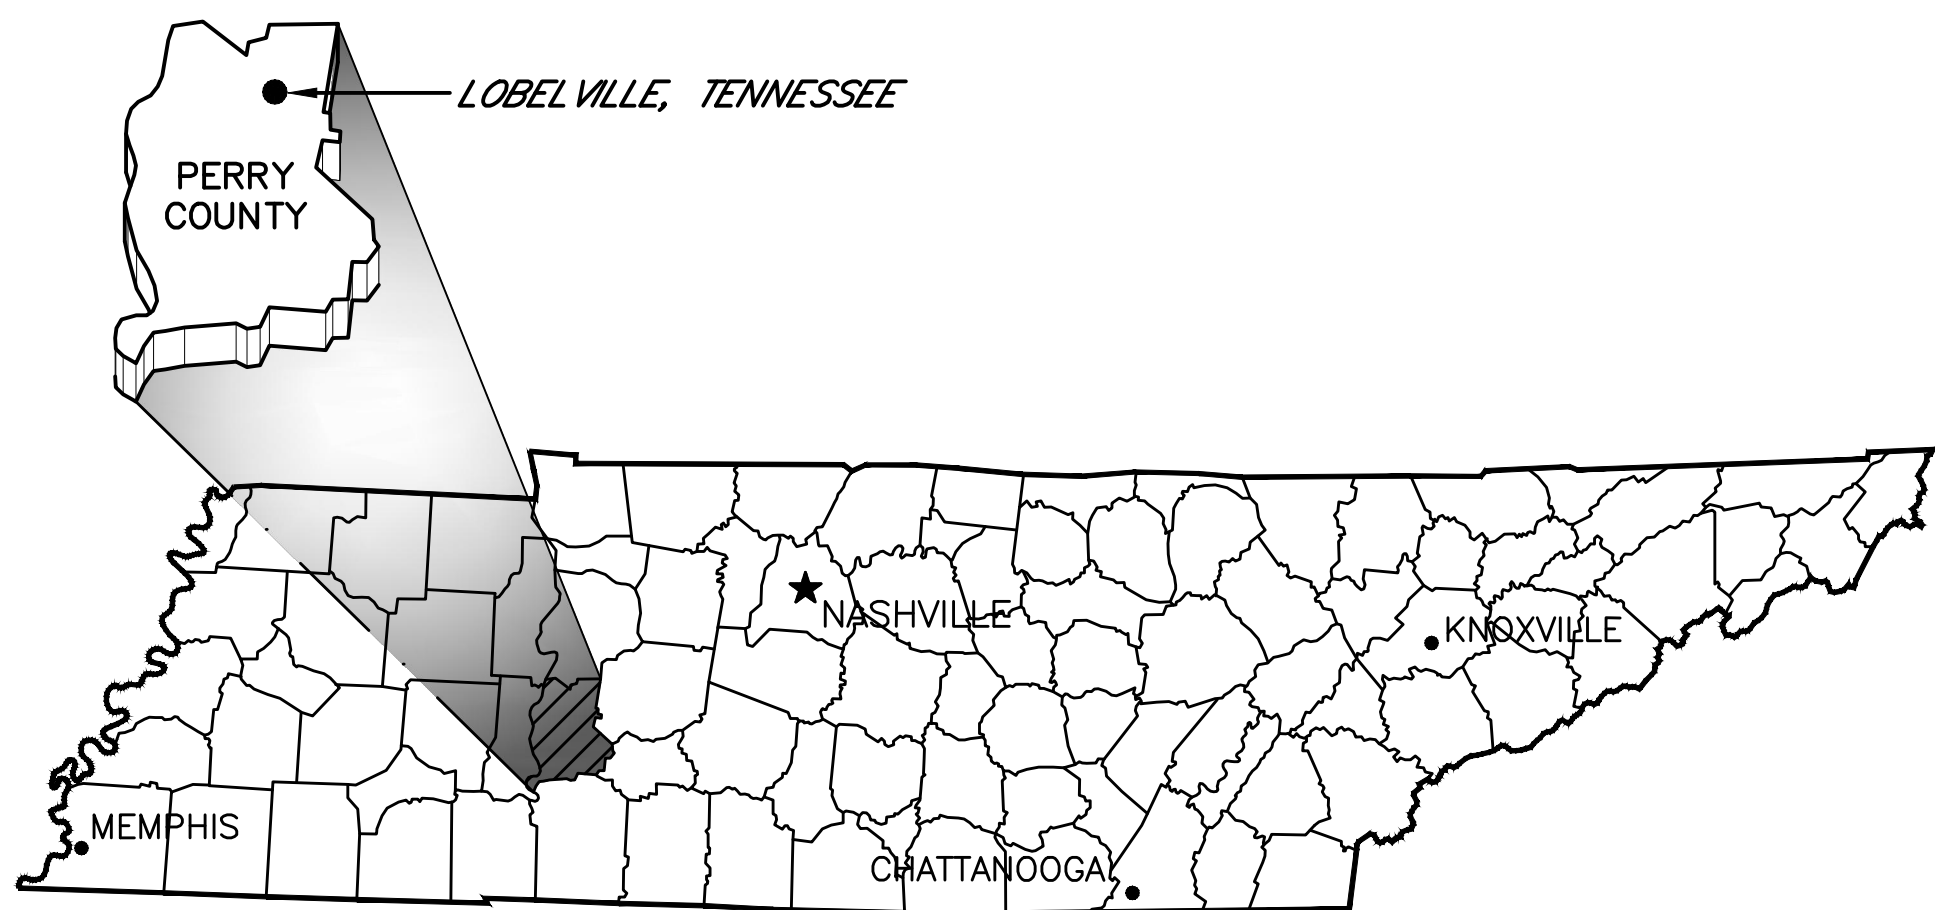

TENNESSEE VICINITY MAP
NOT TO SCALE

DWG. No.	INDEX OF DRAWINGS
C-01 -	GENERAL NOTES, PROJECT AREA MAP AND LEGEND
C-02 -	PROJECT KEYMAP
C-03 -	HIGHWAY 13 - 8" PVC WATER LINE - STA. 0+00 TO STA. 60+00
C-04 -	HIGHWAY 13 - 8" PVC WATER LINE - STA. 60+00 TO STA. 67+35 E.O.L.
C-05 -	LOBELVILLE-LINDEN PUMP STATION - PLAN, SECTION AND DETAILS
C-06 -	STANDARD WATER LINE DETAILS
C-07 -	STANDARD WATER LINE DETAILS
C-08 -	EROSION CONTROL - STANDARD DETAILS
E- 1 -	WATER TREATMENT PLANT - GENERATOR LOCATION AND DETAILS




ENGINEERS - ARCHITECTS - PLANNERS

www.grwinc.com

This document, originally issued, sealed, and signed by JAMES W. HILBORN, Tennessee Professional Engineer, No. 16514, on 4-08-2013, shall not be used in lieu of a certified document.

OCTOBER 2010

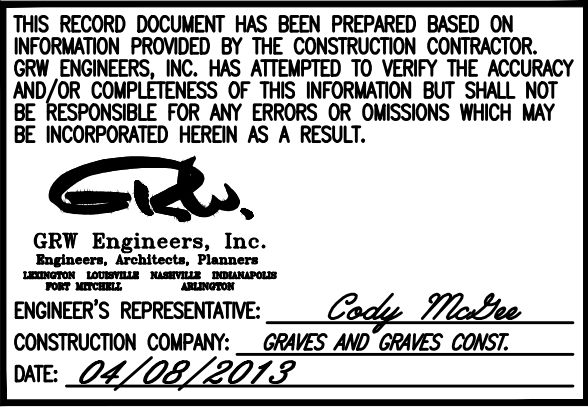

GRW PROJECT NO. 3827-03