


# 2012-D DISASTER RECOVERY EMERGENCY WATER CONNECTION IMPROVEMENTS CDBG CONTRACT NO. 34821

## CITY OF LOBELVILLE, TENNESSEE

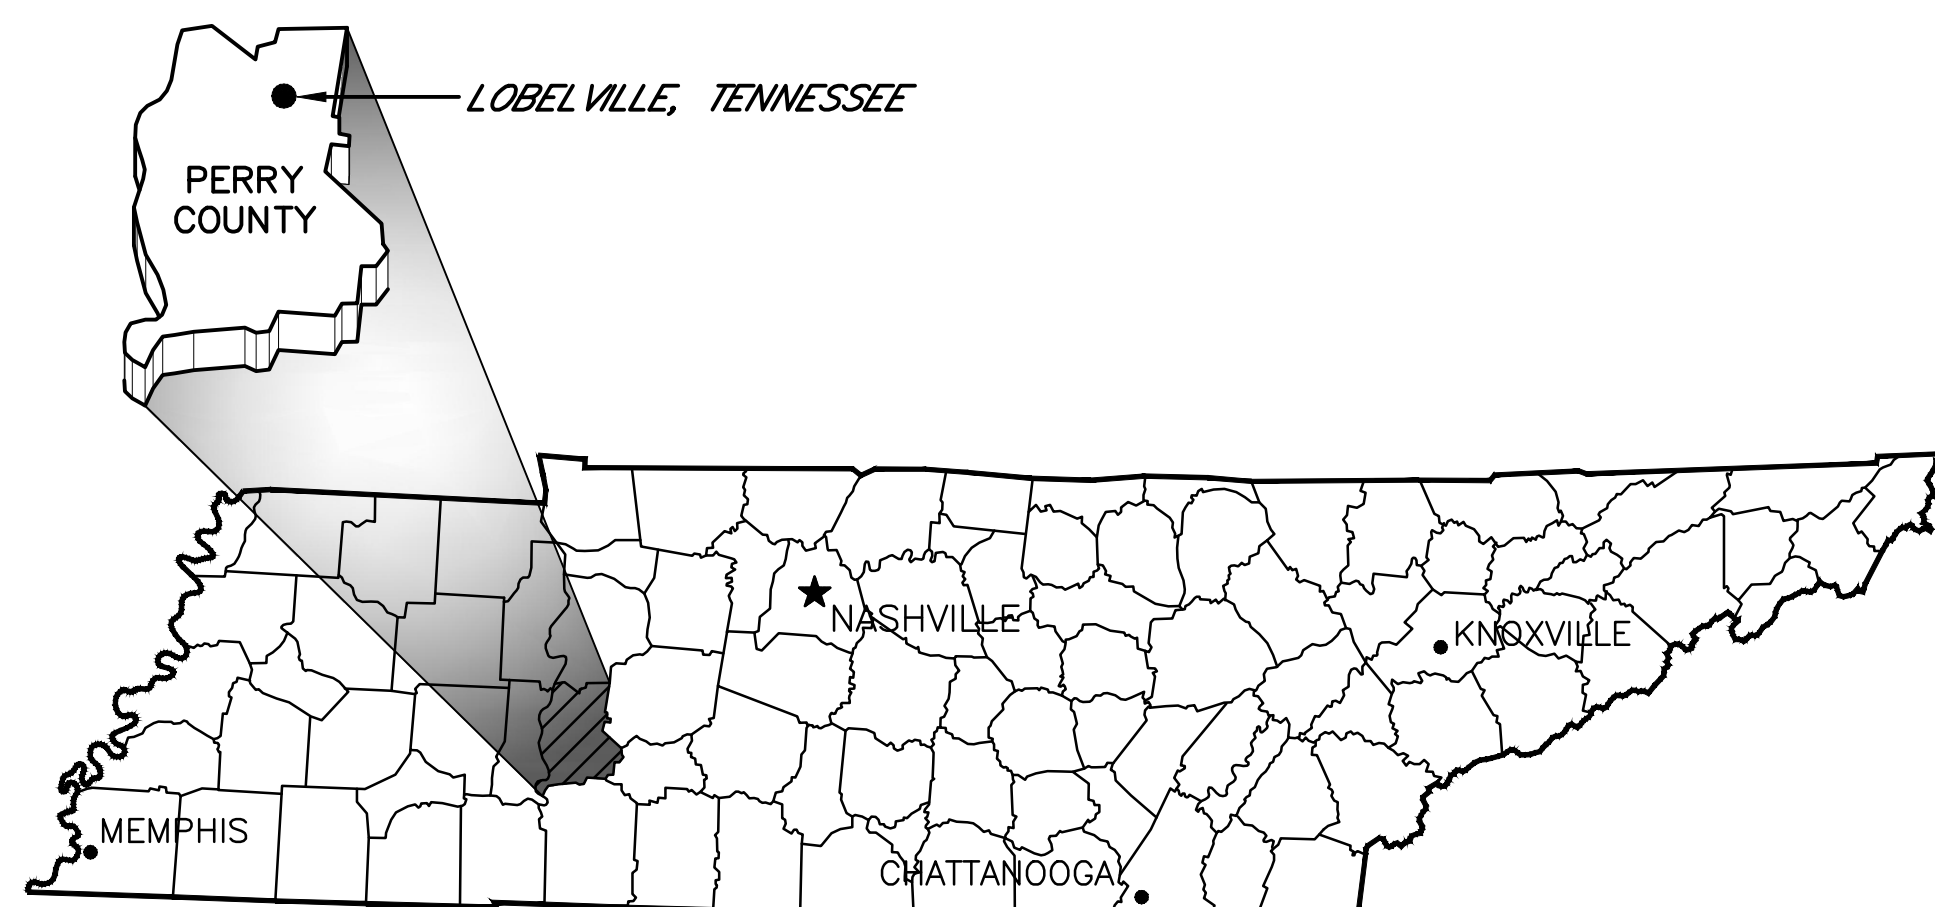


TENNESSEE VICINITY MAP  
NOT TO SCALE

DWG. No.	INDEX OF DRAWINGS
C-0-01 -	GENERAL NOTES, LEGEND AND EROSION SEDIMENT CONTROL NOTES
C-0-02 -	PROJECT AREA MAP AND PROJECT SHEET KEYMAP
C-0-03 -	12" WATER LINE - STA. 0+00 TO STA. 57+00
C-0-04 -	12" WATER LINE - STA. 57+00 TO STA. 114+00
C-0-05 -	12" WATER LINE - STA. 114+00 TO STA. 173+00
C-0-06 -	12" WATER LINE - STA. 173+00 TO STA. 230+00
C-0-07 -	12" WATER LINE - STA. 230+00 TO STA. 295+00
C-0-08 -	12" WATER LINE - STA. 295+00 TO STA. 353+00
C-0-09 -	12" WATER LINE - STA. 353+00 TO STA. 373+45 E.O.L.
C-0-10 -	LOBELVILLE-WAVERLY PUMP STATION - PLAN, SECTION AND DETAILS
C-0-11 -	STANDARD WATER LINE DETAILS
C-0-12 -	STANDARD WATER LINE DETAILS
C-0-13 -	STANDARD EROSION CONTROL DETAILS



ENGINEERS - ARCHITECTS - PLANNERS

[www.grwinc.com](http://www.grwinc.com)

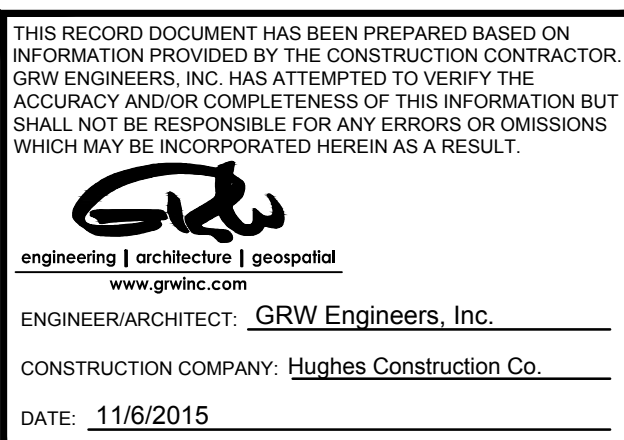

JULY 2013

GRW PROJECT NO. 3827-06