


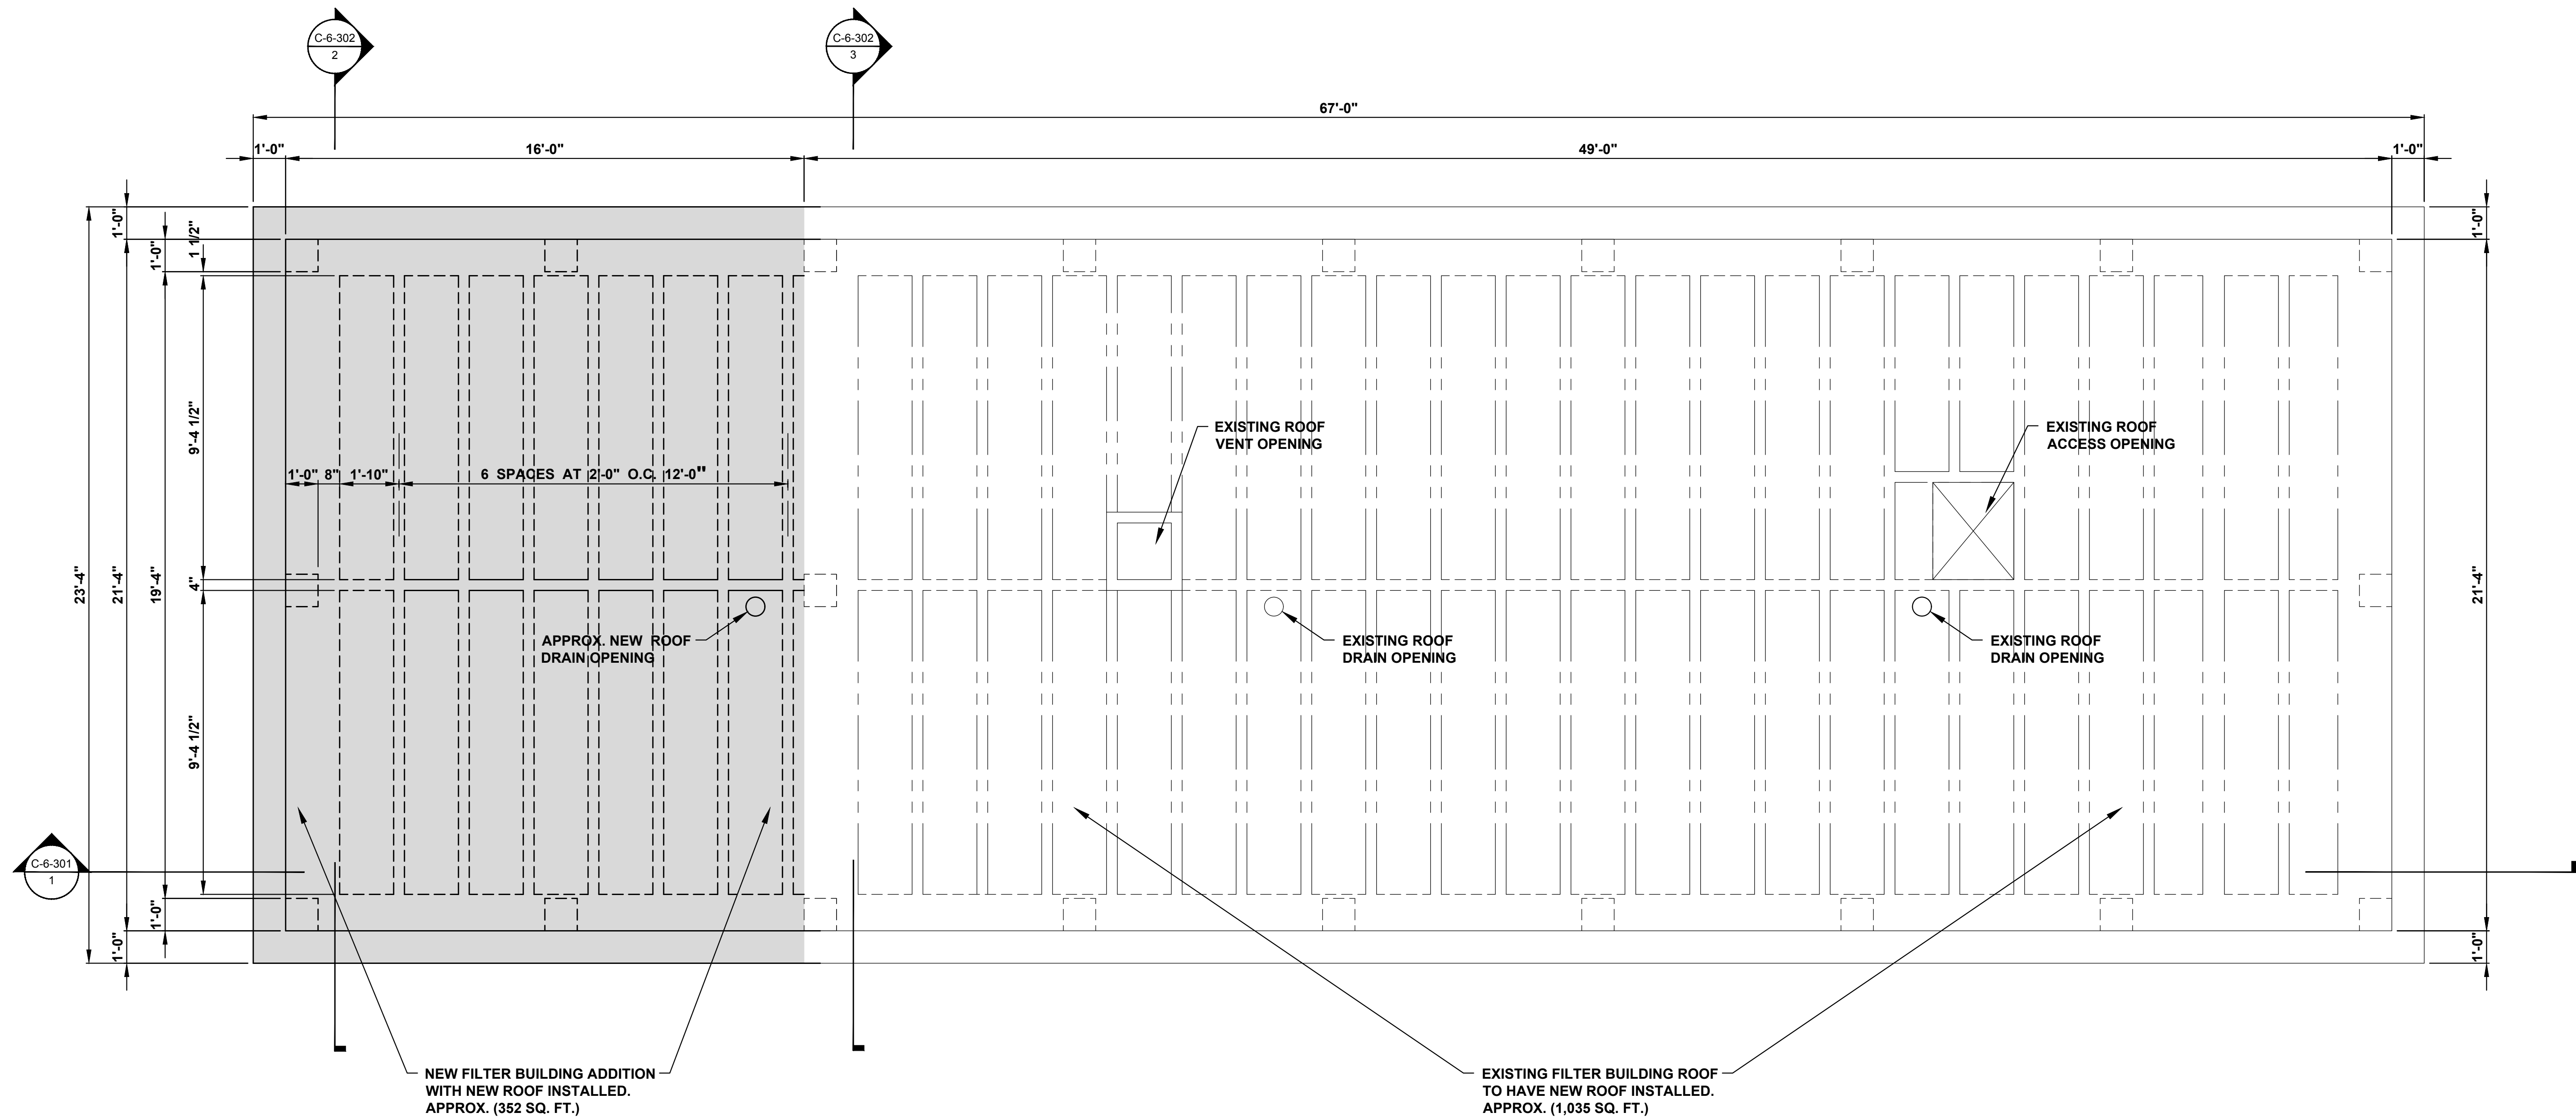

ROOF - PLAN VIEW

SCALE: 3/8"=1'-0"

SEE STRUCTURAL DRAWINGS FOR ALL CONCRETE AND STEEL REINFORCING REQUIREMENT

SEE ELECTRICAL DRAWINGS FOR ALL ELECTRICAL APPURTANCES REQUIREMENT

NOTES:

1. CONNECT NEW ROOF DRAIN TO EXISTING DRAIN SYSTEM

THIS RECORD DOCUMENT HAS BEEN PREPARED BASED ON INFORMATION PROVIDED BY THE CONSTRUCTION CONTRACTOR. GRW ENGINEERS, INC. HAS ATTEMPTED TO VERIFY THE ACCURACY AND/OR COMPLETENESS OF THIS INFORMATION BUT SHALL NOT BE RESPONSIBLE FOR ANY ERRORS OR OMISSIONS WHICH MAY BE INCORPORATED HEREIN AS A RESULT.

GRW
engineering | architecture | geospatial
www.grwinc.com

ENGINEER/ARCHITECT: BARRY L. CLOYD
CONSTRUCTION COMPANY: QUINN CONS. CORP.
09/27/2018

ROOF PLAN

WATER TREATMENT PLANT EXPANSION
CITY OF LOBEVILLE, TENNESSEE

DESIGNED	BLC
DRAWN	SH
REVIEWED	JWH
APPROVED	BLC

NO.	DATE	DESCRIPTION

DATE: JUNE 2015
SCALE: NOTED
SHEET NO. C-6-106

GRW PROJECT NO. 3827-07
CLIENT PROJECT NO.
ALL RIGHTS RESERVED. NO PART OF THIS DOCUMENT SHALL BE REPRODUCED IN WHOLE OR IN PART WITHOUT THE WRITTEN PERMISSION OF GRW ENGINEERS, INC. AND SHALL NOT BE USED FOR ANY OTHER PROJECT OTHER THAN THIS SPECIFIC PROJECT WITHOUT THE WRITTEN PERMISSION.

GRW
engineering | architecture | geospatial
www.grwinc.com