


LOST CREEK ROAD AND RUSSELL CREEK ROAD WATER LINES

CDBG CONTRACT: 2011-D PERRY CO. DISASTER WATER LINES

CITY OF LOBELVILLE, TENNESSEE

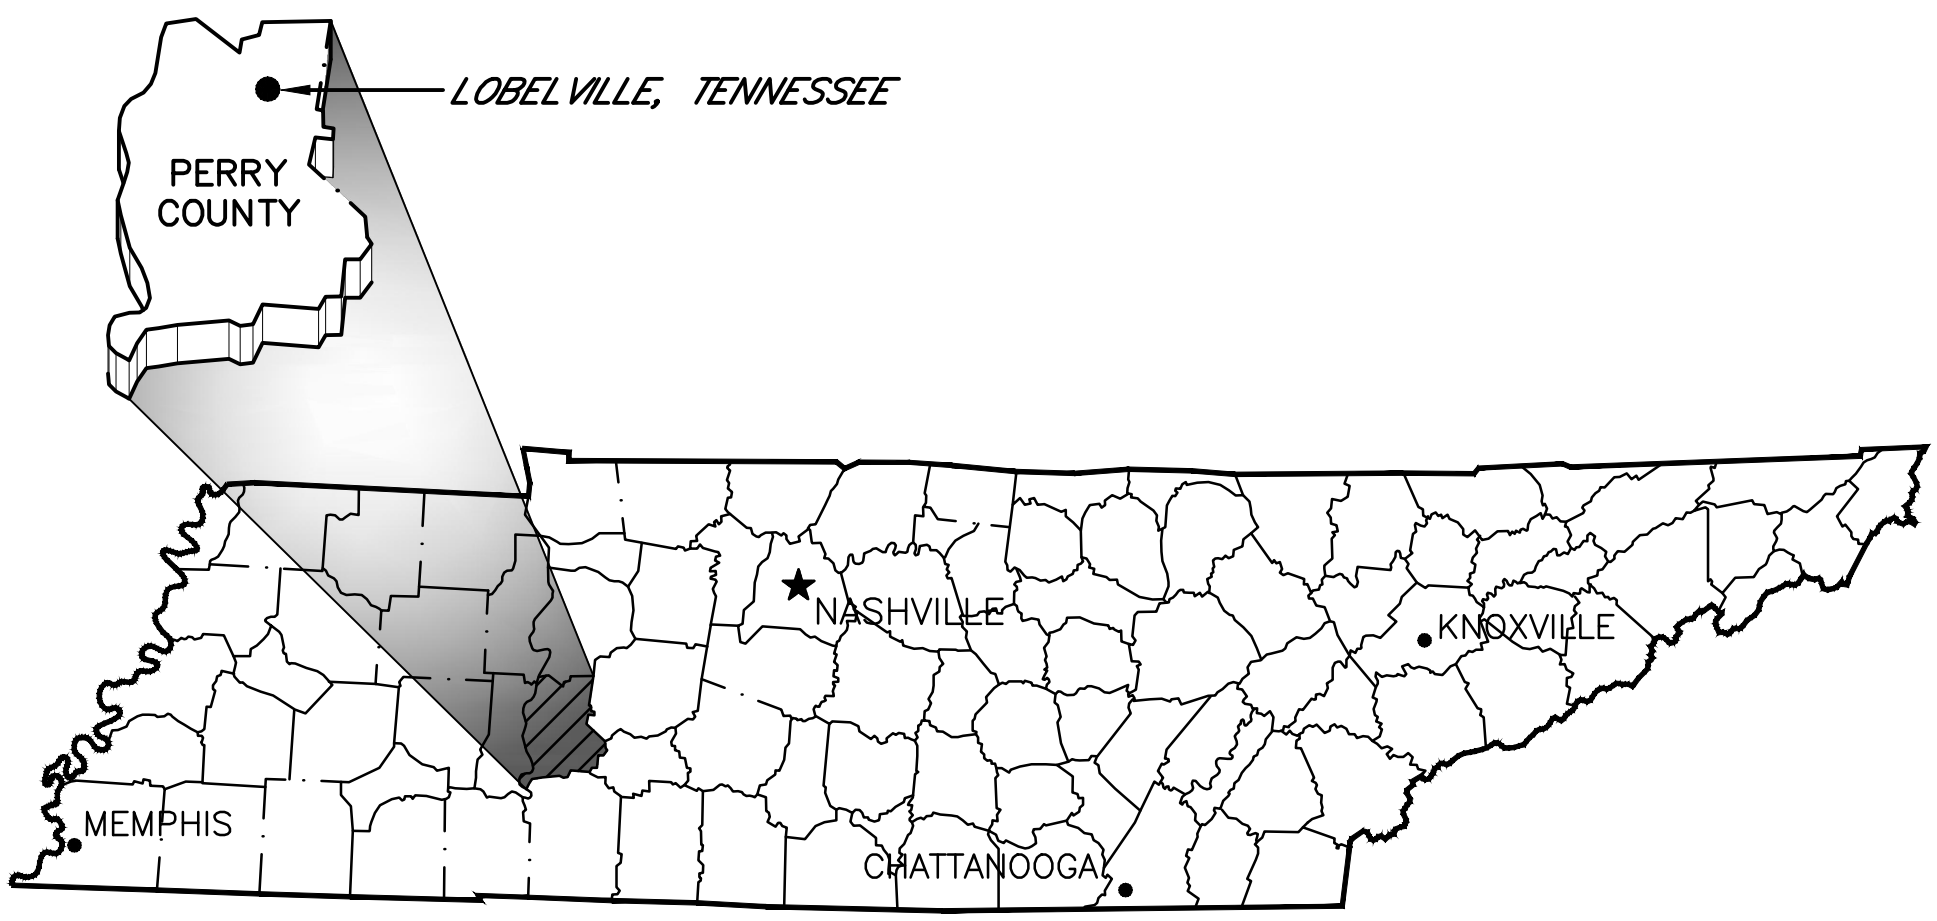

TENNESSEE VICINITY MAP
NOT TO SCALE



engineering | architecture | geospatial

www.grwinc.com

DWG. NO.	INDEX OF DRAWINGS
C-01	GENERAL NOTES, LEGEND AND EROSION SEDIMENT CONTROL NOTES
C-02	LINE "A" - STA. 14+40 TO STA. 57+00
C-03	LINE "A" - STA. 57+00 TO STA. 120+00
C-04	LINE "A" - STA. 120+00 TO STA. 185+00 (NOT IN CONTRACT)
C-05	LINE "A" - STA. 185+00 TO STA. 219+30 E.O.L. (NOT IN CONTRACT)
C-06	LINE "A" - STA. 0+00 TO STA. 14+40 LINE "B" - STA. 0+00 TO STA. 62+00
C-07	LINE "B" - STA. 62+00 TO STA. 117+00
C-08	LINE "B" - STA. 117+00 TO STA. 127+80 E.O.L. LINE "C" - STA. 0+00 TO STA. 13+05 E.O.L.
C-09	PUMP STATION - PLAN, SECTIONS AND DETAILS
SD-10	STANDARD WATER LINE DETAILS
SD-11	STANDARD WATER LINE DETAILS
EC-12	STANDARD EROSION CONTROL DETAILS

THIS RECORD DOCUMENT HAS BEEN PREPARED BASED ON INFORMATION PROVIDED BY THE CONSTRUCTION CONTRACTOR. GRW ENGINEERS, INC. HAS ATTEMPTED TO VERIFY THE ACCURACY AND/OR COMPLETENESS OF THIS INFORMATION BUT SHALL NOT BE RESPONSIBLE FOR ANY ERRORS OR OMISSIONS WHICH MAY BE INCORPORATED HEREIN AS A RESULT.



engineering | architecture | geospatial
www.grwinc.com

ENGINEER/ARCHITECT: GRW Engineers, Inc.
HUGHES EXCAVATING, LLC

03/13/2017

OCTOBER 2015

GRW PROJECT NO. 4420-01

FILE NAME: G:\420-1 Lobelville\01-Russell\LostWorking Drawings\AutoCAD - Record Drawing\4420-01-C-00.dwg PRINTED: 5/11/2017 @ 1:01 PM