



**SECOND FLOOR PLAN
LABORATORY AND FILTERS No. 1 & 2**
SCALE: 3/8" = 1'-0"

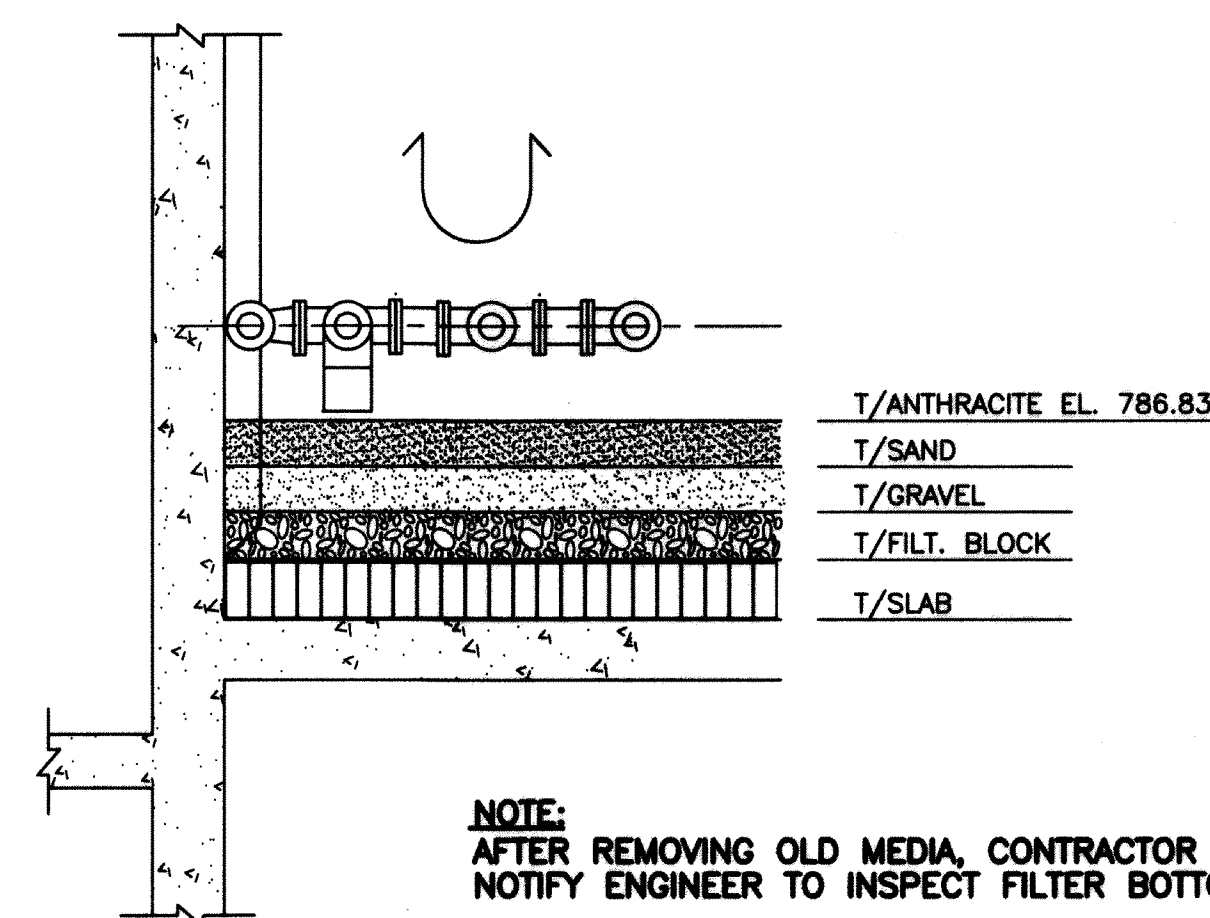

FILTER MEDIA DETAIL
N.T.S.

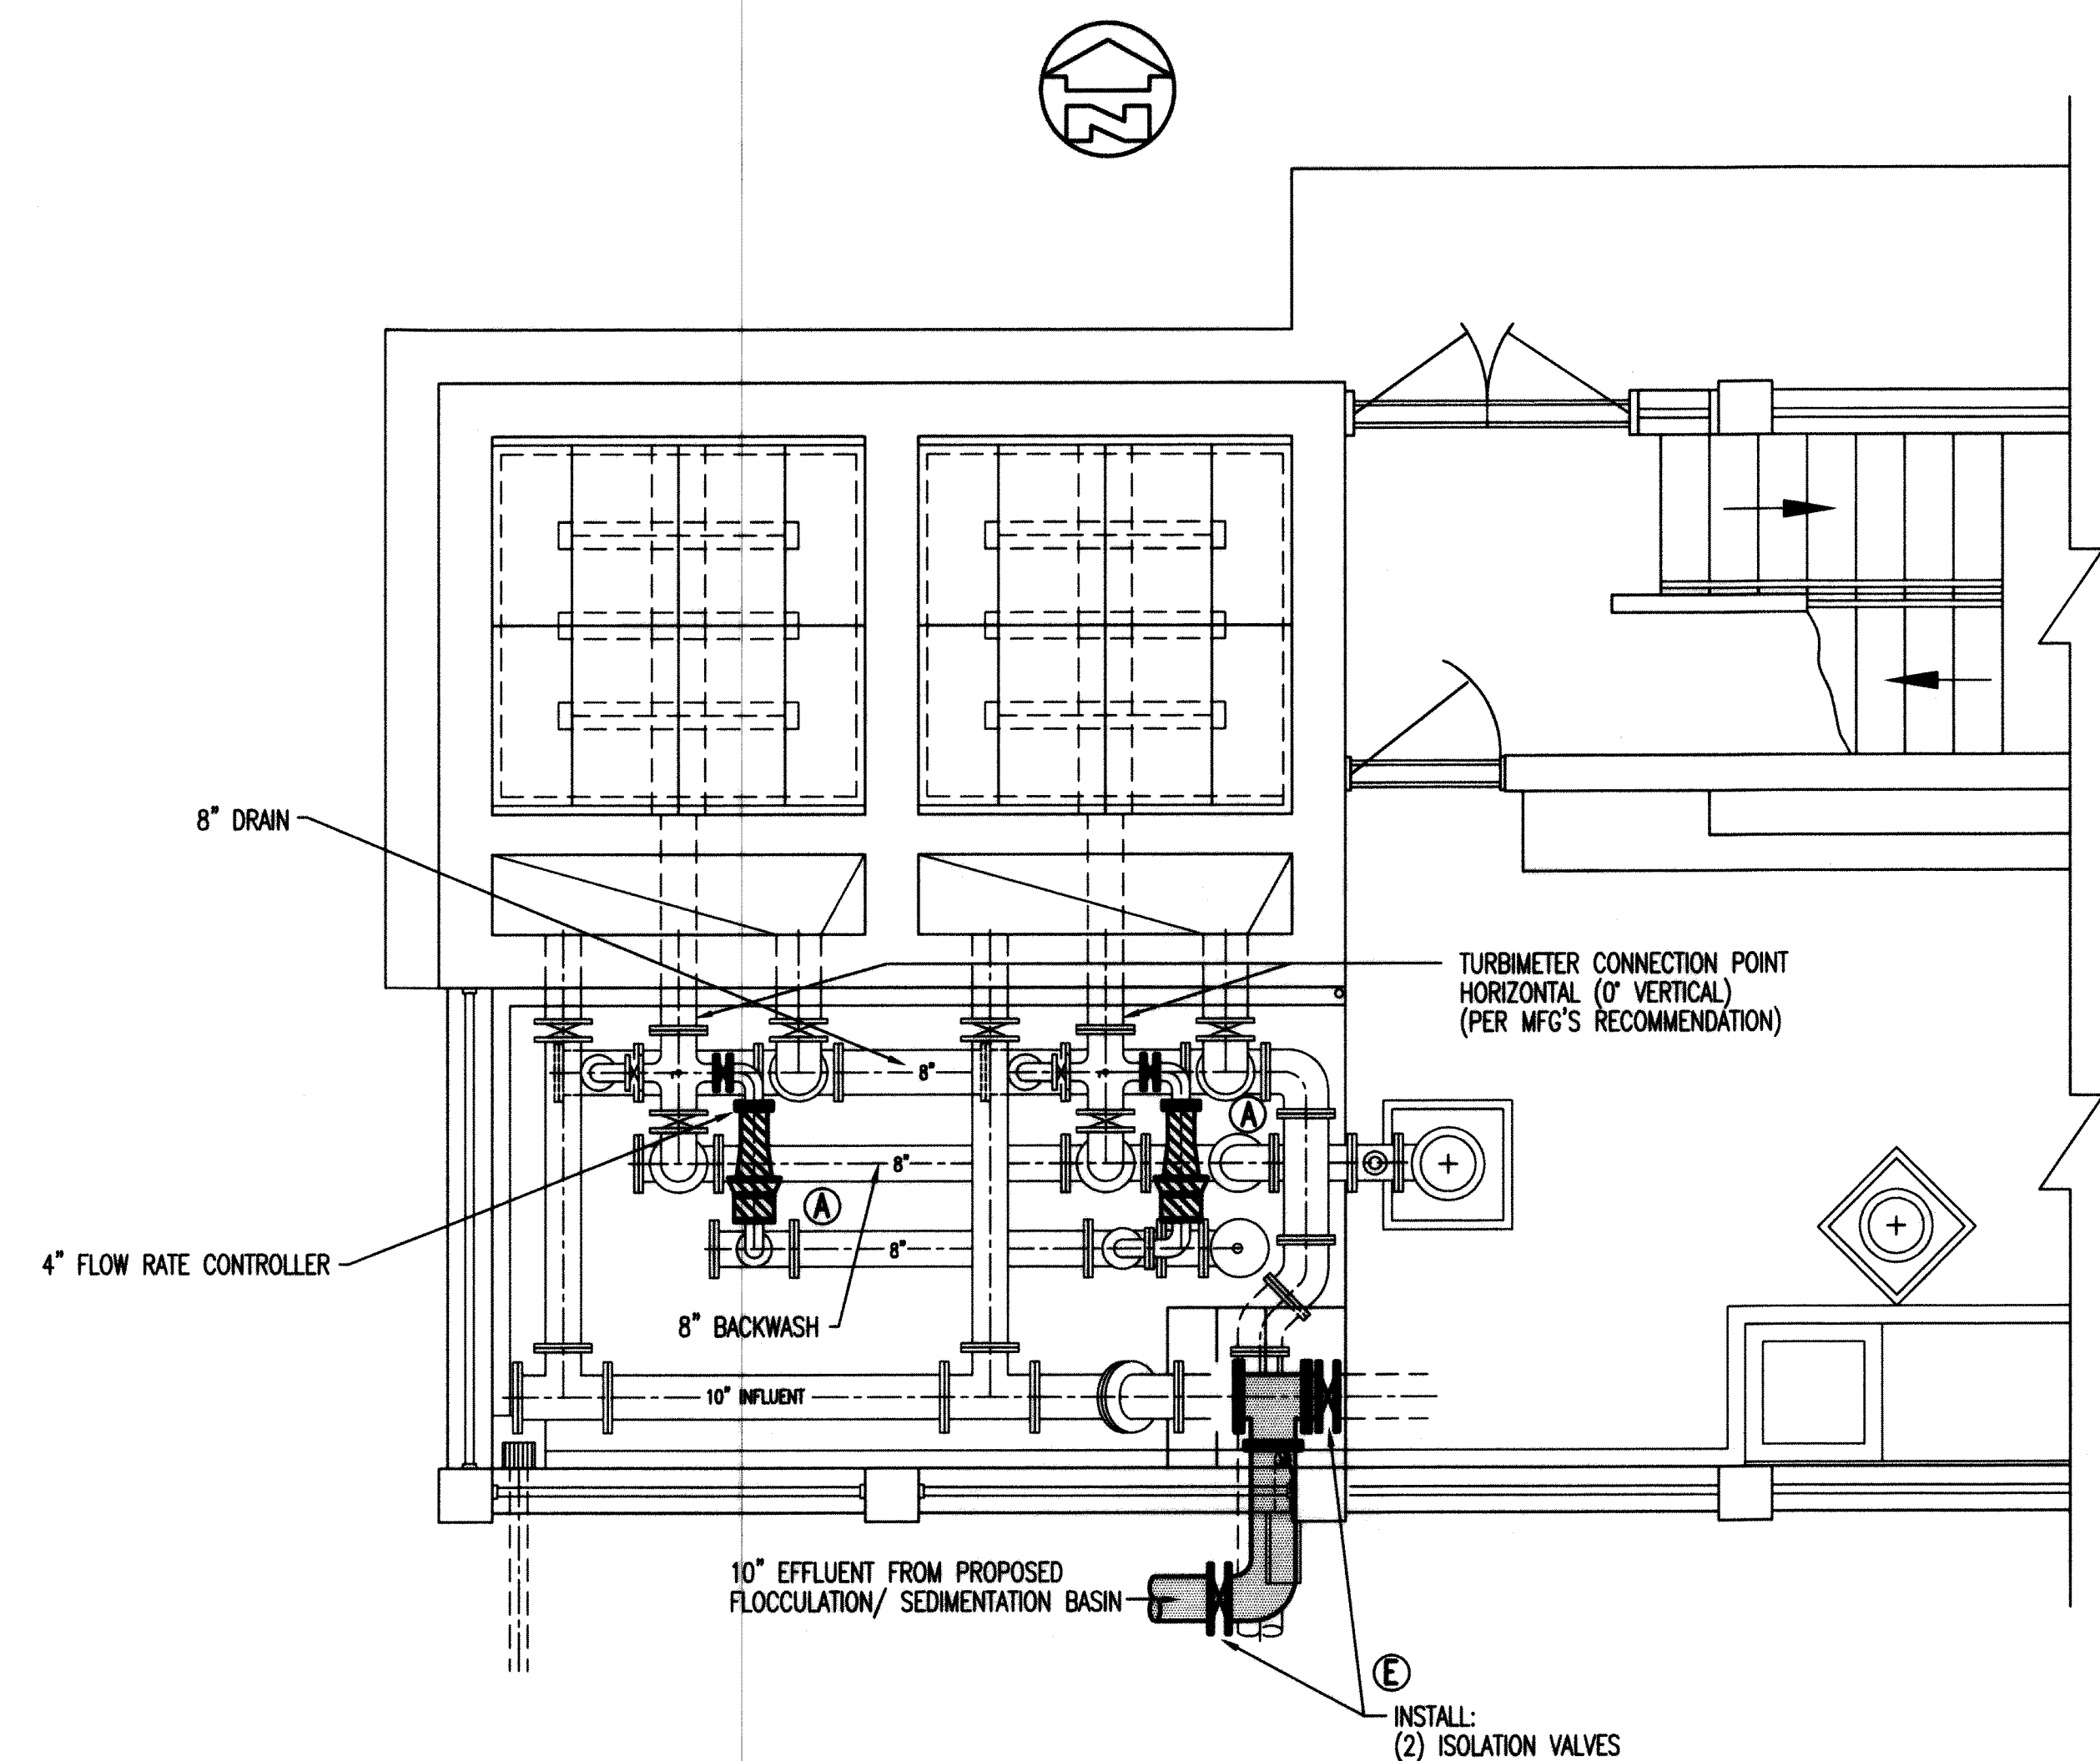


FIRST FLOOR PIPING PLAN
SCALE: 3/8" = 1'-0"

NOTES

- Ⓐ REPLACE EXISTING RATE FLOW CONTROLLER AND BUTTERFLY VALVE WITH NEW RATE OF FLOW CONTROLLER AND 4" BUTTERFLY VALVE
- Ⓑ REPLACE INTERNAL COMPONENTS OF LOSS OF HEAD AND RATE OF FLOW CONTROLLERS WITH NEW LED COMPONENTS
- Ⓒ REMOVE HANDLE AND EXTENSION. THIS SECTION OF FLOOR TO BE REPAIRED.
- Ⓓ REANCHOR SURFACE WASH
- Ⓔ INSTALL 10" TEE, 2 B'FLY VALVES, AND CONNECT 10" FILTER INFLUENT LINES.

ALL RIGHTS RESERVED: THIS DOCUMENT IS THE PROPERTY OF GRW ENGINEERS, INC. AND SHALL NOT BE REPRODUCED IN WHOLE OR IN PART OR USED FOR CONSTRUCTION OF OTHER THAN THIS SPECIFIC PROJECT WITHOUT WRITTEN PERMISSION OF GRW ENGINEERS, INC.			
NO.	DESCRIPTION	DATE	BY
REVISIONS			

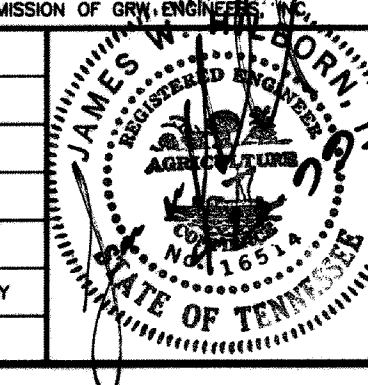

GRW PROJECT NO. 7385

**WATER TREATMENT PLANT EXPANSION
LOBELVILLE, TENNESSEE
REHABILITATION & UPGRADE
FILTERS AND PIPE GALLERY**

GRW

GRW Engineers, Inc.
Engineers, Architects, Planners
LEXINGTON LOUISVILLE NASHVILLE INDIANAPOLIS

DESIGNED: KRS	DATE: APRIL, 1999
DRAWN: GAM	SCALE: 3/8" = 1'-0"
REVIEWED: GAM, KRS	SHEET NO.
APPROVED: JWH	C-7