


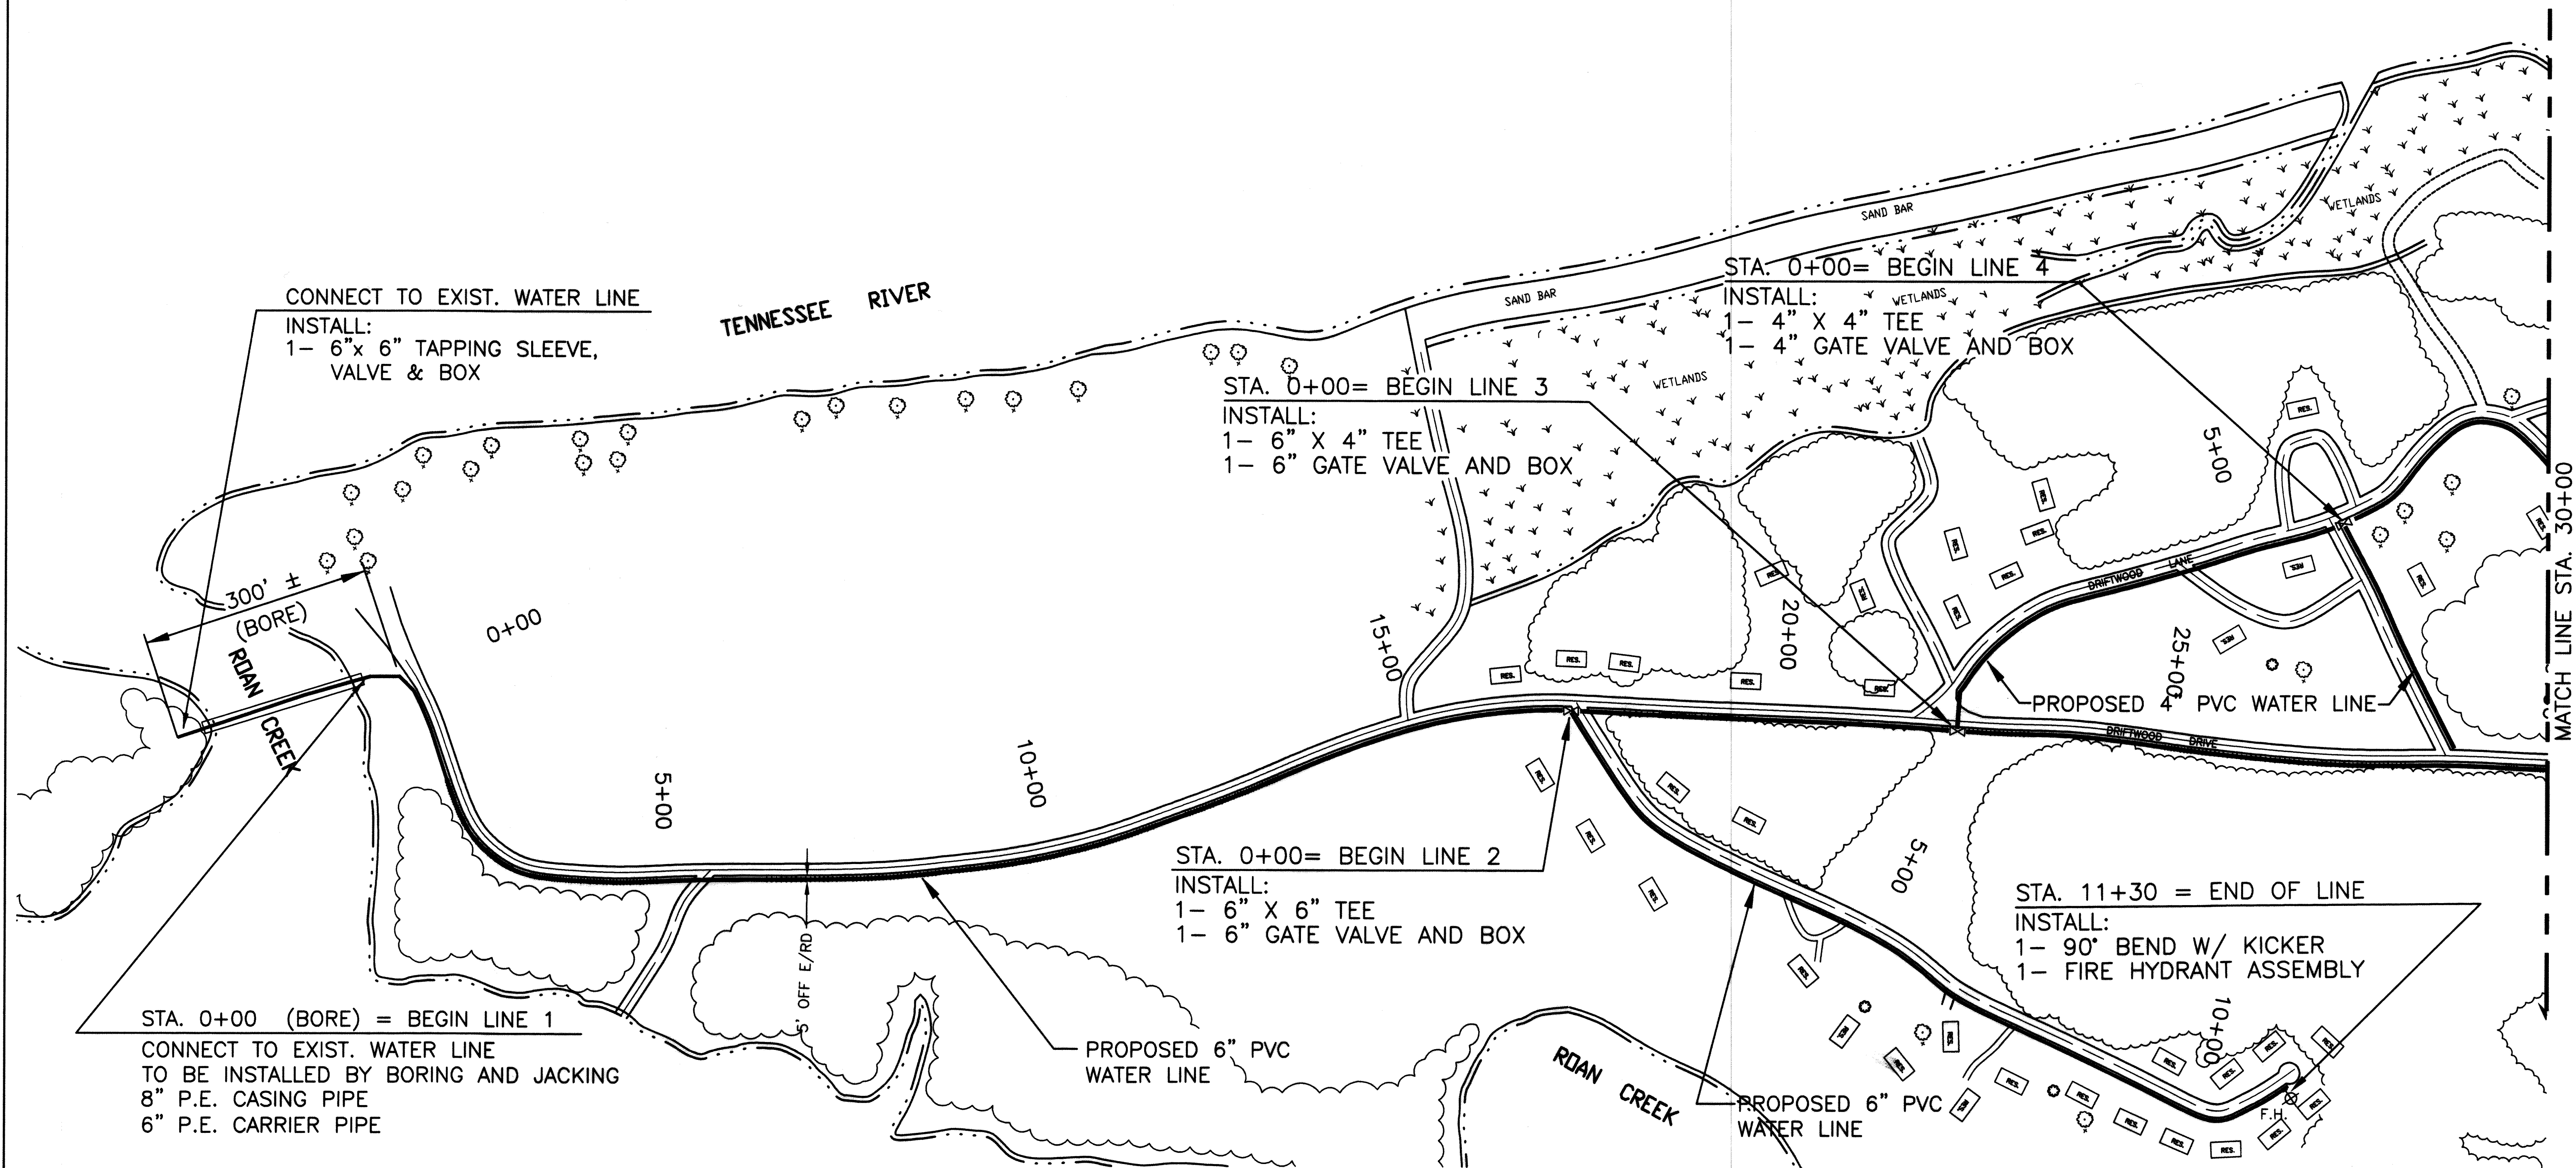

STA. 0+00 (BORE) = BEGIN LINE 1
CONNECT TO EXIST. WATER LINE
TO BE INSTALLED BY BORING AND JACKING
8" P.E. CASING PIPE
6" P.E. CARRIER PIPE

STA. 0+00= BEGIN LINE 2
INSTALL:
1- 6" X 6" TEE
1- 6" GATE VALVE AND BOX

STA. 0+00= BEGIN LINE 3
INSTALL:
1- 6" X 4" TEE
1- 6" GATE VALVE AND BOX


STA. 0+00= BEGIN LINE 4
INSTALL:
1- 4" X 4" TEE
1- 4" GATE VALVE AND BOX

STA. 11+30 = END OF LINE
INSTALL:
1- 90° BEND W/ KICKER
1- FIRE HYDRANT ASSEMBLY

BURIED TELEPHONE CABLES AND UTILITIES
CALL: TENNESSEE ONE CALL (1-800-351-1111)

REVISIONS			
NO.	DESCRIPTION	DATE	BY

100 0 100

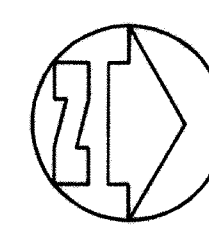

GRW PROJECT NO. 7408

PERRY COUNTY
LOBELVILLE, TENNESSEE
WATER LINE EXTENSION, DRIFTWOOD SUBDIVISION
SITE PLAN

GRW
GRW Engineers, Inc.
Engineers, Architects, Planners
LEXINGTON LOUISVILLE NASHVILLE INDIANAPOLIS

DESIGNED: JWH	DATE: MAY, 2001
DRAWN: DLT	SCALE: 1" = 100'
REVIEWED: EEM	SHEET NO. C-2
APPROVED: JWH	