


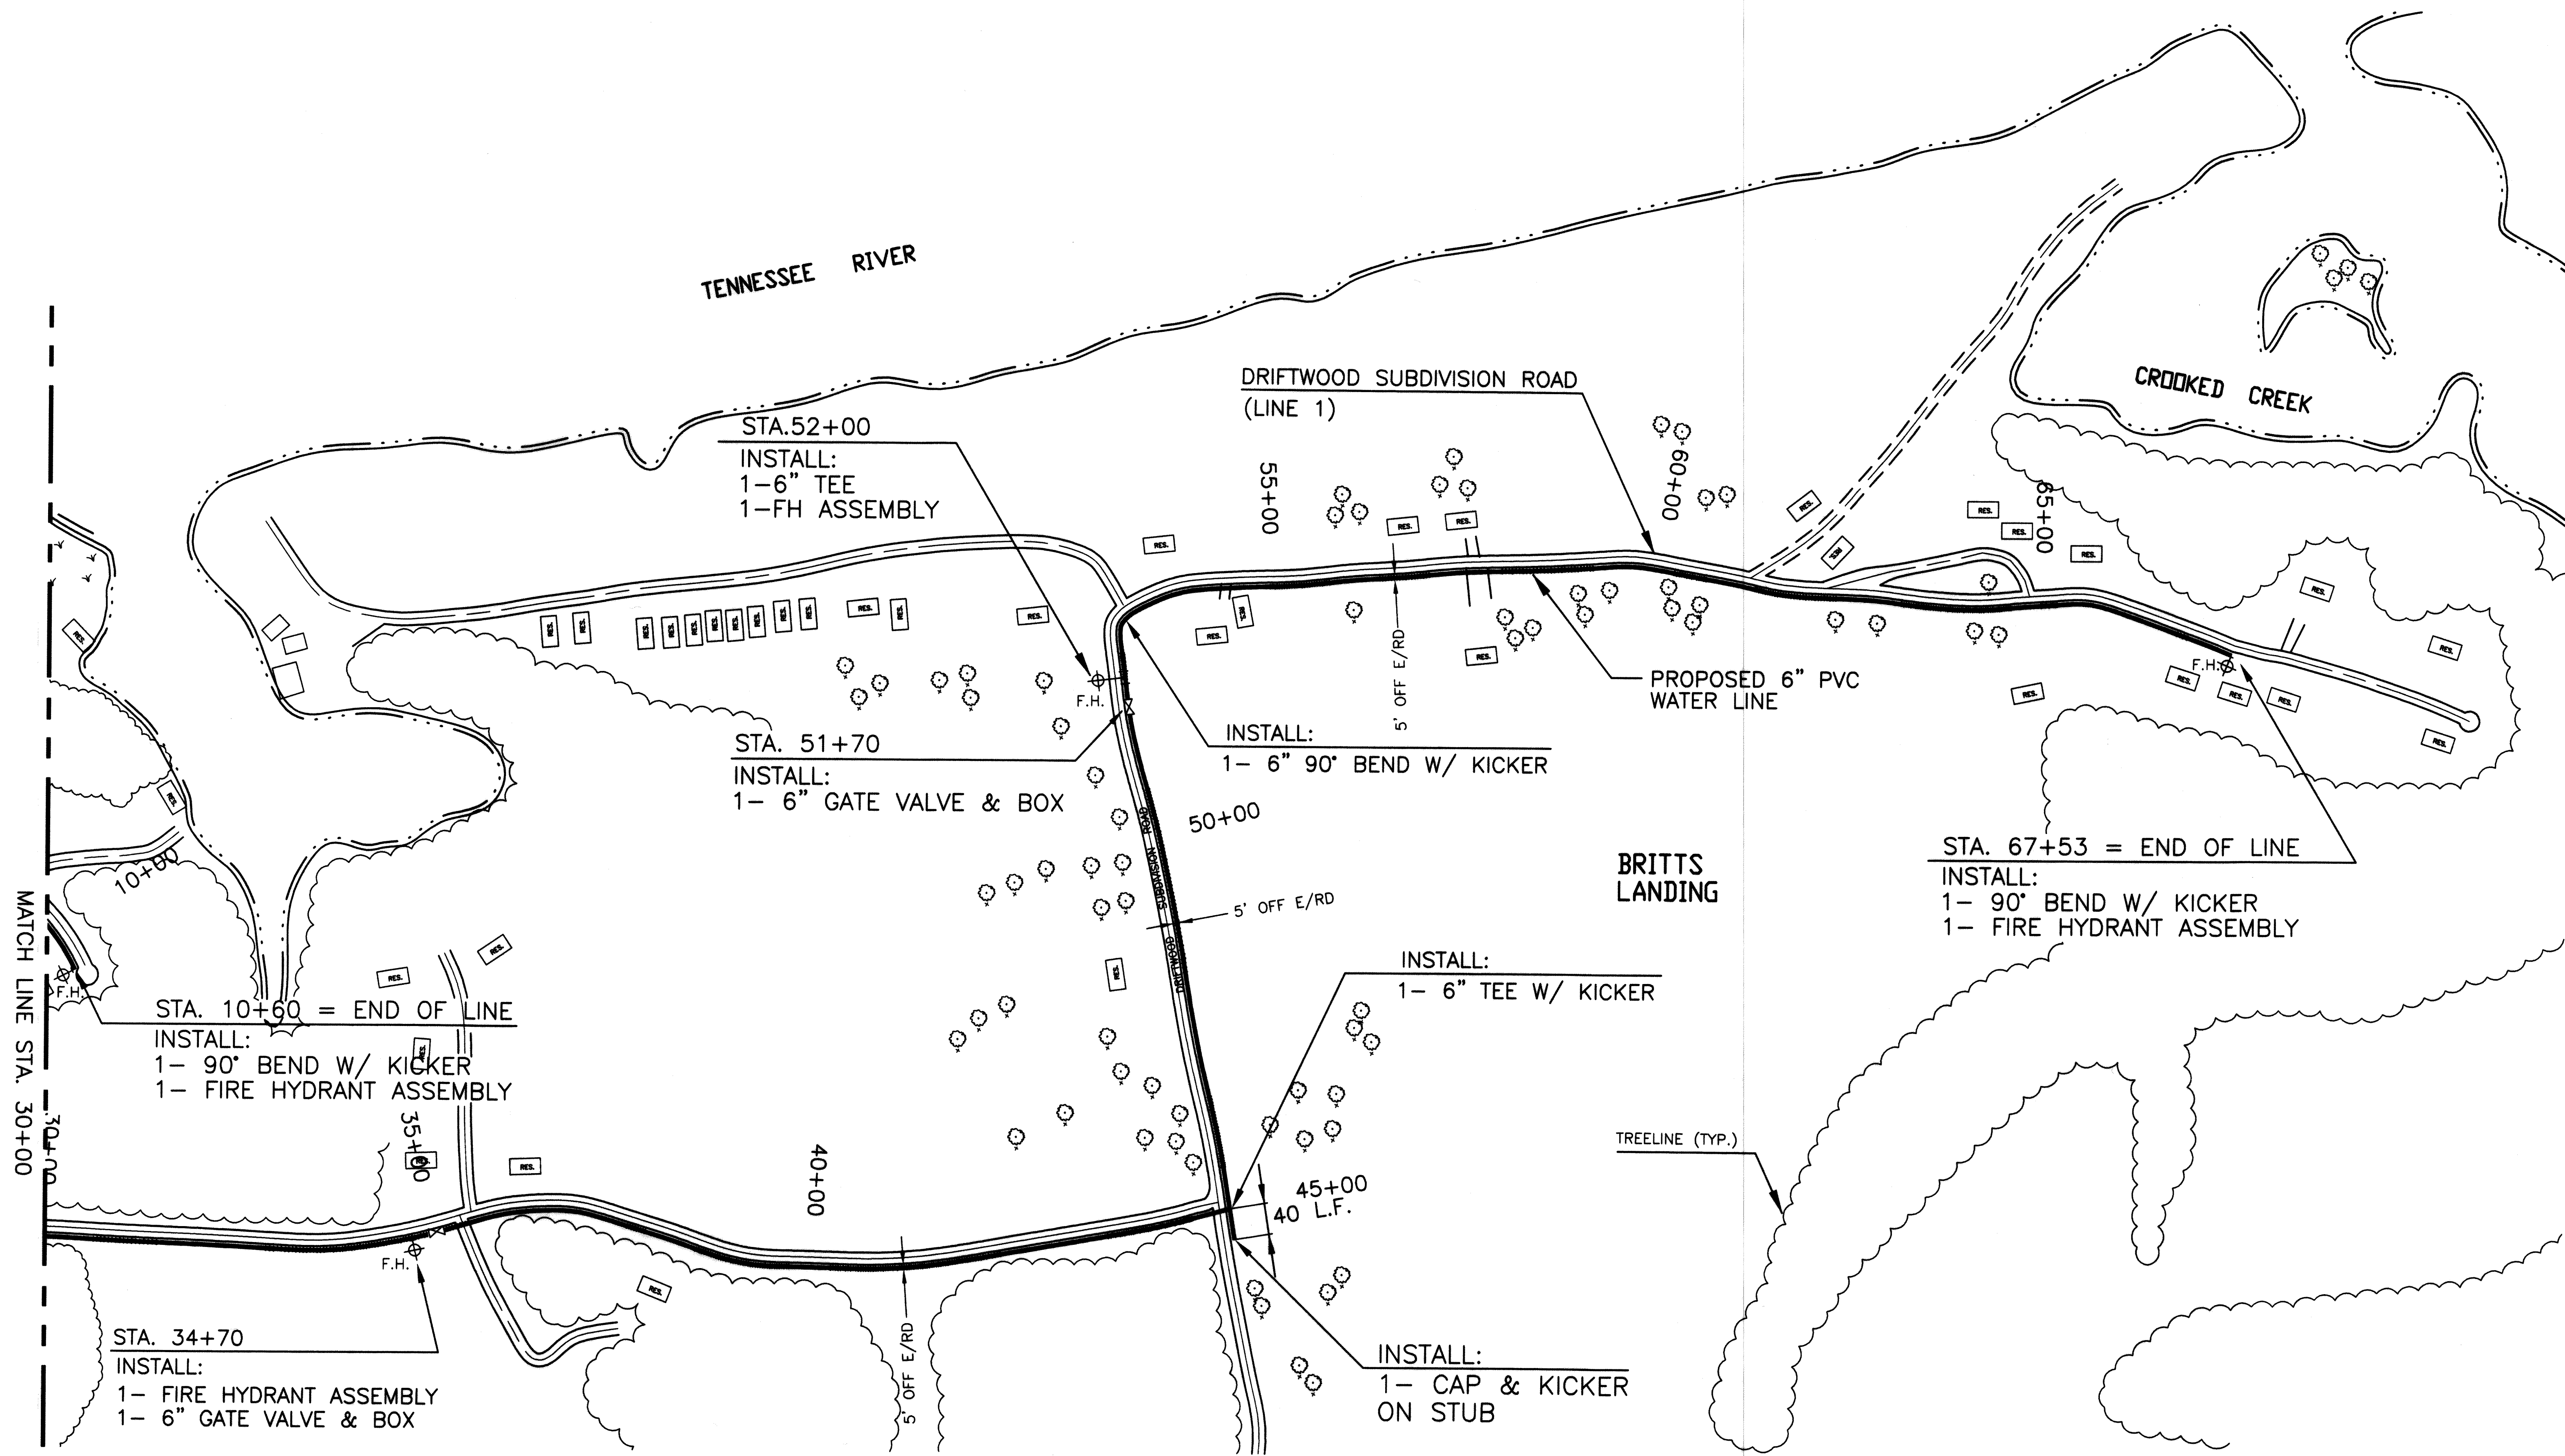

BURIED TELEPHONE CABLES AND UTILITIES
CALL: TENNESSEE ONE CALL (1-800-351-1111)

THIS DOCUMENT IS THE PROPERTY OF GRW ENGINEERS, INC. AND SHALL NOT BE REPRODUCED IN WHOLE OR IN PART OR USED FOR CONSTRUCTION OF OTHER THAN THIS SPECIFIC PROJECT WITHOUT WRITTEN PERMISSION OF GRW ENGINEERS, INC.

NO.	DESCRIPTION	DATE	BY

GRW PROJECT NO. 7408

PERRY COUNTY
LOBELVILLE, TENNESSEE
WATER LINE EXTENSION, DRIFTWOOD SUBDIVISION
SITE PLAN

DESIGNED: JWH
DRAWN: DLT
REVIEWED: EEM
APPROVED: JWH

DATE: MAY, 2001
SCALE: 1" = 100'
SHEET NO. C-3

GRW Engineers, Inc.
Engineers, Architects, Planners
LEXINGTON LOUISVILLE NASHVILLE INDIANAPOLIS