



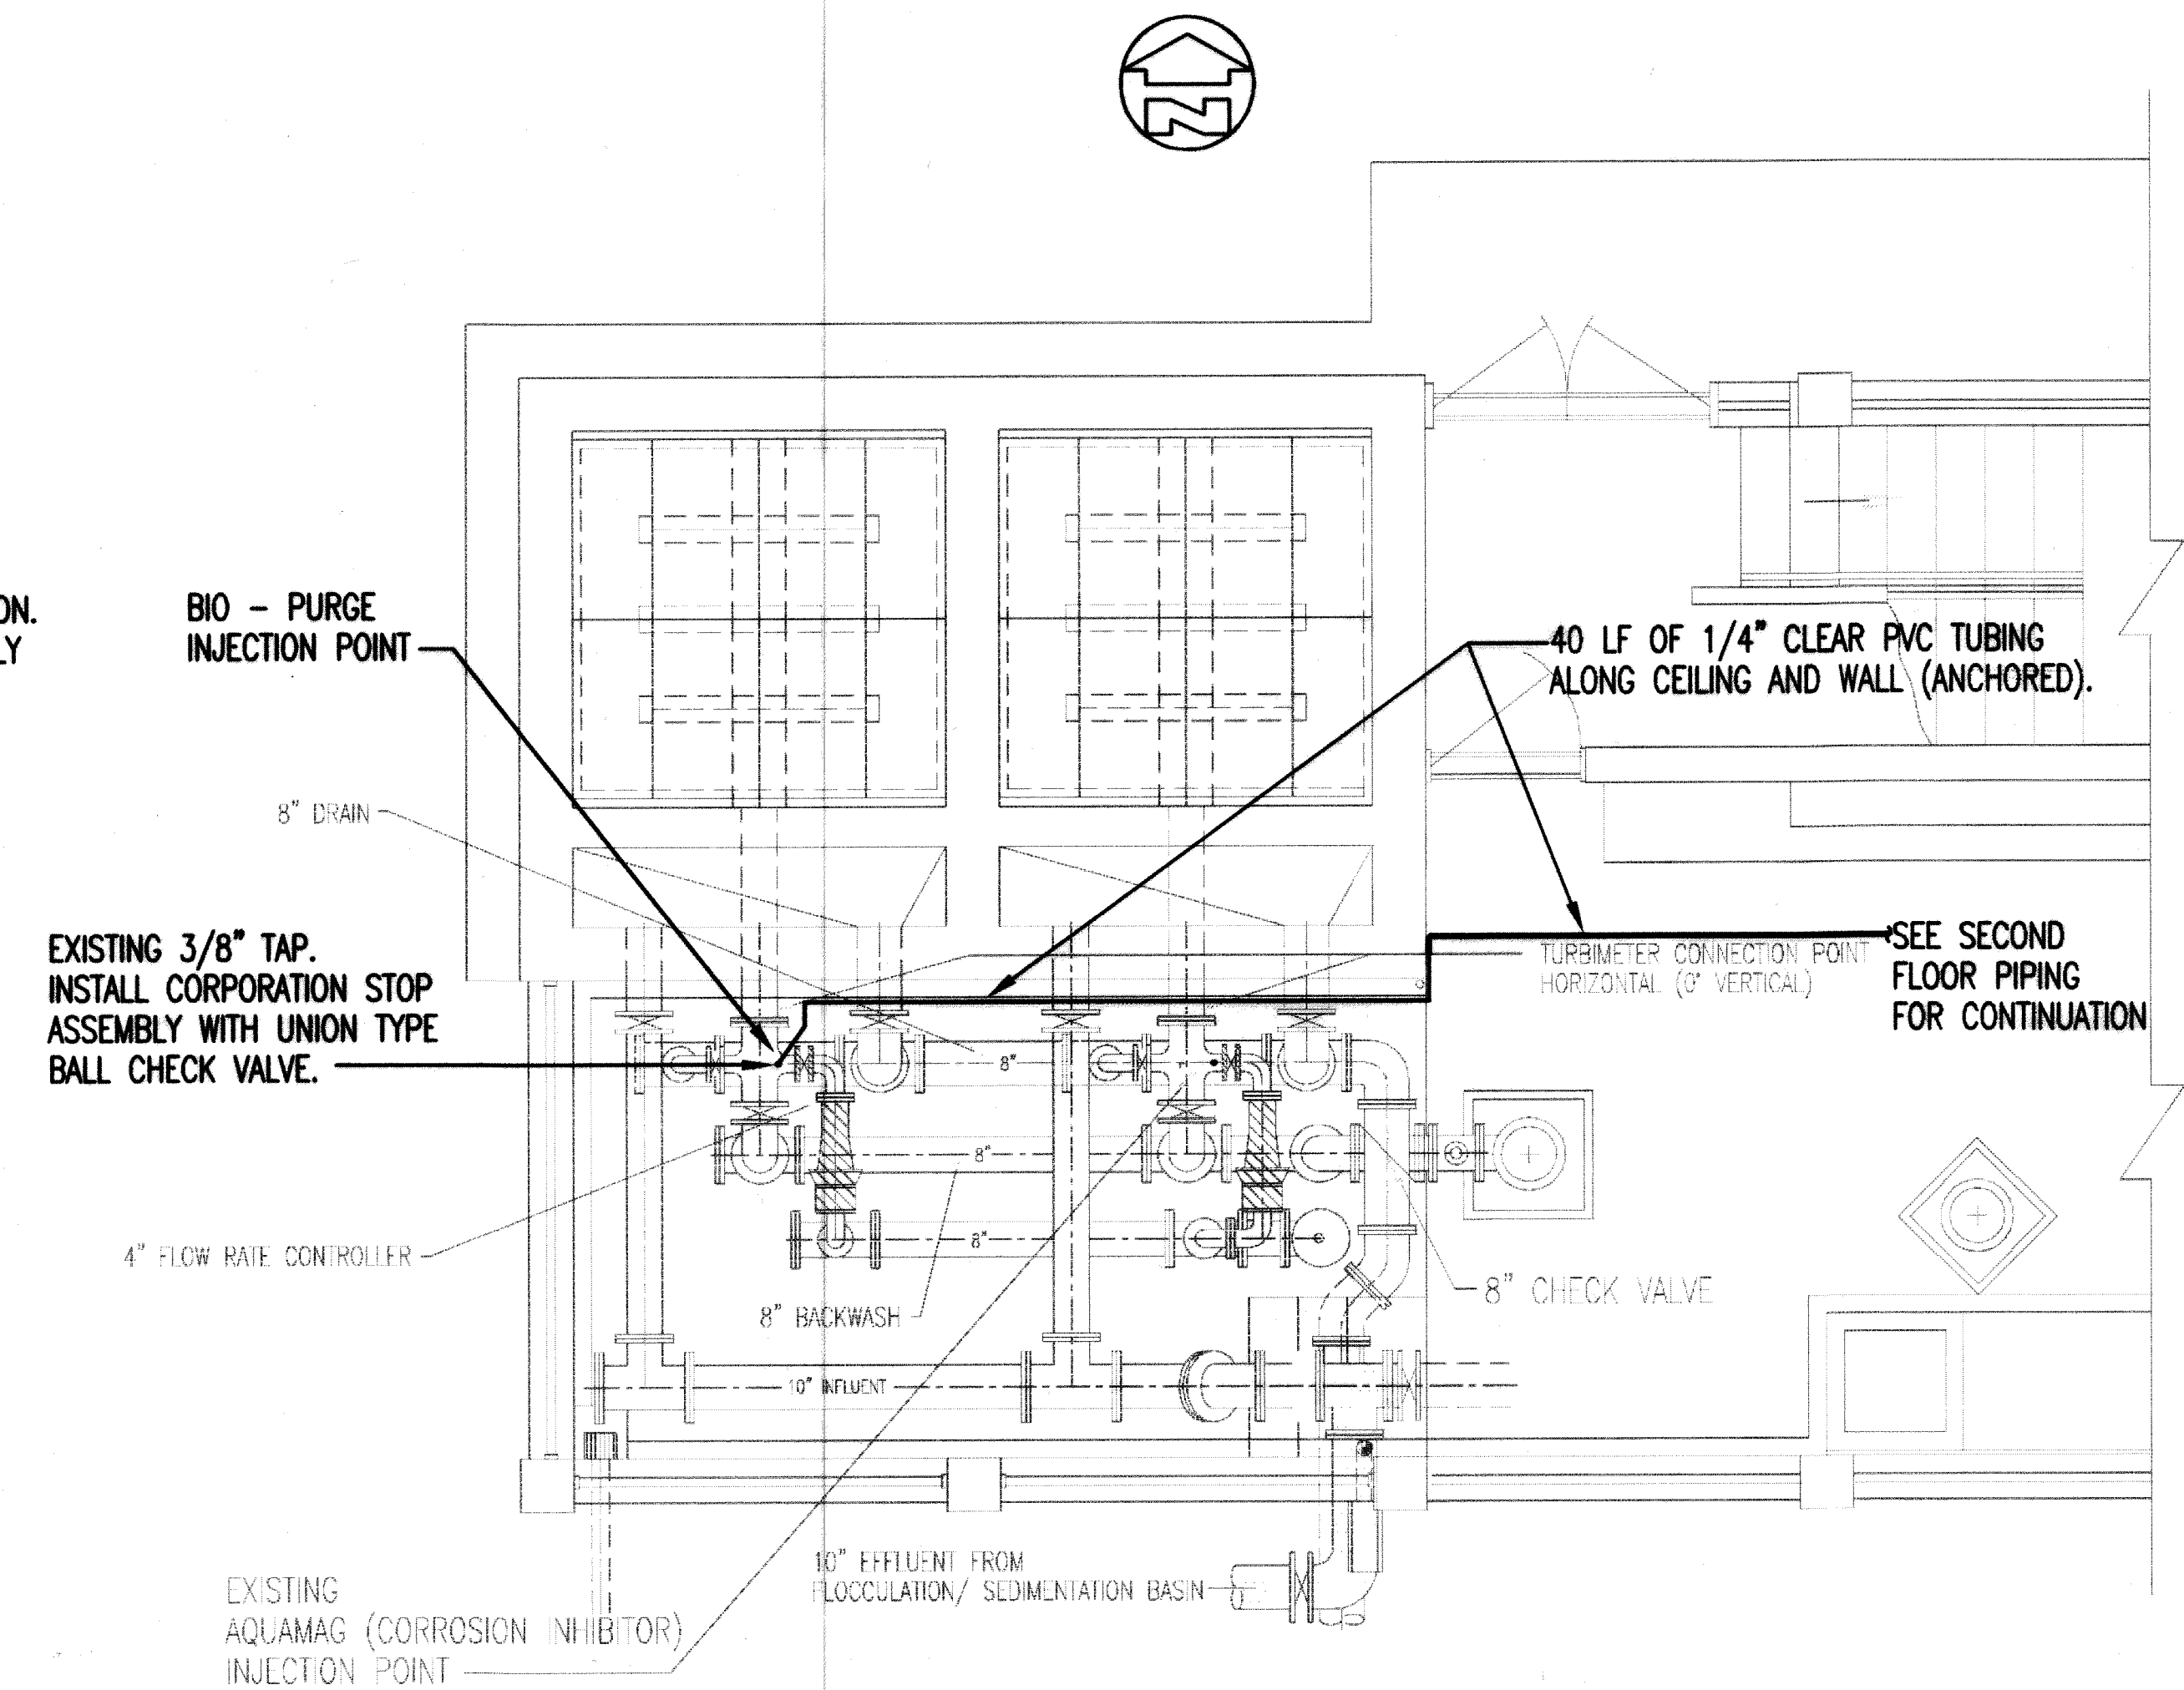

FIRST FLOOR PIPING PLAN
SCALE: 3/8" = 1'-0"

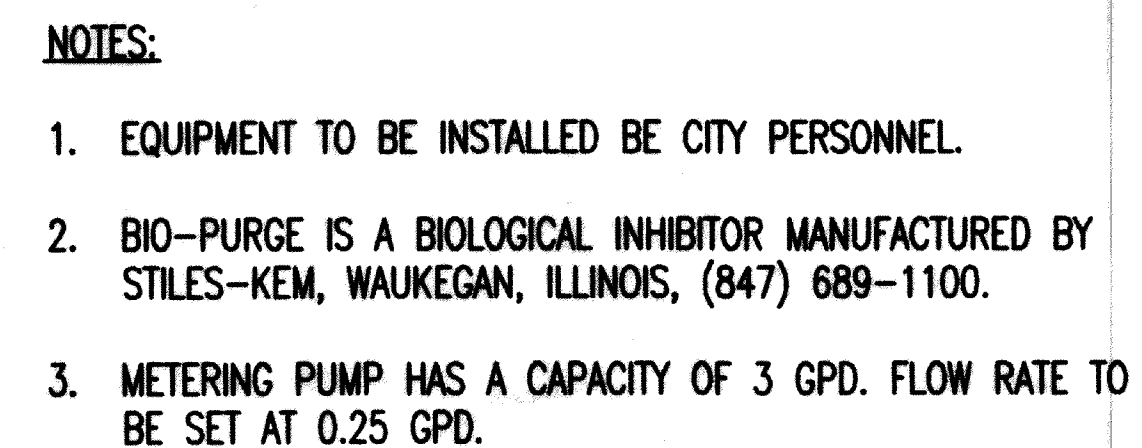

THIS DOCUMENT IS THE PROPERTY OF GRW ELROD DUNSON, INC. AND SHALL NOT BE REPRODUCED IN WHOLE OR IN PART OR USED FOR CONSTRUCTION OF OTHER THAN THIS SPECIFIC PROJECT WITHOUT WRITTEN PERMISSION OF GRW ELROD DUNSON, INC.				ALL RIGHTS RESERVED.			
				DESIGNED:			
				KRS			
				DATE:			
				APRIL, 2002			
				DRAWN:			
DLT				SCALE:			
AS NOTED				SHEET NO.			
REVIEWED:				KRS			
APPROVED:				1 of 1			
JWH							