



LOCATION: WEIHE ENGINEERING PROJECTS\2025\W250894\engineering\design\civil\W250894.C5.1 FORCE MAIN.dwg
DATE PLOTTED: May 16, 2026 - 11:22am
PLOTTED BY: mcsahj

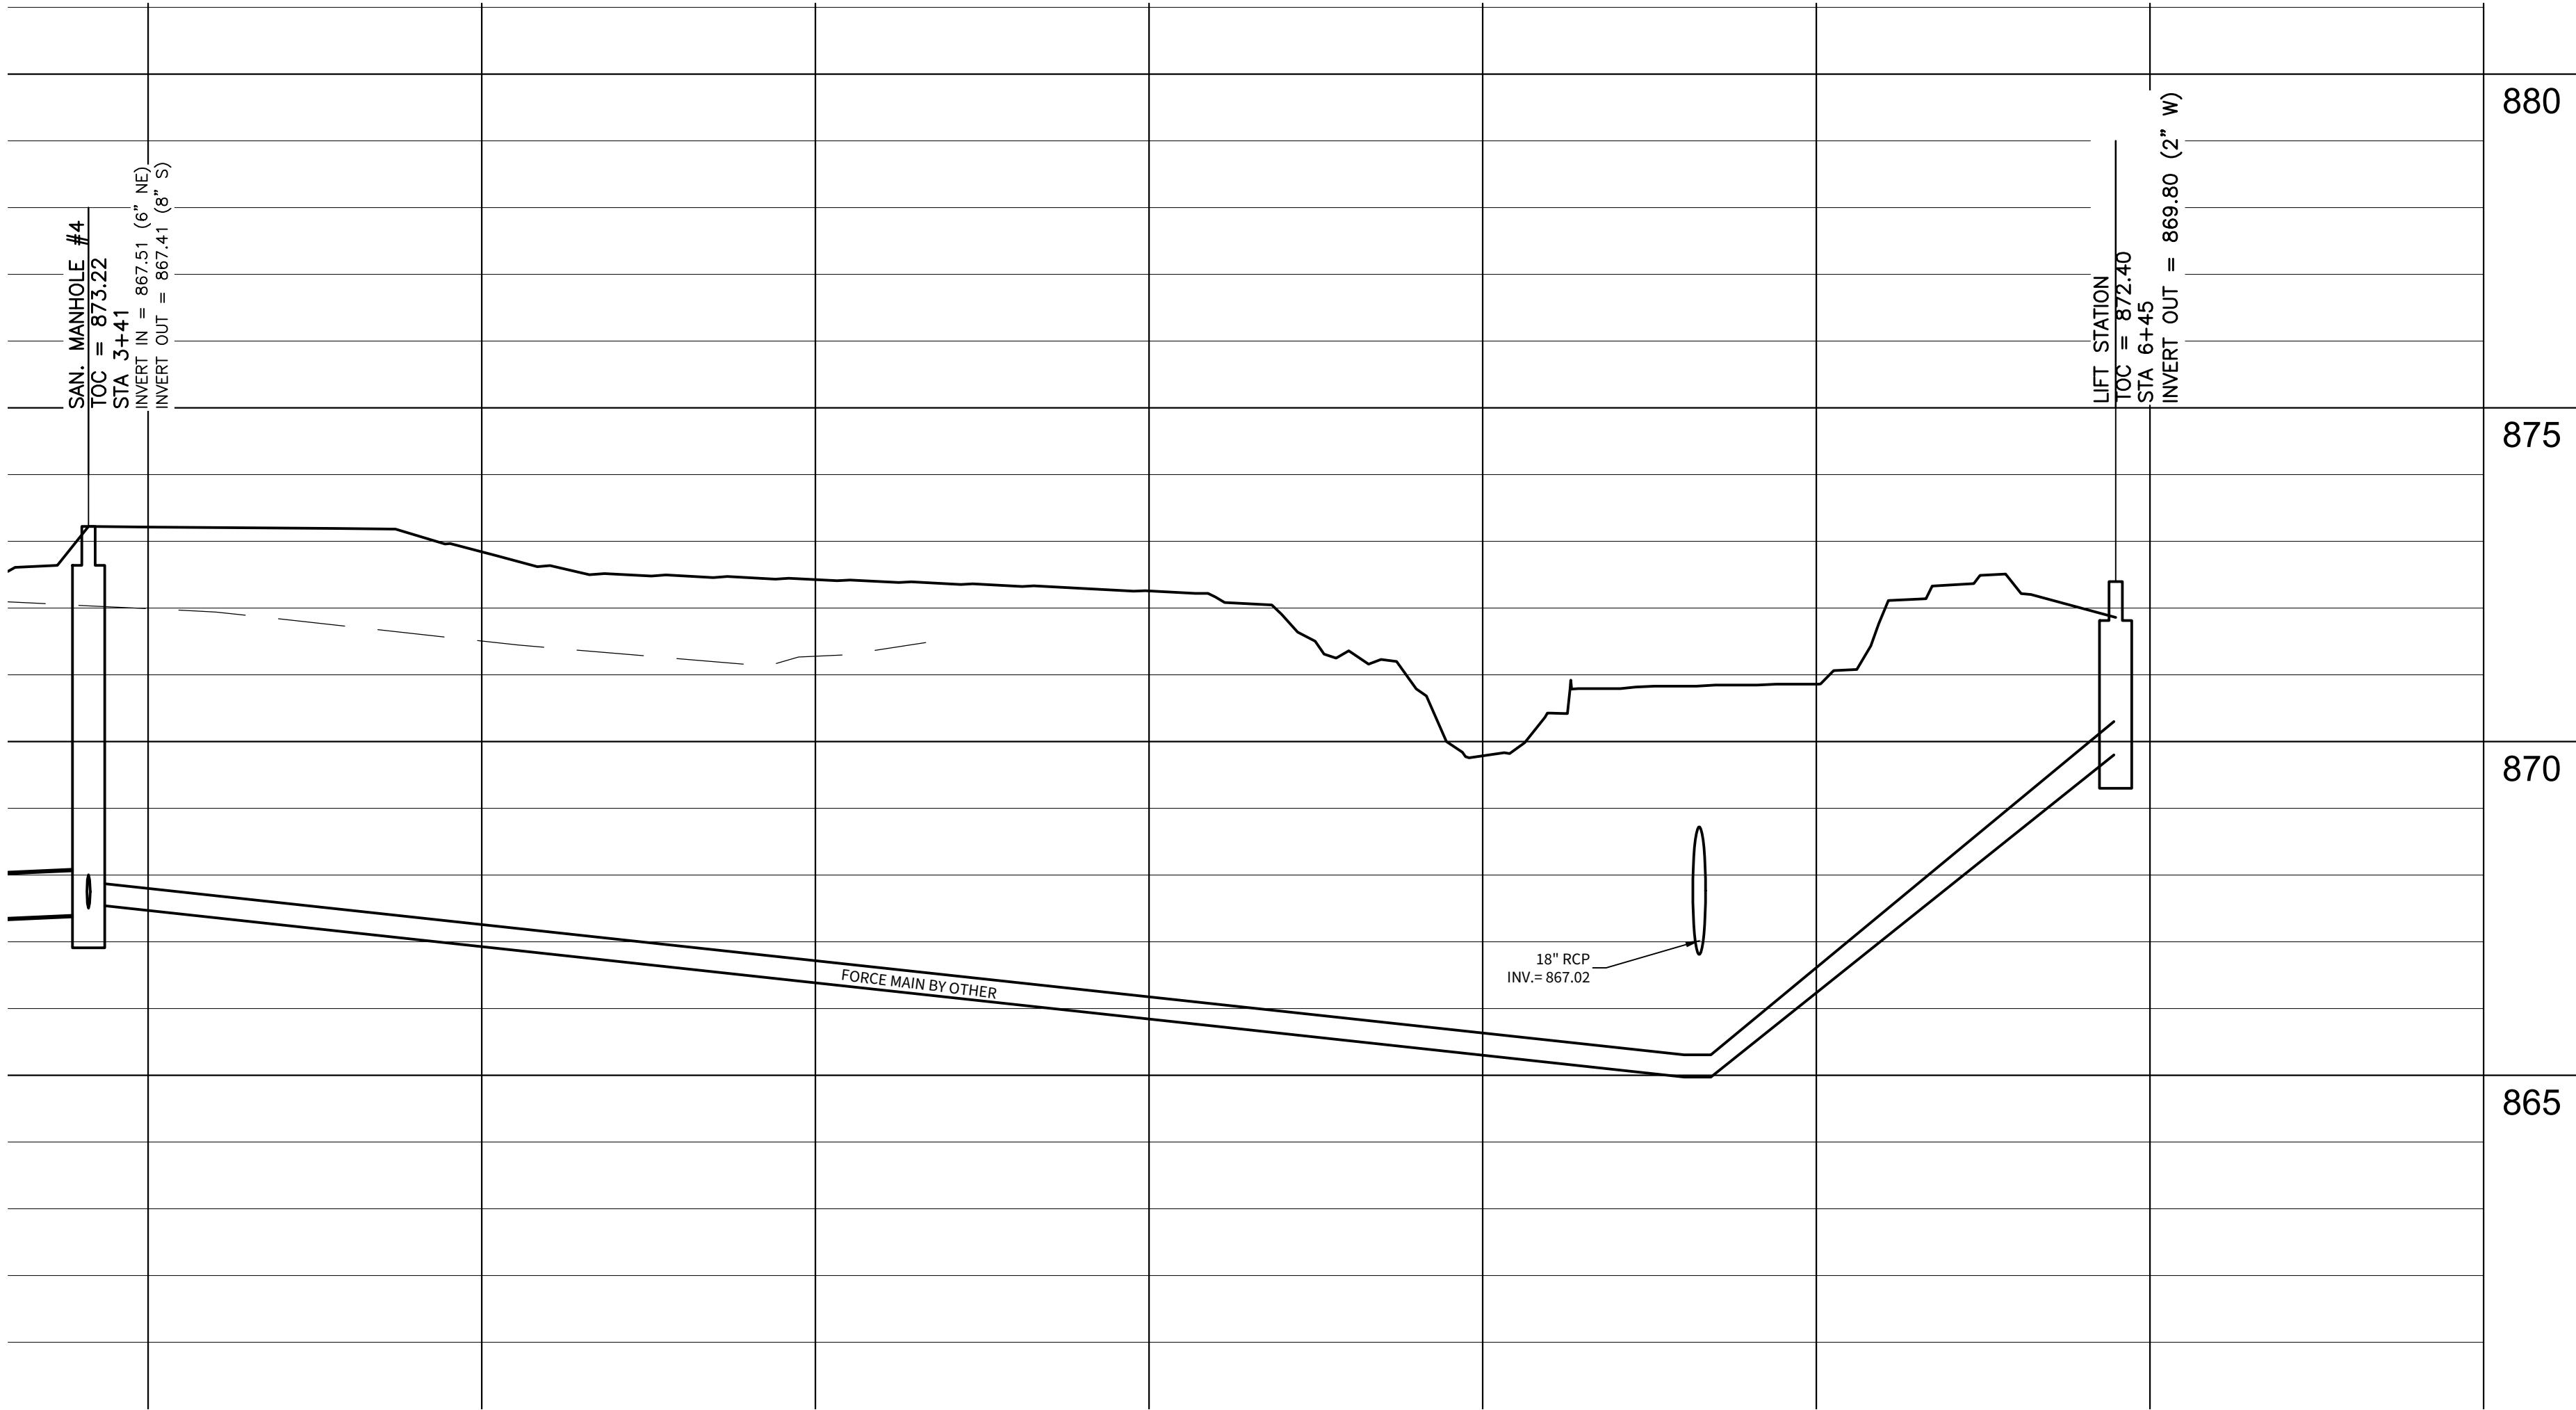

LEGEND	
	EXISTING GRADE
	FINISHED GRADE
	GRANULAR BACKFILL

HORIZONTAL SCALE: 1"=20'
VERTICAL SCALE: 1"=2'

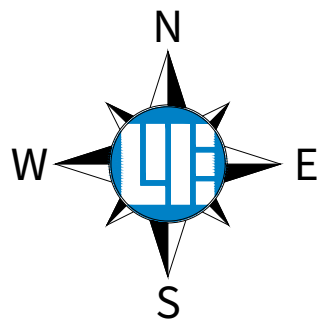




**Know what's below.
Call before you dig.**


Within Indiana Call
811 or 300-382-5544
24 Hours a Day, 7 Days a Week

PER INDIANA STATE LAW IC 8-1-26,
IT IS AGAINST THE LAW TO DIG/PAVE
WITHOUT NOTIFYING THE UNDERGROUND
LOCATION SERVICE TWO (2) WORKING
DAYS BEFORE COMMENCING WORK.

FORCE MAIN
WORK AND DESIGNED BY OTHERS. THIS IS FOR
INFORMATIONAL PURPOSES ONLY.

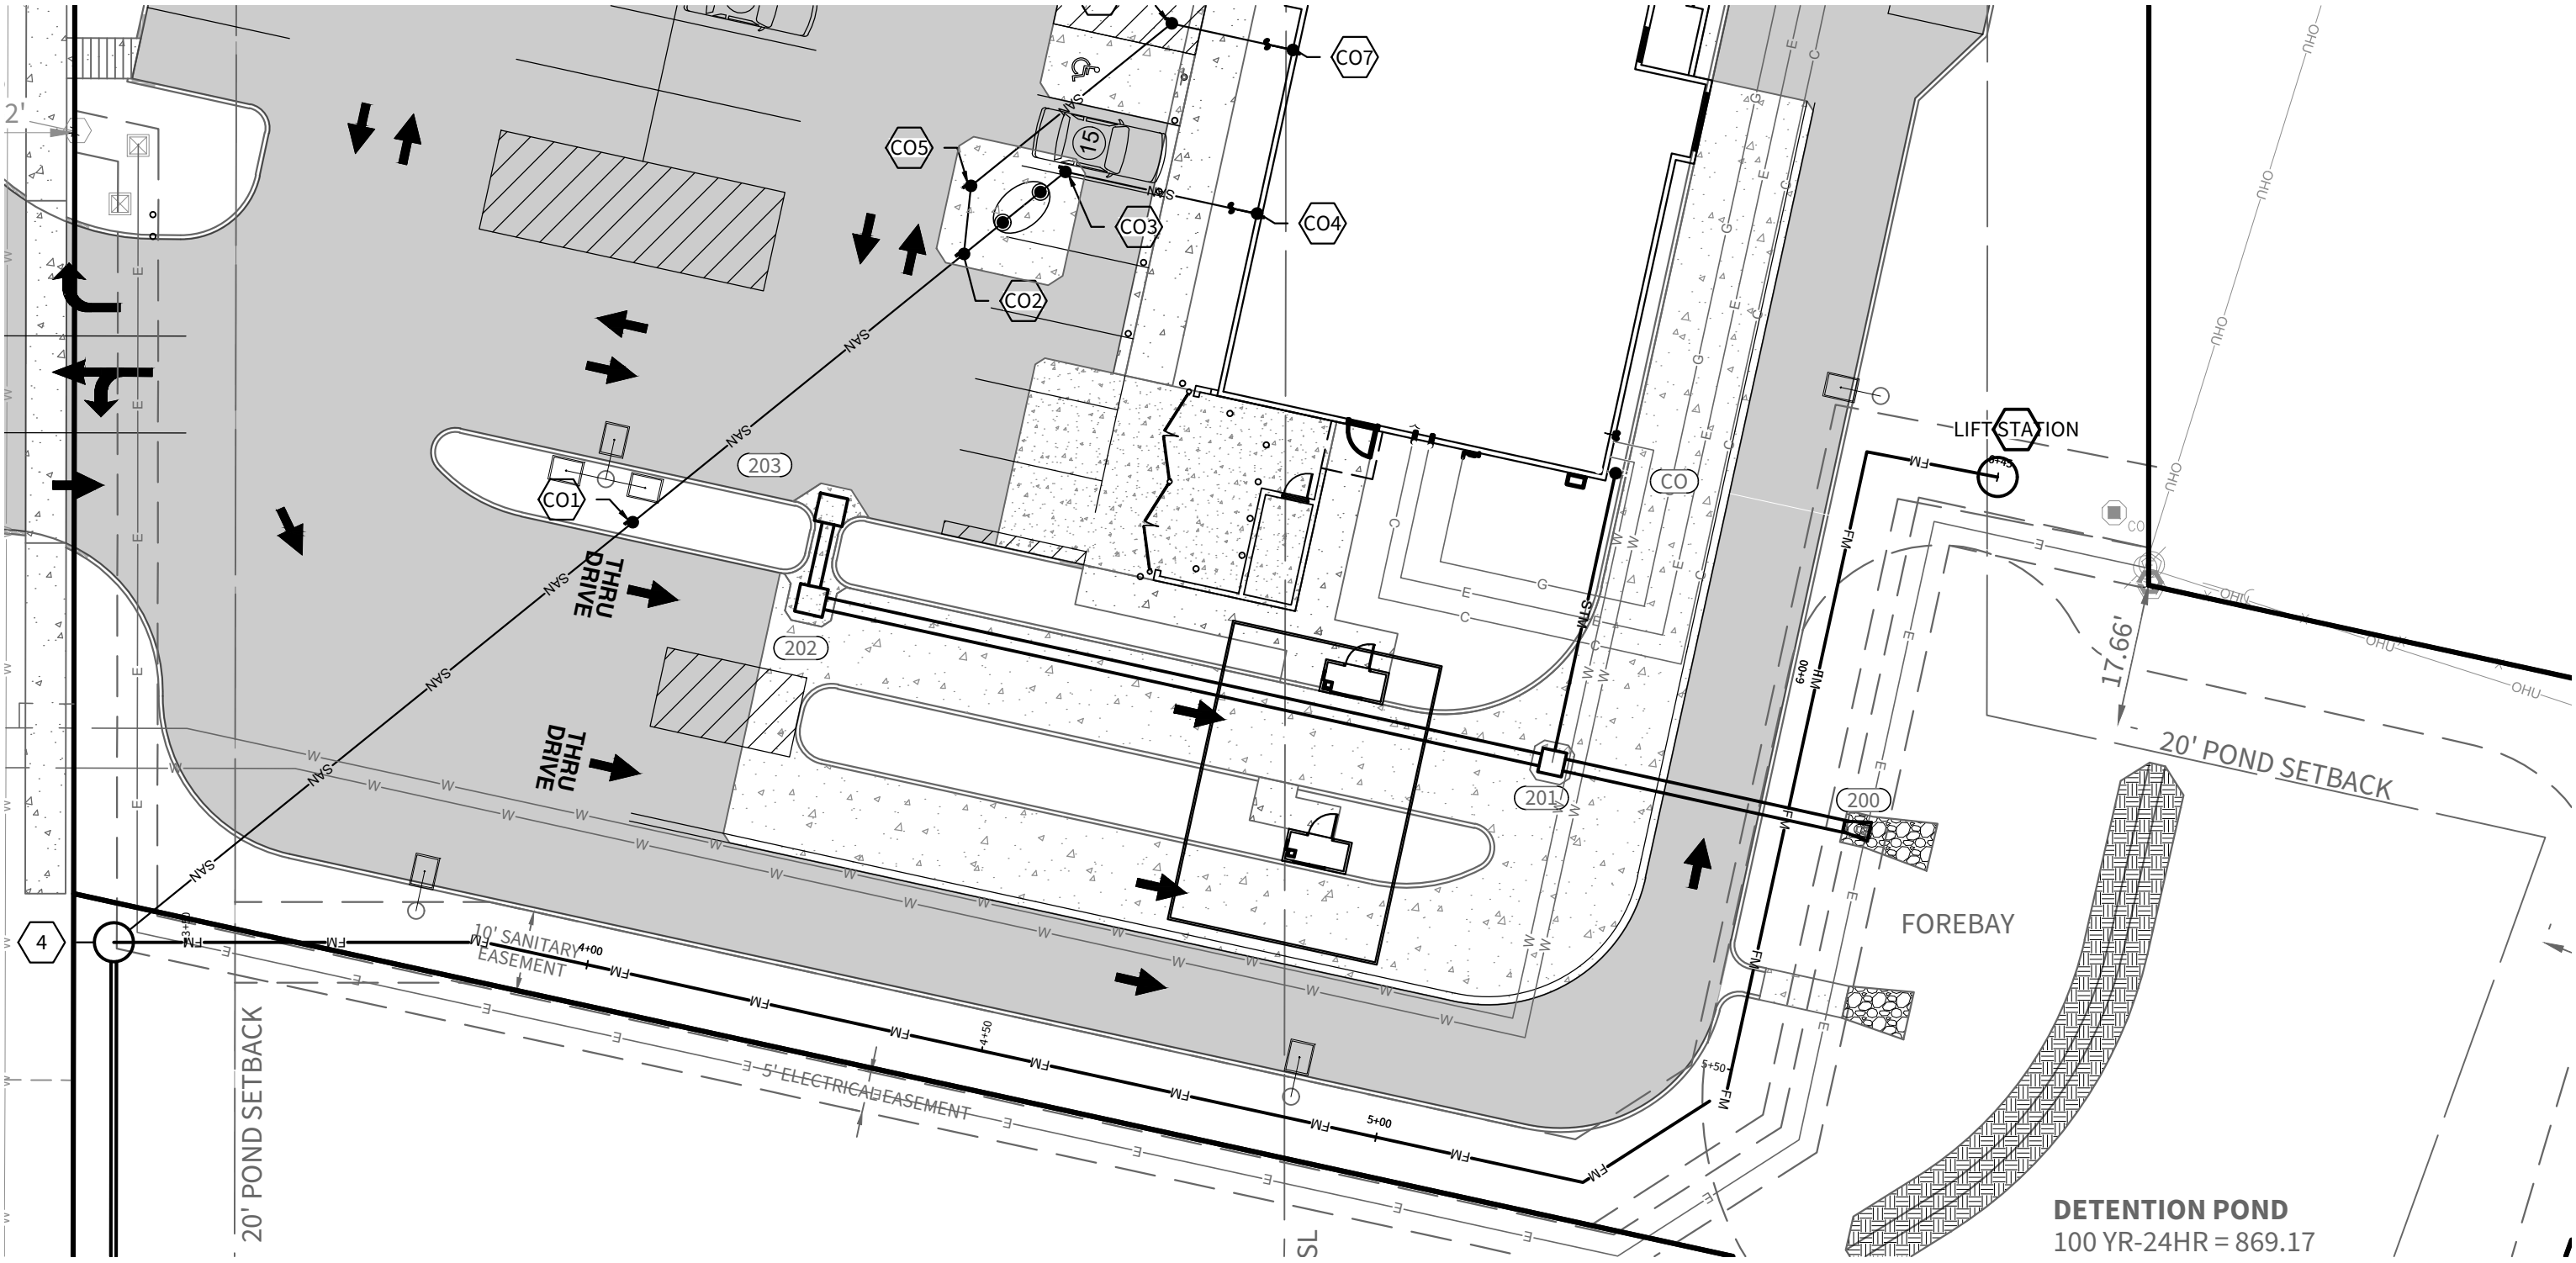

SUBMITTALS AND REVISIONS	
DATE	BY
04.15.2025	JM
05.02.2025	GB
05.13.2026	GB
1. UPDATED LIGHTING PLAN	
2. UPDATED WATER PLAN	
3. CITY COMMENTS	
03/03/2025	

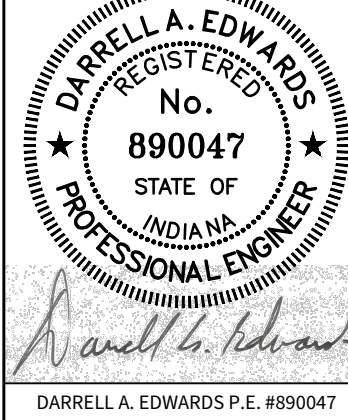

DARRELL A. EDWARDS P.E. #890047

CULVER'S
SEC. W SR 38 & HERITAGE WAY, PENDELTON, INDIANA

FORCE MAIN PLAN & PROFILE
SECTIONS 17 AND 20, TOWNSHIP 18 NORTH, RANGE 7 EAST, FALL CREEK TOWNSHIP, MADISON COUNTY, IN.

SHEET NO.
C5.2

PROJECT NO.
W250894



WEIHE ENGINEERS
BUILD WITH CONFIDENCE™

10505 N. College Ave.
Indianapolis, IN 46280
317.846.6611 · weihe.net

LAND SURVEYING · CIVIL ENGINEERING · SUSTAINABLE DESIGN · LANDSCAPE ARCHITECTURE