
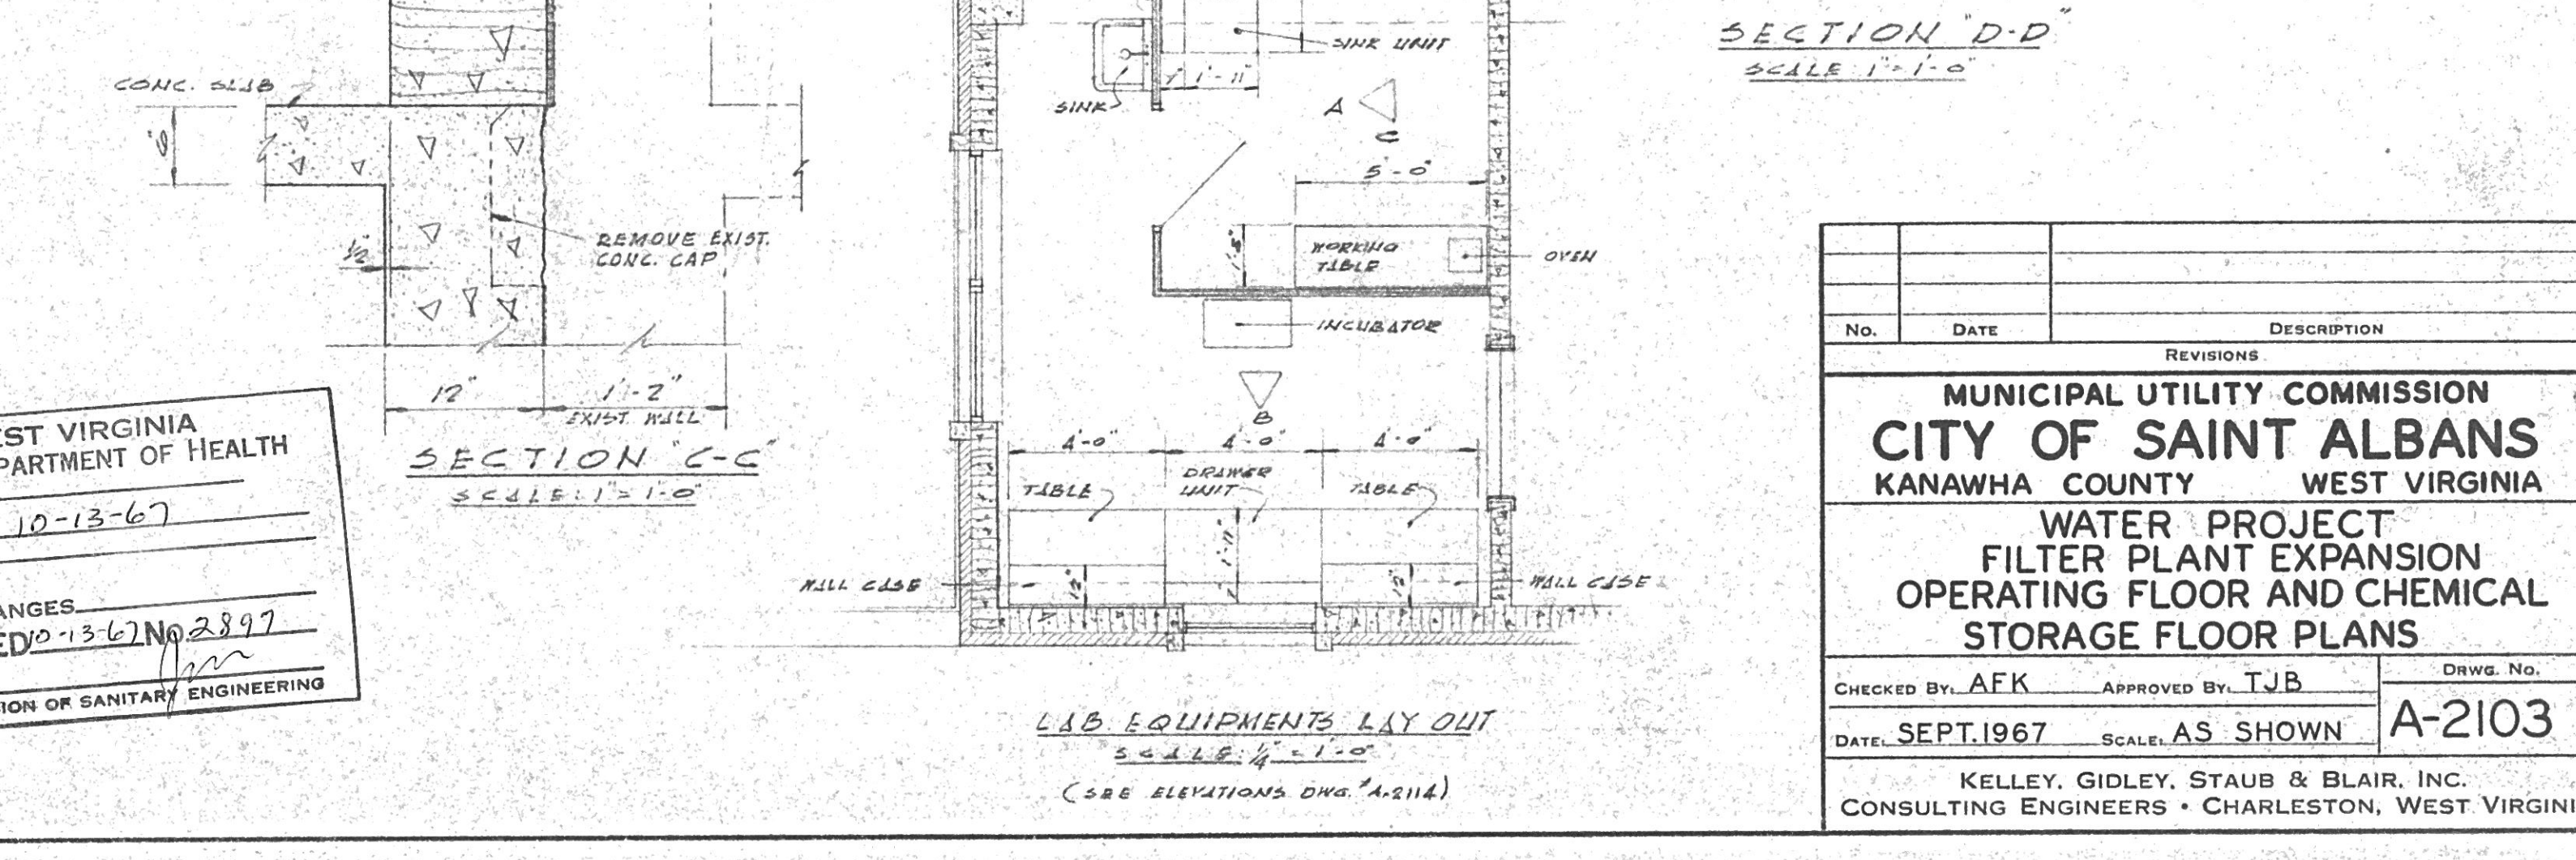
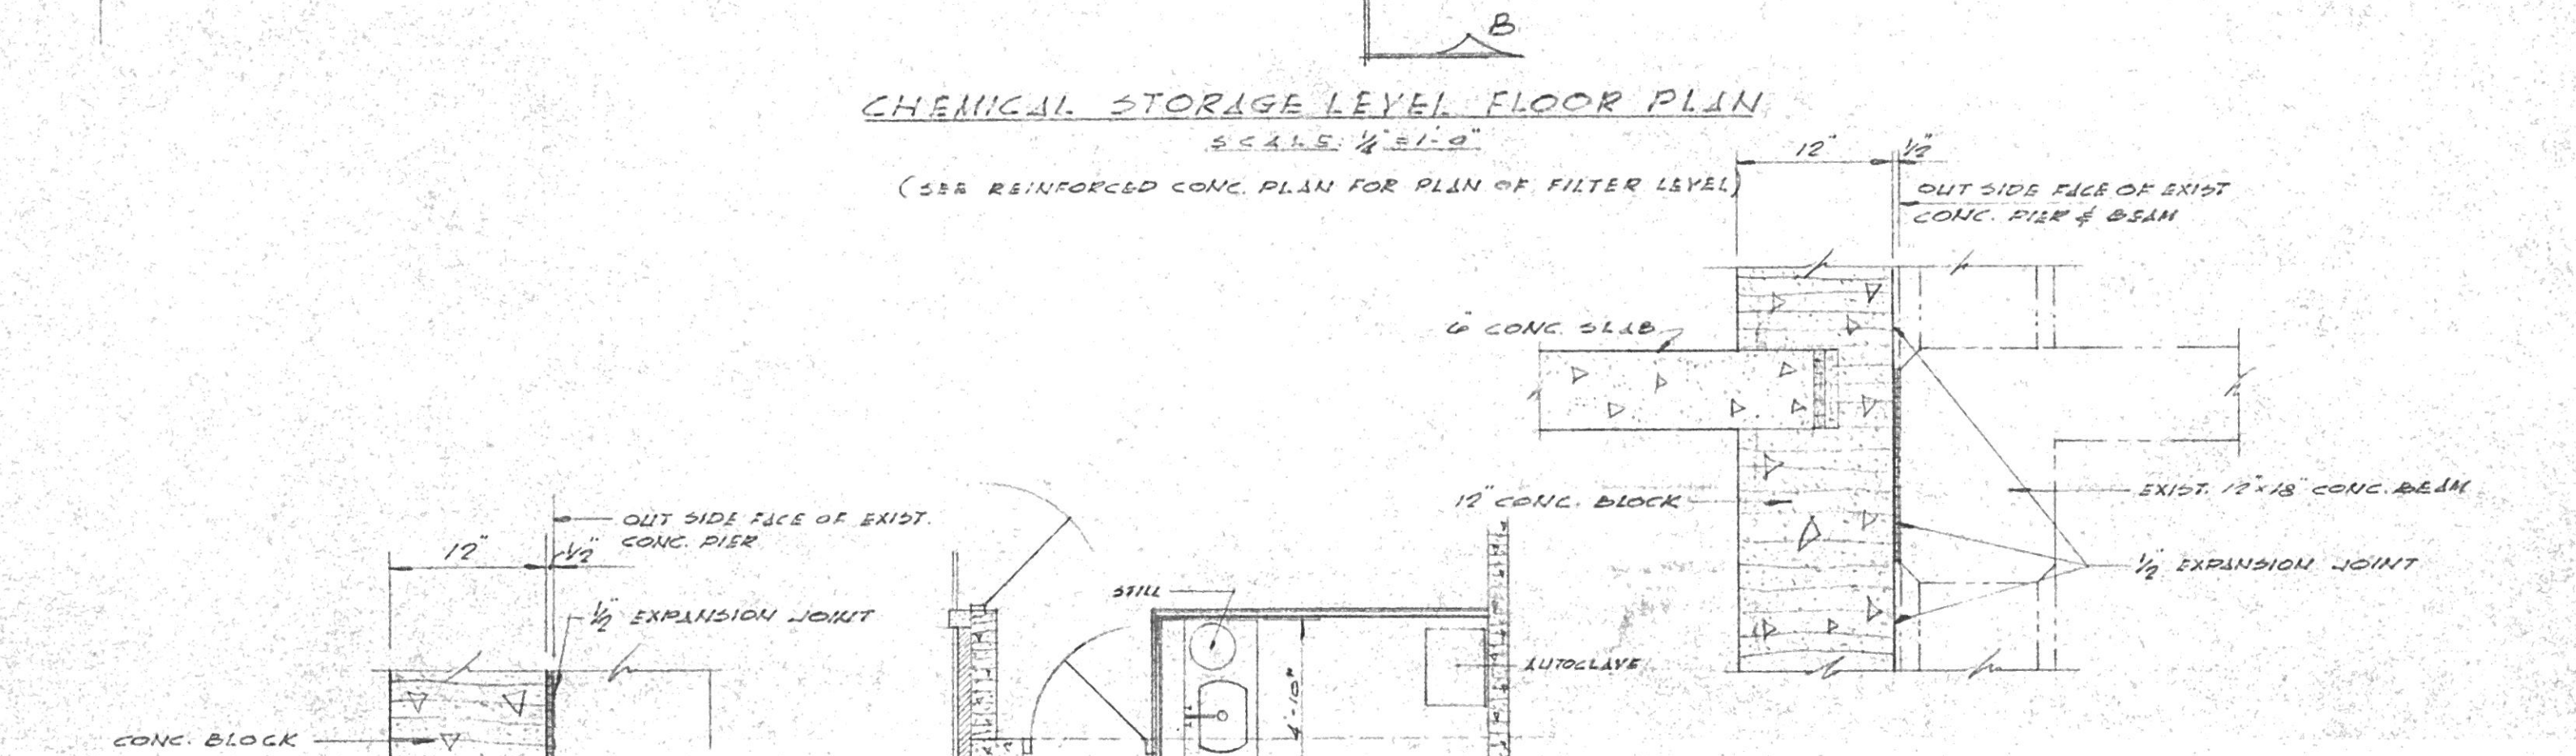
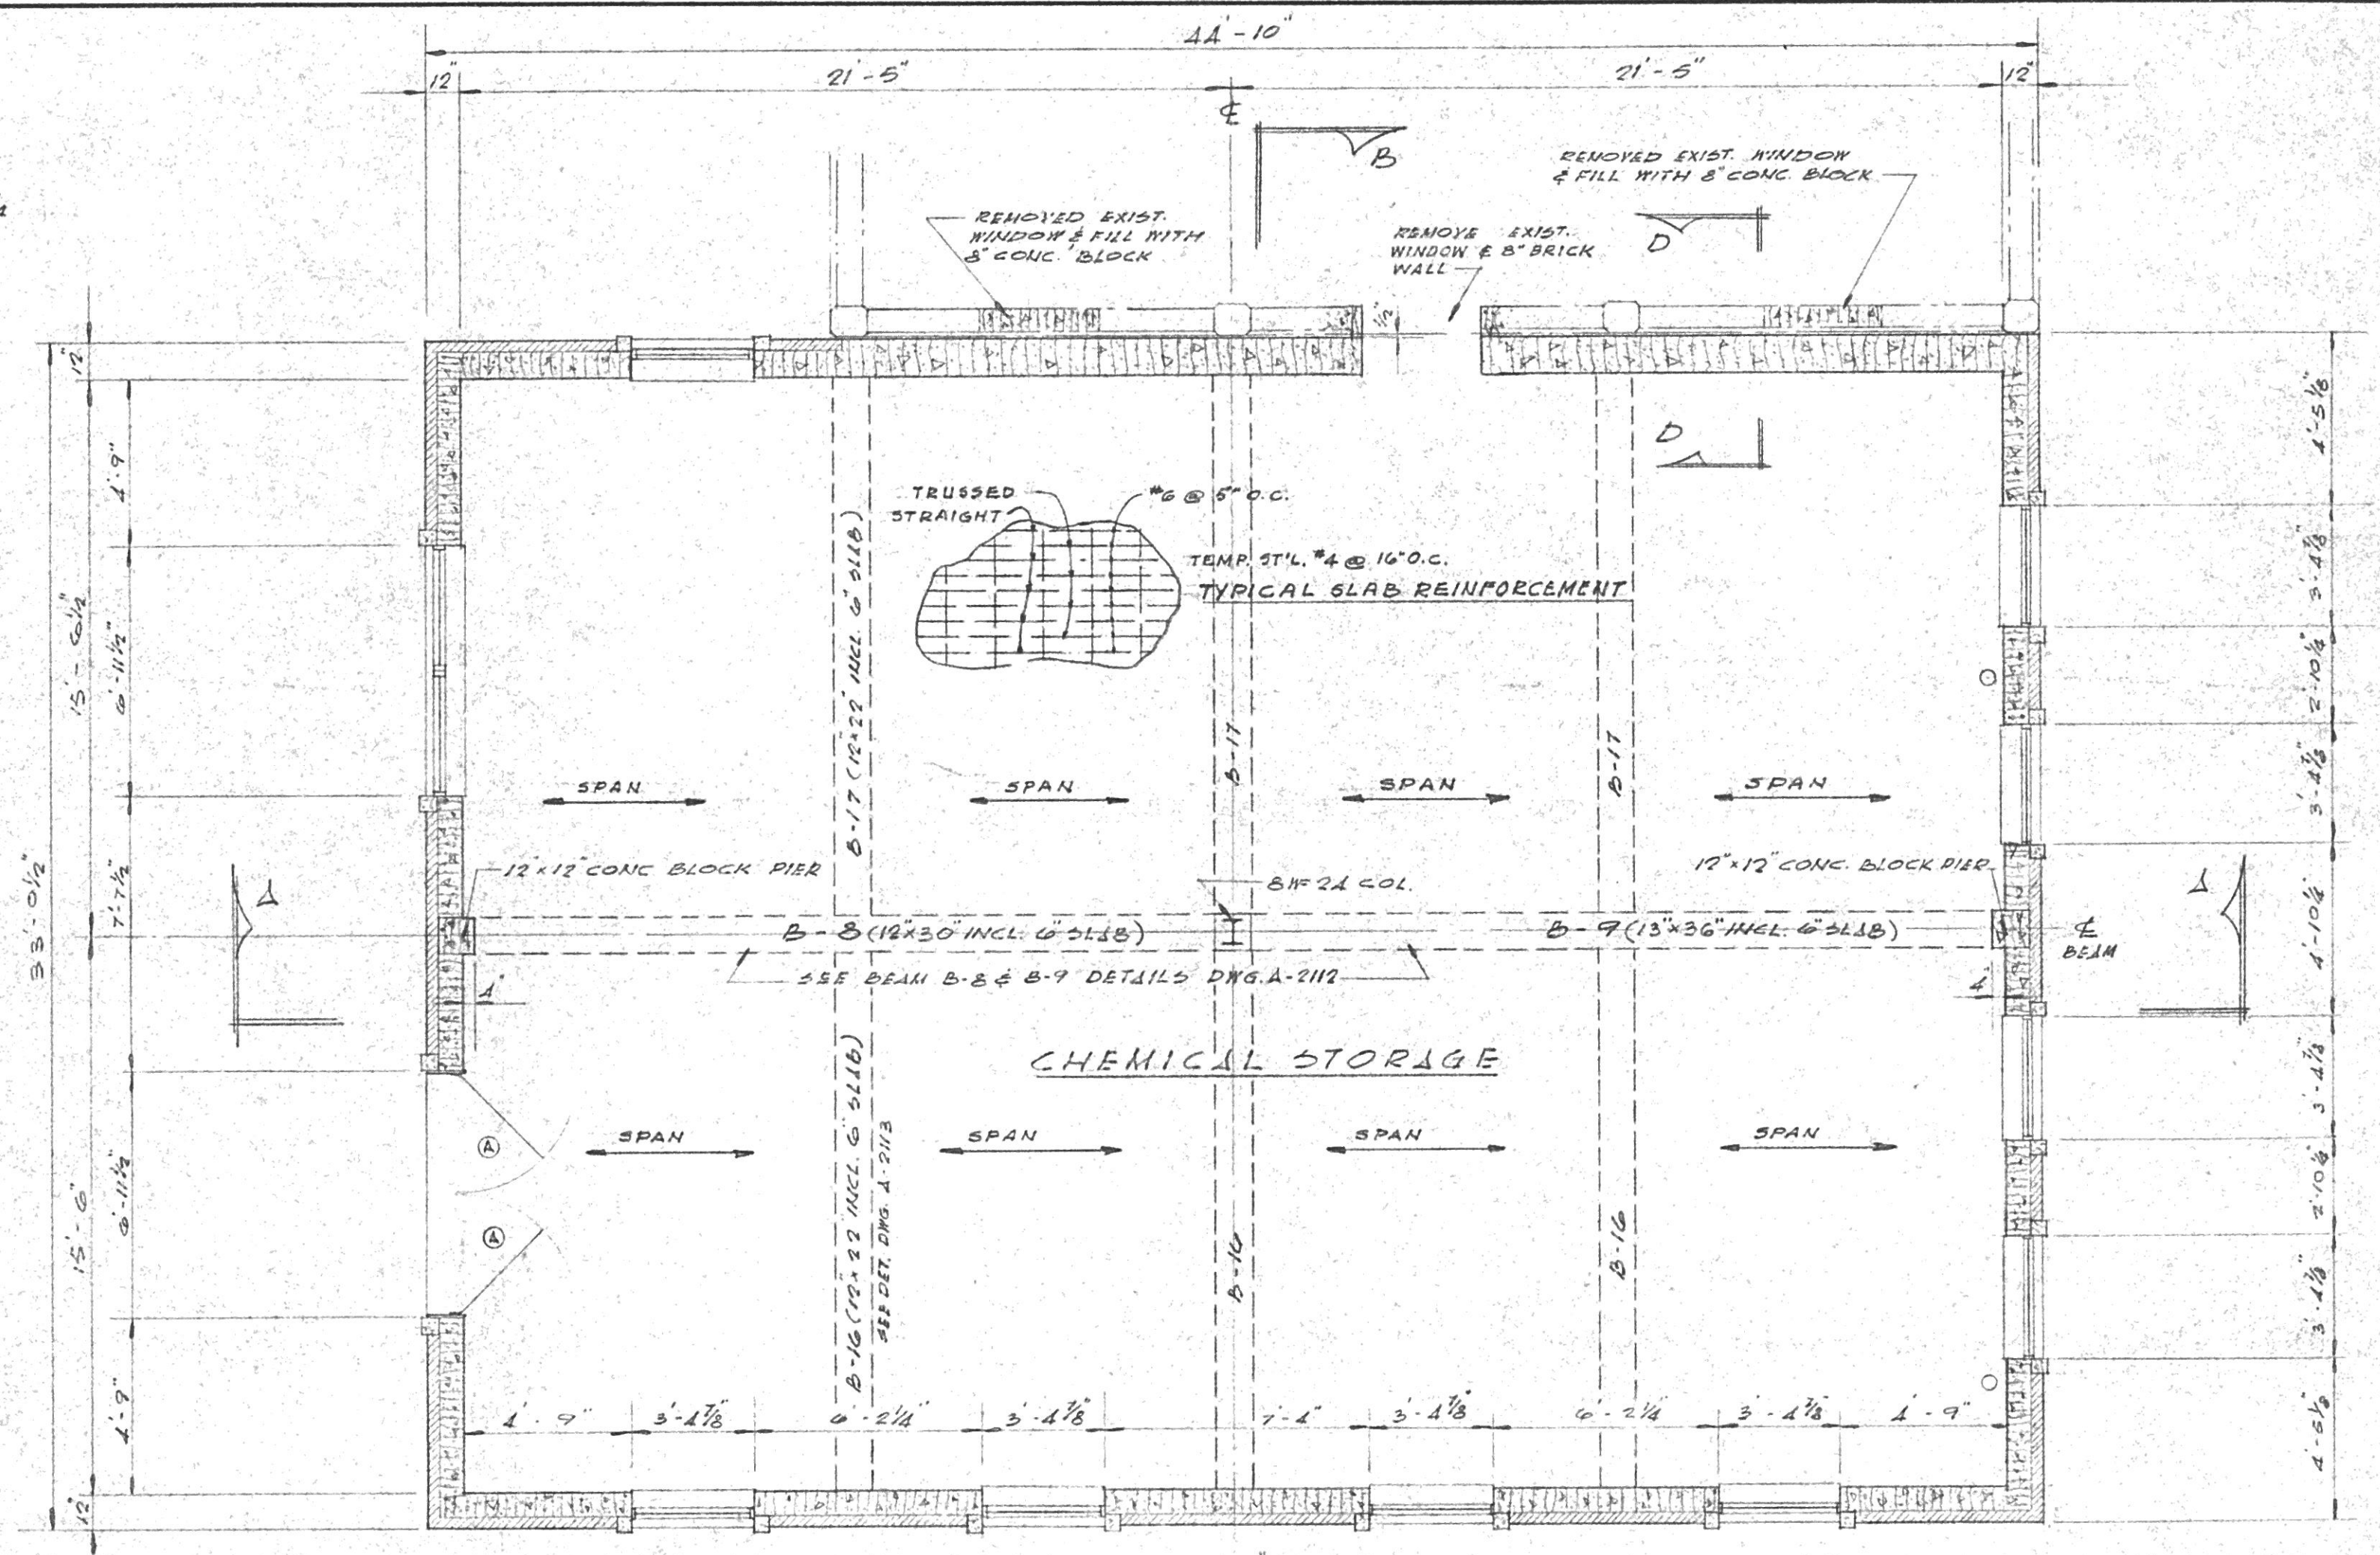
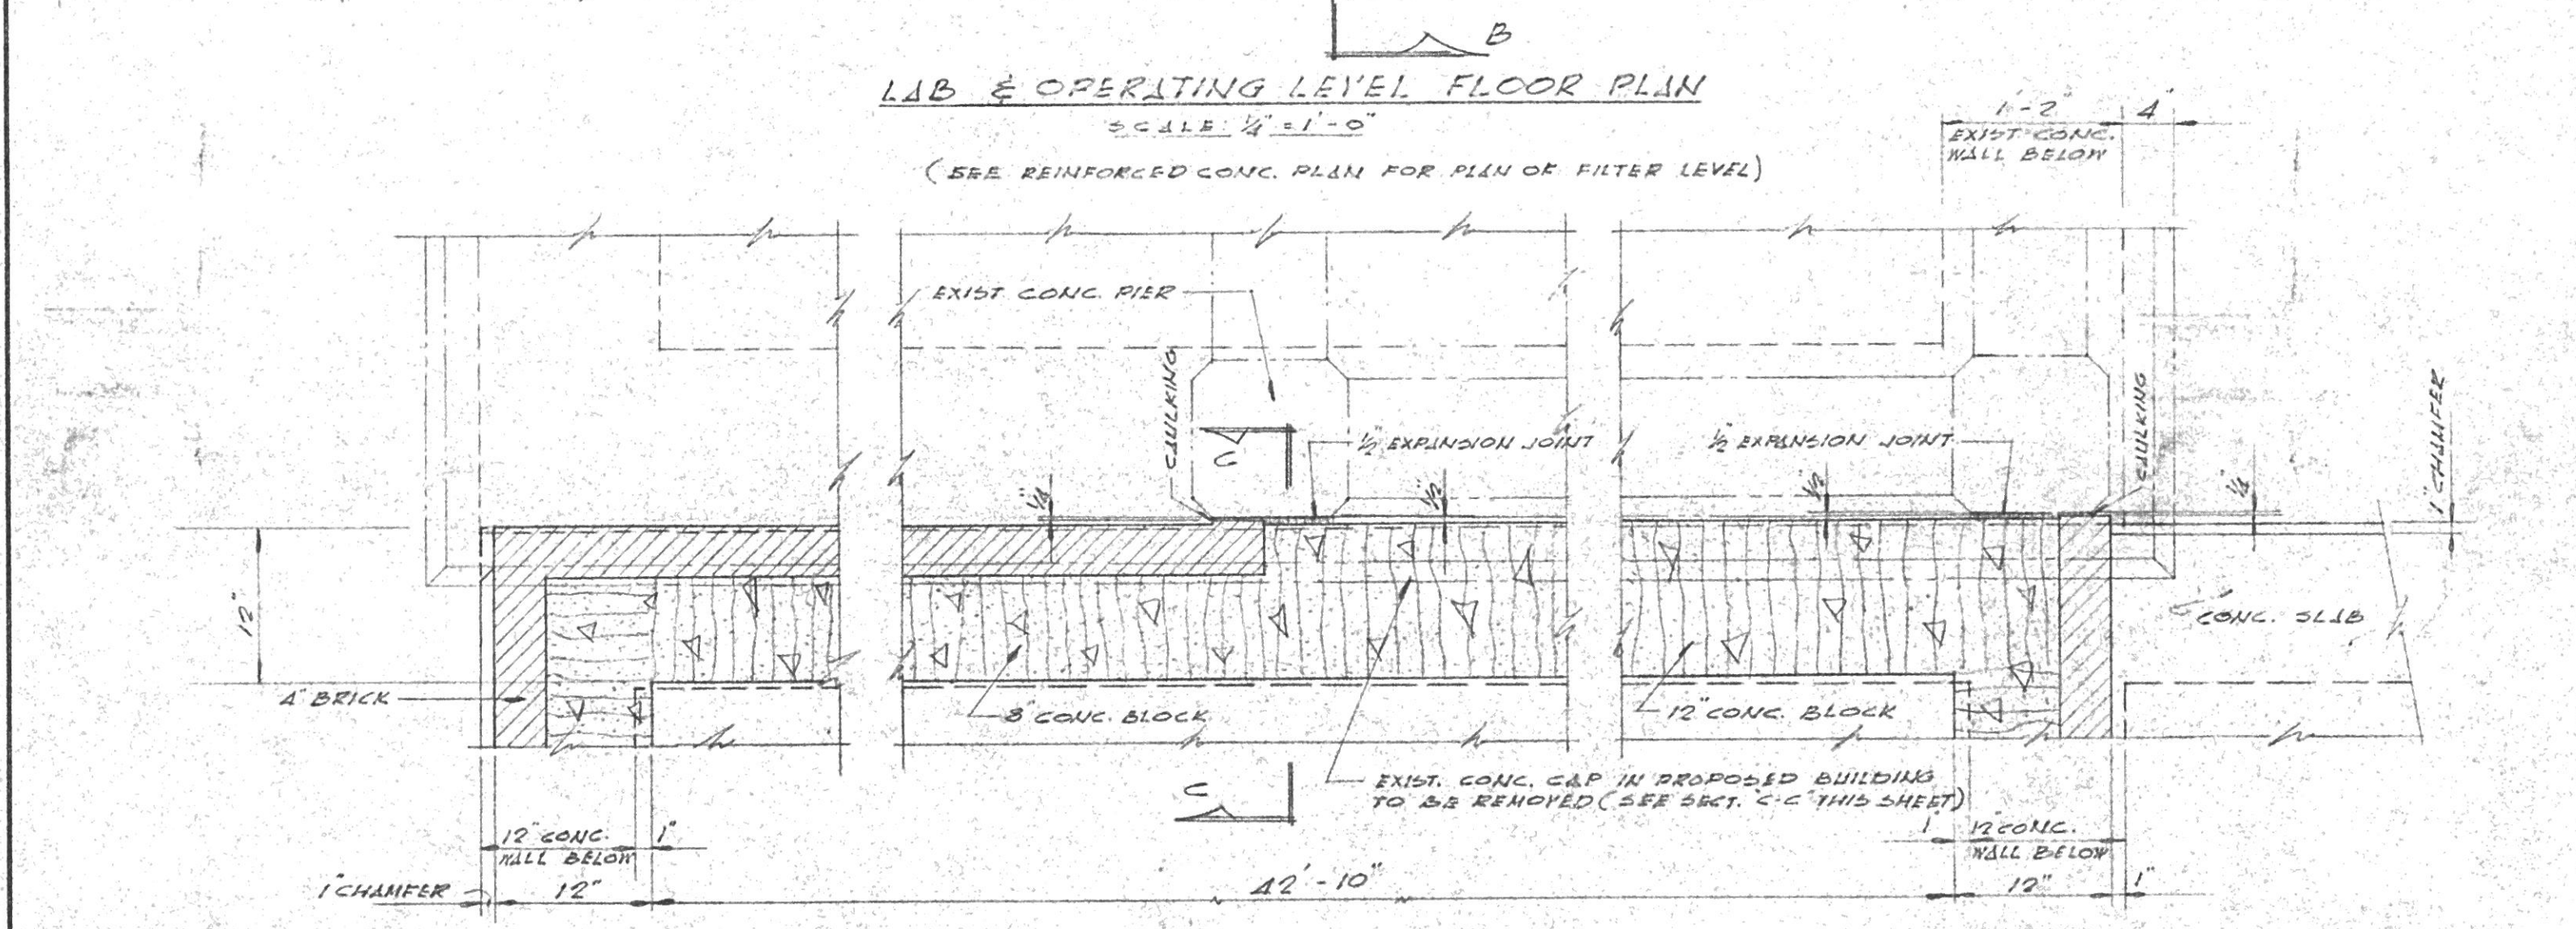


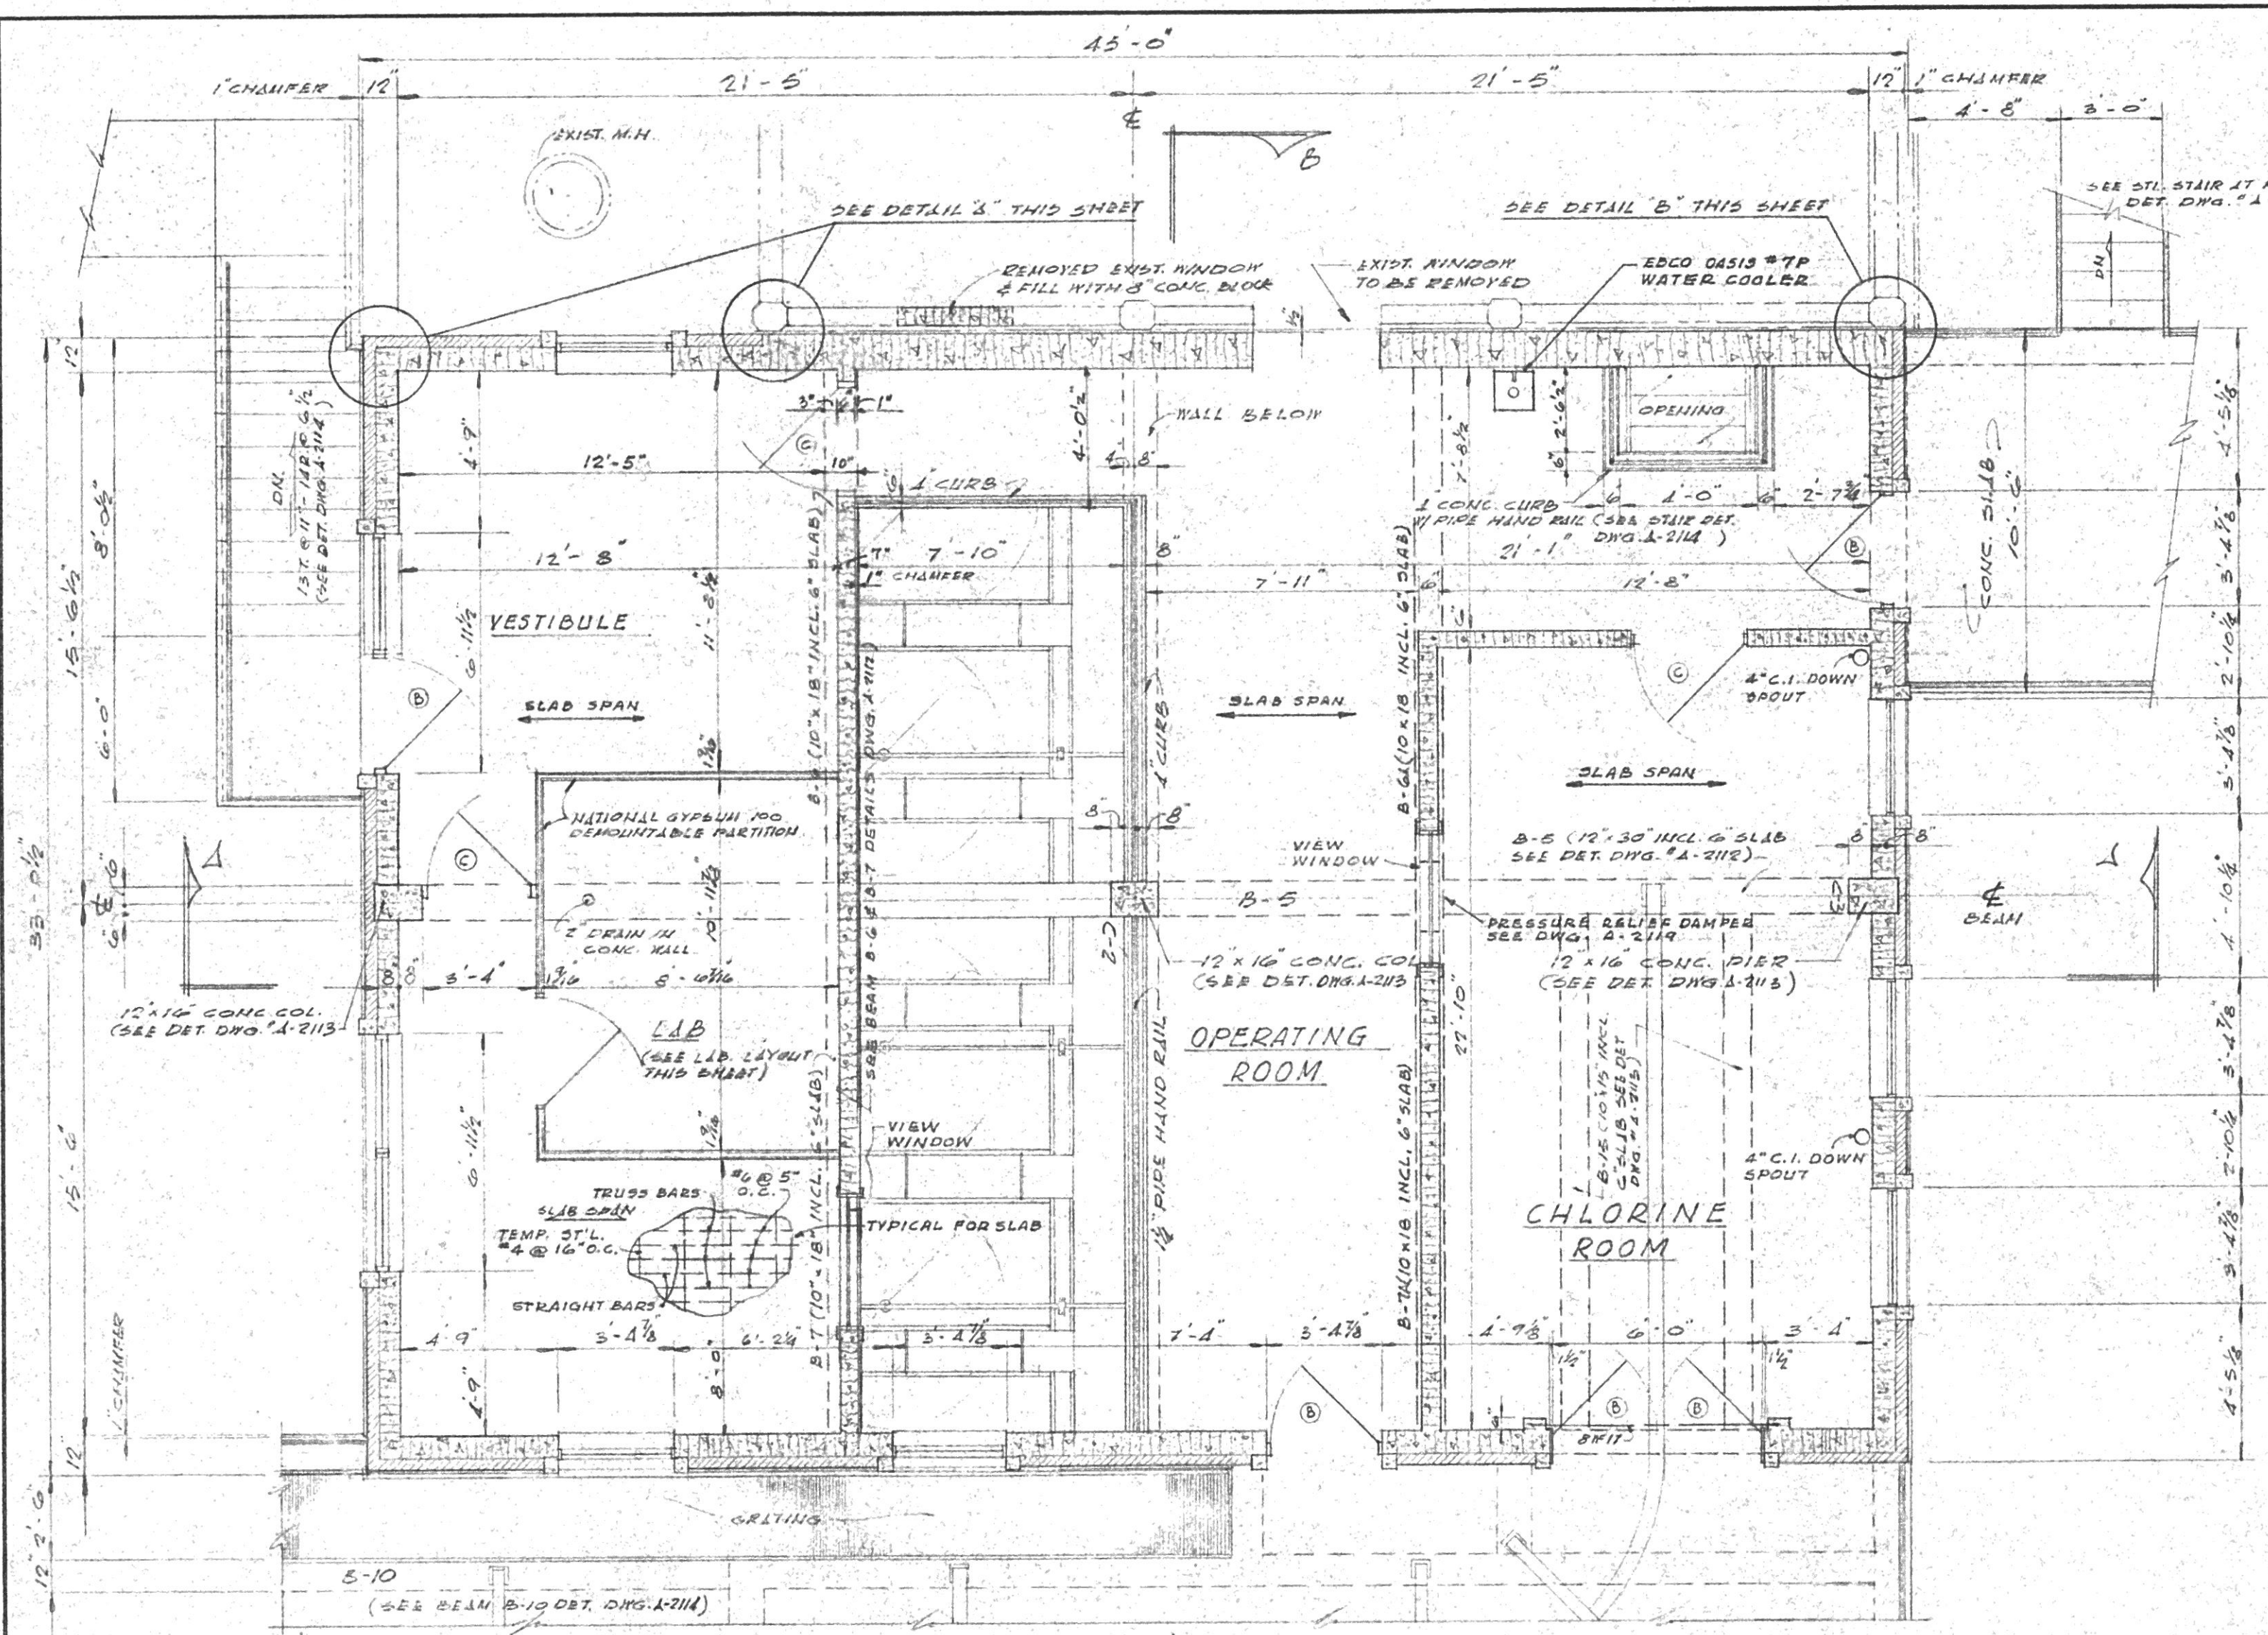

WEST VIRGINIA
 STATE DEPARTMENT OF HEALTH
 RECEIVED 10-13-67
 REJECTED
 RETURNED
 FOR CHANGES
 APPROVED 11-3-67 No. 2897
 DIVISION OF SANITARY ENGINEERING

No.	DATE	DESCRIPTION
REVISIONS		
MUNICIPAL UTILITY COMMISSION		
CITY OF SAINT ALBANS		
KANAWHA COUNTY WEST VIRGINIA		
WATER PROJECT		
FILTER PLANT EXPANSION		
OPERATING FLOOR AND CHEMICAL		
STORAGE FLOOR PLANS		
CHECKED BY: AFK	APPROVED BY: TJB	DRWS. NO.
DATE: SEPT. 1967	SCALE: AS SHOWN	A-2103
KELLEY, GIDLEY, STAUB & BLAIR, INC.		
CONSULTING ENGINEERS • CHARLESTON, WEST VIRGINIA		