




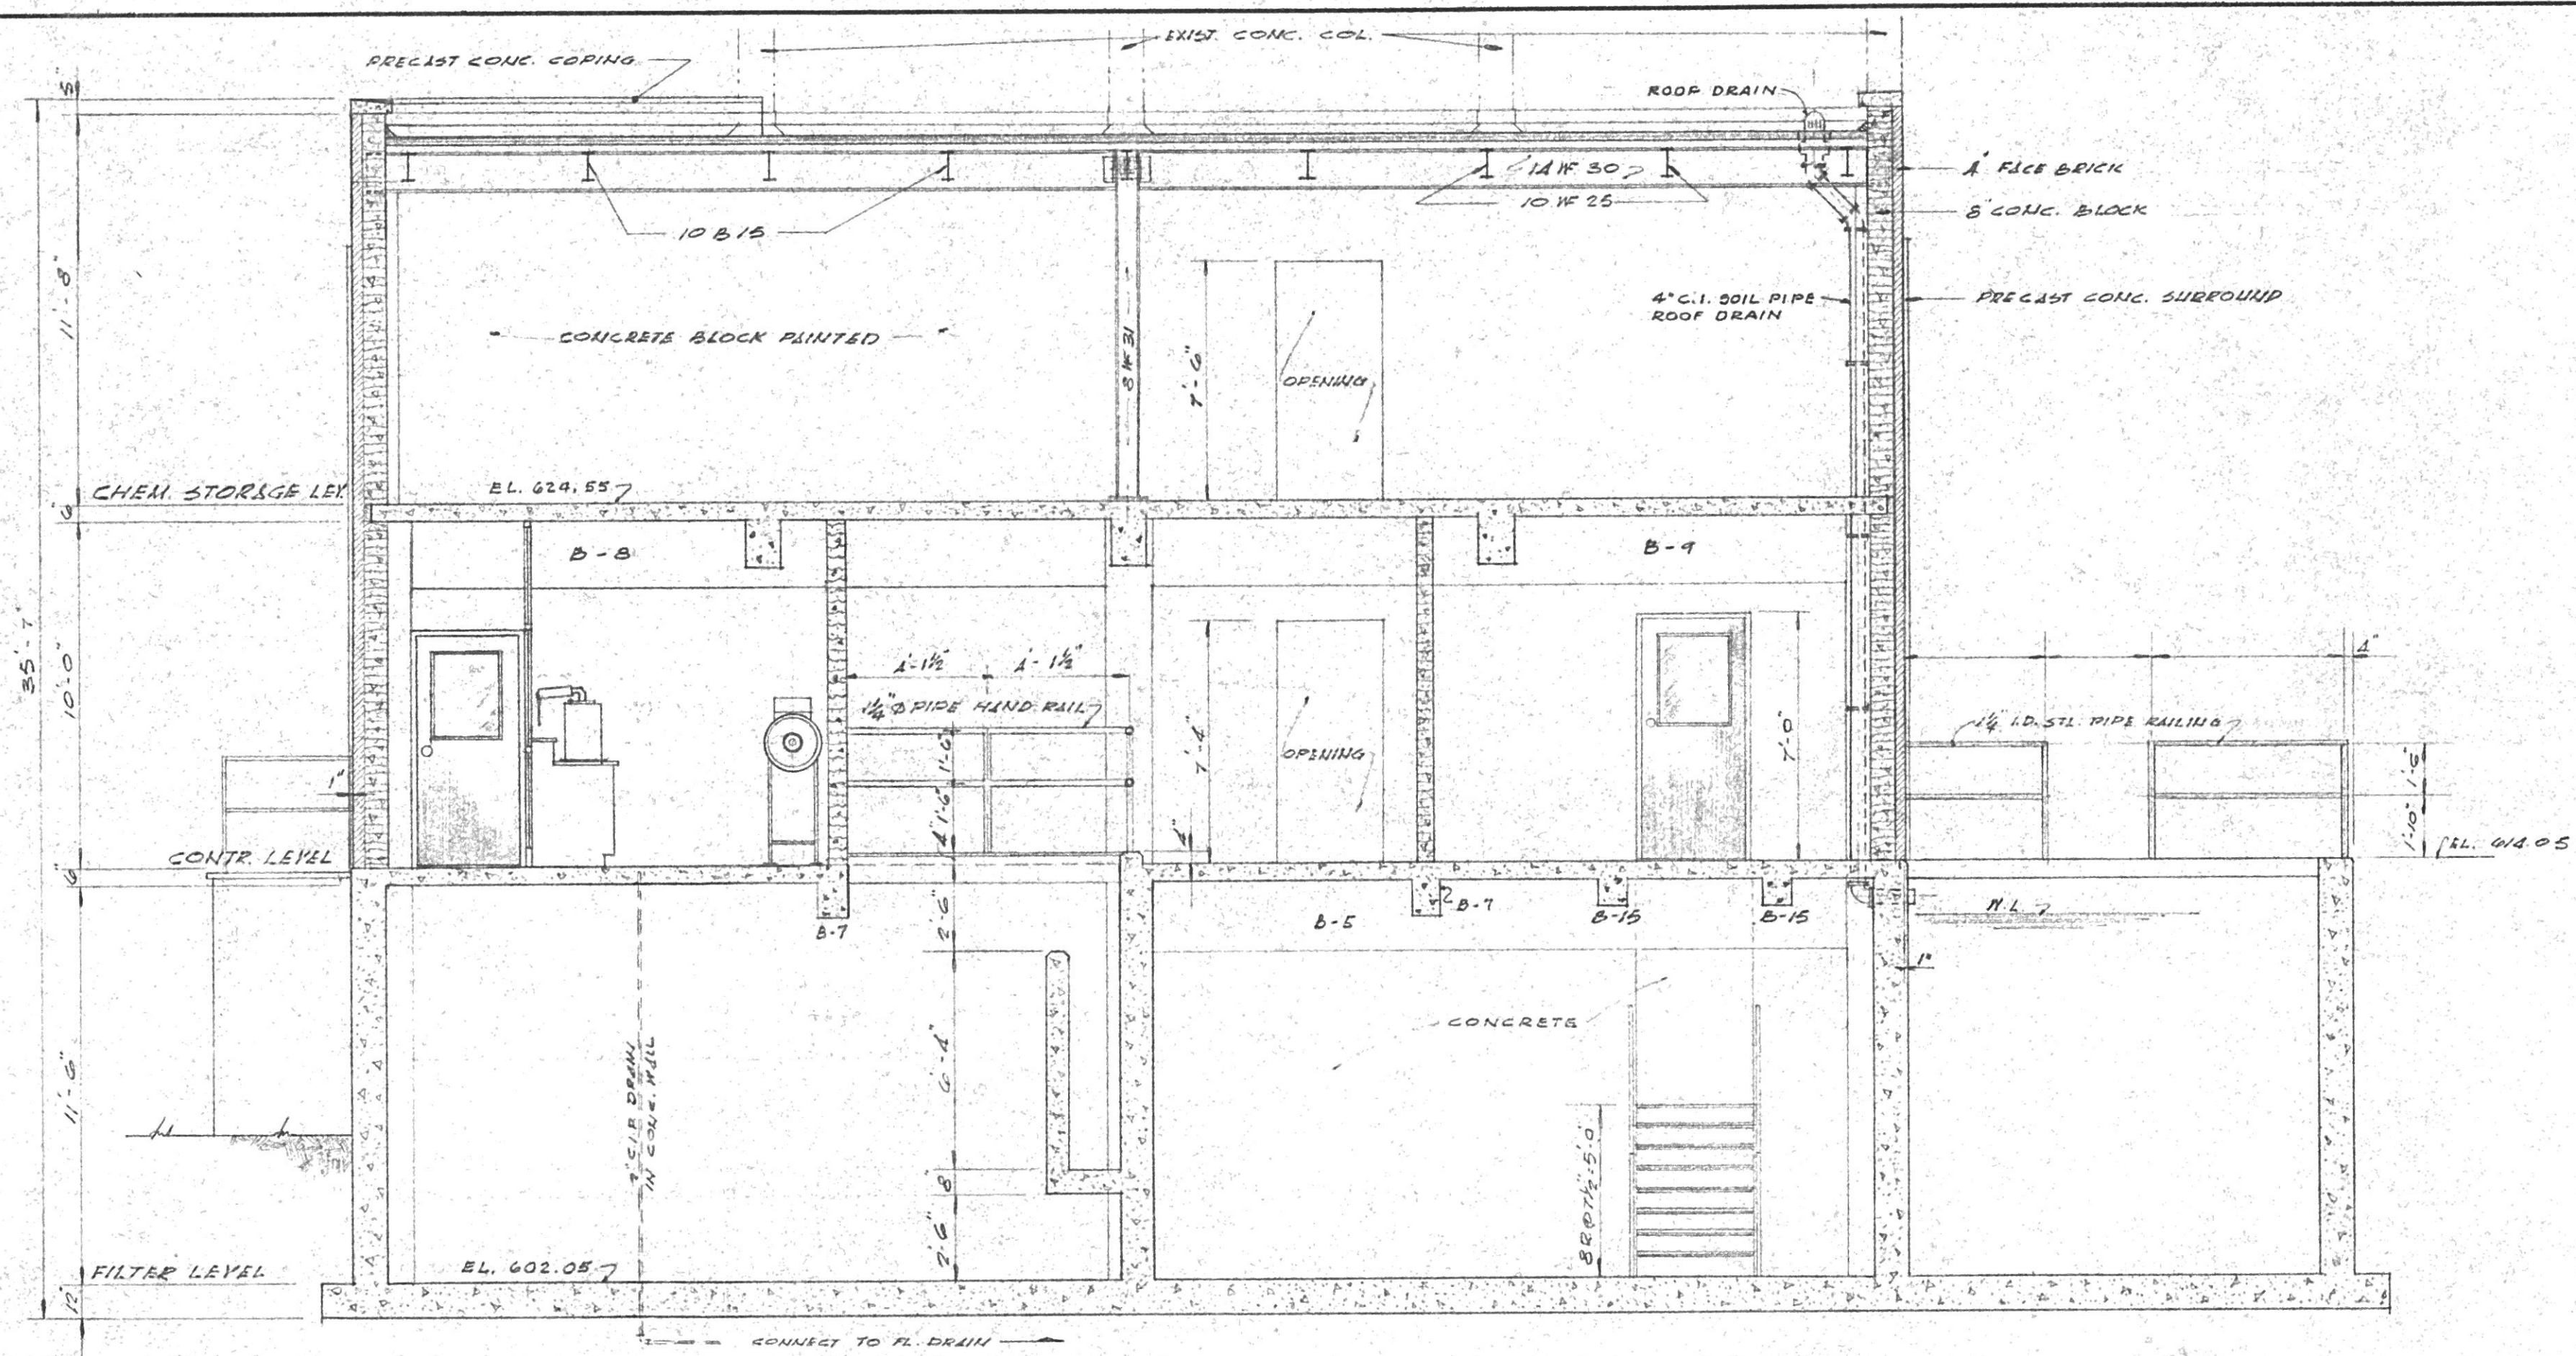


SECTION A-A
SCALE: 1/4" = 1'-0"

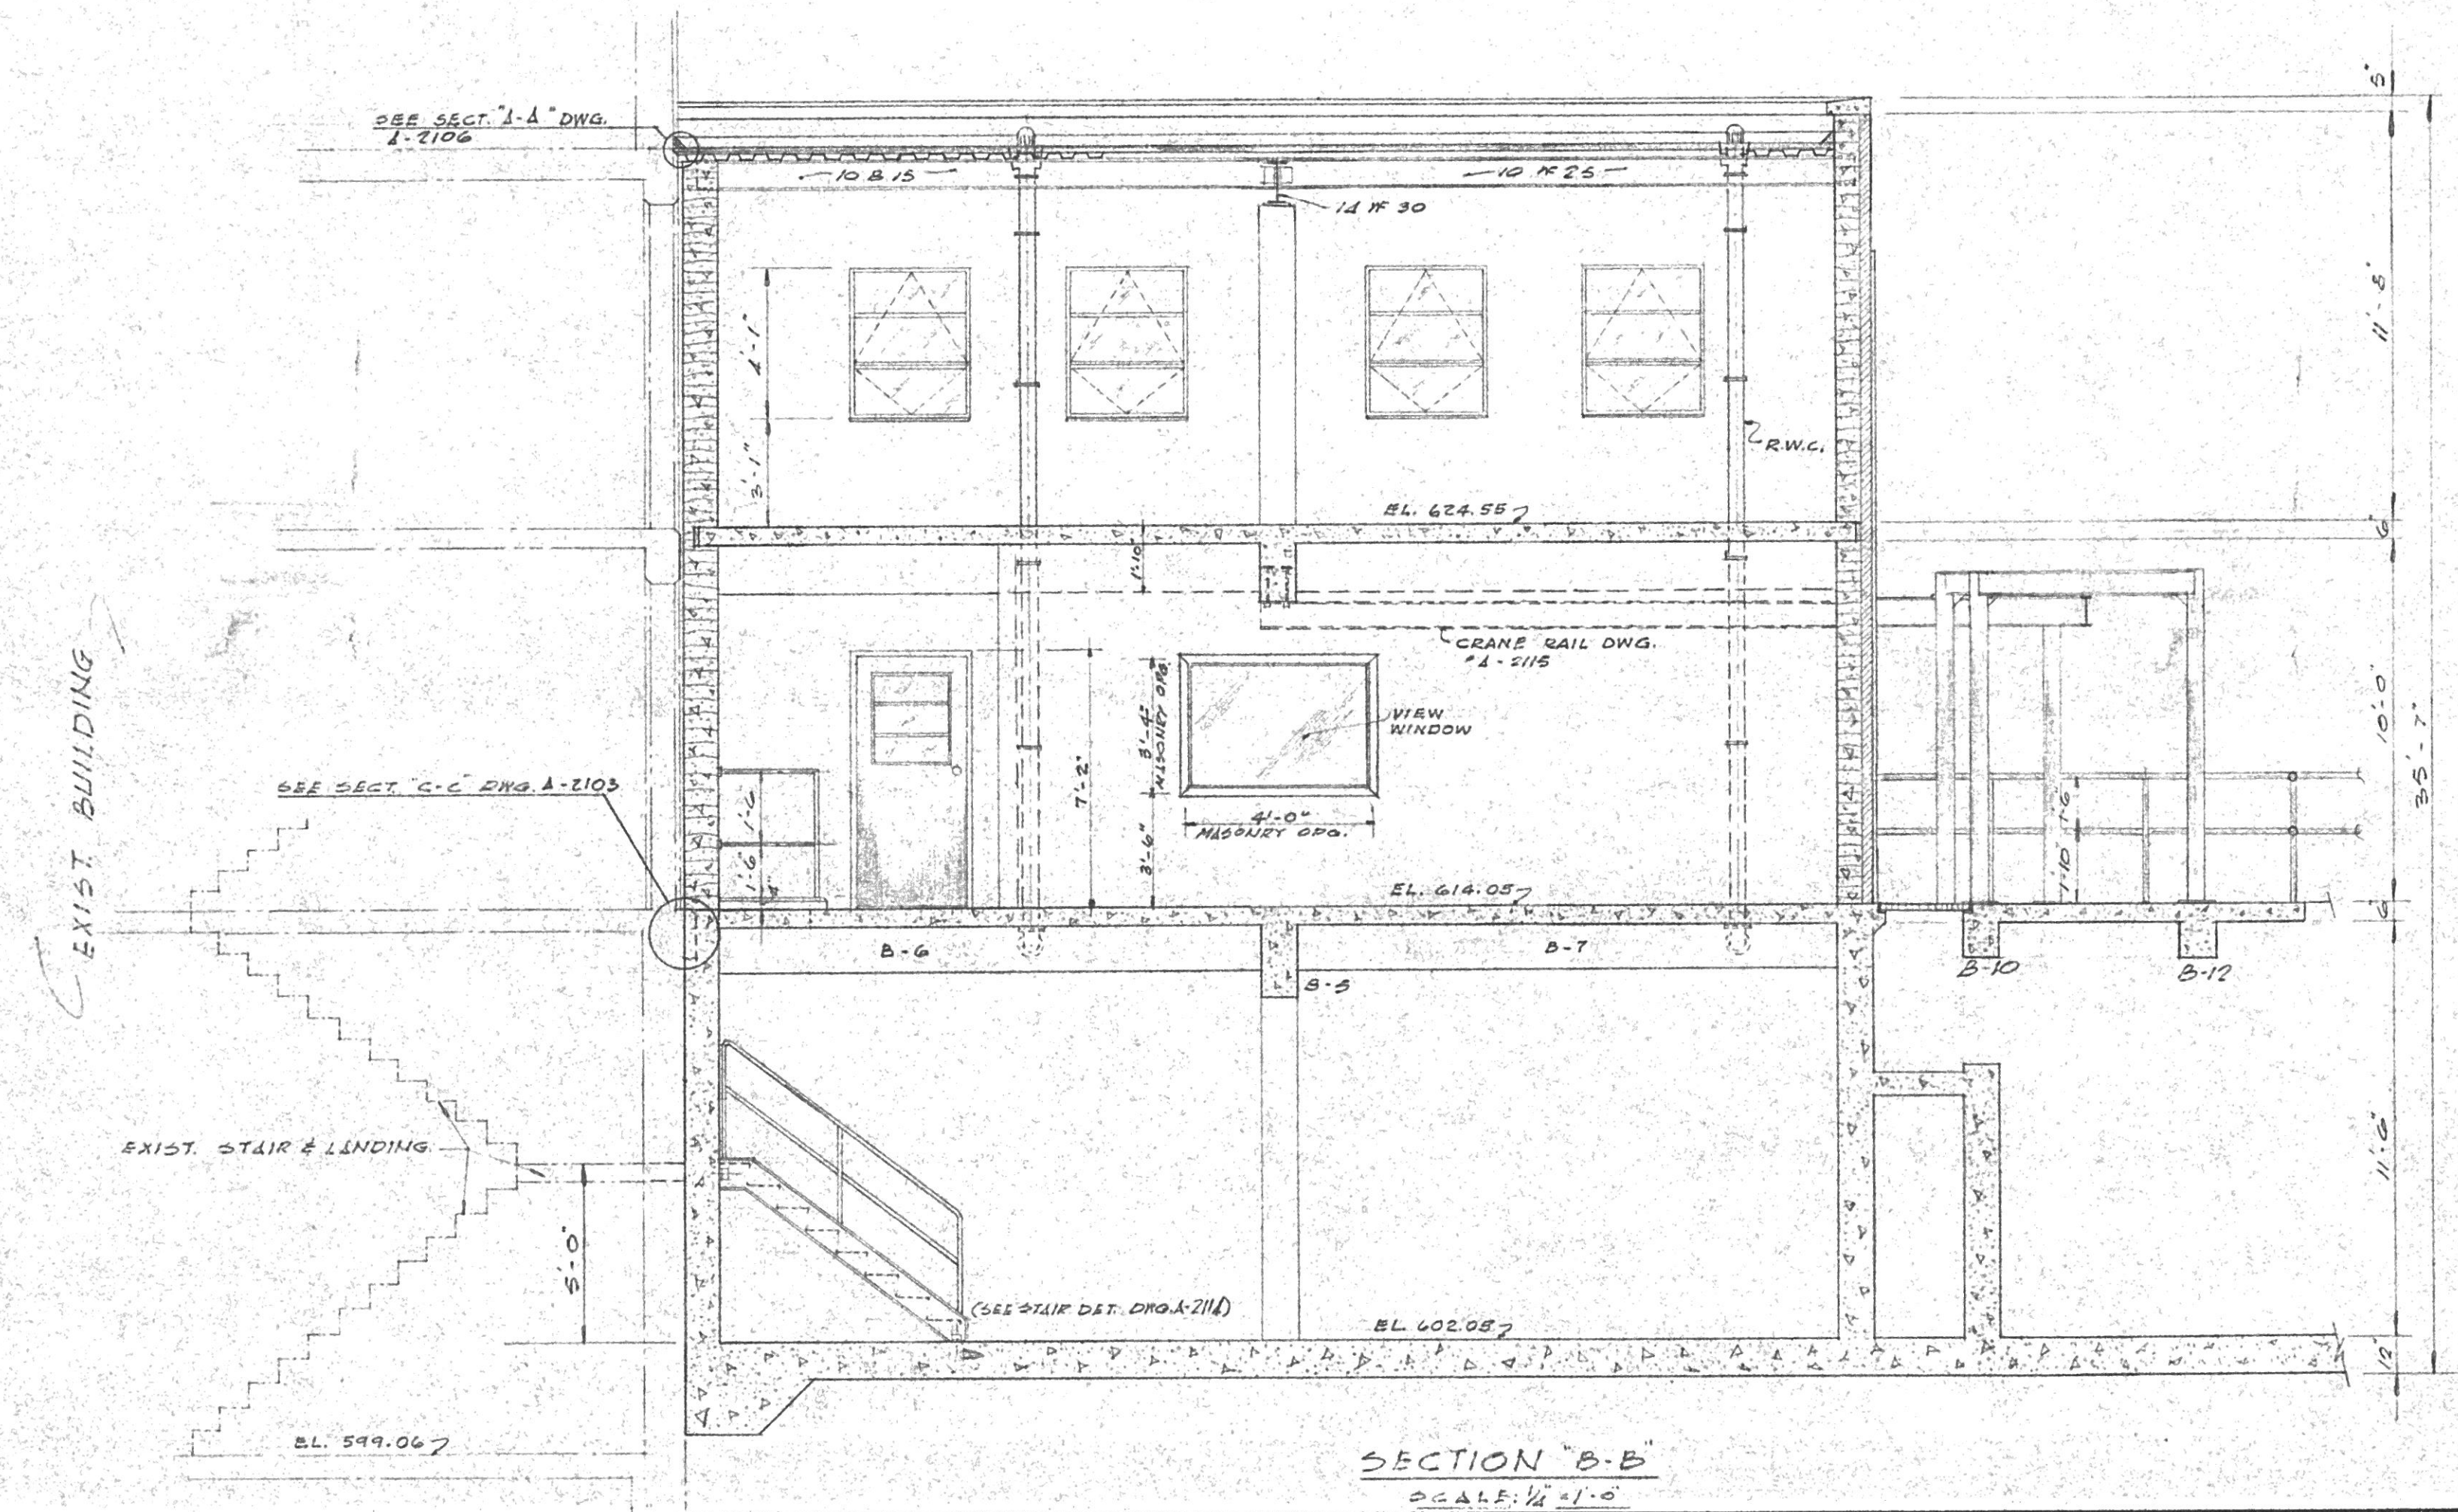

SECTION B-B
SCALE: 1/4" = 1'-0"

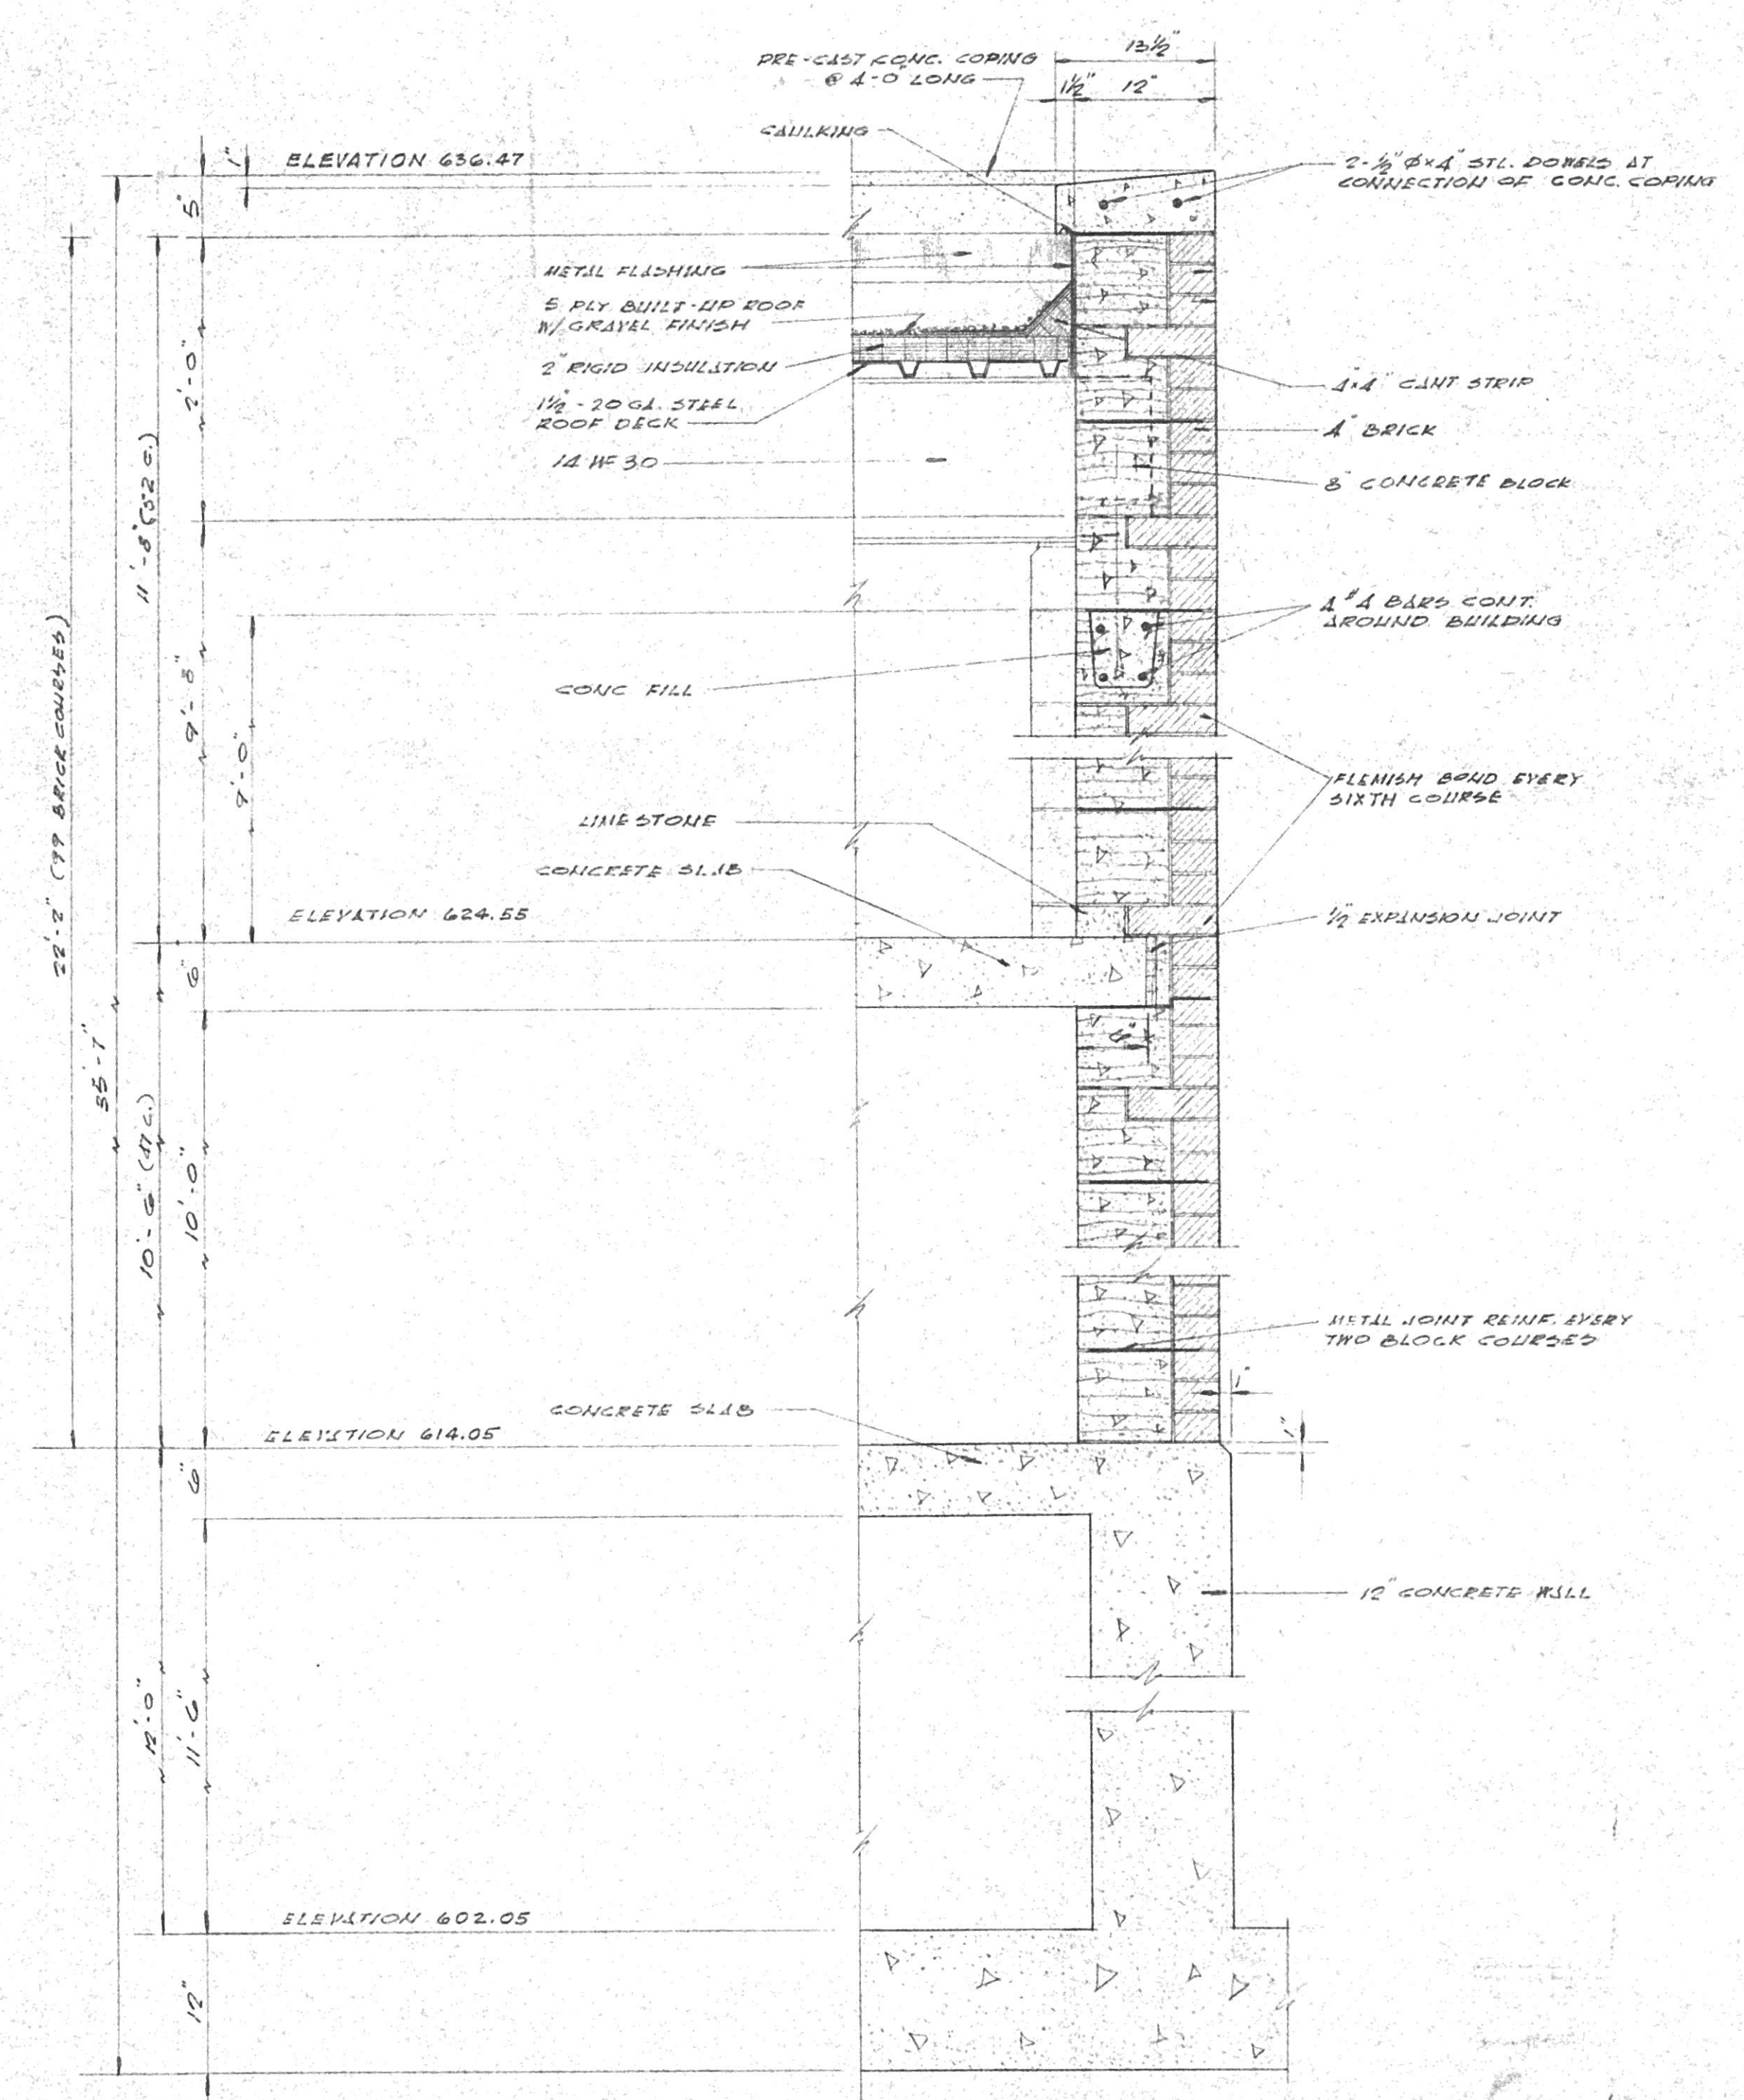

TYPICAL WALL SECTION
SCALE: 1/2" = 1'-0"

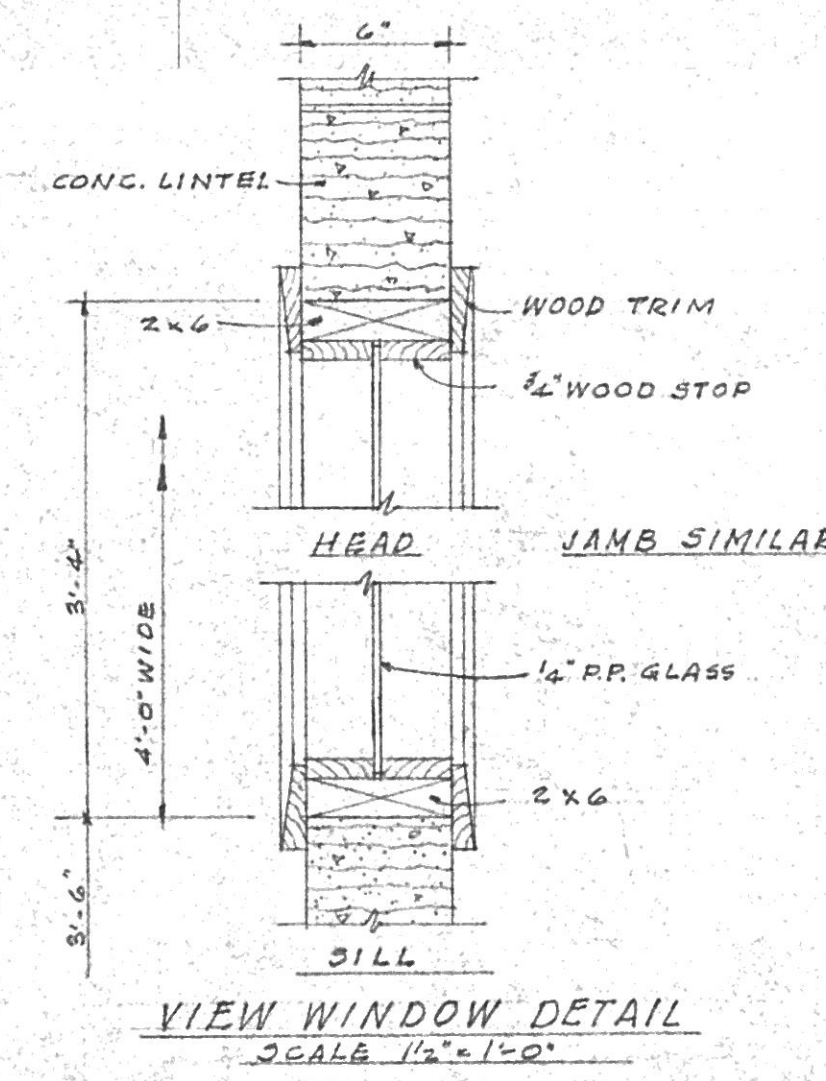

VIEW WINDOW DETAIL
SCALE: 1/2" = 1'-0"

WEST VIRGINIA
STATE DEPARTMENT OF HEALTH
RECEIVED 10-13-67
REJECTED
RETURNED
FOR CHANGES
APPROVED 11-13-67 NO. 2447
DIVISION OF SANITARY ENGINEERING

No.	DATE	REVISIONS	DESCRIPTION
MUNICIPAL UTILITY COMMISSION			
CITY OF SAINT ALBANS			
KANAWHA COUNTY WEST VIRGINIA			
WATER PROJECT			
FILTER PLANT EXPANSION			
BUILDING SECTIONS AND			
DETAILS			
CHECKED BY: AFK		APPROVED BY: TJB	
DATE: SEPT. 1967		SCALE: AS SHOWN	
KELLEY, GIDLEY, STAUB & BLAIR, INC.		CONSULTING ENGINEERS • CHARLESTON, WEST VIRGINIA	
DRWG. No.			A-2104