






SITE PLAN
SCALE: 1" = 100'

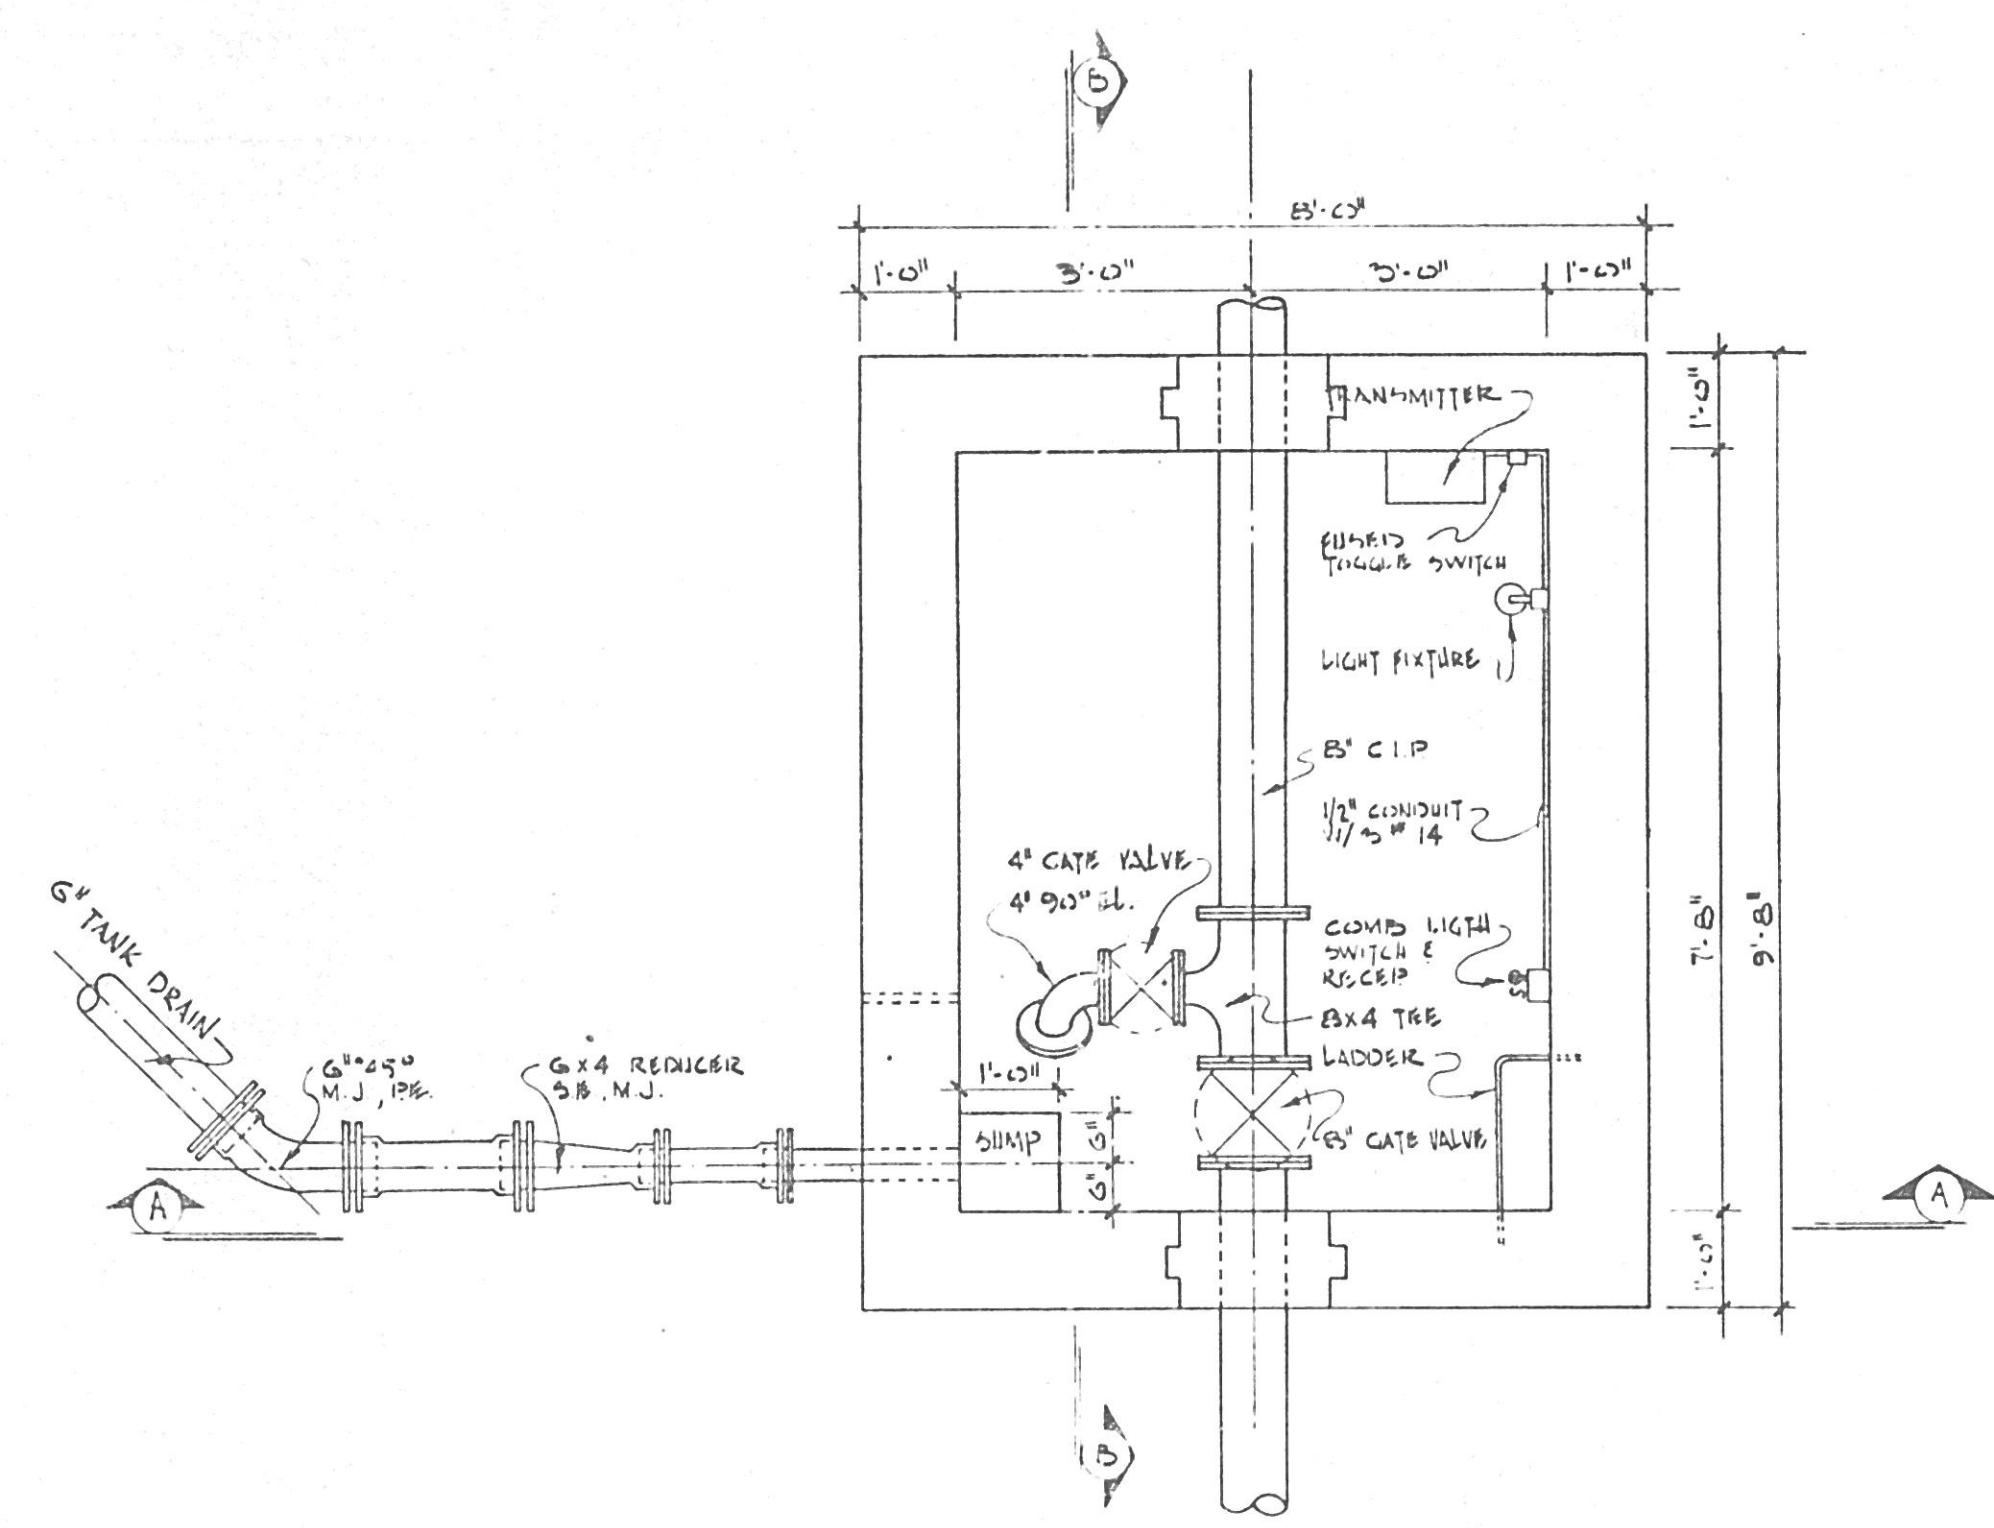


PLAN OF TANK VAULT
SCALE: 1/2" = 1'-0"

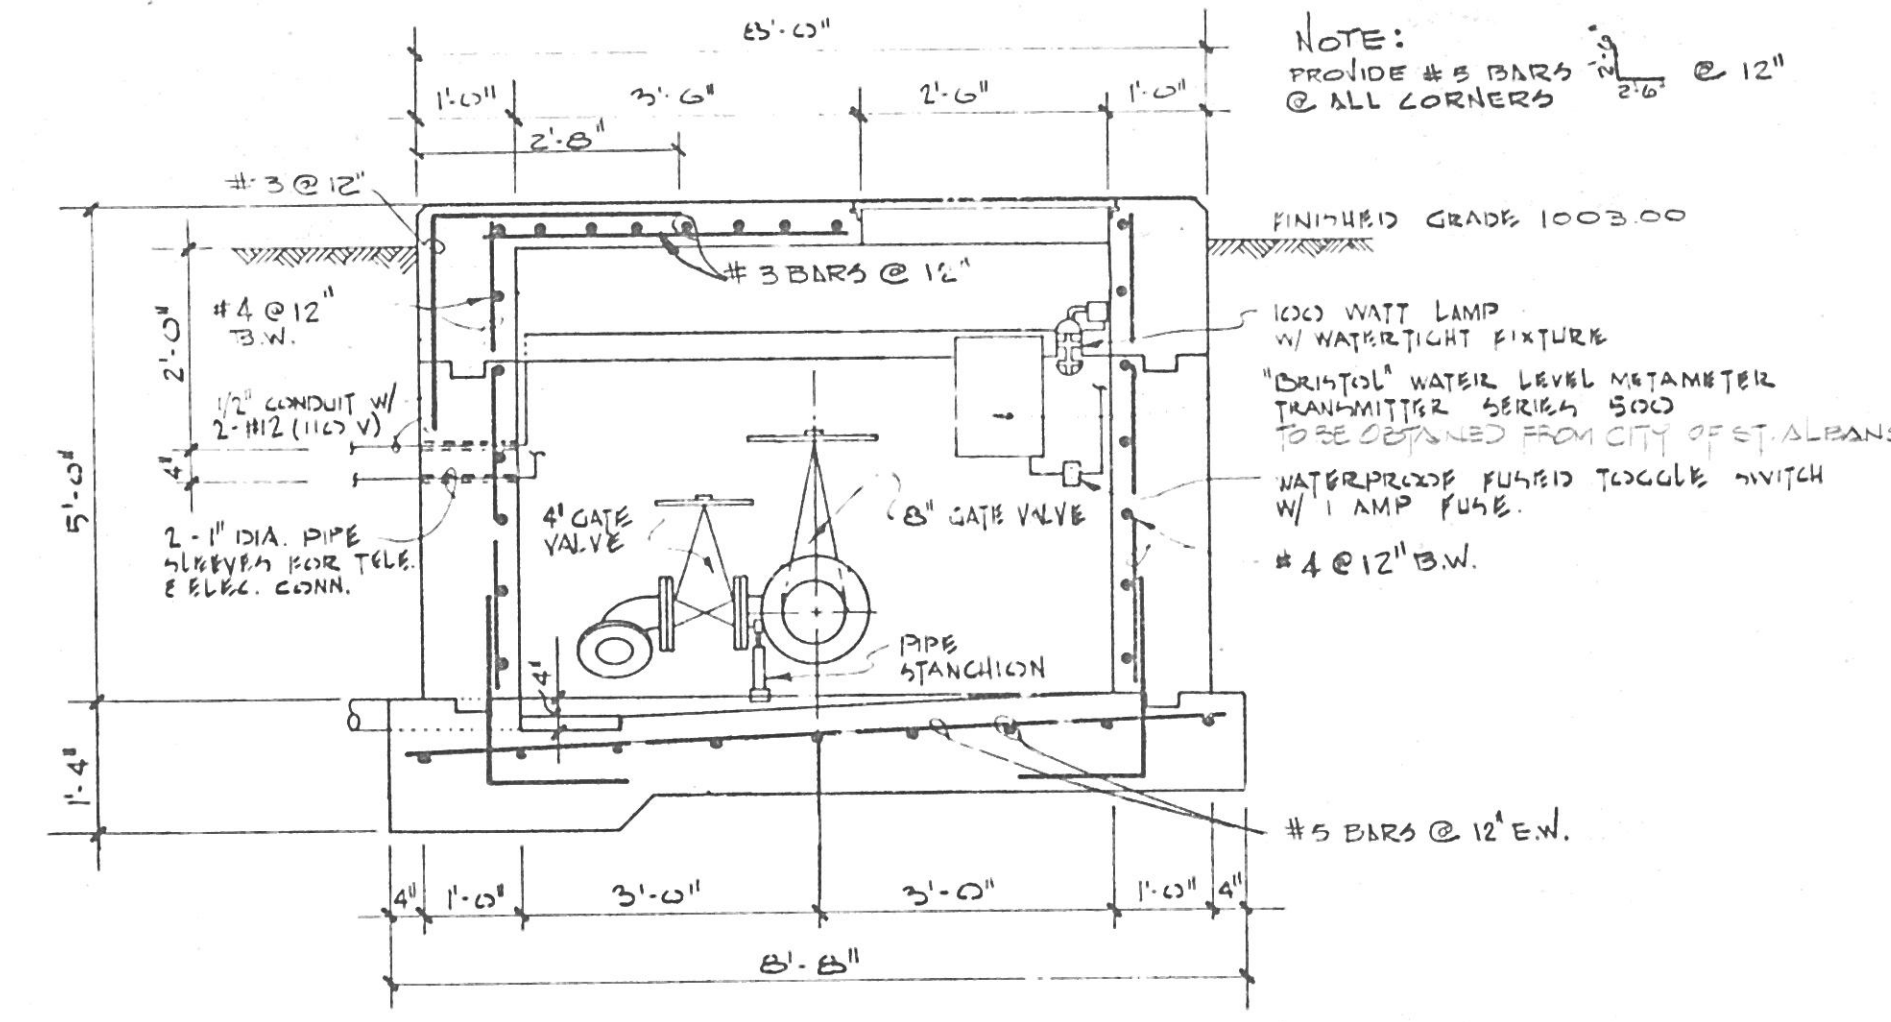


SECTION A-A
SCALE: 1/2" = 1'-0"

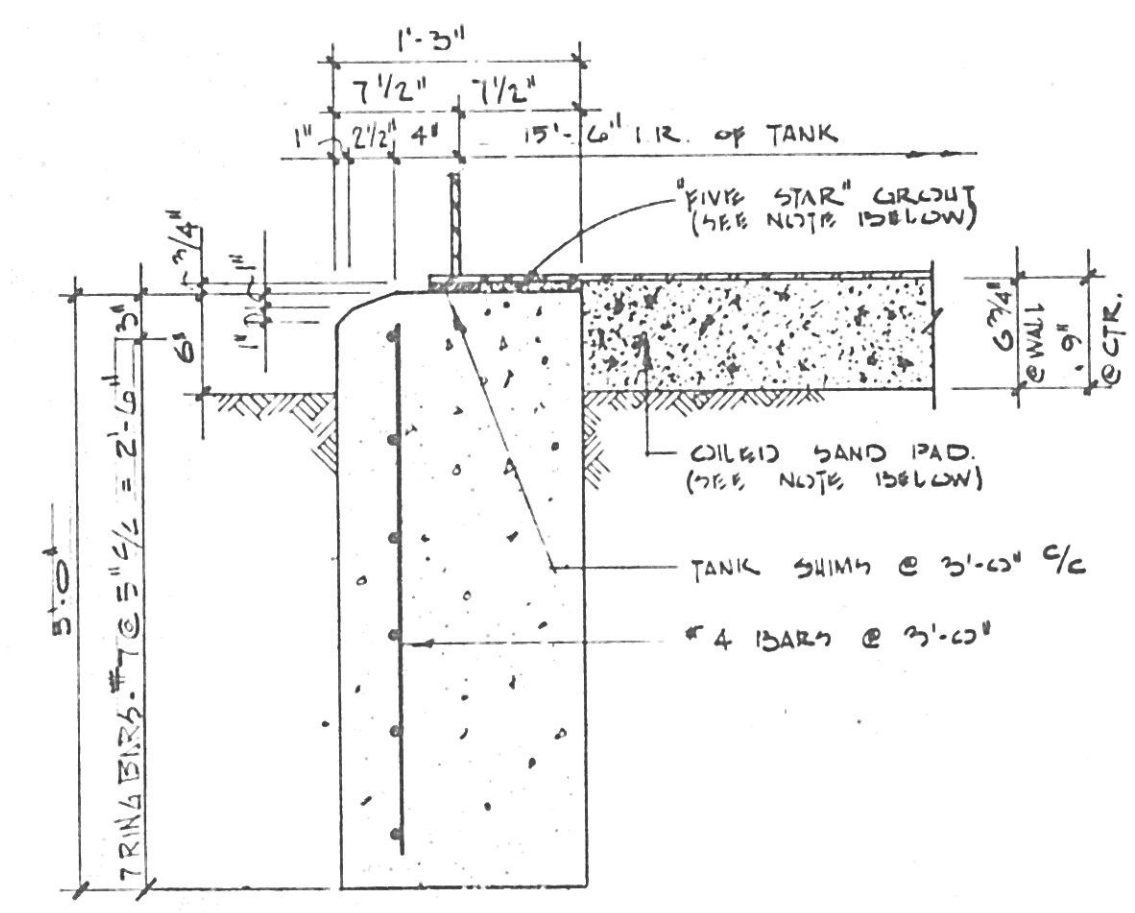


RING WALL SECTION (TYP.)
SCALE: 1" = 1'-0"

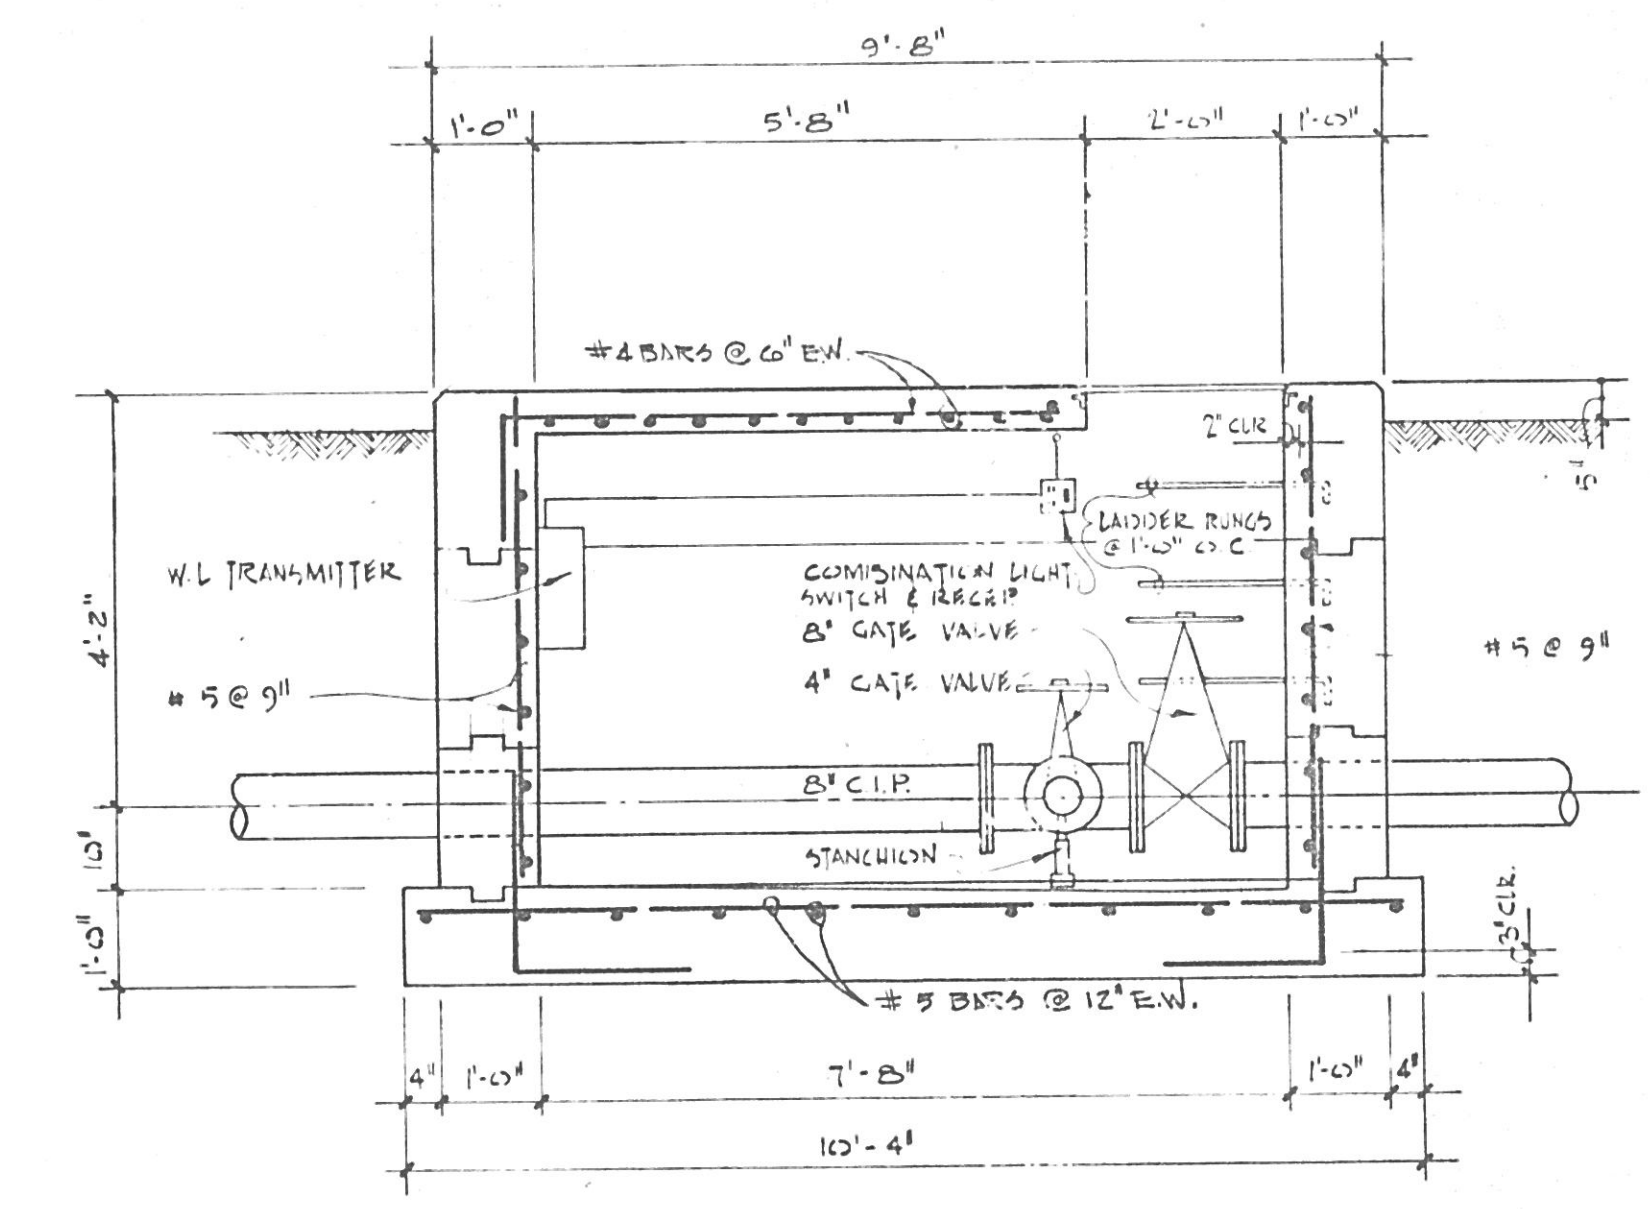

SECTION B-B
SCALE: 1/2" = 1'-0"

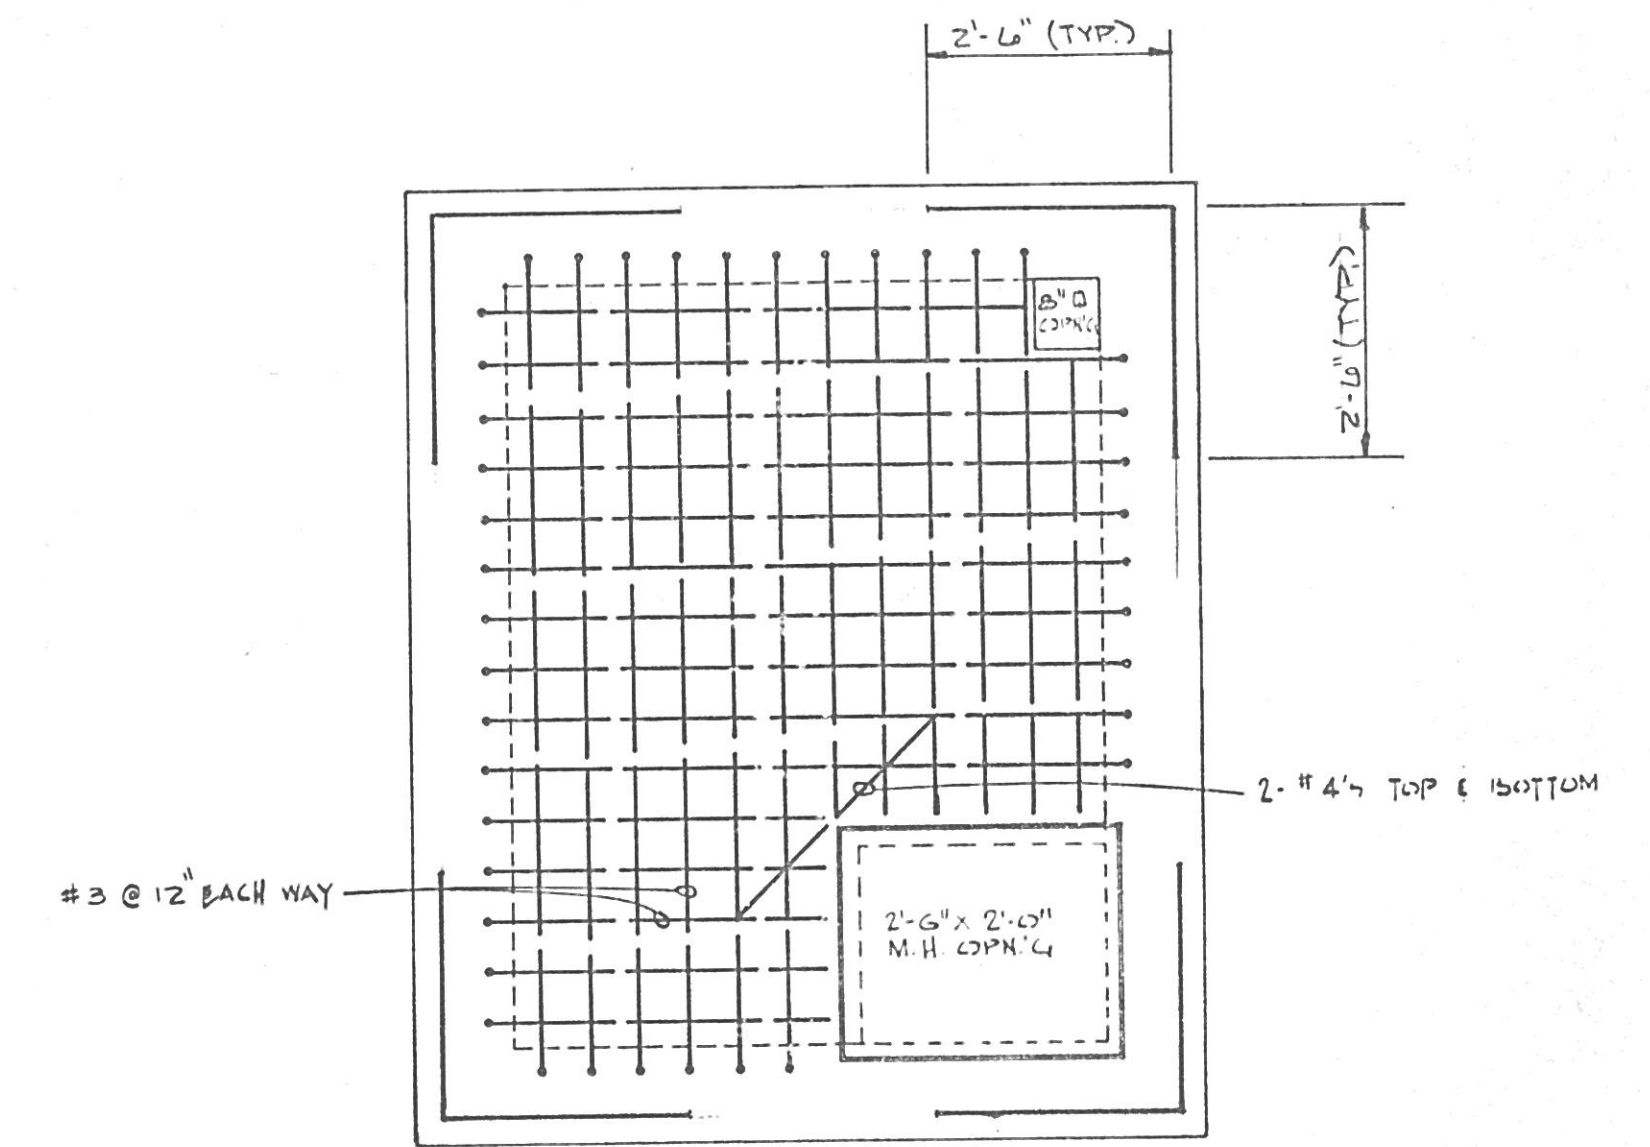

VAULT - TOP SLAB PLAN
SCALE: 1/2" = 1'-0"

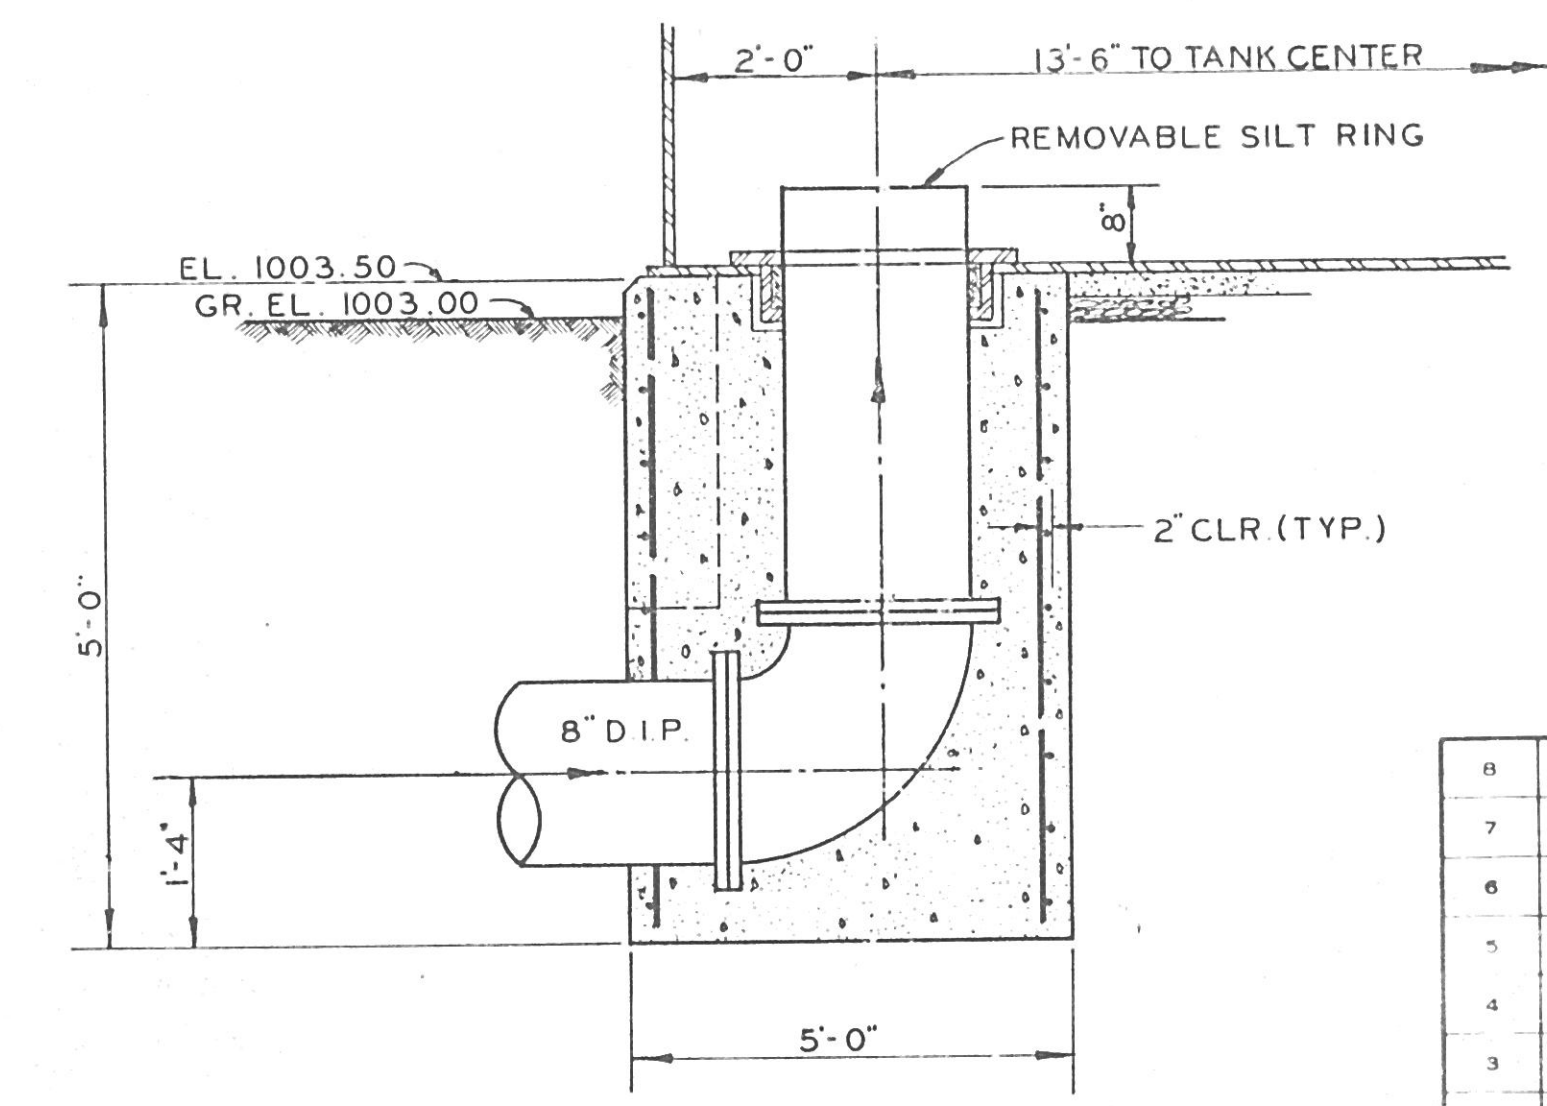

RISER PIPE SECTION
NO SCALE

ALTERNATE NO. 1B

		KELLEY, GIDLEY, BLAIR & WOLFE, INC. CONSULTING ENGINEERS CHARLESTON, WEST VIRGINIA			
		CITY OF ST. ALBANS			
		KANAWHA COUNTY WEST VIRGINIA			
		265,000 GALLON TANK - SITE PLAN			
		FOUNDATION PIPING			
		REINFORCING & MISC. DETAILS			
8		DRAWN	JRS	CHECKED	DAW
7		DRAWN		APPROVED	HRC
6		DRAWN		SCALE	AS NOTED
5		DRAWN		PROJECT	93400
4		DRAWN		DATE	NOV. 82
3		DRAWN		DRAWING NO.	
2		DRAWN			
1		DRAWN			
NO	DATE	DRAWN			
REVISIONS		DRAWN			

93406